

Revisions	Date


Issue Date:	May 2005
Drawn By:	JEF
Designed By:	SMH
Checked By:	SMH
Date:	May 2005

Mattem & Craig
CONSULTING ENGINEERS • SURVEYORS
701 FIRST STREET, S.W.
ROANOKE, VIRGINIA 24016
(540) 345-9342
FAX (540) 345-7691

SANITARY SEWER PROJECT
LINDENWOOD SEWER
TOWN OF VINTON, VIRGINIA

6" AND 10" SANITARY SEWER
-
PLAN AND PROFILE

Sheet No.:	4
Commission Number:	1955-L
Horizontal Scale:	1" = 50'
Vertical Scale:	1" = 10'

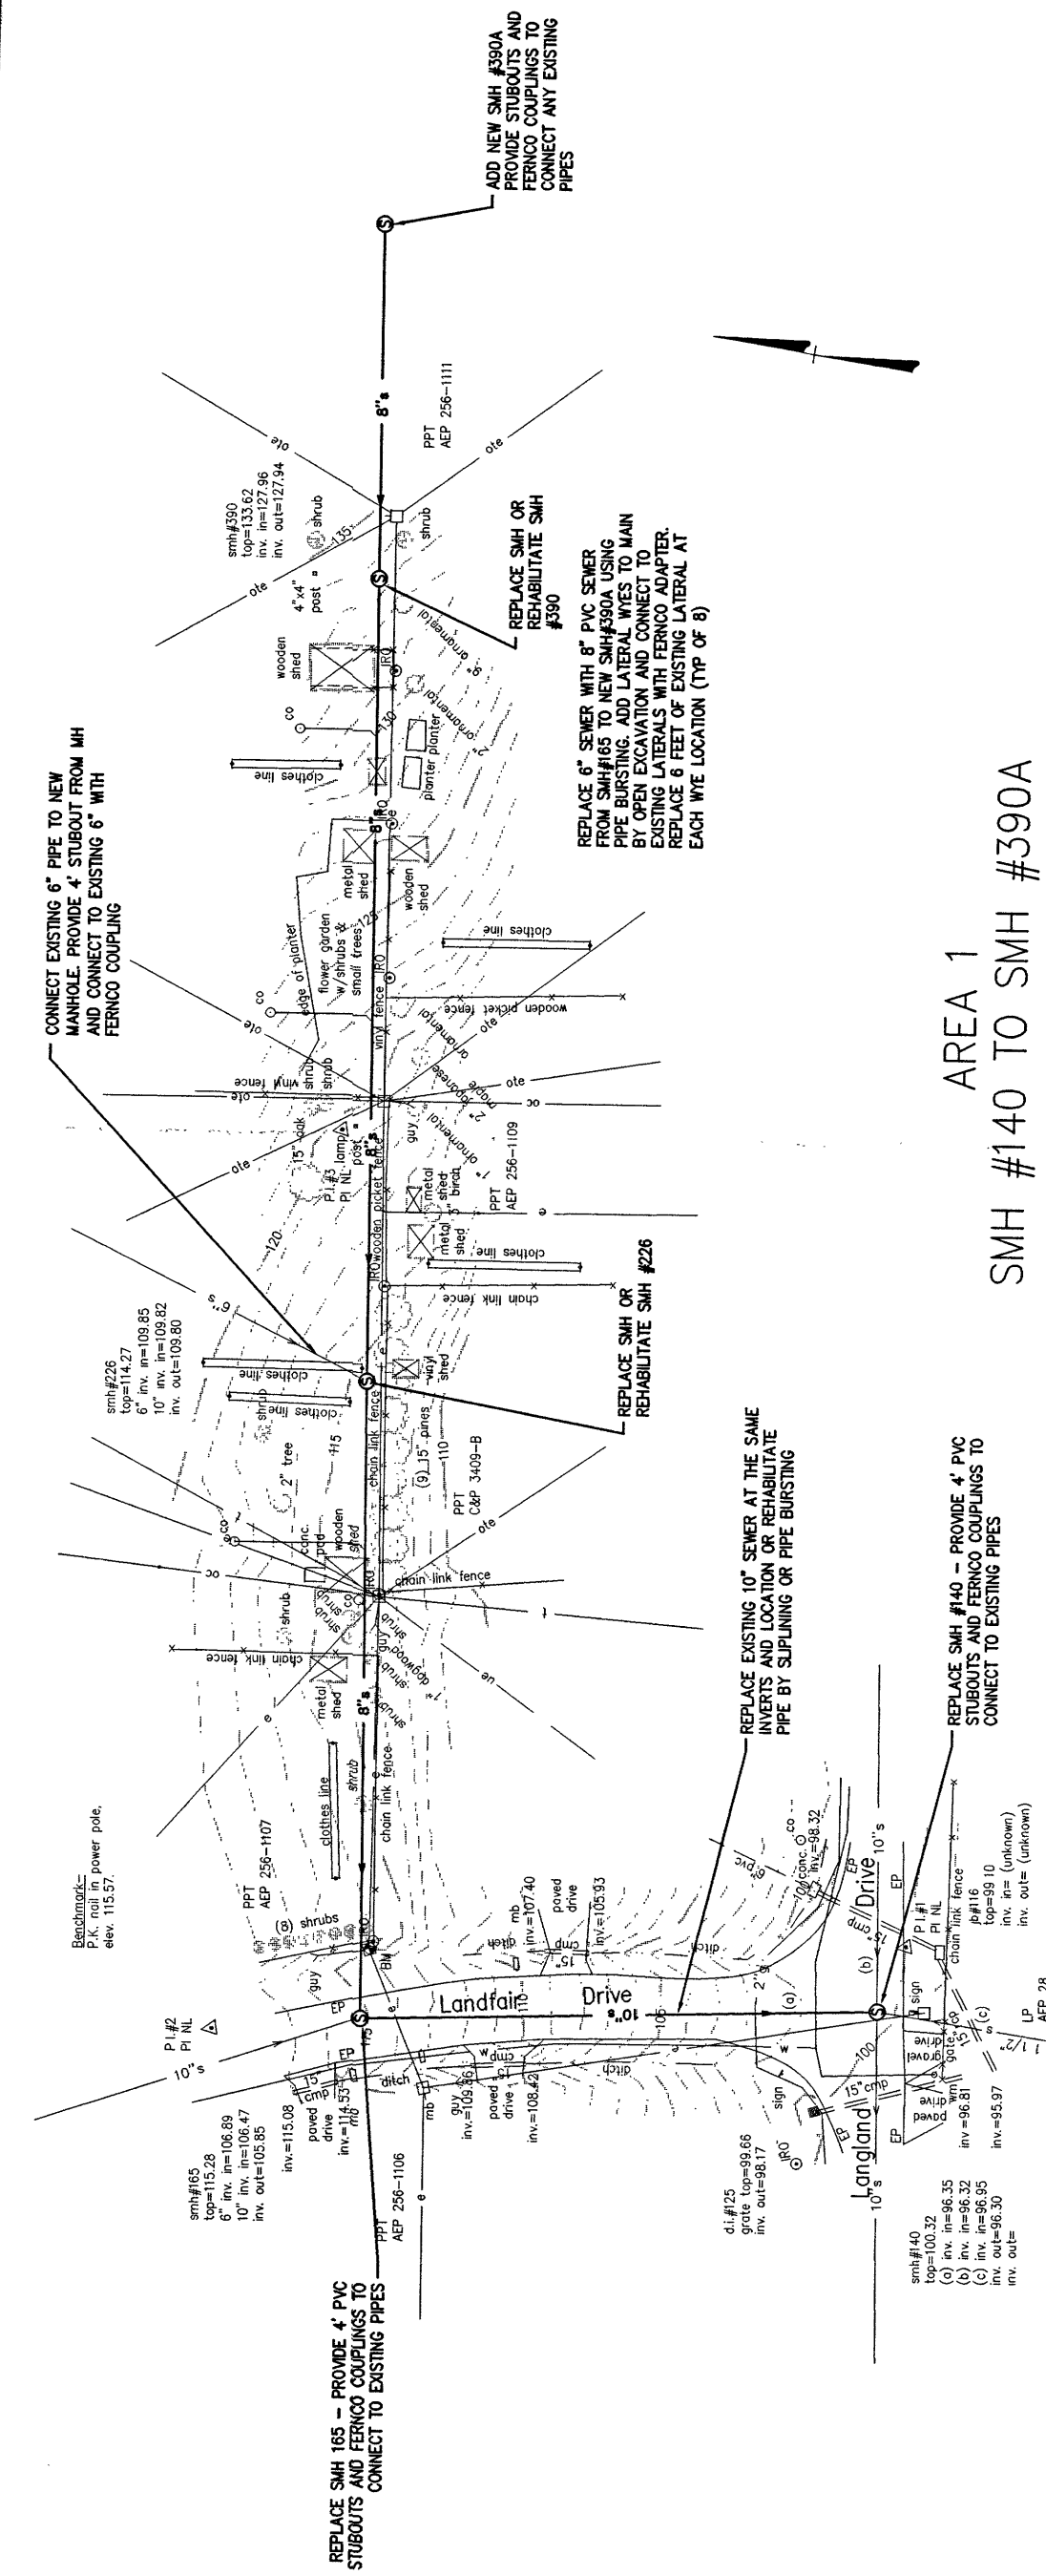

AREA 1

SMH #140 TO SMH #390A

