

SEE SHEET 18 FOR
CONTINUATION
NOTE: HORIZONTAL AND VERTICAL
DATUMS CHANGE AT MANHOLE 1469

REPLACE EXISTING 8" SEWER
FROM SMH#957 TO SMH#1469 AT
SAME INVERTS AND LOCATION OR
REHABILITATE BY SLIPLINING OR
PIPE BURSTING

REPLACE EXISTING 8" SEWER FROM
SMH#1418 TO SMH#1384 AT SAME
LOCATION AND INVERTS OR REHABILITATE
PIPE BY SLIPLINING OR PIPE BURSTING

REPLACE SMH #1384
PROVIDE 4" STUBOUT AND
FERNICO COUPLING TO
CONNECT TO EXISTING 8" PIPE

REPLACE SMH #1469
PROVIDE 4" STUBOUT AND FERNICO
COUPLING TO EXISTING 8" PIPE

ARRANGE FOR POLE TO BE
RELOCATED OR SUPPORTED
DURING CONSTRUCTION

REPLACE EXISTING 8" SEWER FROM
SMH#1418 TO SMH#1590 AT SAME
INVERTS AND LOCATION OR REHABILITATE
PIPE BY SLIPLINING OR PIPE BURSTING


REPLACE EXISTING SMH# 1590,
1545, 1544, 1442, 1418, AND 1469

PROVIDE 6" STUBOUT AND
FERNICO COUPLING TO
CONNECT TO EXISTING 4" PIPE


AREA 2
SMH #1469 TO SMH #1590, SMH#1418 TO SMH#1384,
AND SMH #1418 TO SMH #957

MATCH LINE STA. 13+00
SEE SHEET 6


SEE SHEET 6A FOR PROFILE

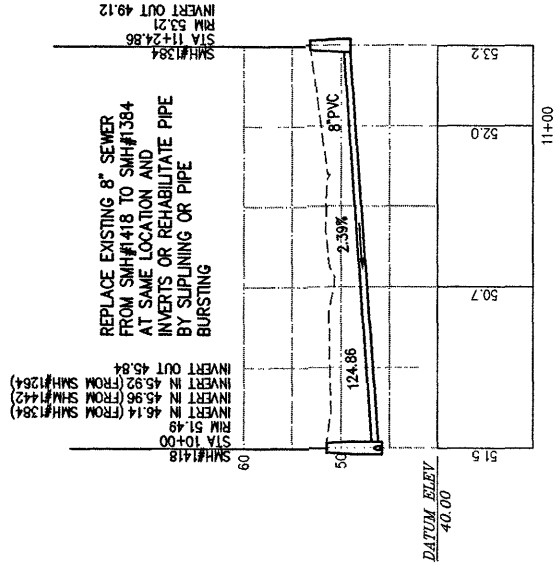

SS 1418-1384

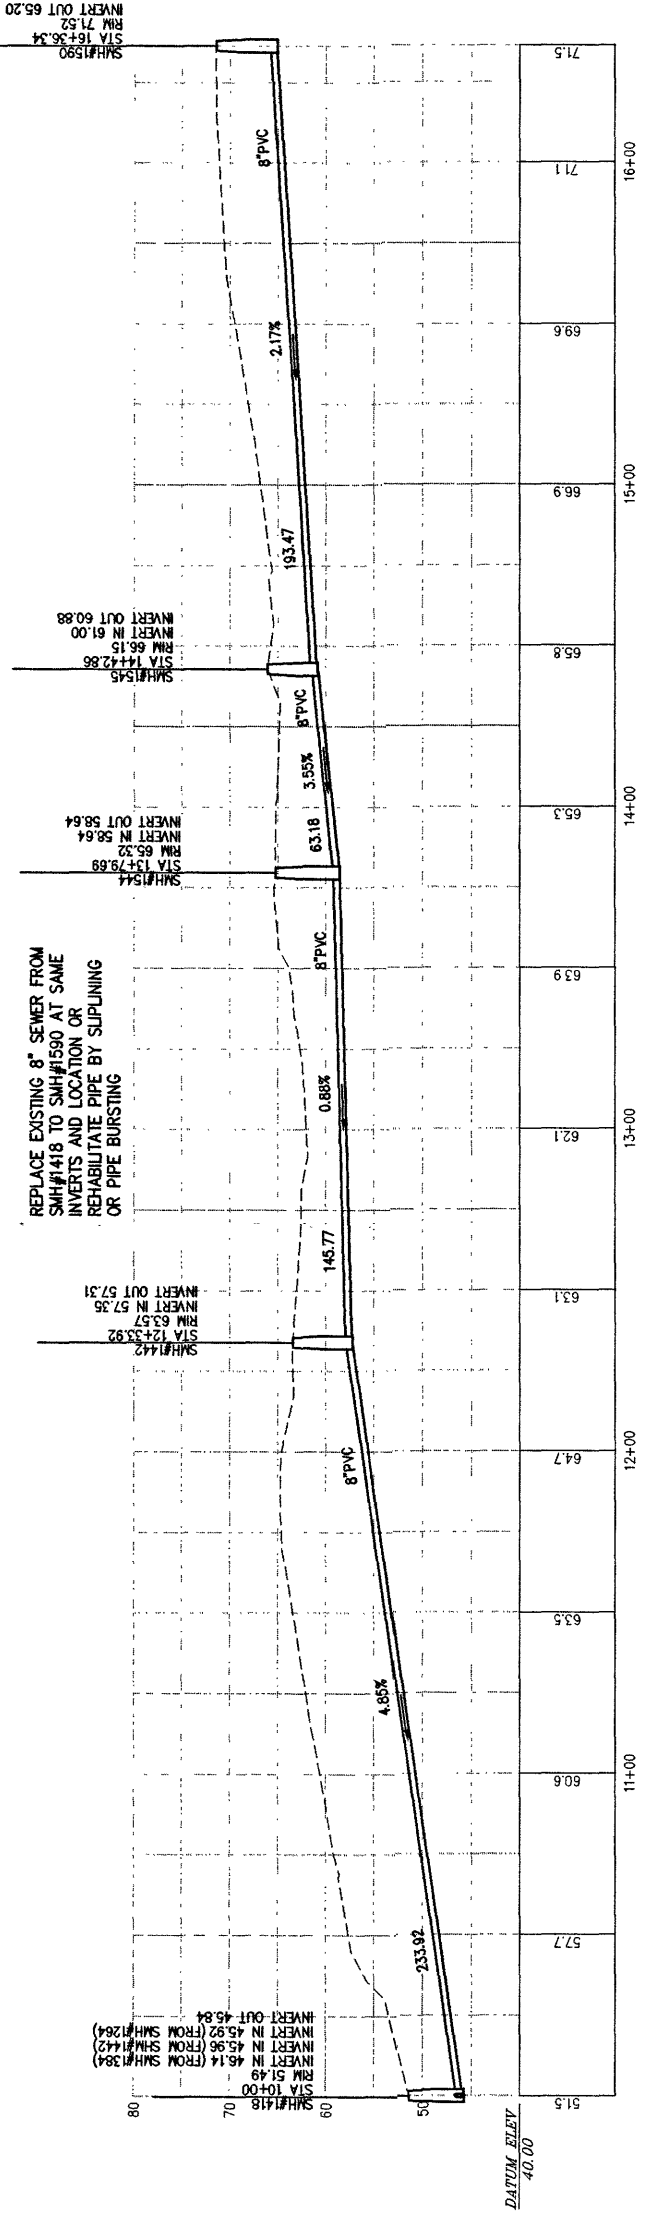

SS 1418-1590

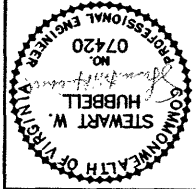

Revisions	Date

Issue Date:	May 2005
Drawn By:	JEF
Designed By:	SMH
Checked By:	SMH
Date:	May 2005

Mattern & Craig
CONSULTING ENGINEERS • SURVEYORS
701 FIRST STREET, S.W.
ROANOKE, VIRGINIA 24016
(540) 345-9342
FAX (540) 345-7691

**PLAN AND PROFILE -
8" SANITARY SEWER**
LINDENWOOD SEWER PROJECT
TOWN OF VINTON, VIRGINIA

Vertical Scale:
1" = 10'

Horizontal Scale:
1" = 30'

Commission Number:
1955-L

Sheet No.:
5