

14

Sheet No.:

Commission Number:
1955-L


Horizontal Scale:
1" = 30'

Vertical Scale:
1" = 10'


SANITARY SEWER PROJECT
LINDENWOOD SEWER
8" SANITARY SEWER
PLAN AND PROFILE -
TOWN OF WINTON, VIRGINIA

Mattem & Craig
CONSULTING ENGINEERS • SURVEYORS
701 FIRST STREET, S.W.
ROANOKE, VIRGINIA 24016
(540) 345-9342
FAX (540) 345-7691

Issue Date: May 2005
Drawn By: JEF
Designed By: SMH
Checked By: SMH
Date: May 2005

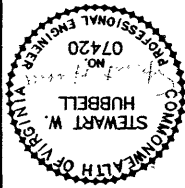


Revisions	Date

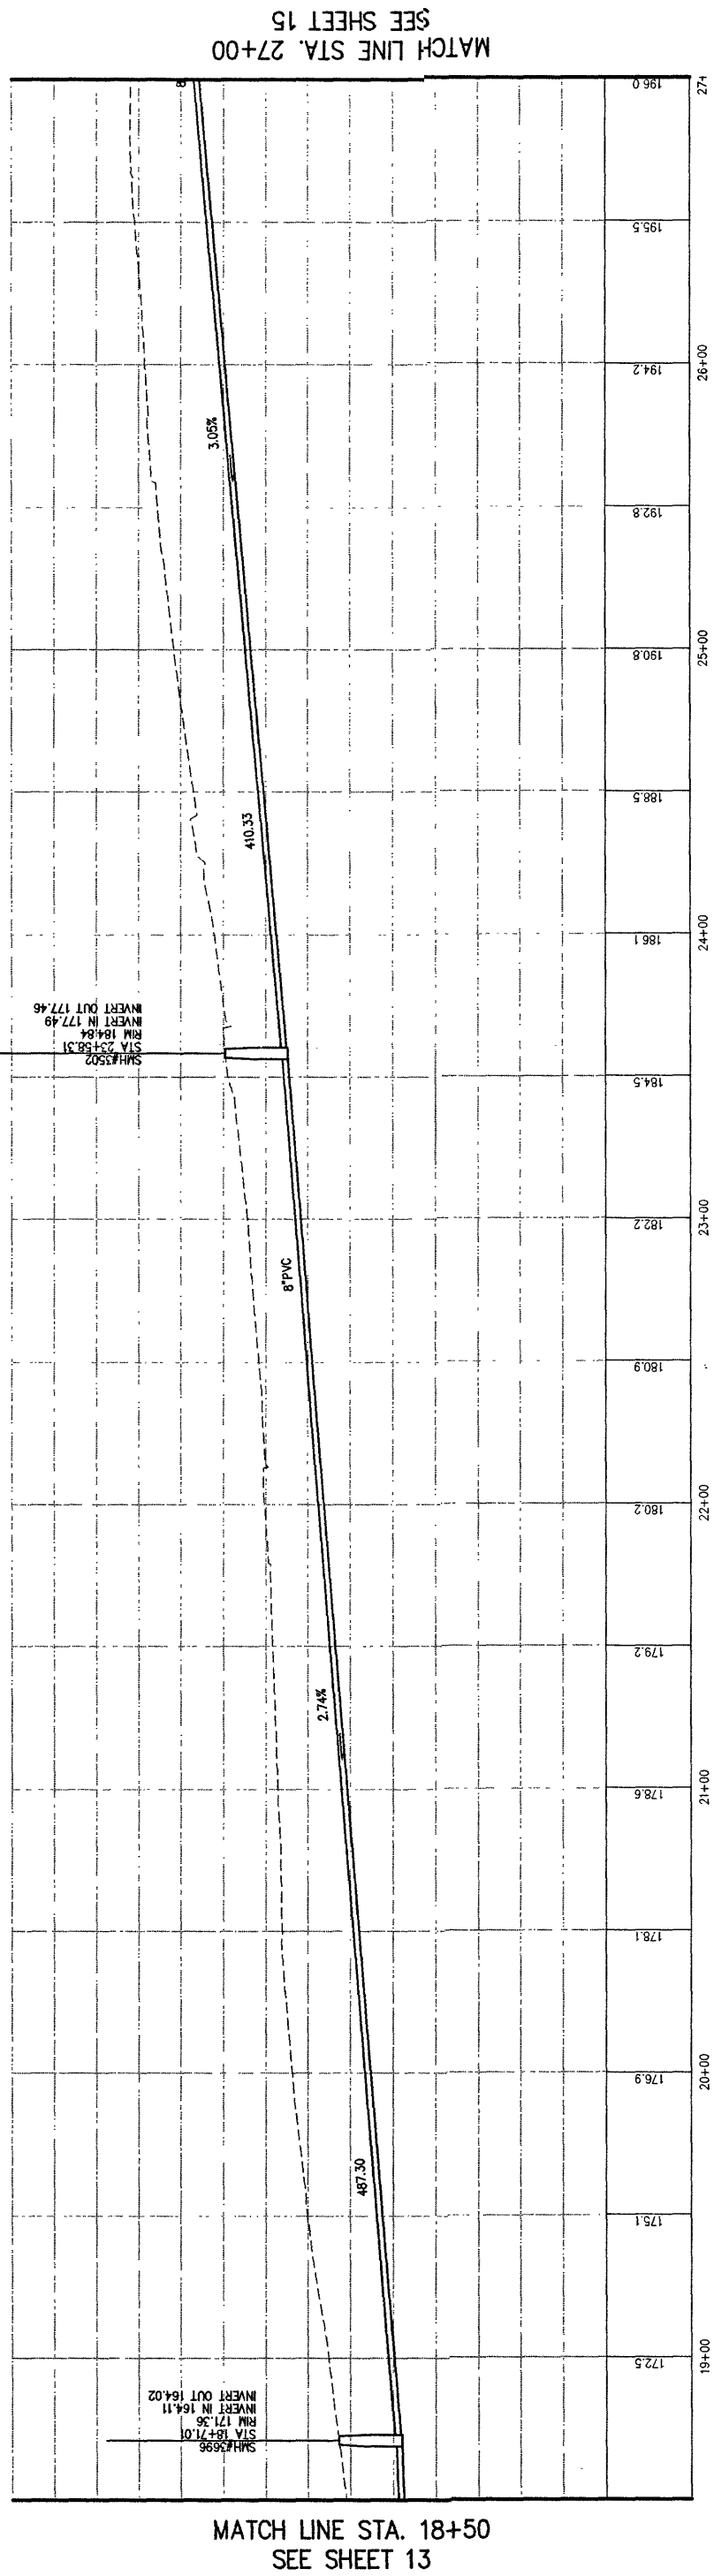

MATCH LINE STA. 18+50
SEE SHEET 13

REPLACE EXISTING SEWER FROM
SMH#3696 TO SMH#3324 IN SAME
LOCATION, SAME INVERTS, OR
REHABILITATE PIPE BY SUTLINING OR
PIPE BURSTING

MATCH LINE STA. 27+00
SEE SHEET 15

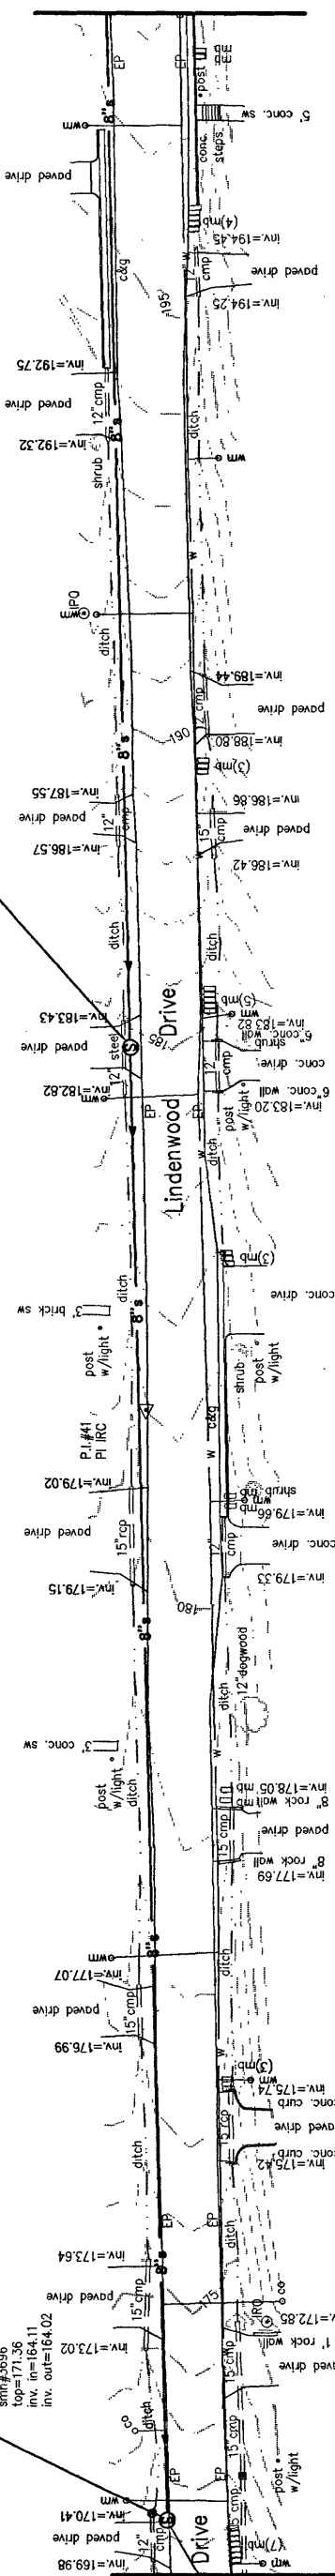

MATCH LINE STA. 18+50
SEE SHEET 13

AREA 7
SMH #6246 TO SMH #3324

REPLACE EXISTING SEWER FROM
SMH#3696 TO SMH#3324 IN SAME
LOCATION, SAME INVERTS, OR
REHABILITATE PIPE BY SUTLINING OR
PIPE BURSTING

REPLACE SMH#3502, CONNECT STUBOUT
TO EXISTING PIPE WITH FERNCO
COUPLINGS OR REHABILITATE SMH

CONNECT EXISTING LATERALS TO NEW
PIPE WITH WYES, 4" STUBOUTS AND
FERNCO COUPLINGS—LOCATIONS
UNKNOWN (TYP OF 20 THIS SHEET)