

Issue Date:	May 2005
Drawn By:	JEF
Designed By:	SWH
Checked By:	SWH
Date:	May 2005

 Mattern & Craig
CONSULTING ENGINEERS • SURVEYORS
701 FIRST STREET, S.W.
ROANOKE, VIRGINIA 24016
(540) 345-9342
FAX (540) 345-7691

SANITARY SEWER PROJECT
LINDENWOOD SEWER
PLAN AND PROFILE -
8" SANITARY SEWER
TOWN OF VINTON, VIRGINIA

Vertical Scale
1" = 10'


Horizontal Scale:
1" = 30'

Commission Number:
1055-1

Sheet No :

16

R:\dwg\1955-L\dwg\BASE3.dwg, 16, 8/1/2005 9:10:3

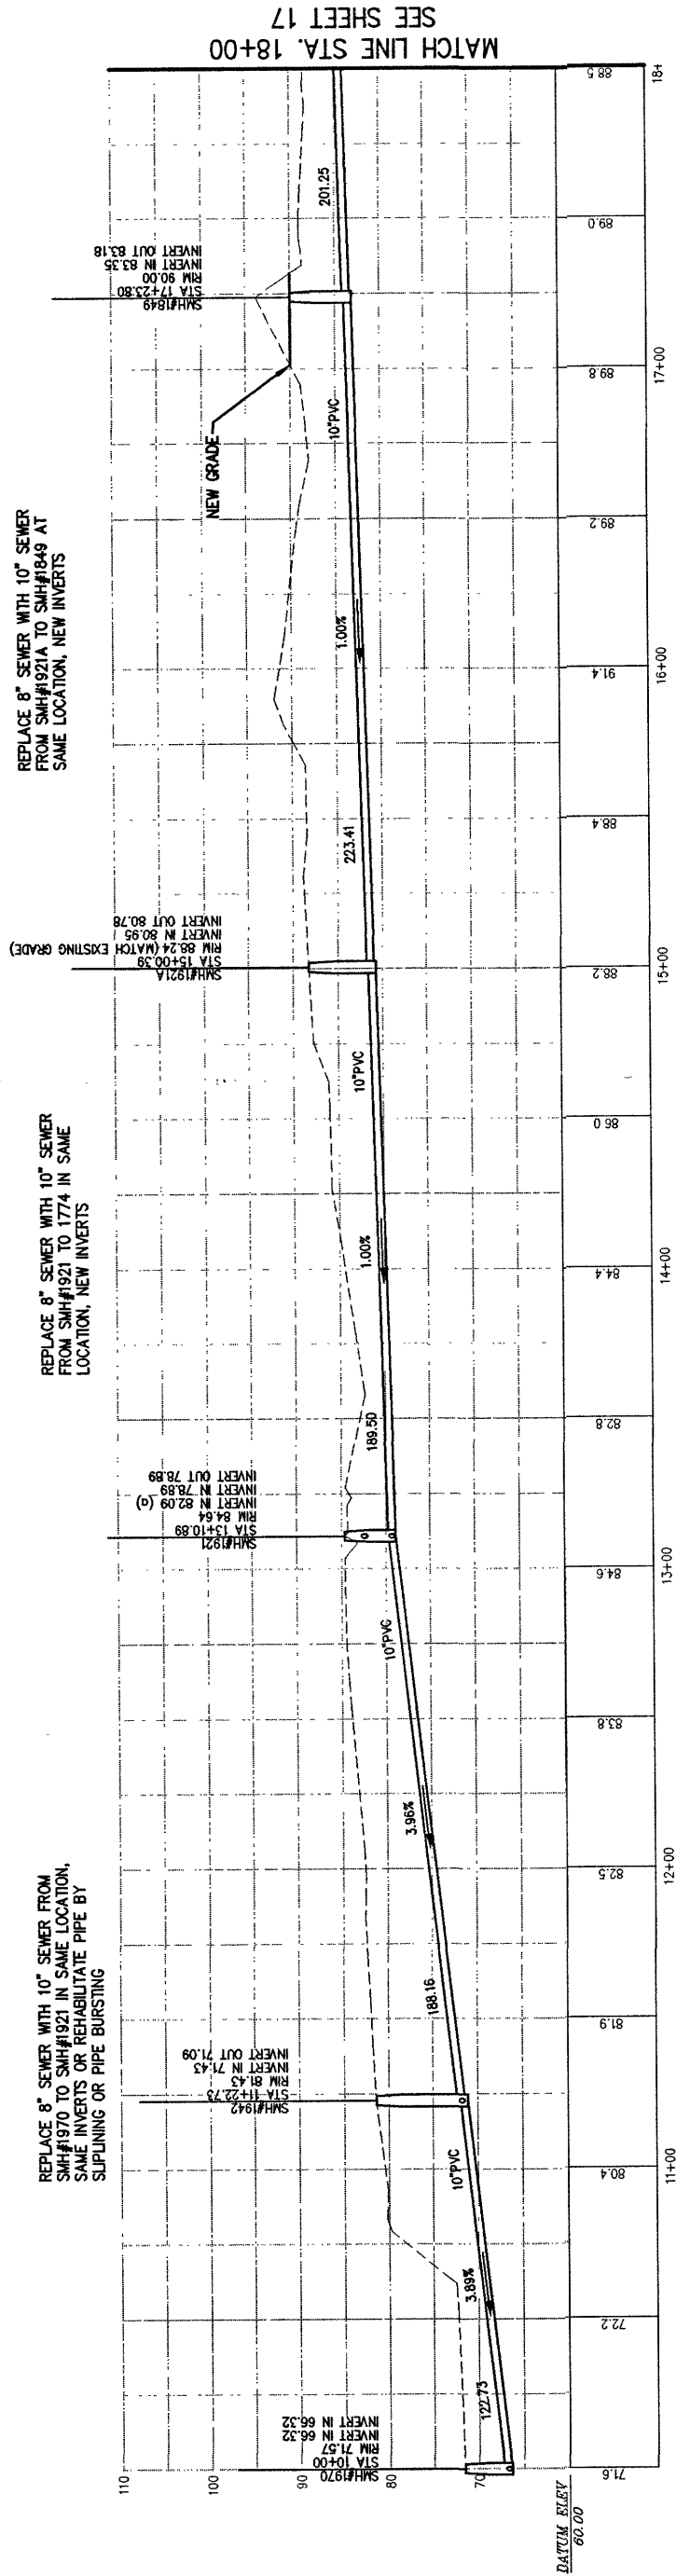

SS 1970-1774

