

May 2005

Drawn By: JEF

Designed By: SWH

Checked By: SWH


Date May 2005

Matthew & Craig
CONSULTING ENGINEERS • SURVEYORS

701 FIRST STREET, S.W.
ROANOKE, VIRGINIA 24016
(540) 345-5342
FAX (540) 345-7691

LINDENWOOD SEWER
PLAN AND PROFILE -
8" SANITARY SEWER
TOWN OF VINTON, VIRGINIA

Vertical Scale: 1"= 10'	Horizontal Scale: 1"= 30'	Commission Number: 1955-L	Sheet No.: 17
----------------------------	------------------------------	------------------------------	------------------

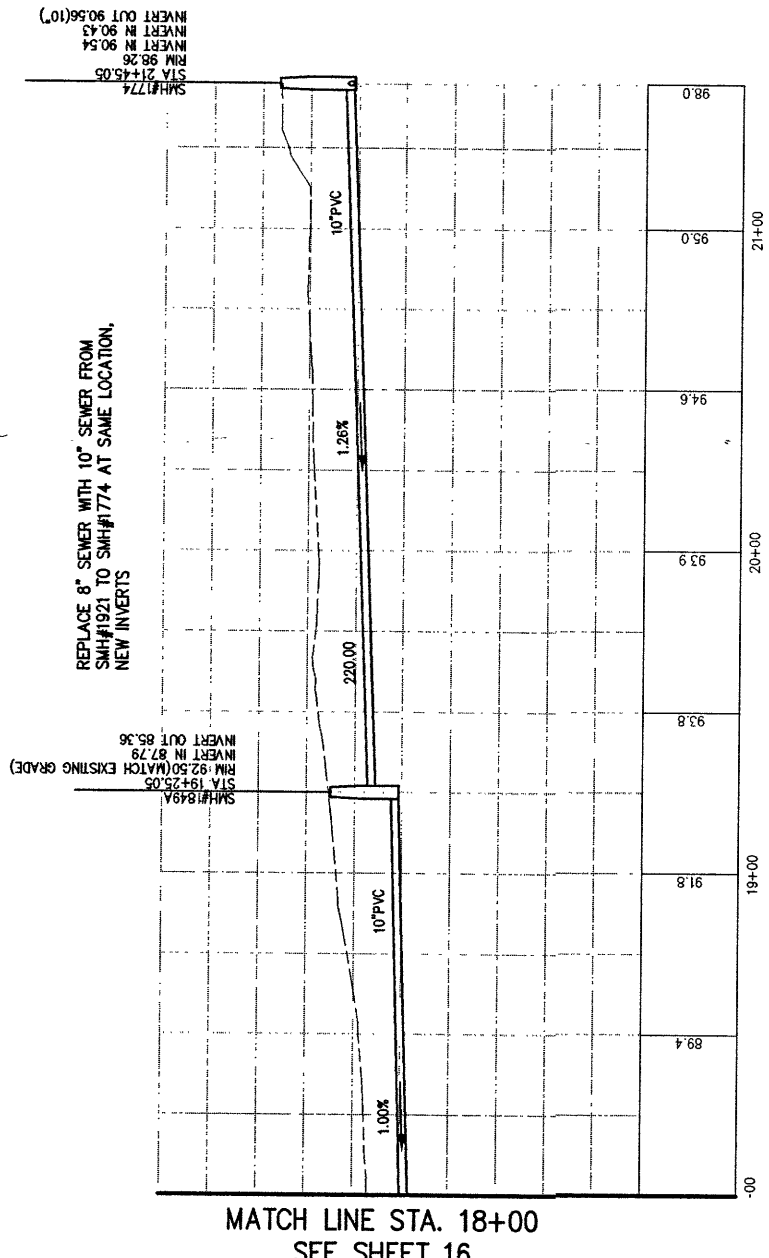

SS 1970-1774

