




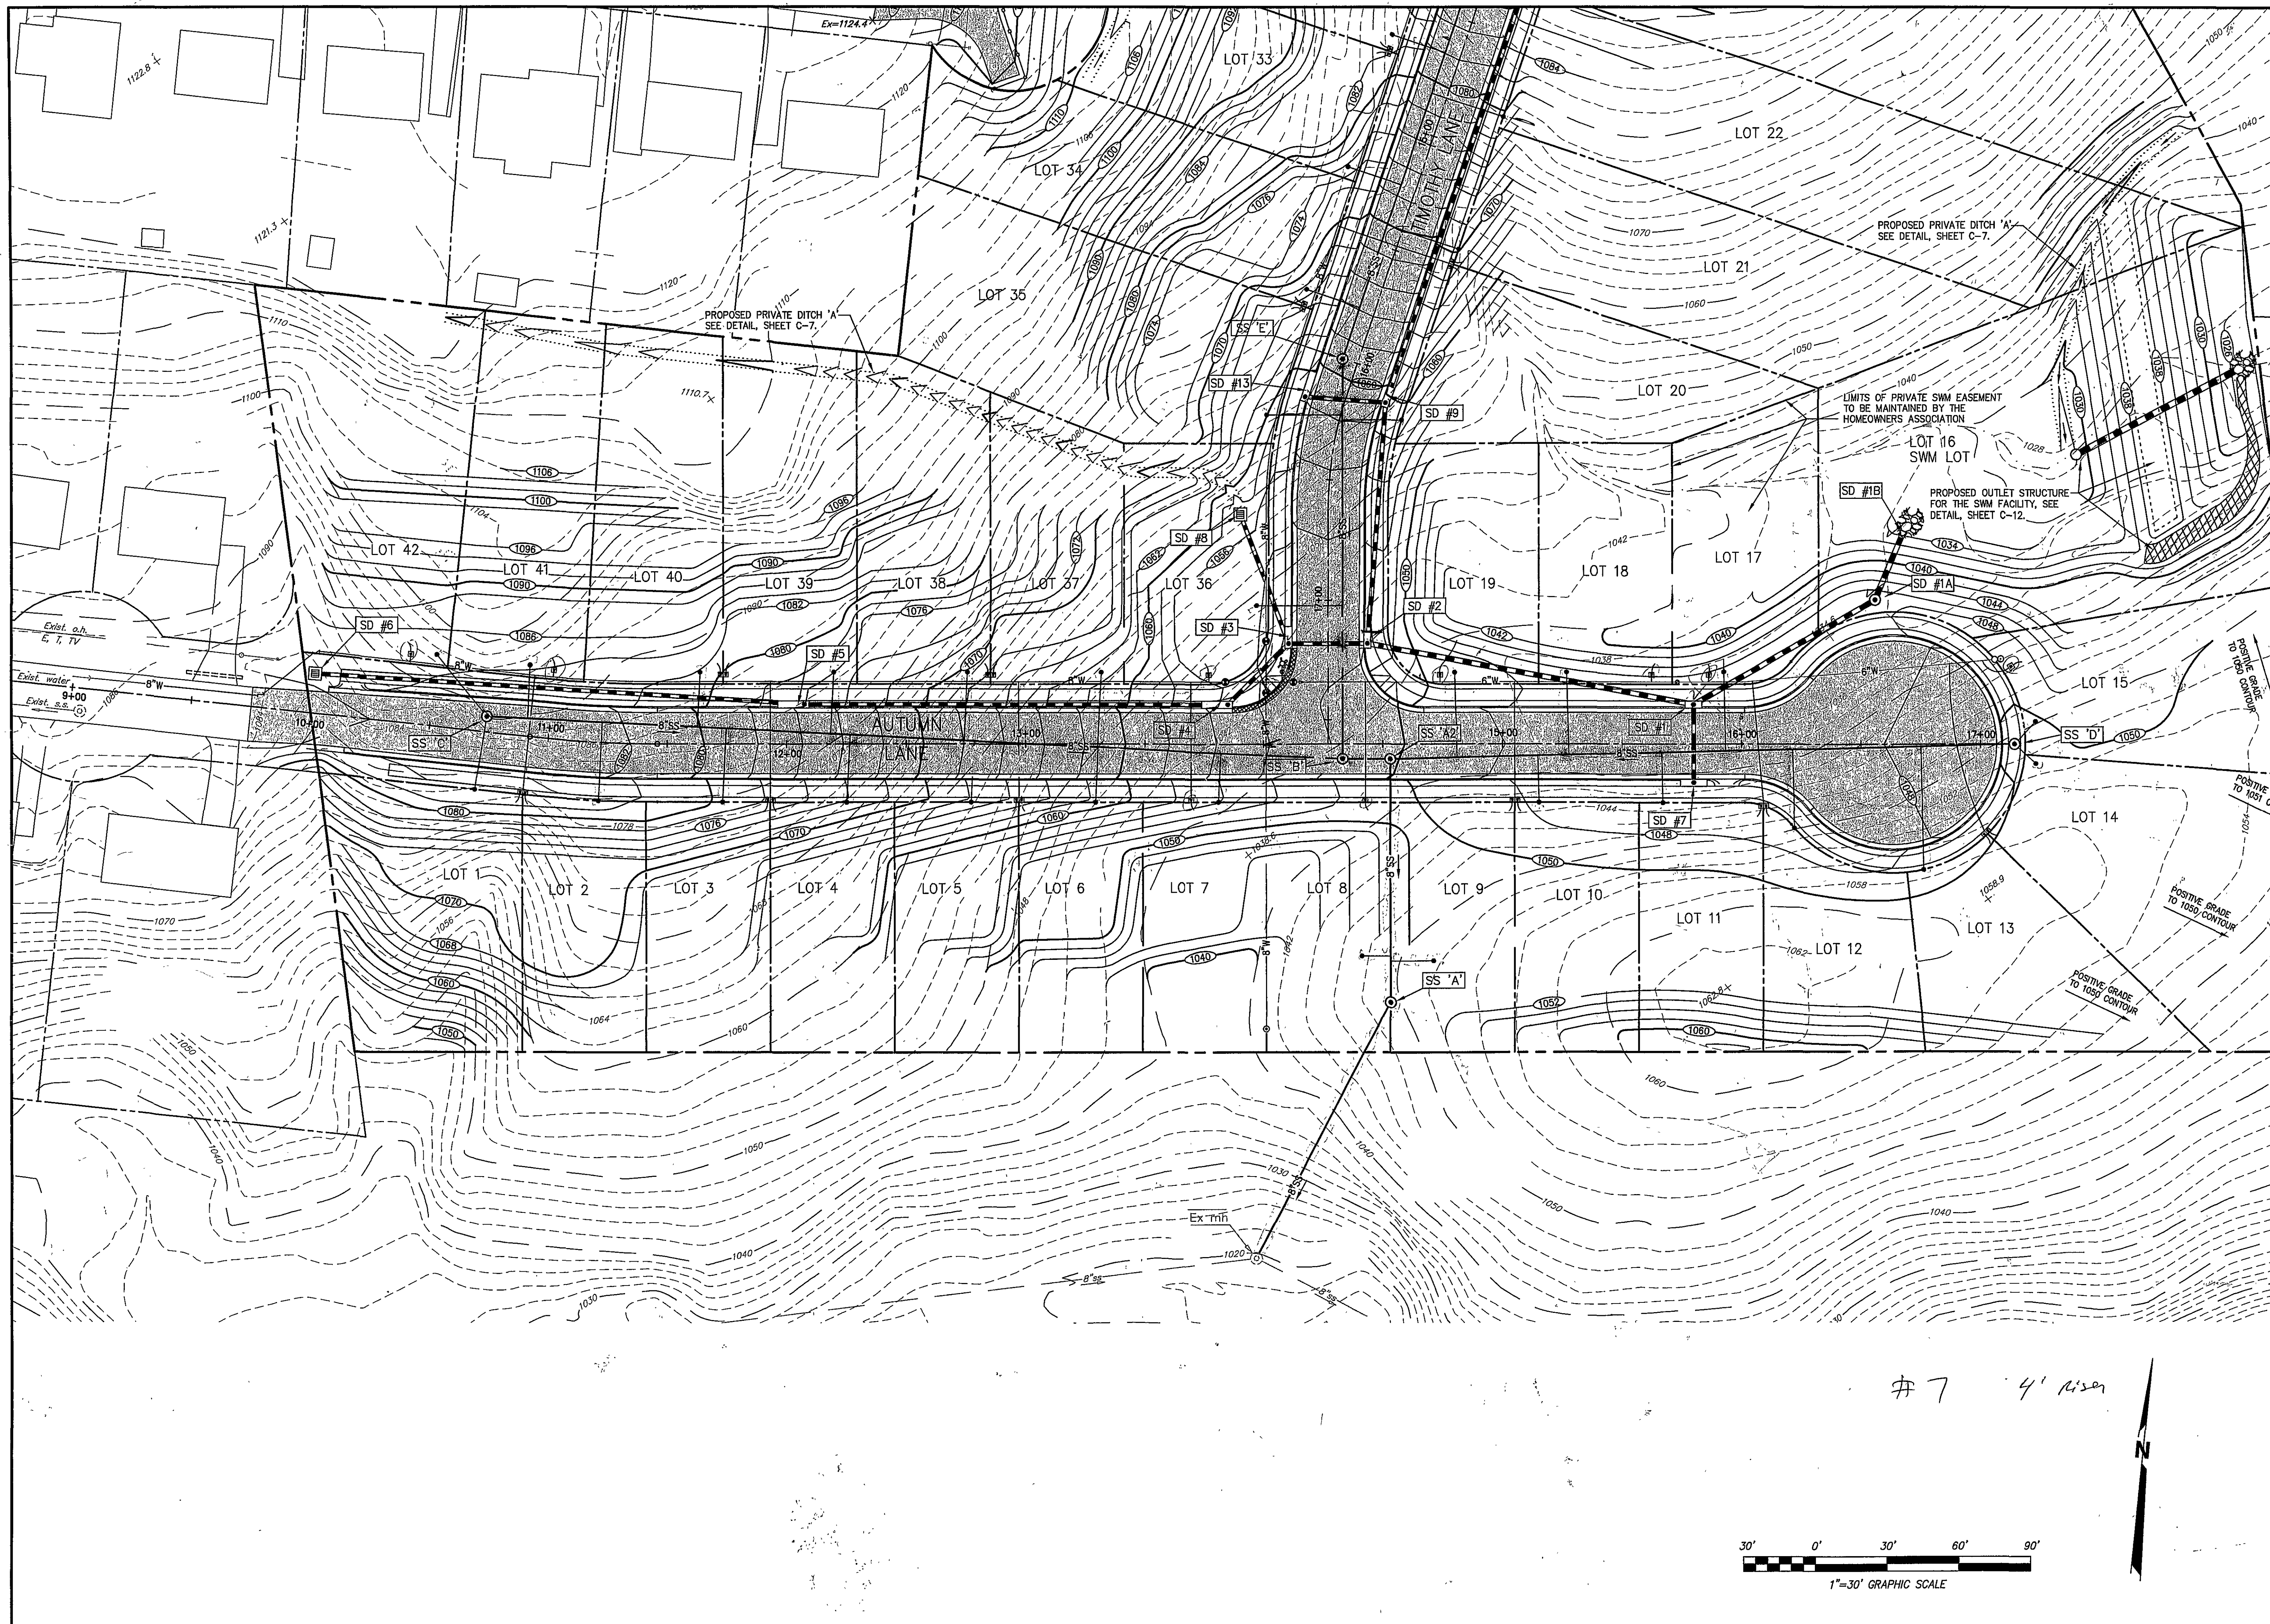

#7 4' rise

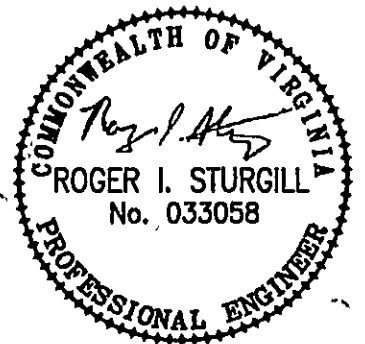

112
360
92

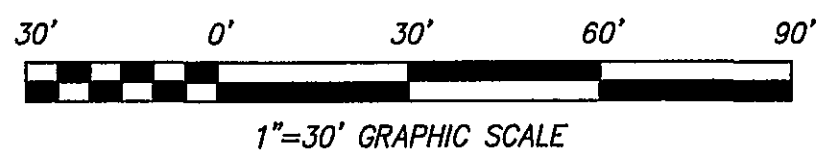

PLANNERS • ARCHITECTS
ENGINEERS • SURVEYORS

1208 Corporate Circle
Roanoke, Virginia 24018
Phone: 540/772-9580
FAX: 540/772-8050

601 Branchway Road
Richmond, Virginia 23298
Phone: 804/794-0571
FAX: 804/794-0555

880 Technology Park Drive
Suite 200
Glen Allen, Virginia 23059
Phone: 804/653-0139
FAX: 804/653-0133

448 Peppers Ferry Road, NW
Christiansburg, Virginia 24073
Phone: 540/381-1280
FAX: 540/381-4281

1667 Commerce Road
Suite 201
Verona, Virginia 24482
Phone: 540/248-2220
FAX: 540/248-3251

MAPLE RIDGE

GRADING PLAN

ROANOKE CITY, VIRGINIA

DRAWN BY: JVV
DESIGNED BY: JVV
CHECKED BY: SMH
DATE: 09/29/2006

- REVISIONS:
- 1st - 02/26/2007
per City Review
 - 2nd - 04/20/2007
per City Review
 - 3rd - 05/15/2007
per City Review
 - 4th - 08/28/2007
Owner Revisions
 - 5th - 09/20/2007
per City Review
- SHEET NO.

C-6

JOB NO.
R0400131.03