
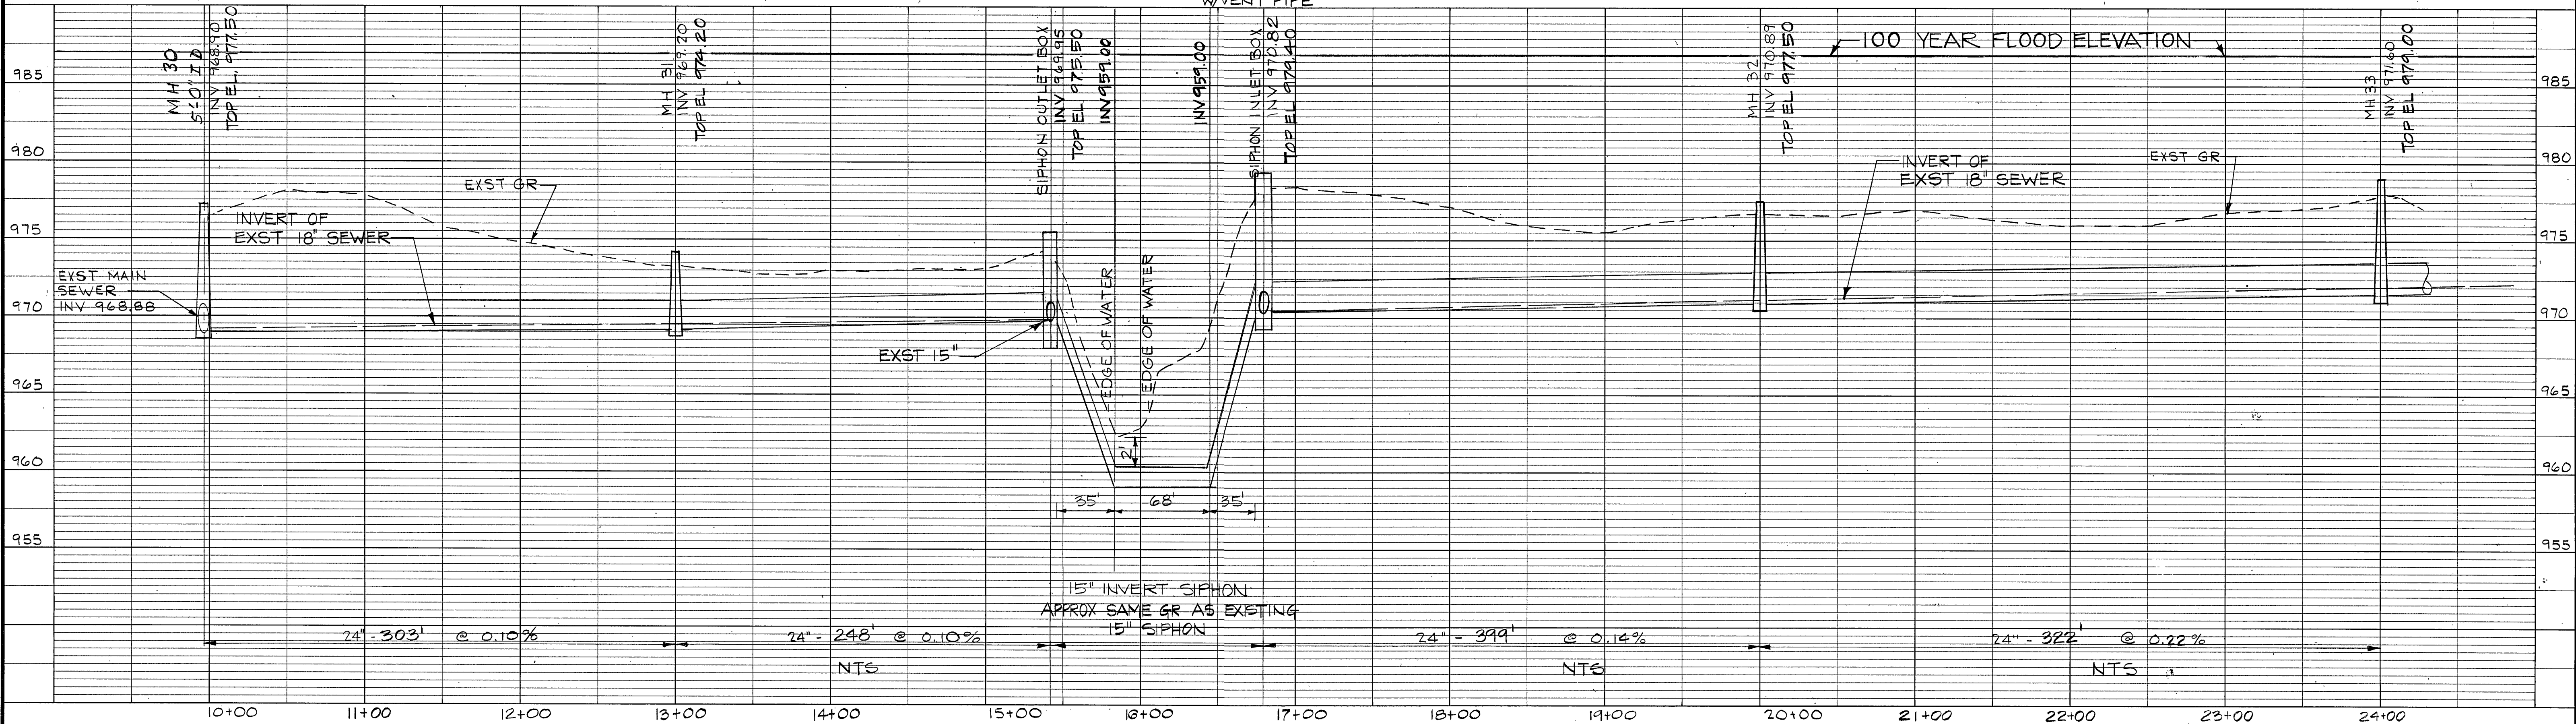


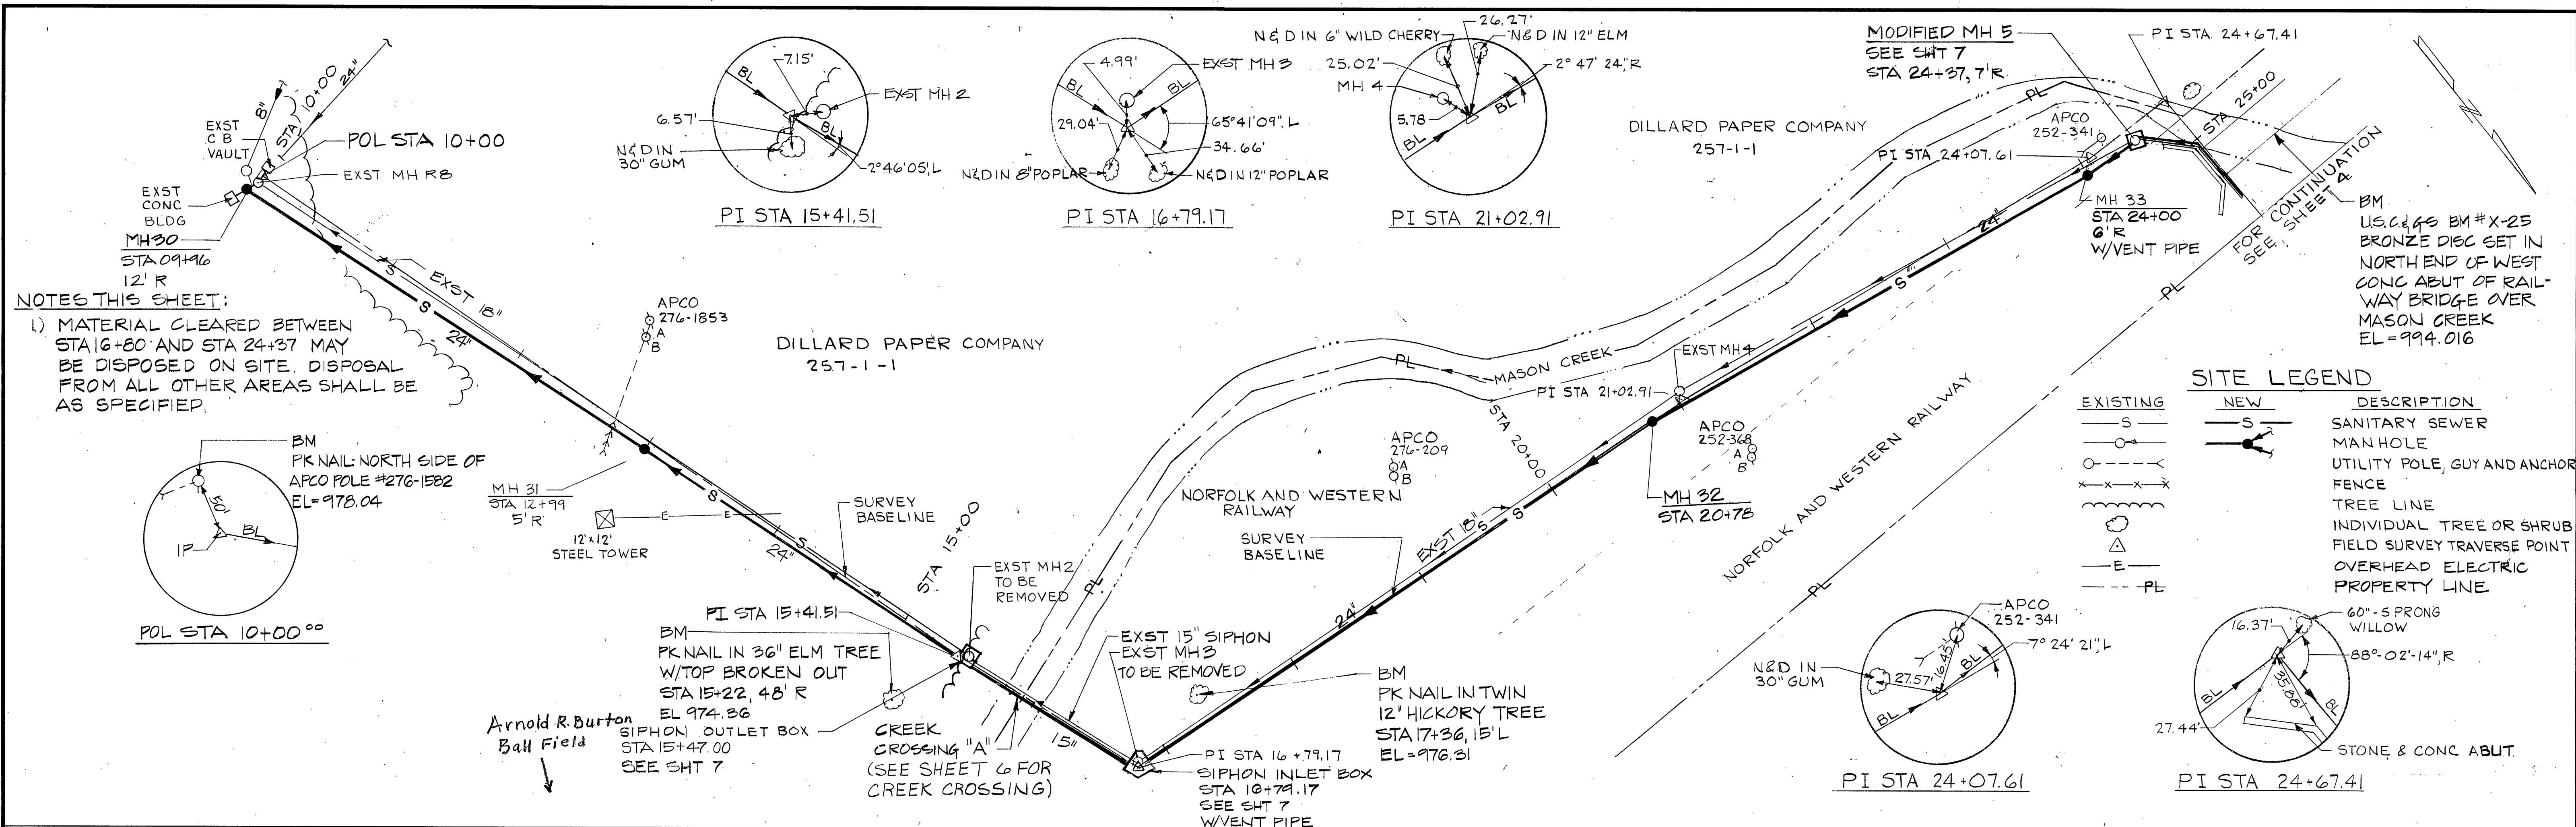


DESIGNED: SSJ 8/25
 DRAWN: JME 8/26
 CHECKED: MCB 8/26
 APPROVED: JAP 8/26

REVISIONS			REVISIONS		
DATE	BY	DESCRIPTION	DATE	BY	DESCRIPTION

MASON CREEK INTERCEPTOR SEWER
 CITY OF SALEM, VIRGINIA

HAYES, SEAY, MATTERN AND MATTERN
 ARCHITECTS - ENGINEERS - PLANNERS

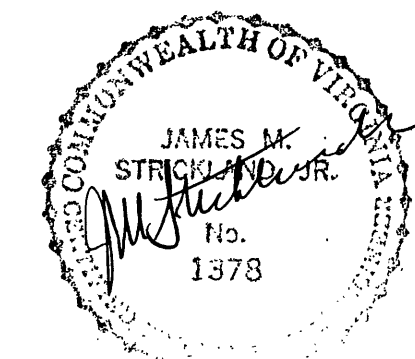

PLAN AND PROFILE
 STATION 10+00 TO STATION 24+37

SCALE: HORIZ 1"=50'
 VERT 1"=5'
 DATE: AUG 1986
 COMM. NO. 4212 B
 DRAWING NO. 3