
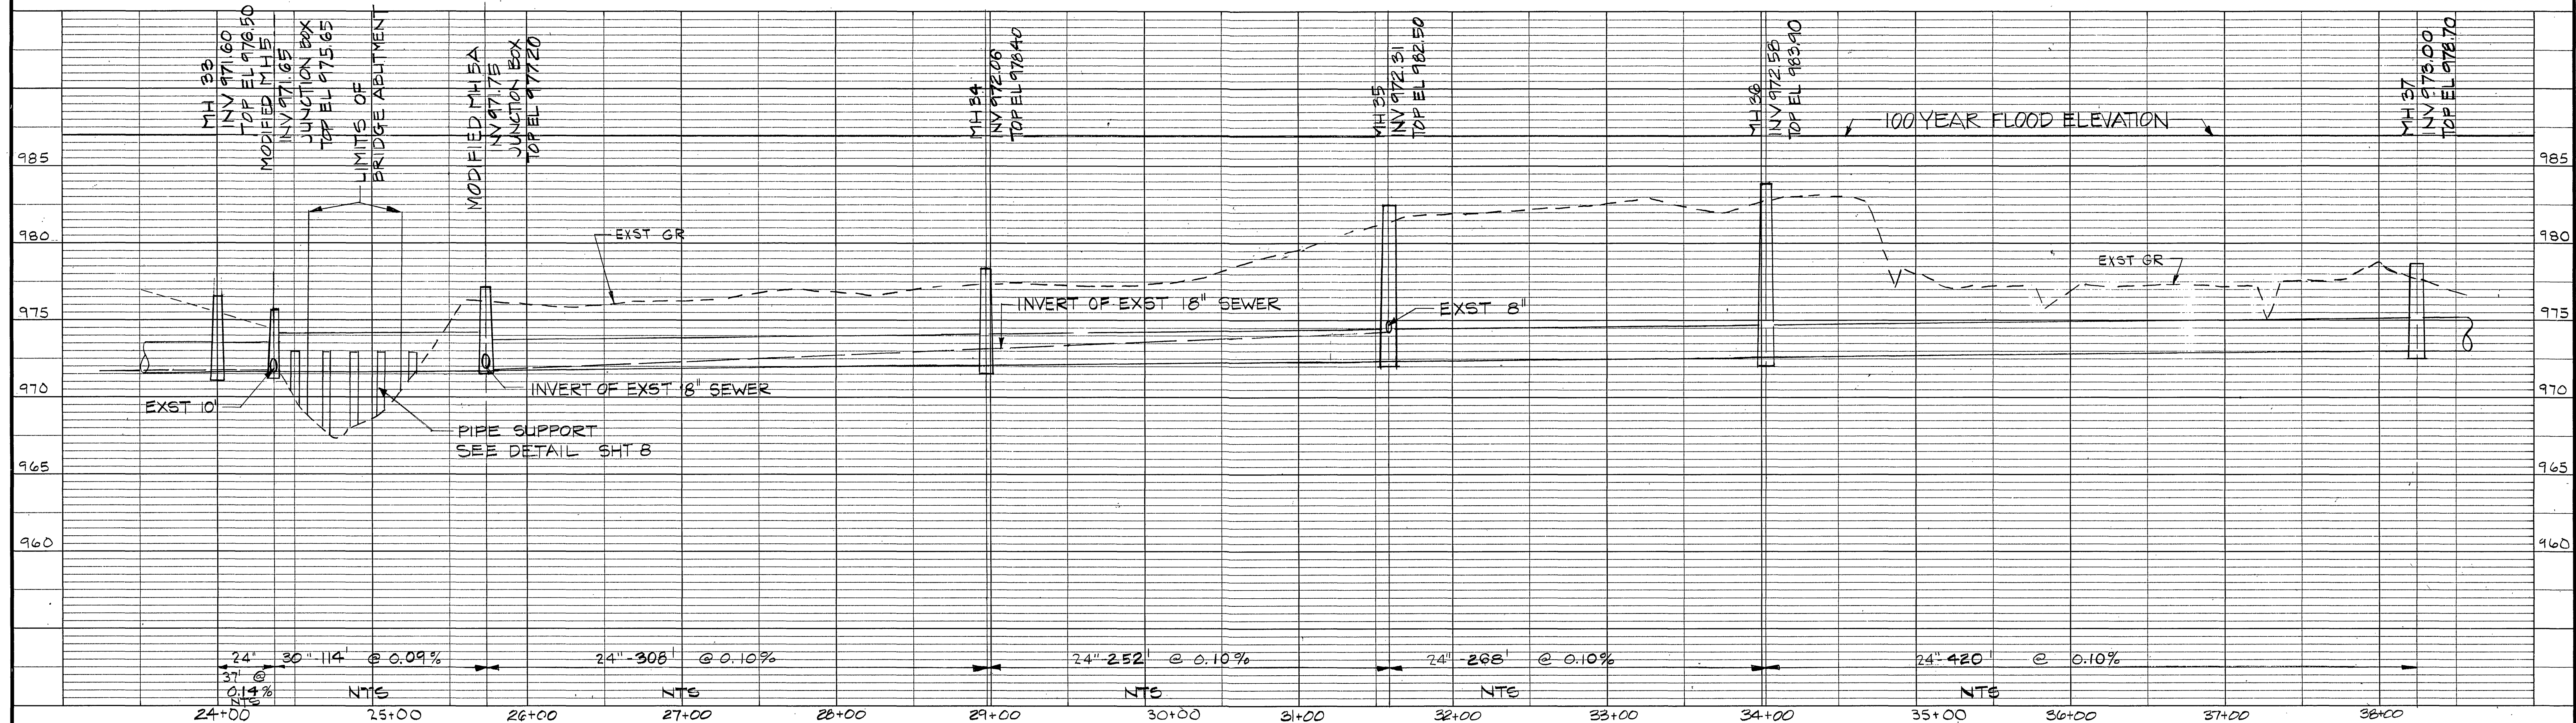


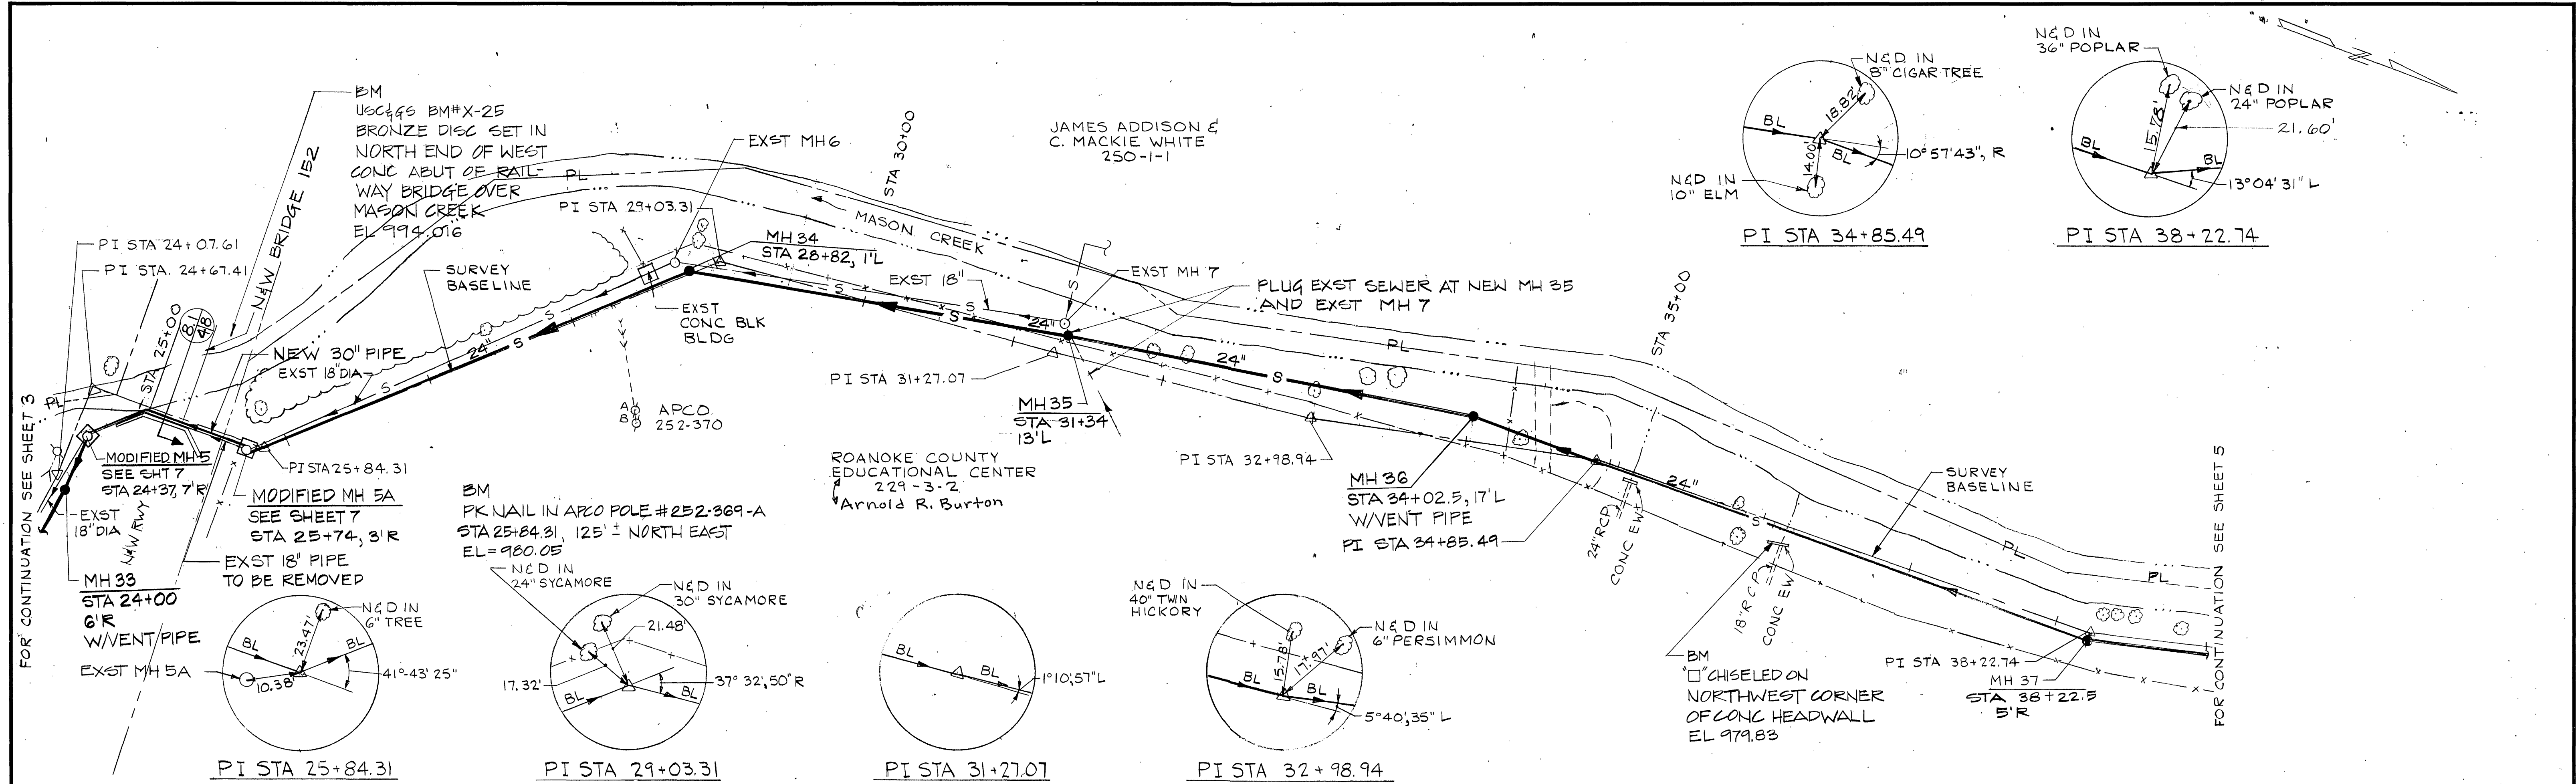

DESIGNED	SSJ	8/80	REVISIONS			REVISIONS			MASON CREEK INTERCEPTOR SEWER CITY OF SALEM, VIRGINIA HAYES, SEAY, MATTEN AND MATTEN ARCHITECTS - ENGINEERS - PLANNERS COMMONWEALTH OF VIRGINIA JAMES M. STRICKLAND, JR. No. 1378 REGISTERED PROFESSIONAL ENGINEER	PLAN AND PROFILE STATION 24+37 TO STATION 38+22.5			
DRAWN	JME	8/80	DATE	BY	DESCRIPTION	DATE	BY	DESCRIPTION		SCALE: HORIZ 1"=50'	DATE: AUG 1986	COMM. NO. 4212 B	DRAWING NO. 4
CHECKED	MLB	8/80								VERT 1"=5'			
APPROVED	JAP	8/80											