

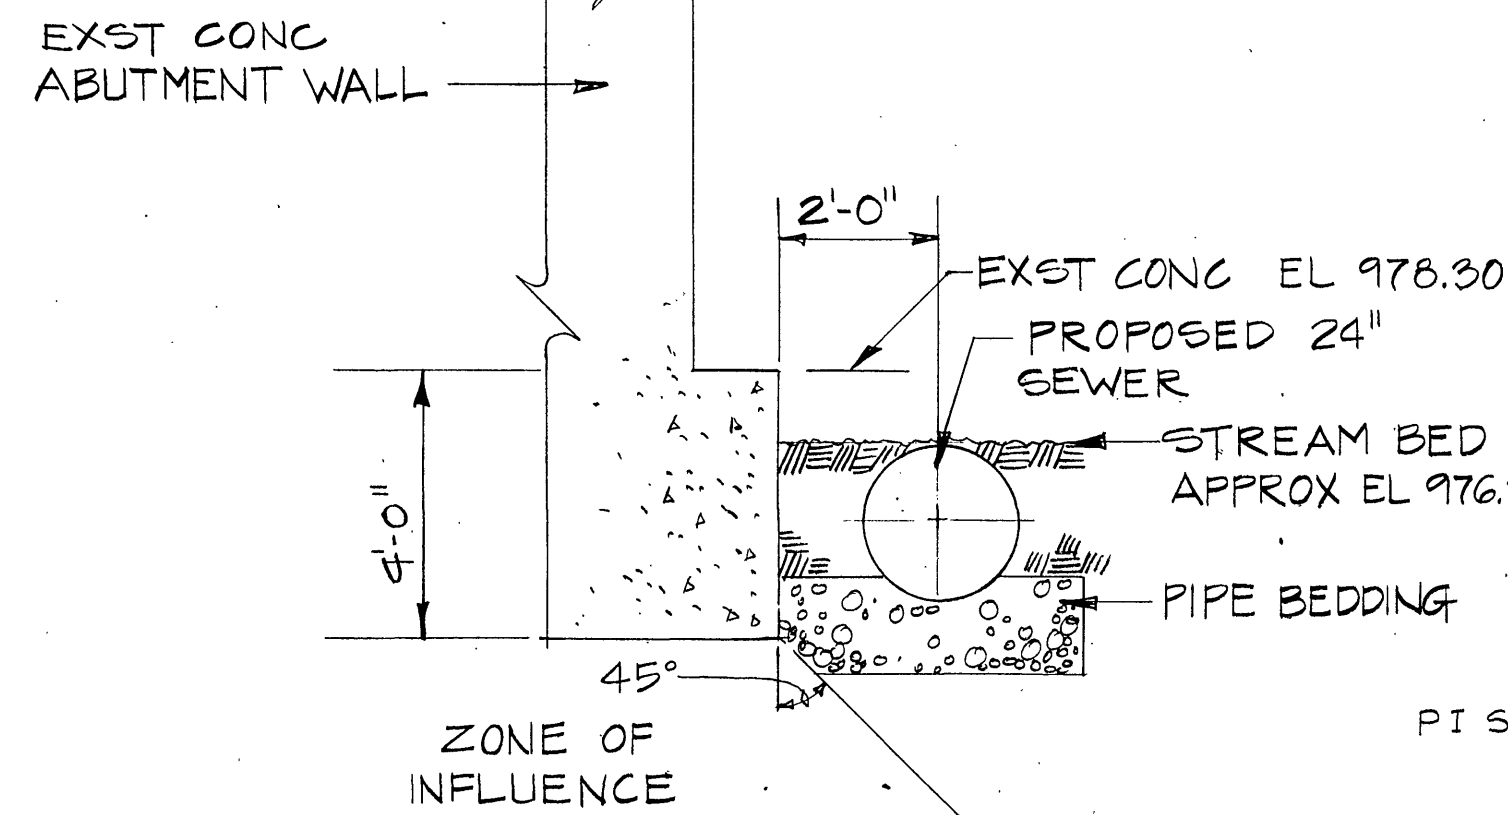


NOTE: 4'-0" FOOTED DEPTH IS
FROM VDHT MASON CREEK
BRIDGE SUBSTRUCTURE
DETAILS DATED JAN, 1936.

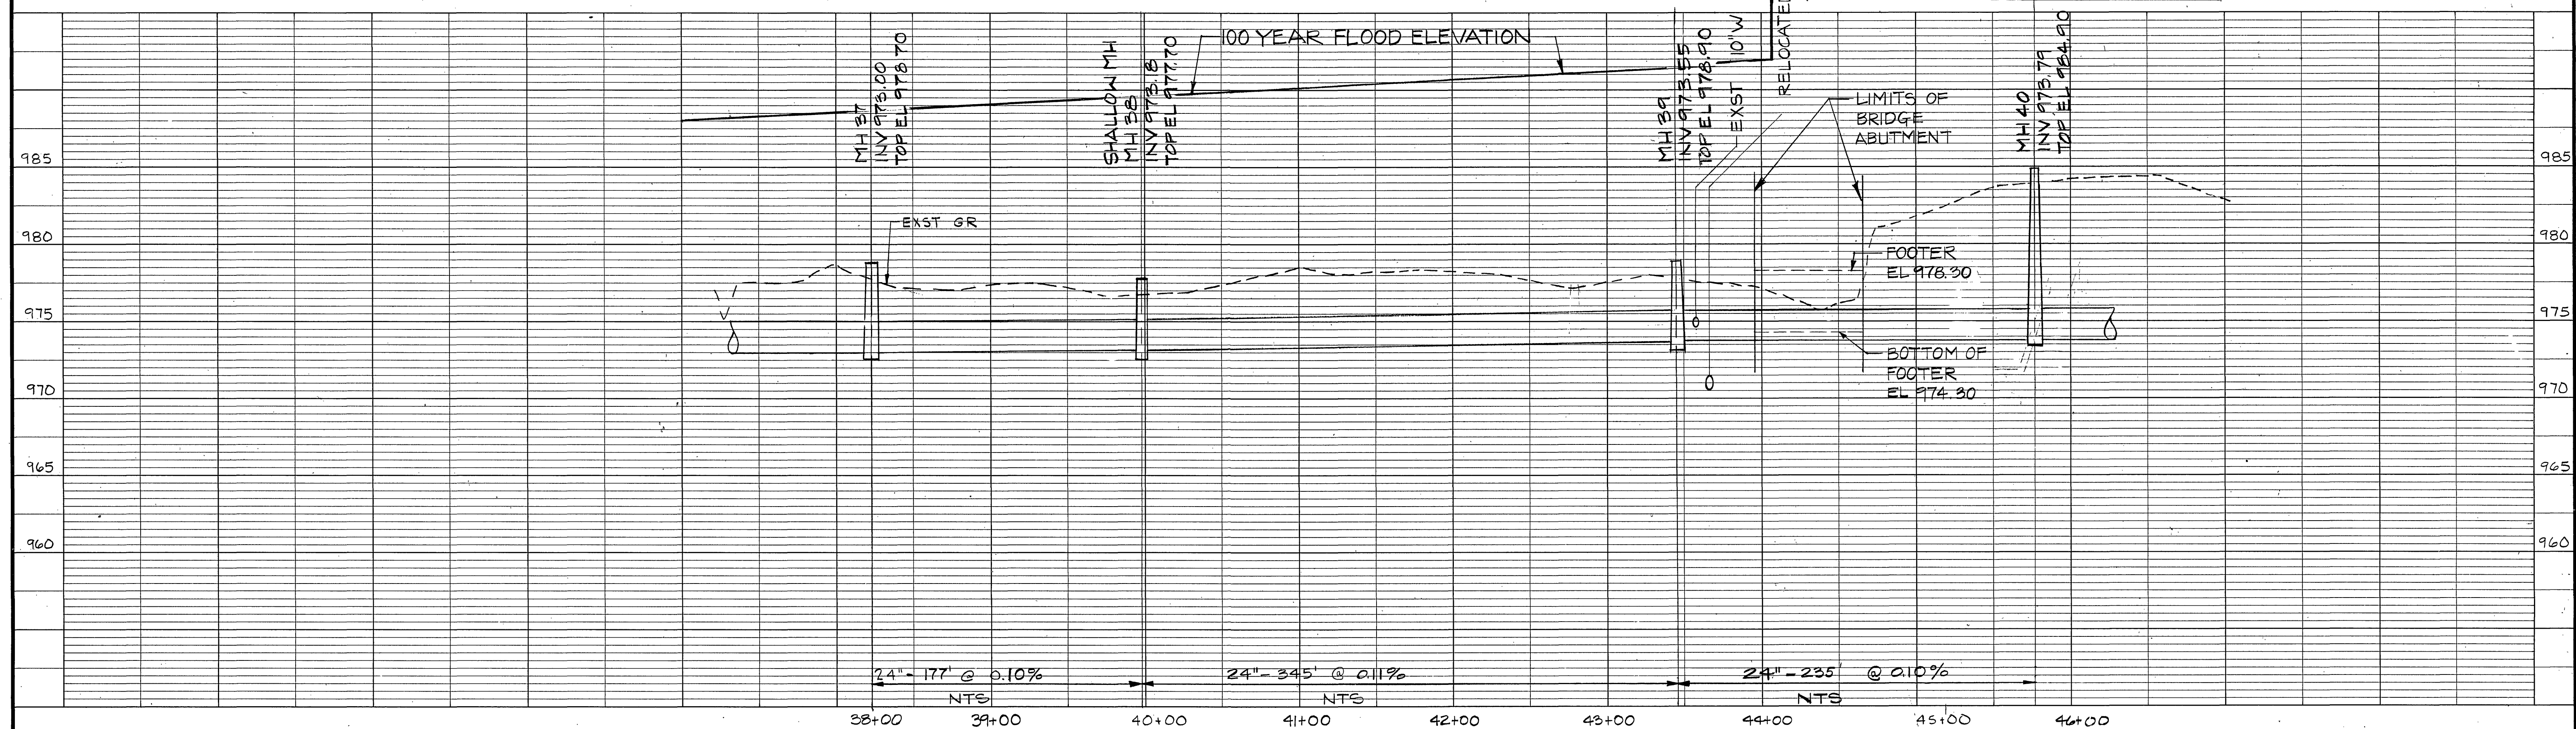

NOTE: PIPE TRENCH SHALL NOT
BE EXCAVATED WITHIN THE ZONE
OF INFLUENCE SHOWN


SECTION
NO SCALE

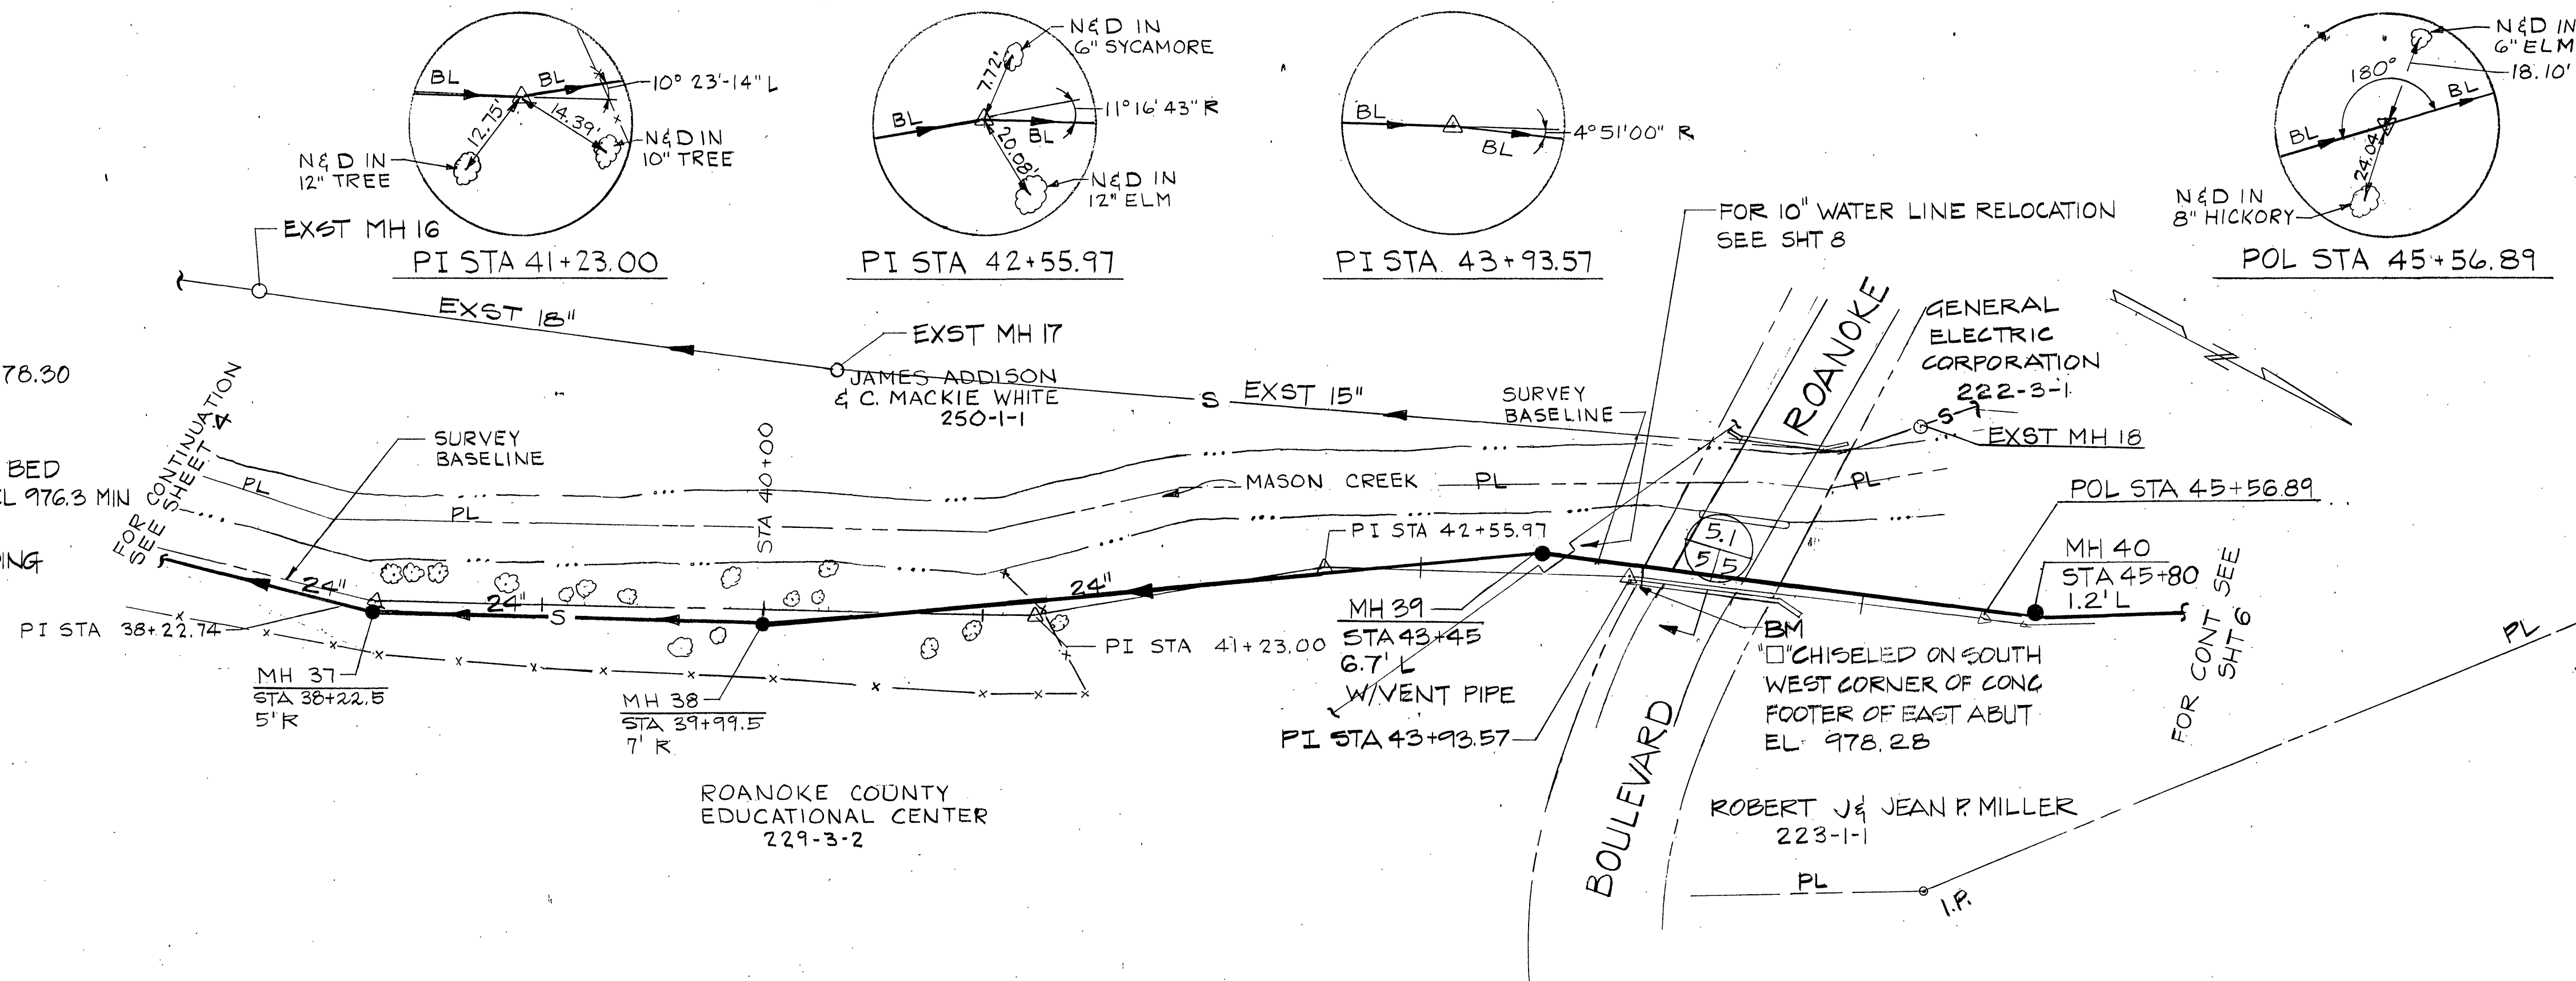

DESIGNED	DATE	DATE	BY	DESCRIPTION	DATE	BY	DESCRIPTION
JME	8/86						
DRAWN	8/86						
CHECKED	8/86						
APPROVED	8/86						

MASON CREEK INTERCEPTOR SEWER
CITY OF SALEM, VIRGINIA

HAYES, SEAY, MATTERN AND MATTERN
ARCHITECTS - ENGINEERS - PLANNERS

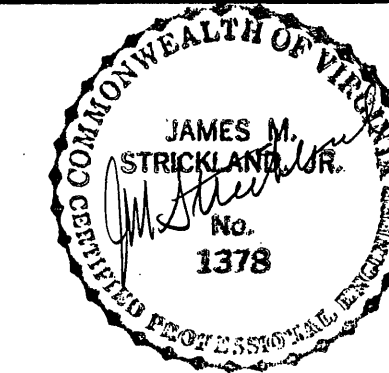

PLAN AND PROFILE
STATION 38+22.5 TO STATION 45+75

SCALE: HORIZ 1"=50'	DATE: AUG 1986	COMM. NO. 4212 B	DRAWING NO. 5
---------------------	----------------	------------------	---------------