



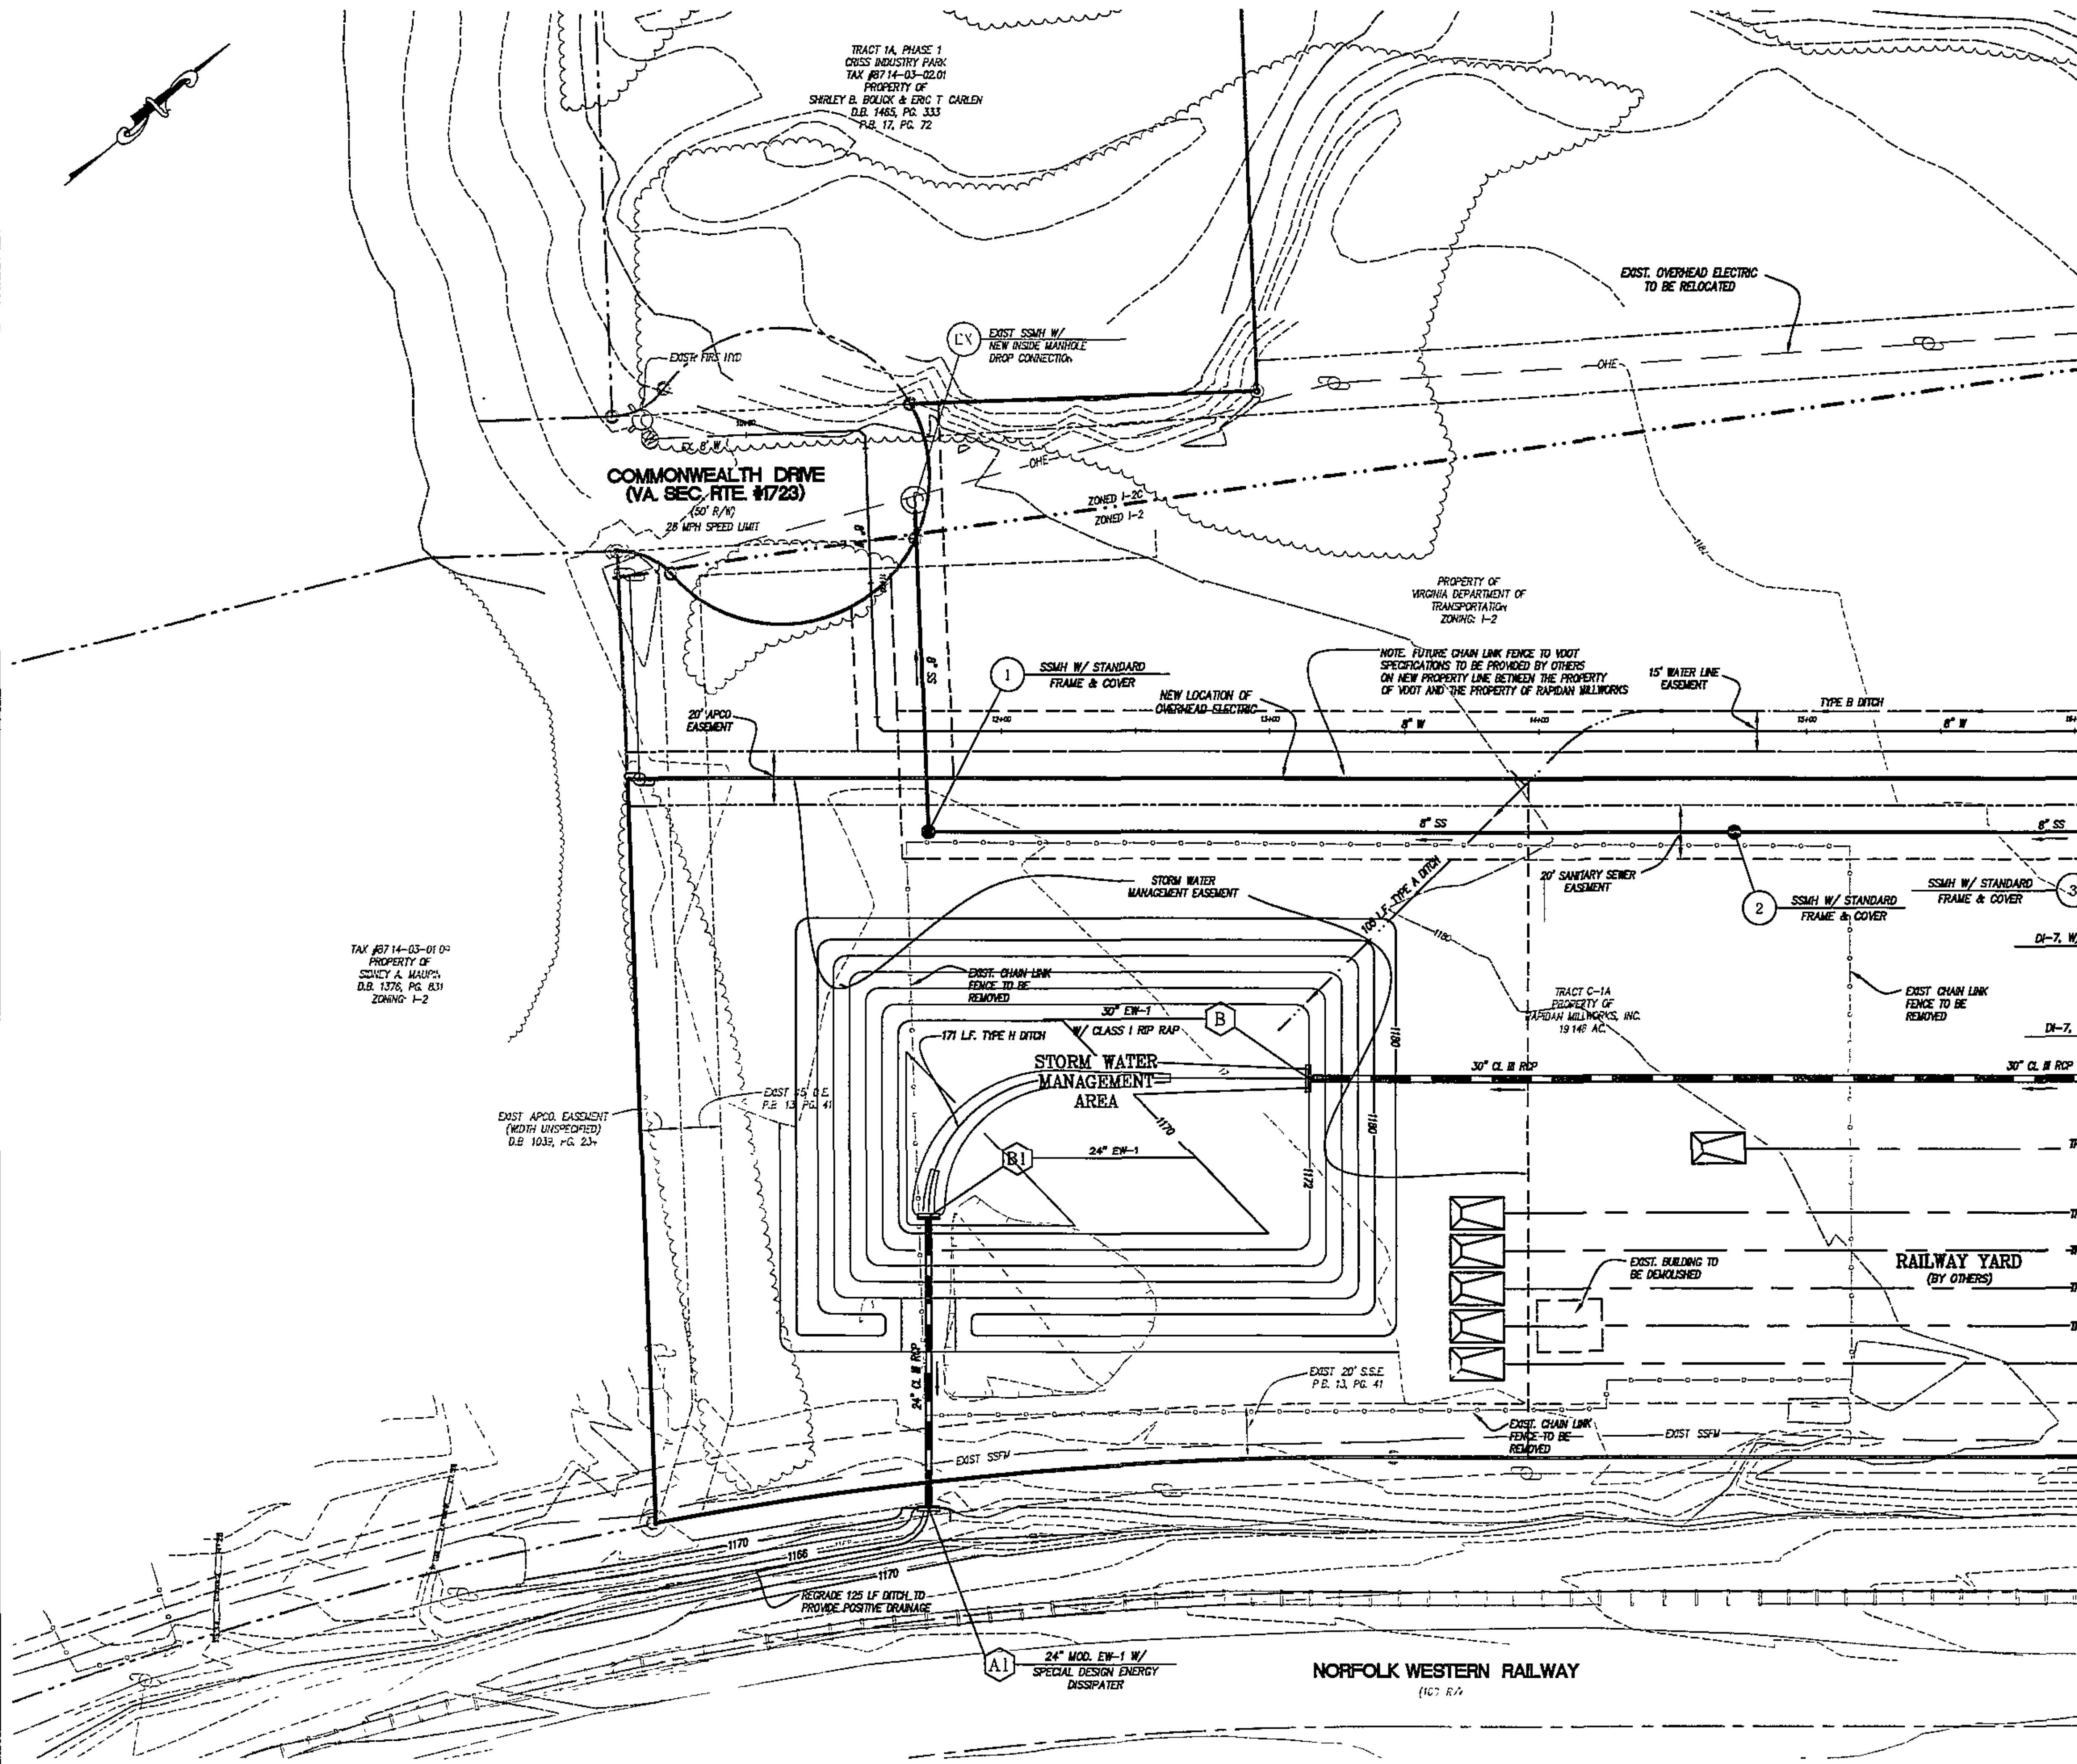

OVERVIEW MAP
NO SCALE

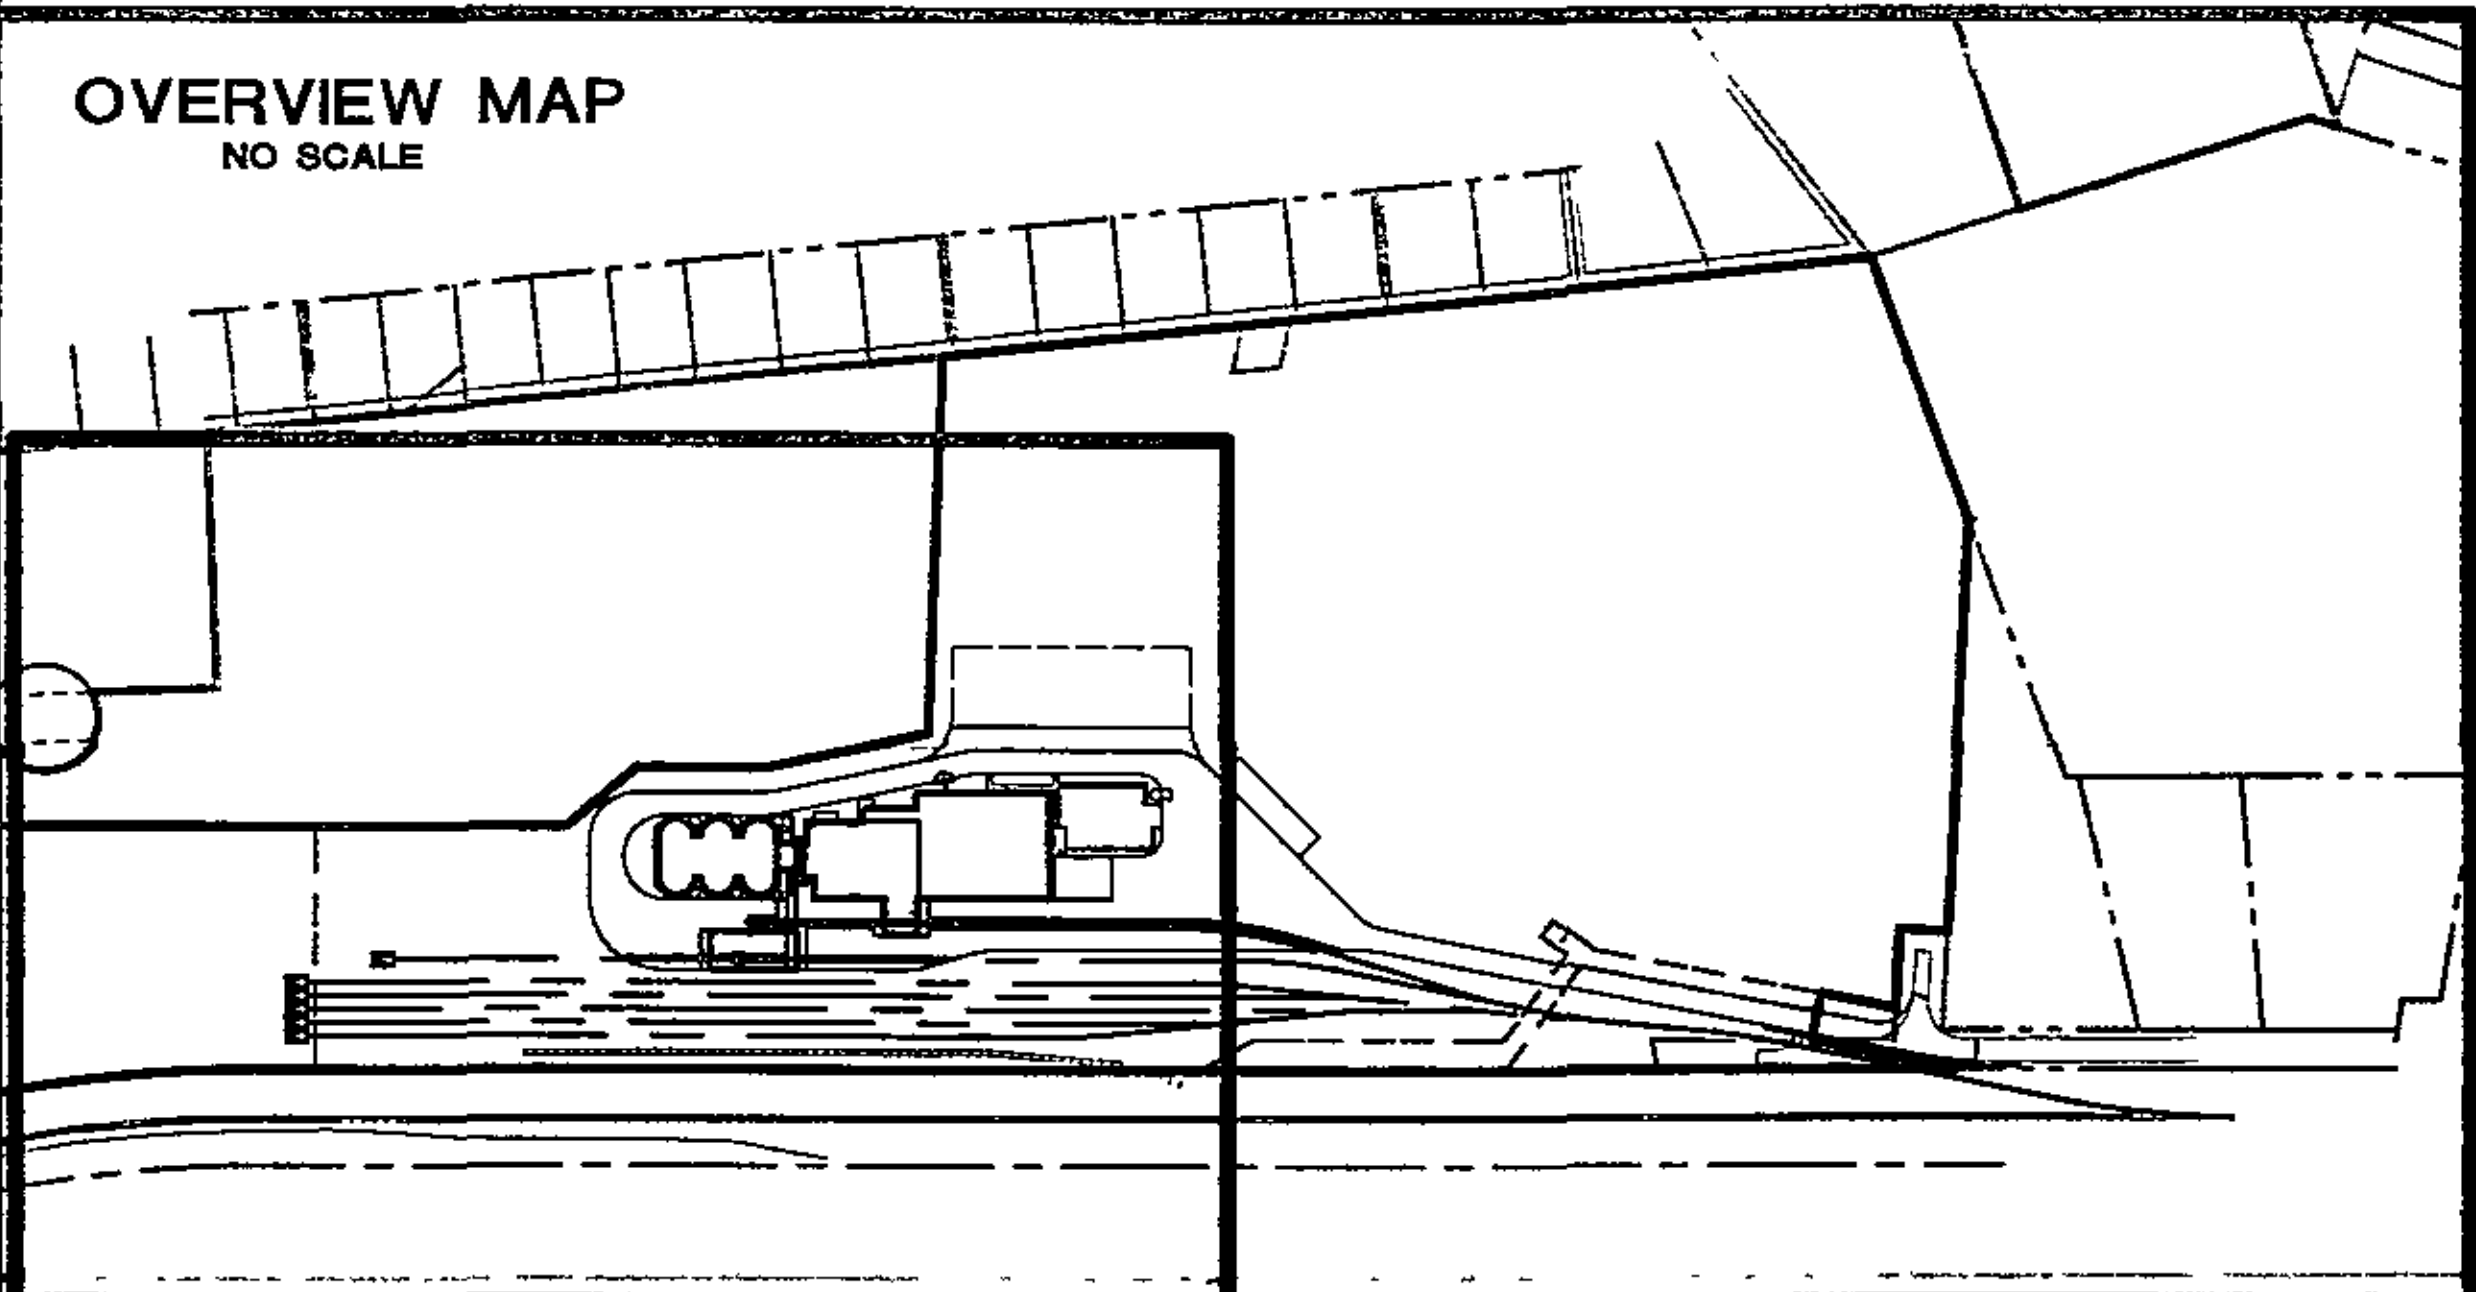

LEGEND		EXISTING	PROPOSED
ITEM			
PAVEMENT		---	---
CURB		---	---
CURB AND GUTTER		---	---
MANHOLE		⊙	⊙
STORM DRAIN		15" SD	15" CONC
SANITARY SEWER		8" SS	8" SS
DOMESTIC WATER LINE		---	---
CONCRETE		---	---
GRAVEL		---	---
UTILITY POLE		⊕	⊕
PIPE BOLLARD		---	---
ELECTRIC LINE - OVERHEAD		---CHE---	---
TELEPHONE - OVERHEAD		---OHT---	---
CONTOUR		---1020---	---1020---

LUMSDEN ASSOCIATES, P.C.
ENGINEERS-SURVEYORS-PLANNERS
ROANOKE, VIRGINIA

4664 BRAMBLETON AVENUE
P.O. BOX 20660
ROANOKE, VIRGINIA 24016

PHONE: (540) 774-4411
FAX: (540) 772-2445
E-MAIL: MAIL@LUMSDEN.COM



**GRADING & STORM
DRAINAGE PLAN**

MENNEL MILLING CO. FLOUR MILL
PREPARED FOR
MENNEL MILLING COMPANY
CAVE SPRING MAGISTERIAL DISTRICT
ROANOKE COUNTY, VIRGINIA

REVISIONS		DATE	DESCRIPTION
NO.	DATE		
1	02/06/04		REVISED STORM DRAIN LAYOUT W/ 24" RCP OUTLET
2			
3			
4			
5			

DATE: JUNE 1, 2006
SCALE: 1"=30'
COMMISSION NO: 04-2171BE
SHEET 7 OF 16