
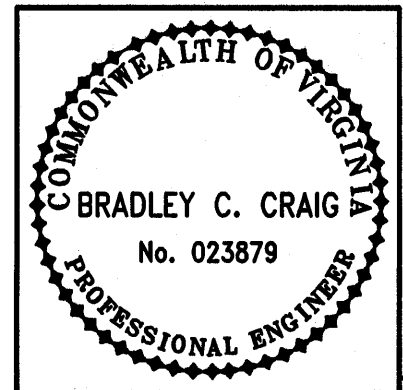
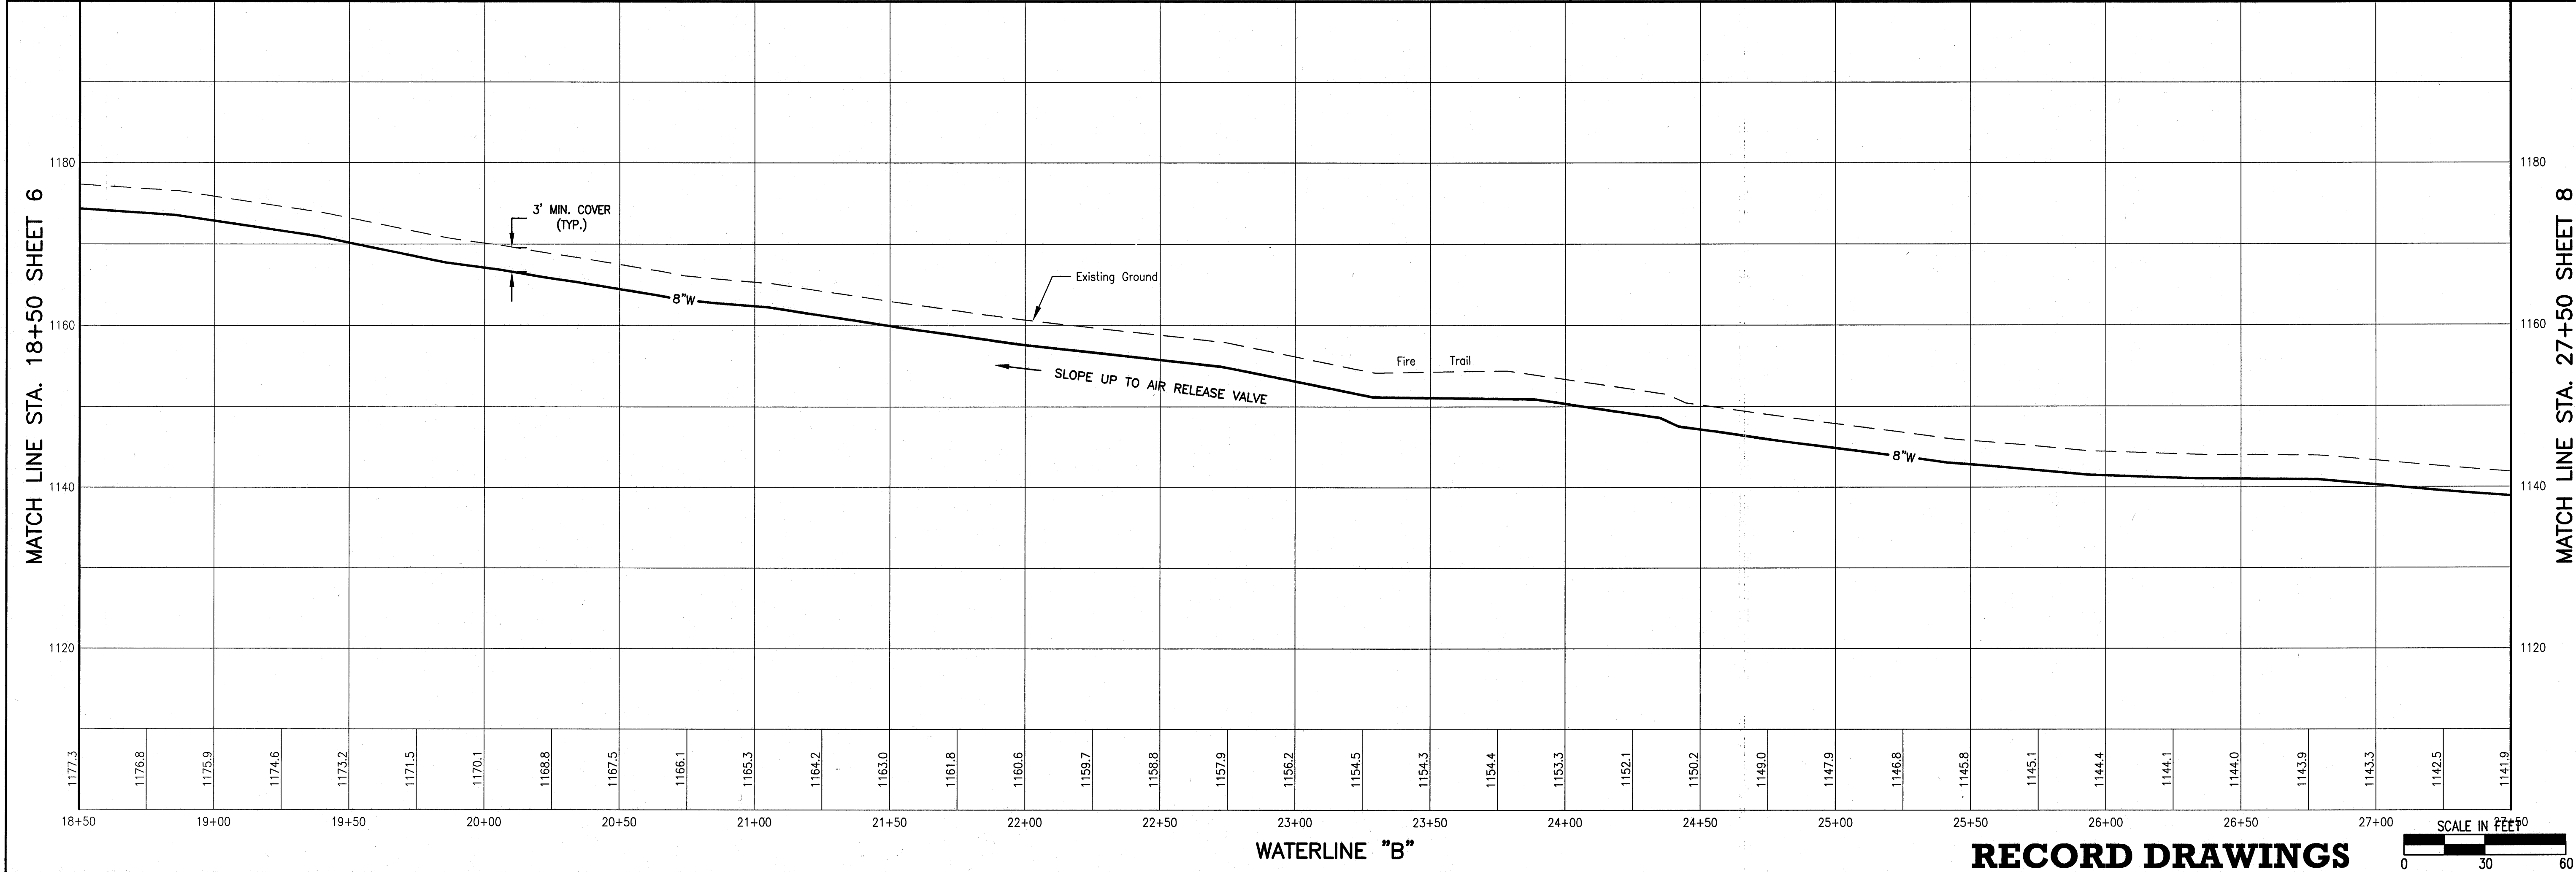


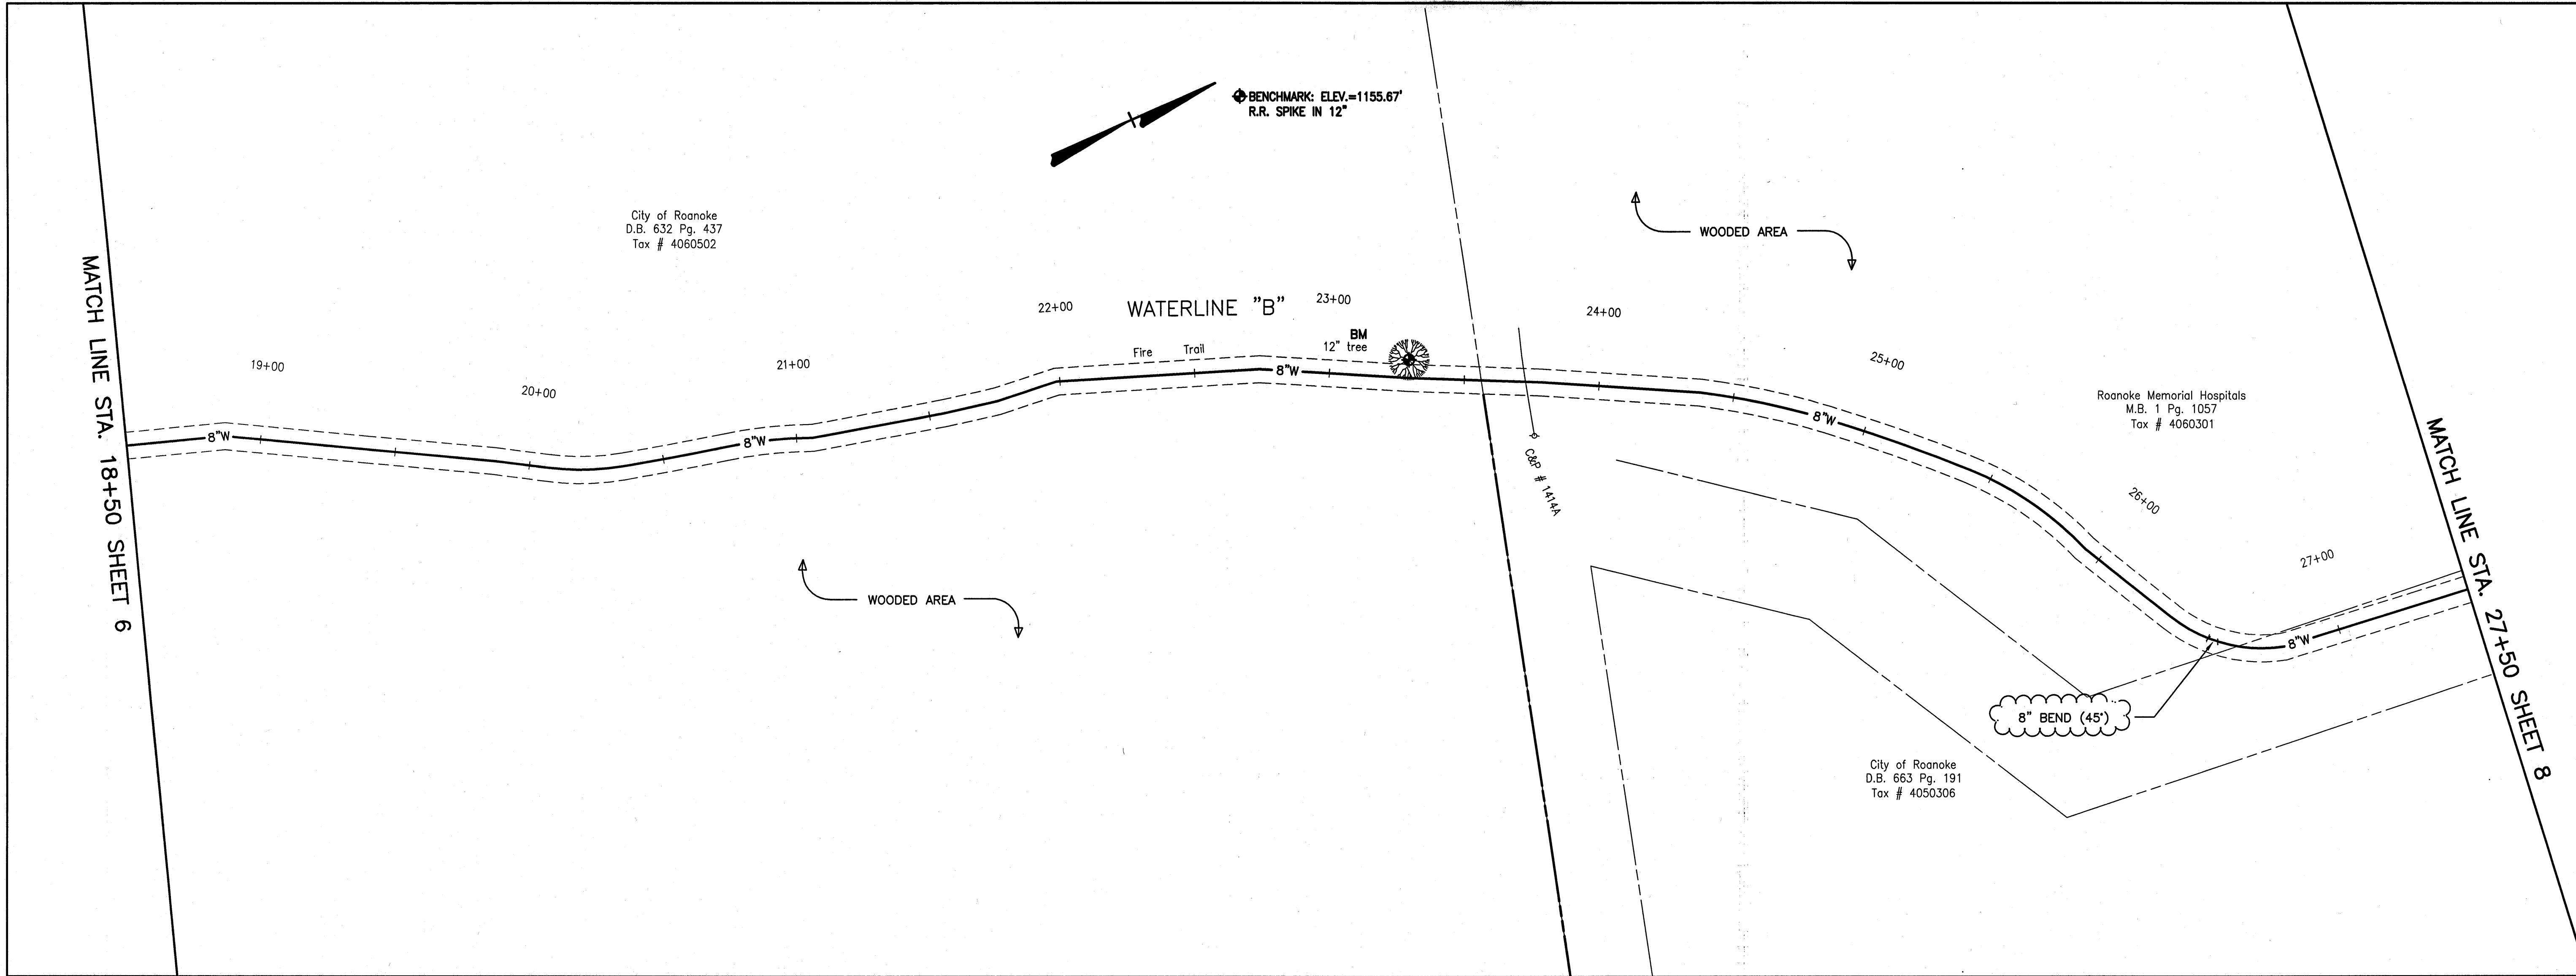

Date	
Revisions	

Issue Date:	02/17/04
Drawn By:	ARB
Designed By:	BCC
Checked By:	BCC
Date:	02/17/04

Mattem & Craig
CONSULTING ENGINEERS • SURVEYORS
701 FIRST STREET, S.W.
ROANOKE, VIRGINIA 24016
(540) 345-5852
FAX (540) 345-7891

MILL MOUNTAIN WATER PROJECT
**PLAN AND PROFILE -
8" WATERLINE**
CITY OF ROANOKE, VIRGINIA

Vertical Scale:	1" = 10'
Horizontal Scale:	1" = 30'
Commission Number:	2120
Sheet No.:	7

RECORD DRAWINGS

R:\DWG\2120\DWGS\7.DWG