
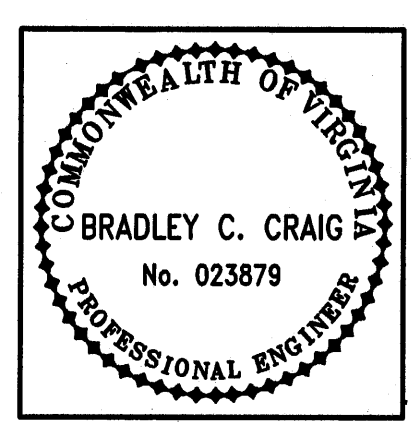
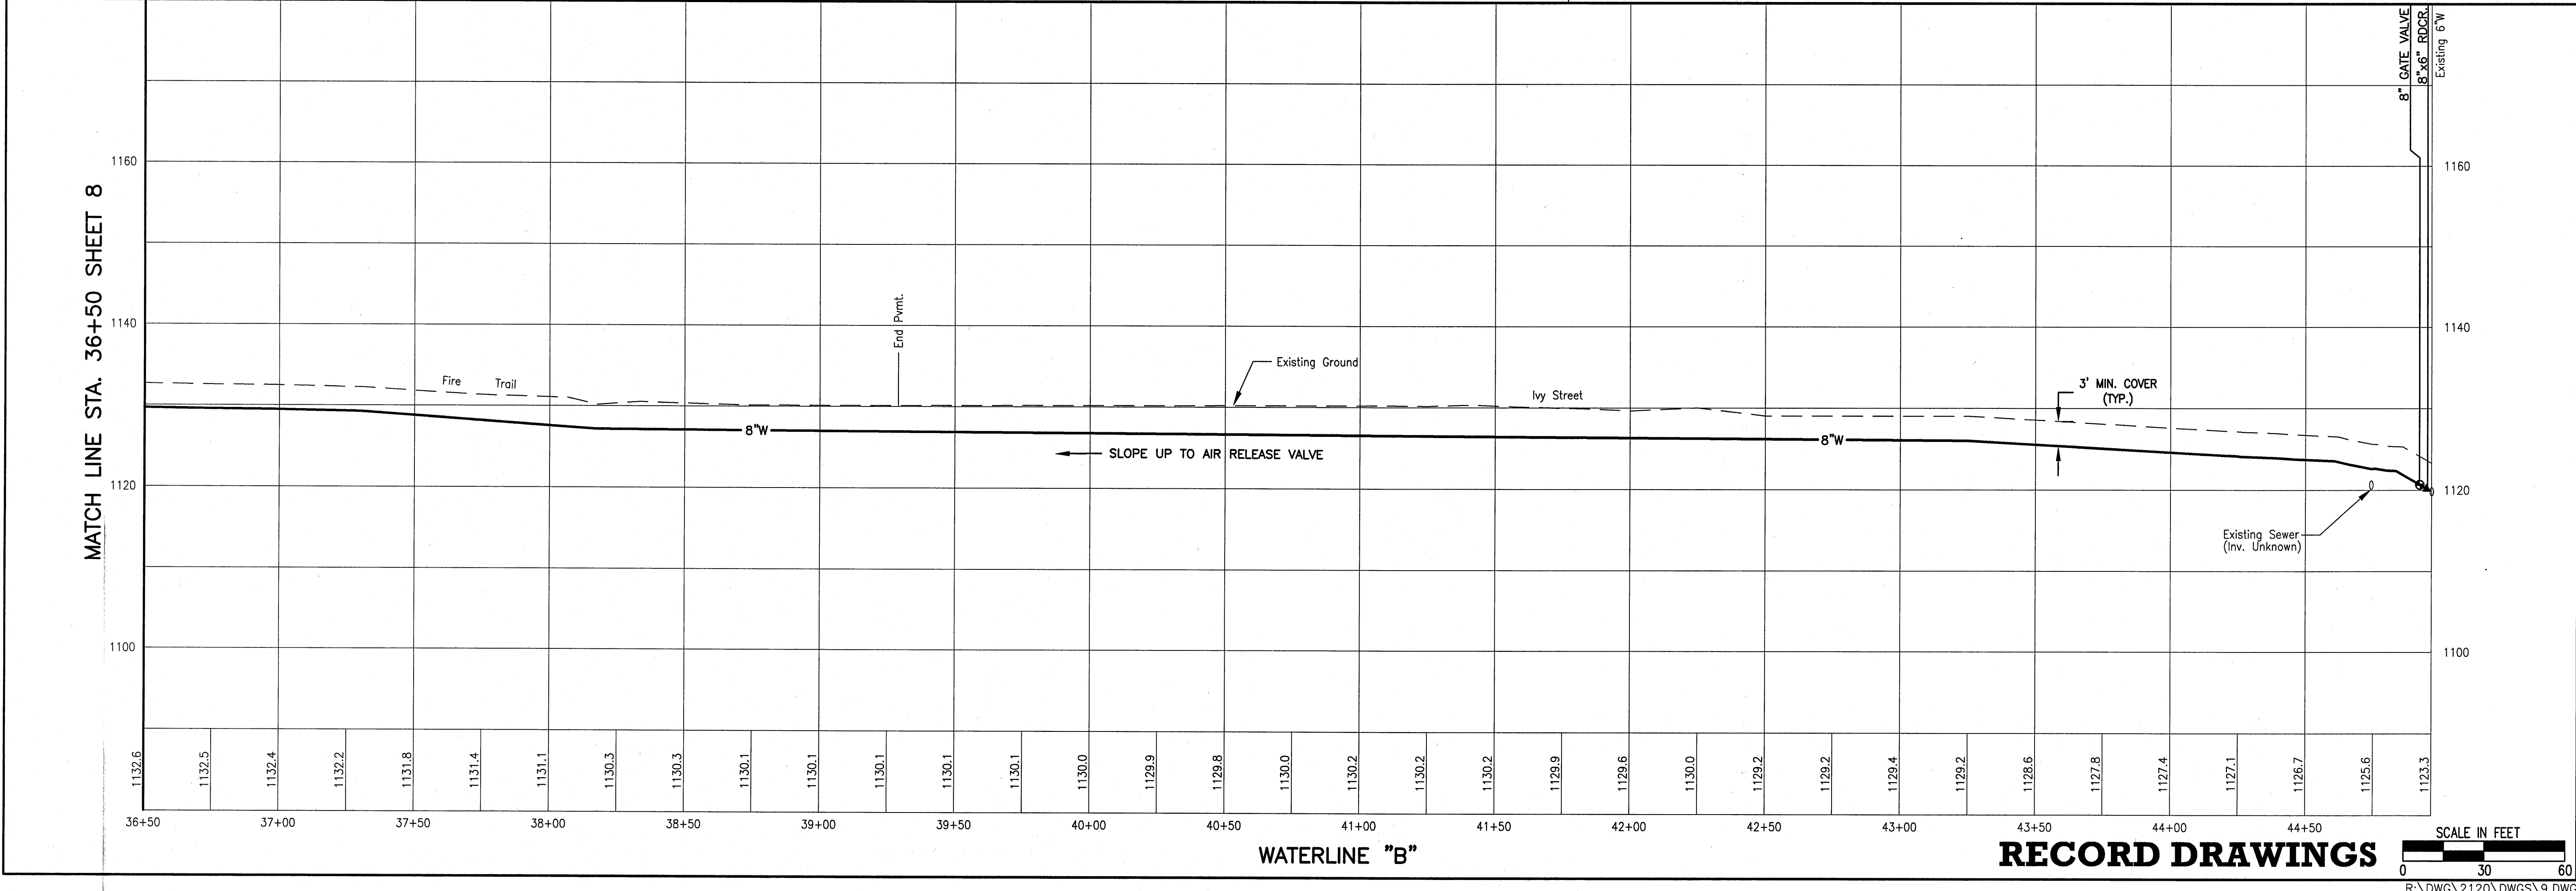


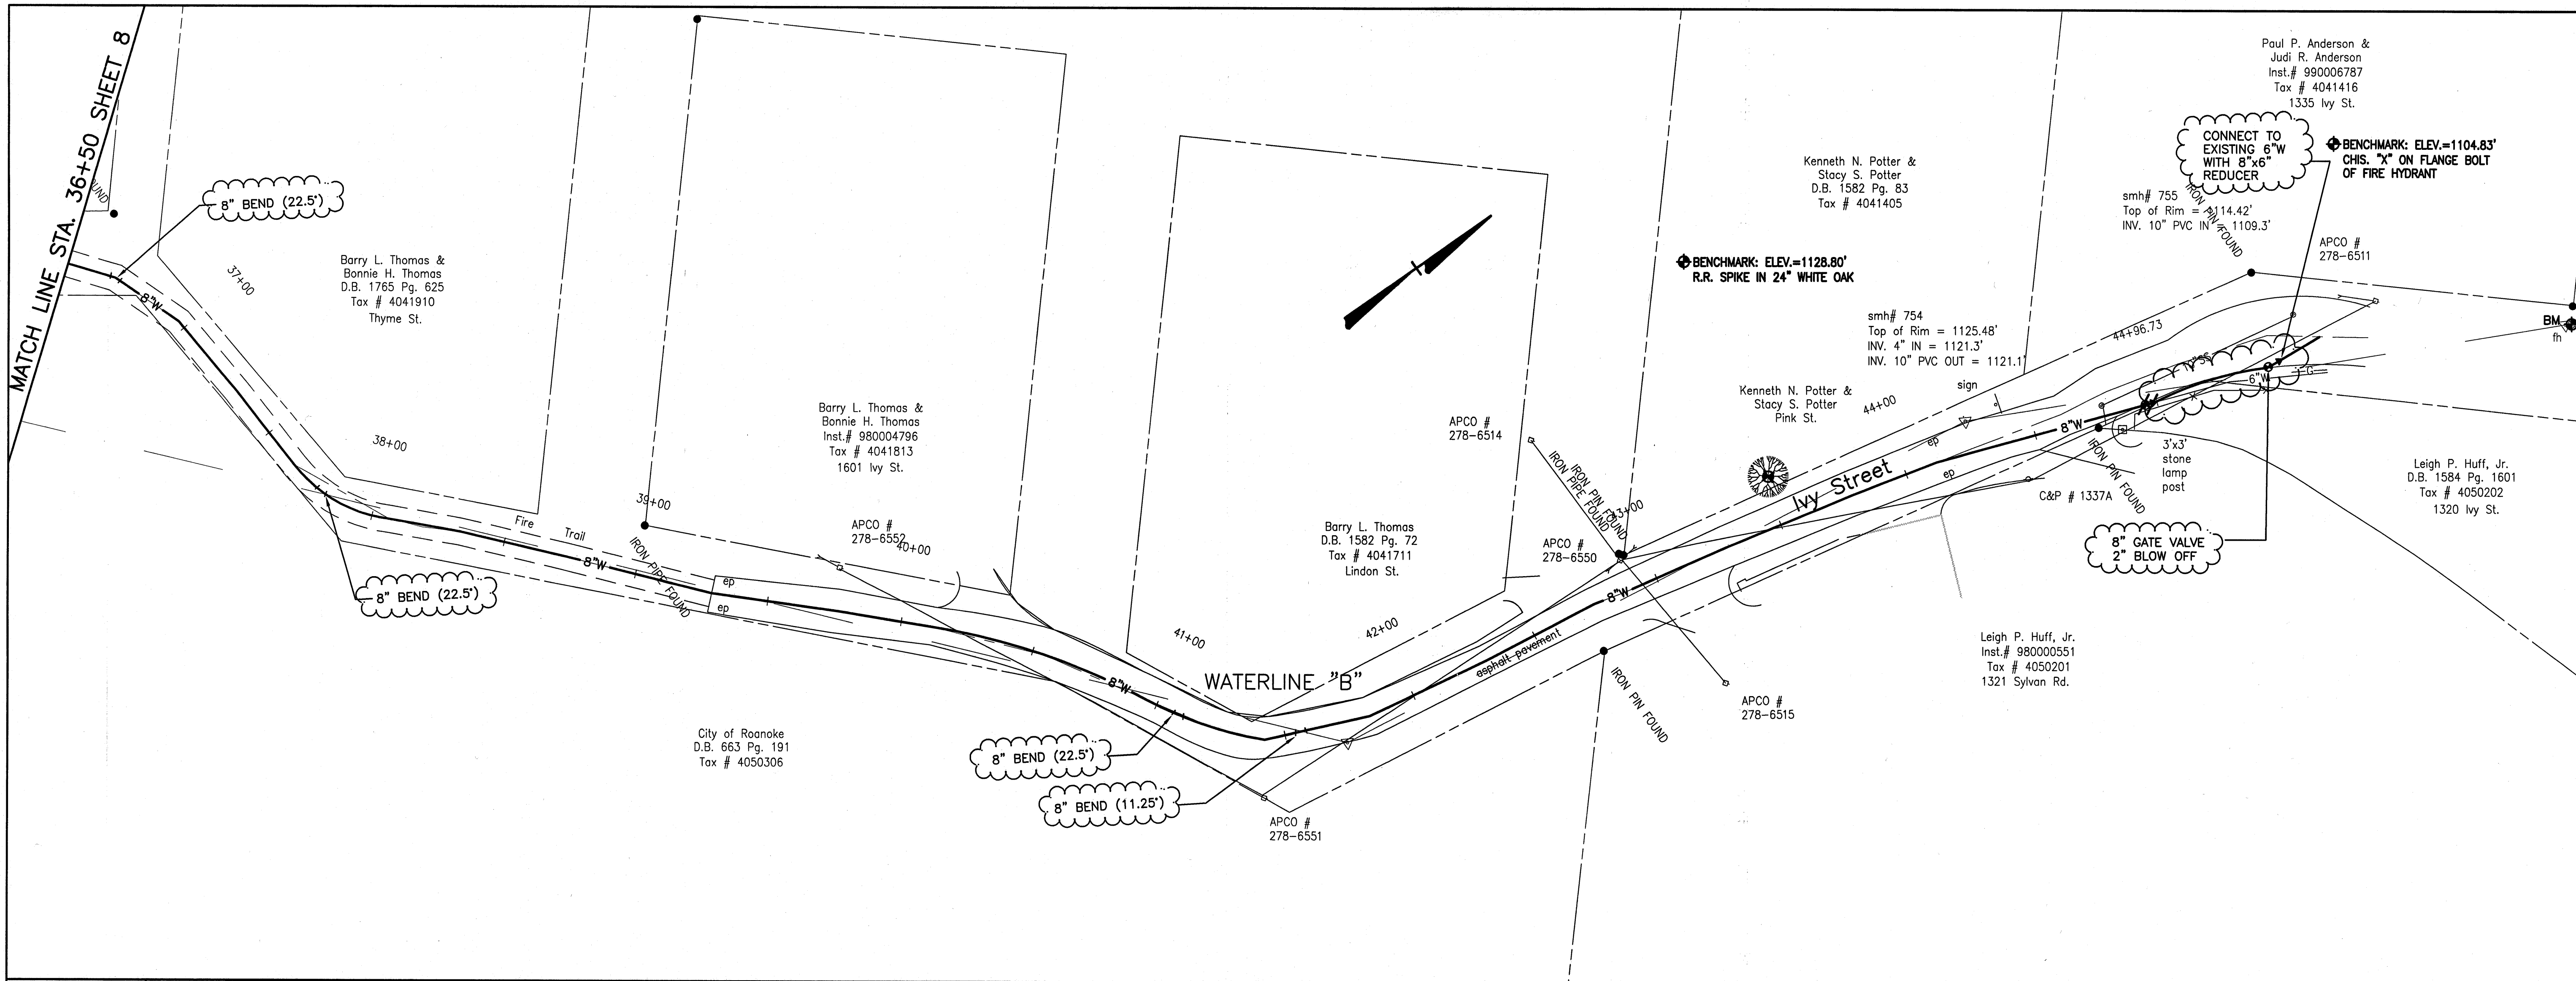

Date	
Revisions	

Issue Date:	02/17/04
Drawn By:	ARB
Designed By:	BCC
Checked By:	BCC
Date:	02/17/04

Mattem & Craig
CONSULTING ENGINEERS • SURVEYORS
701 FIRST STREET, S.W.
ROANOKE, VA 24016
(540) 345-5622
FAX (540) 345-7881

MILL MOUNTAIN WATER PROJECT
**PLAN AND PROFILE—
8" WATERLINE**
CITY OF ROANOKE, VIRGINIA


Vertical Scale:
1" = 10'

Horizontal Scale:
1" = 30'

Commission Number:
2120

Sheet No.:
9

RECORD DRAWINGS

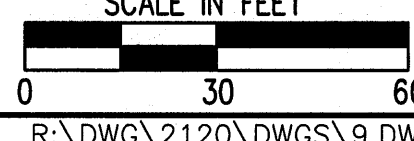

R:\DWG\2120\DWGS\9.DWG