
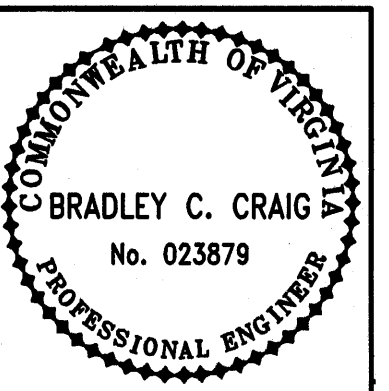
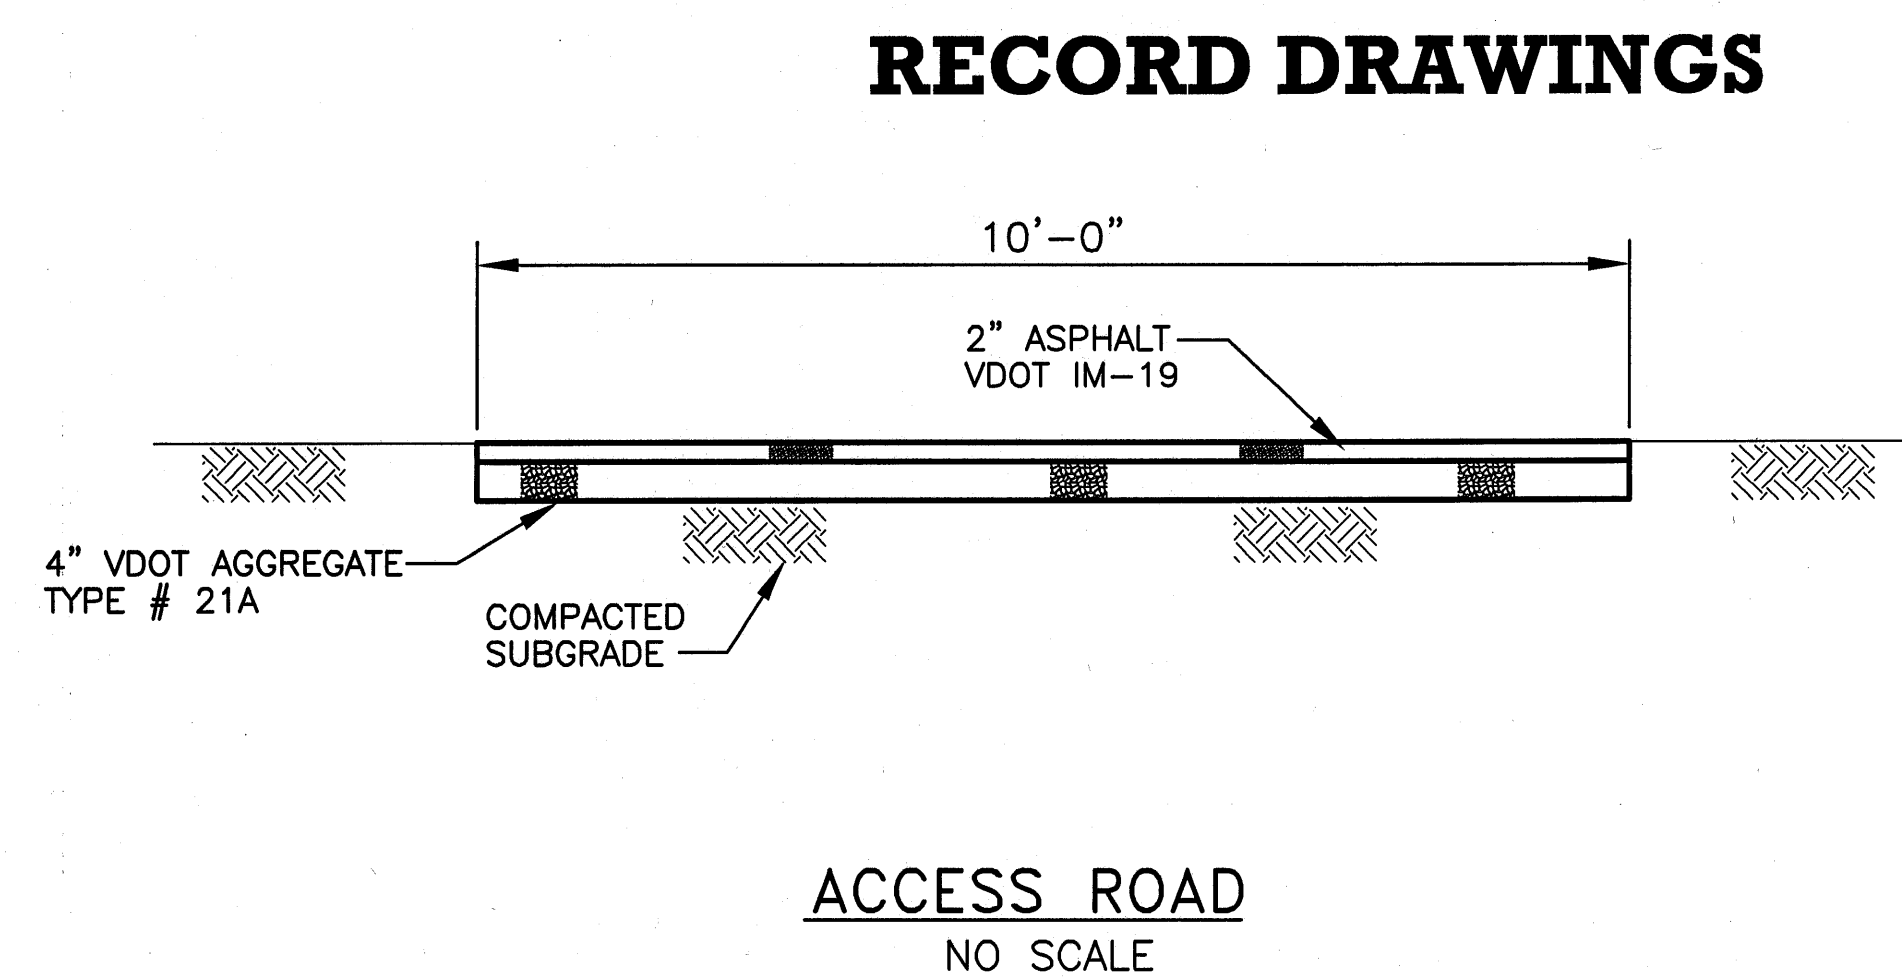
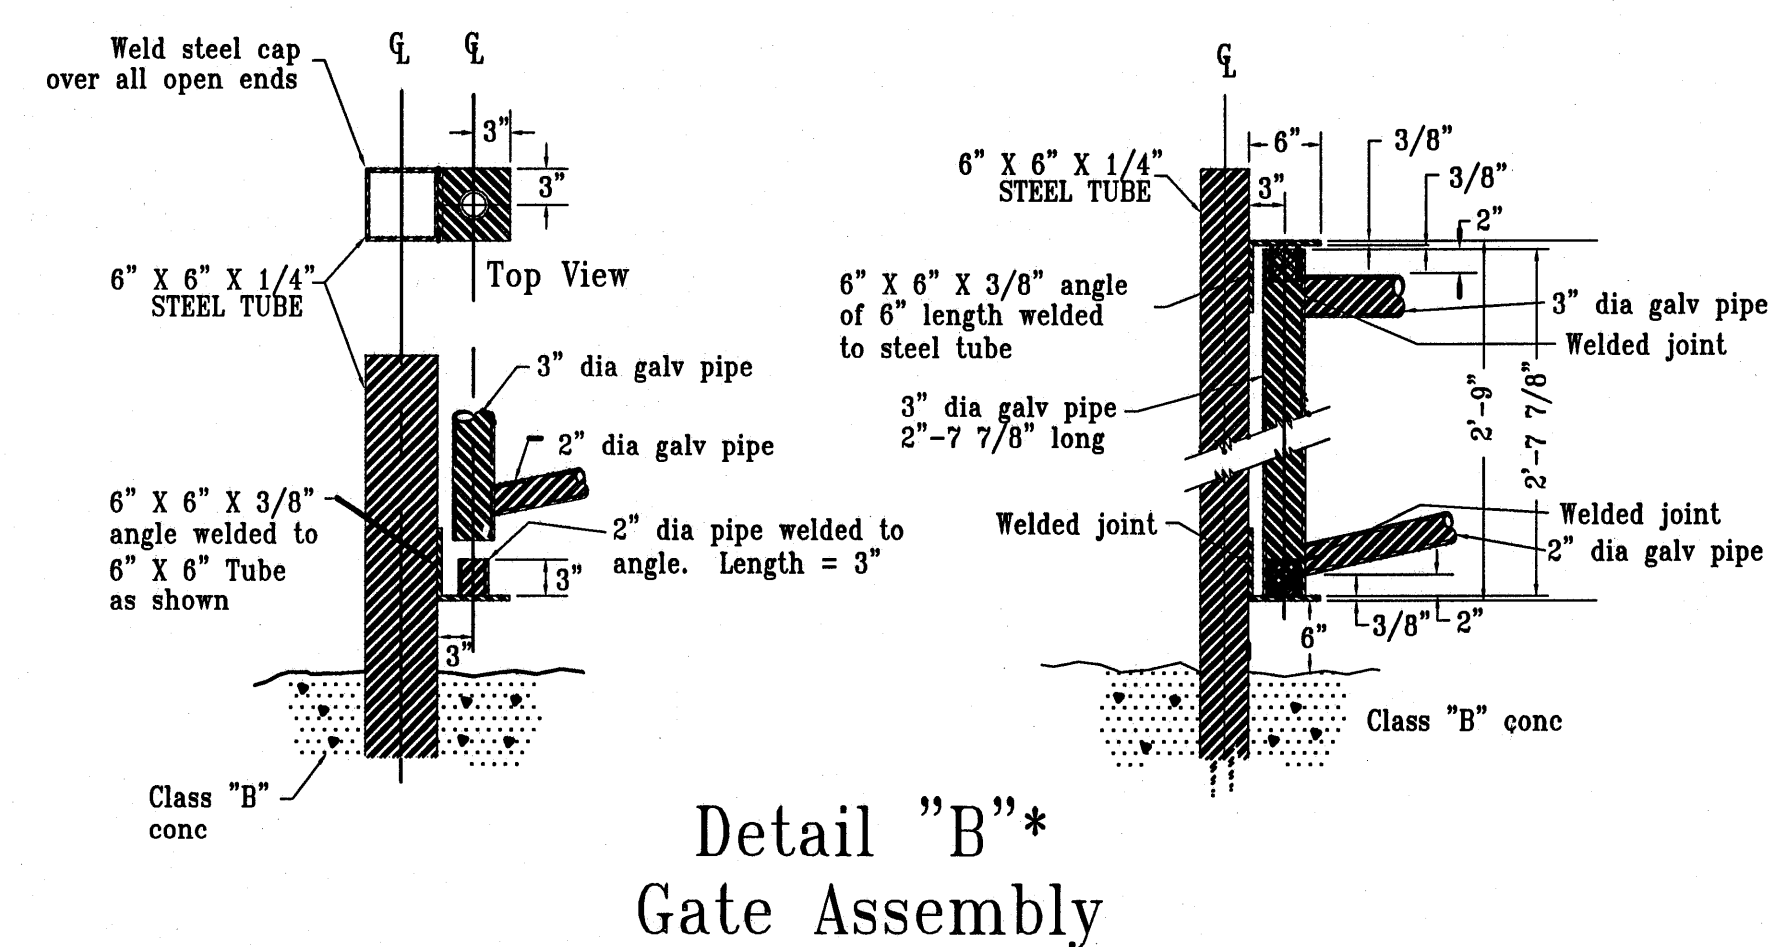
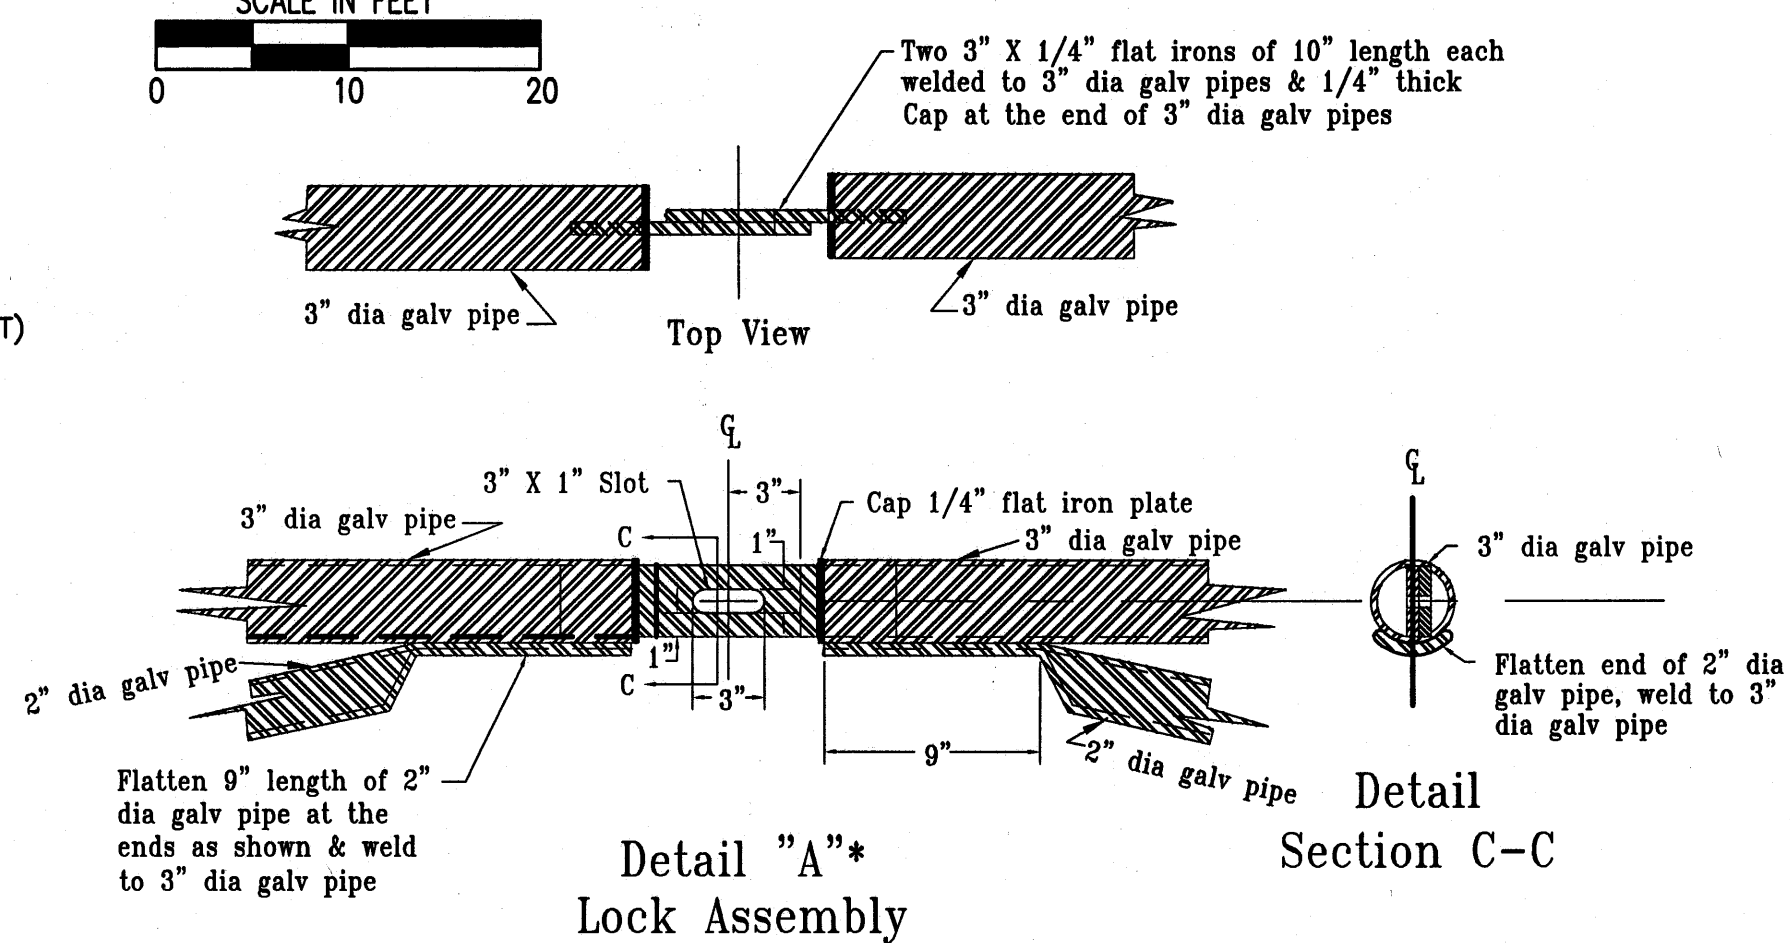
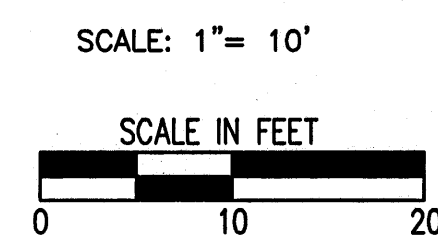
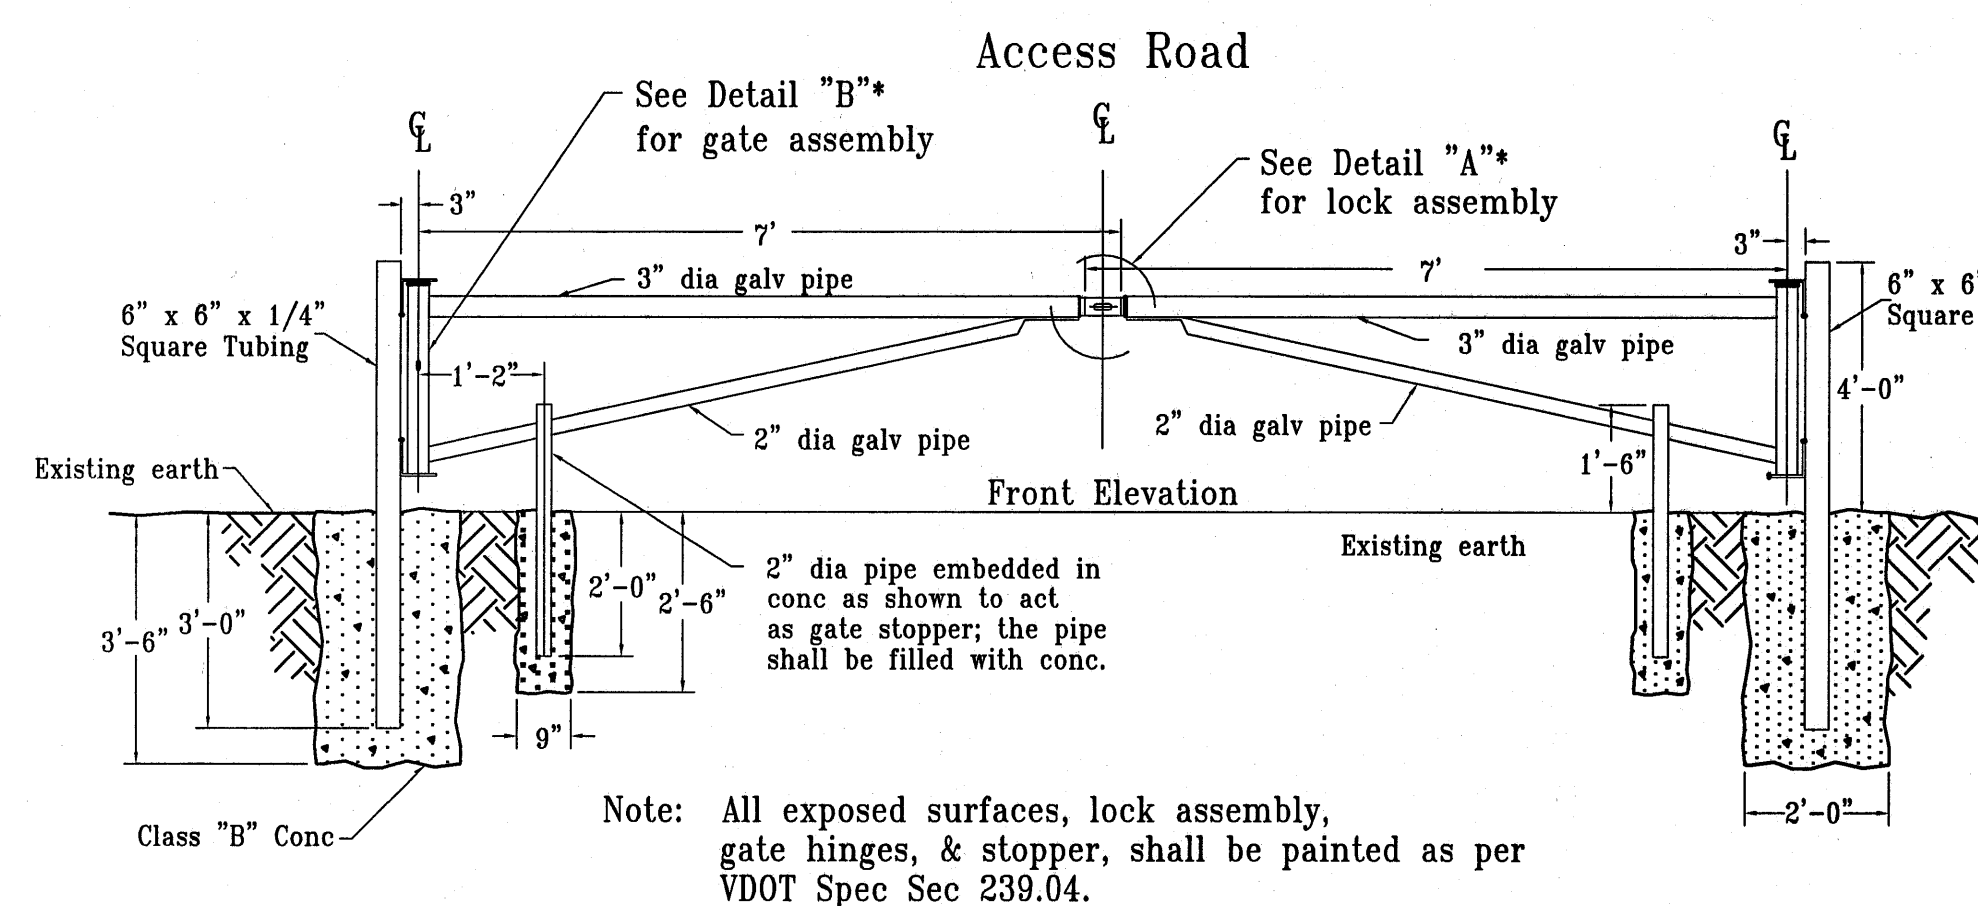
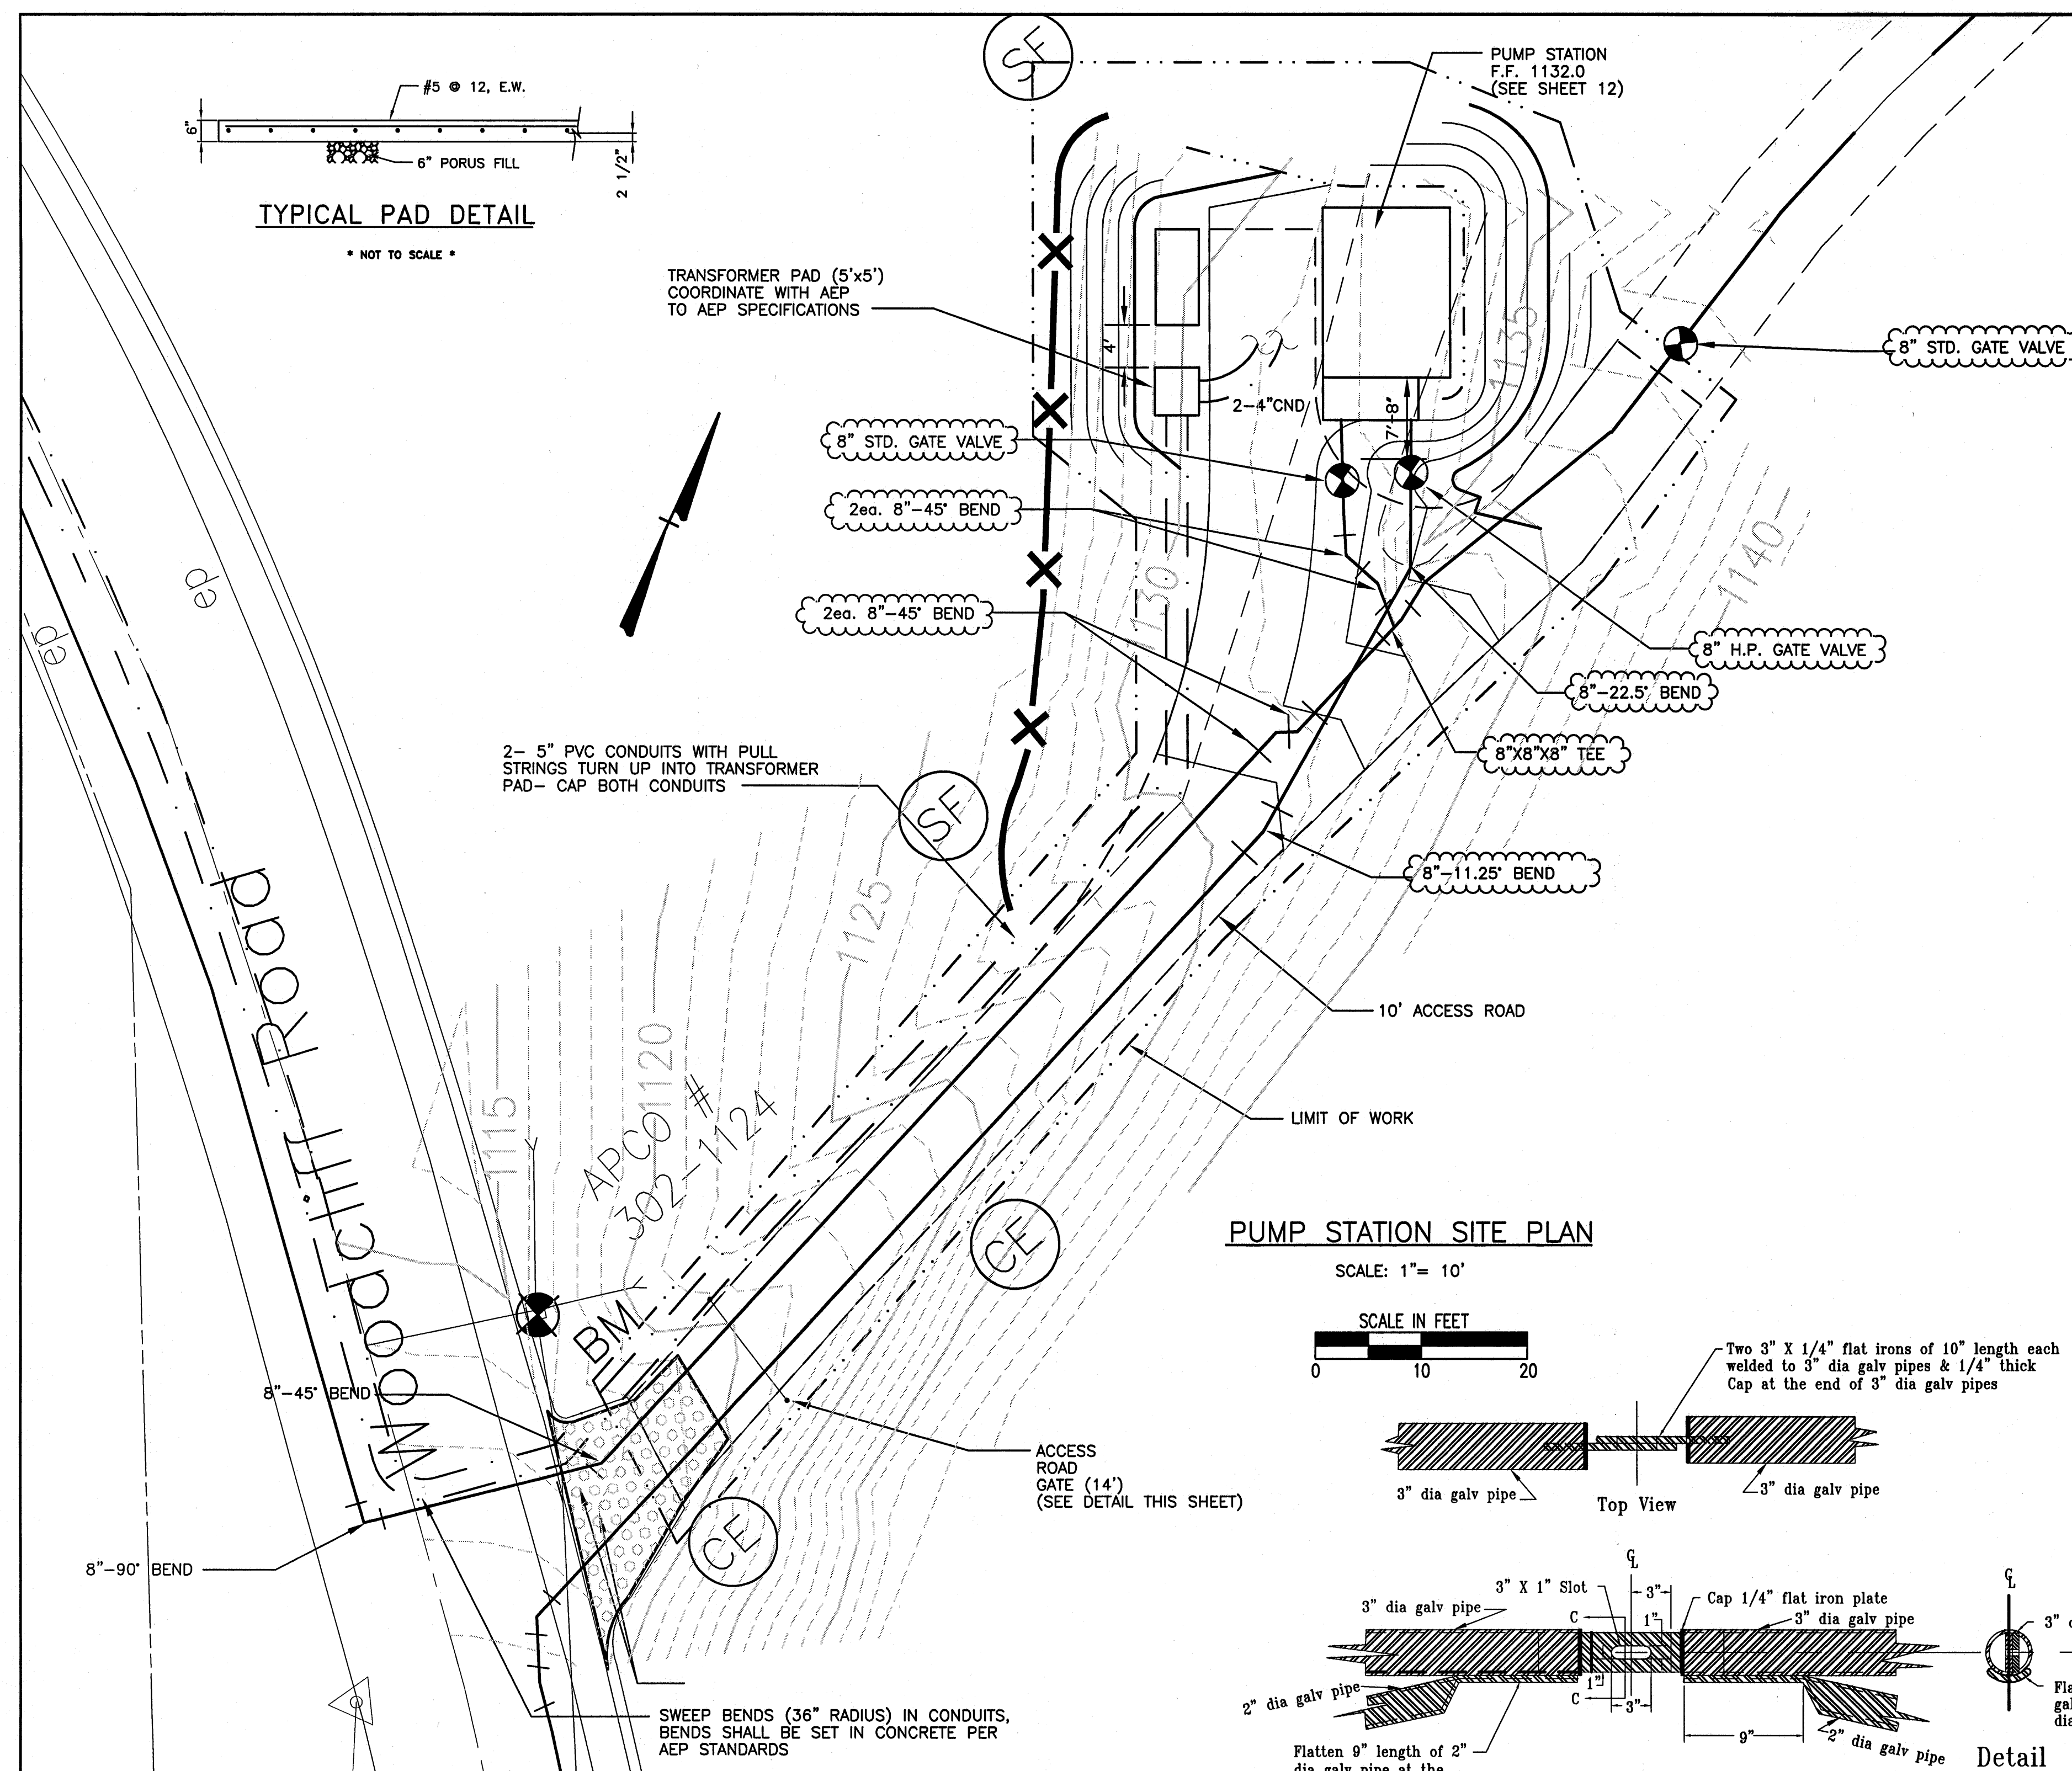


[illegible]

Issue Date: 02/17/04	Drawn By: ARB Designed By: BCC	Checked By: BCC Date: 02/17/04
-------------------------	-----------------------------------	-----------------------------------

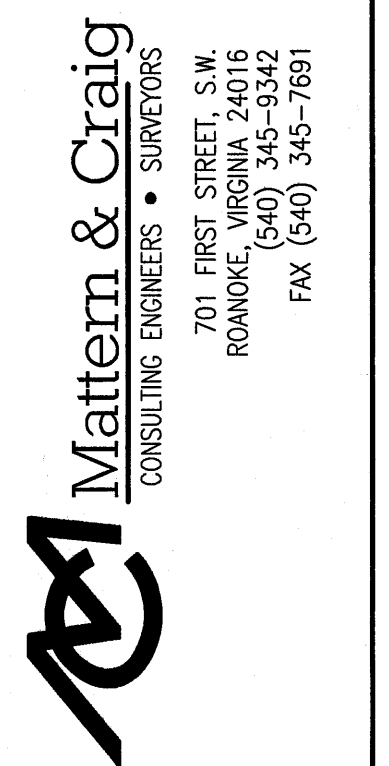

MILL MOUNTAIN WATER PROJECT
PUMP STATION—
SITE PLAN
CITY OF ROANOKE, VIRGINIA

Vertical Scale: N/A
Horizontal Scale: 1"= 10'
Commission Number: 2120
Sheet No.:

11