


13162-ph2-comp1-revise-04-pp01.plt

w:\drawings\2013\13162\eng\phase2\13162-ph2-comp1-revise.dwg

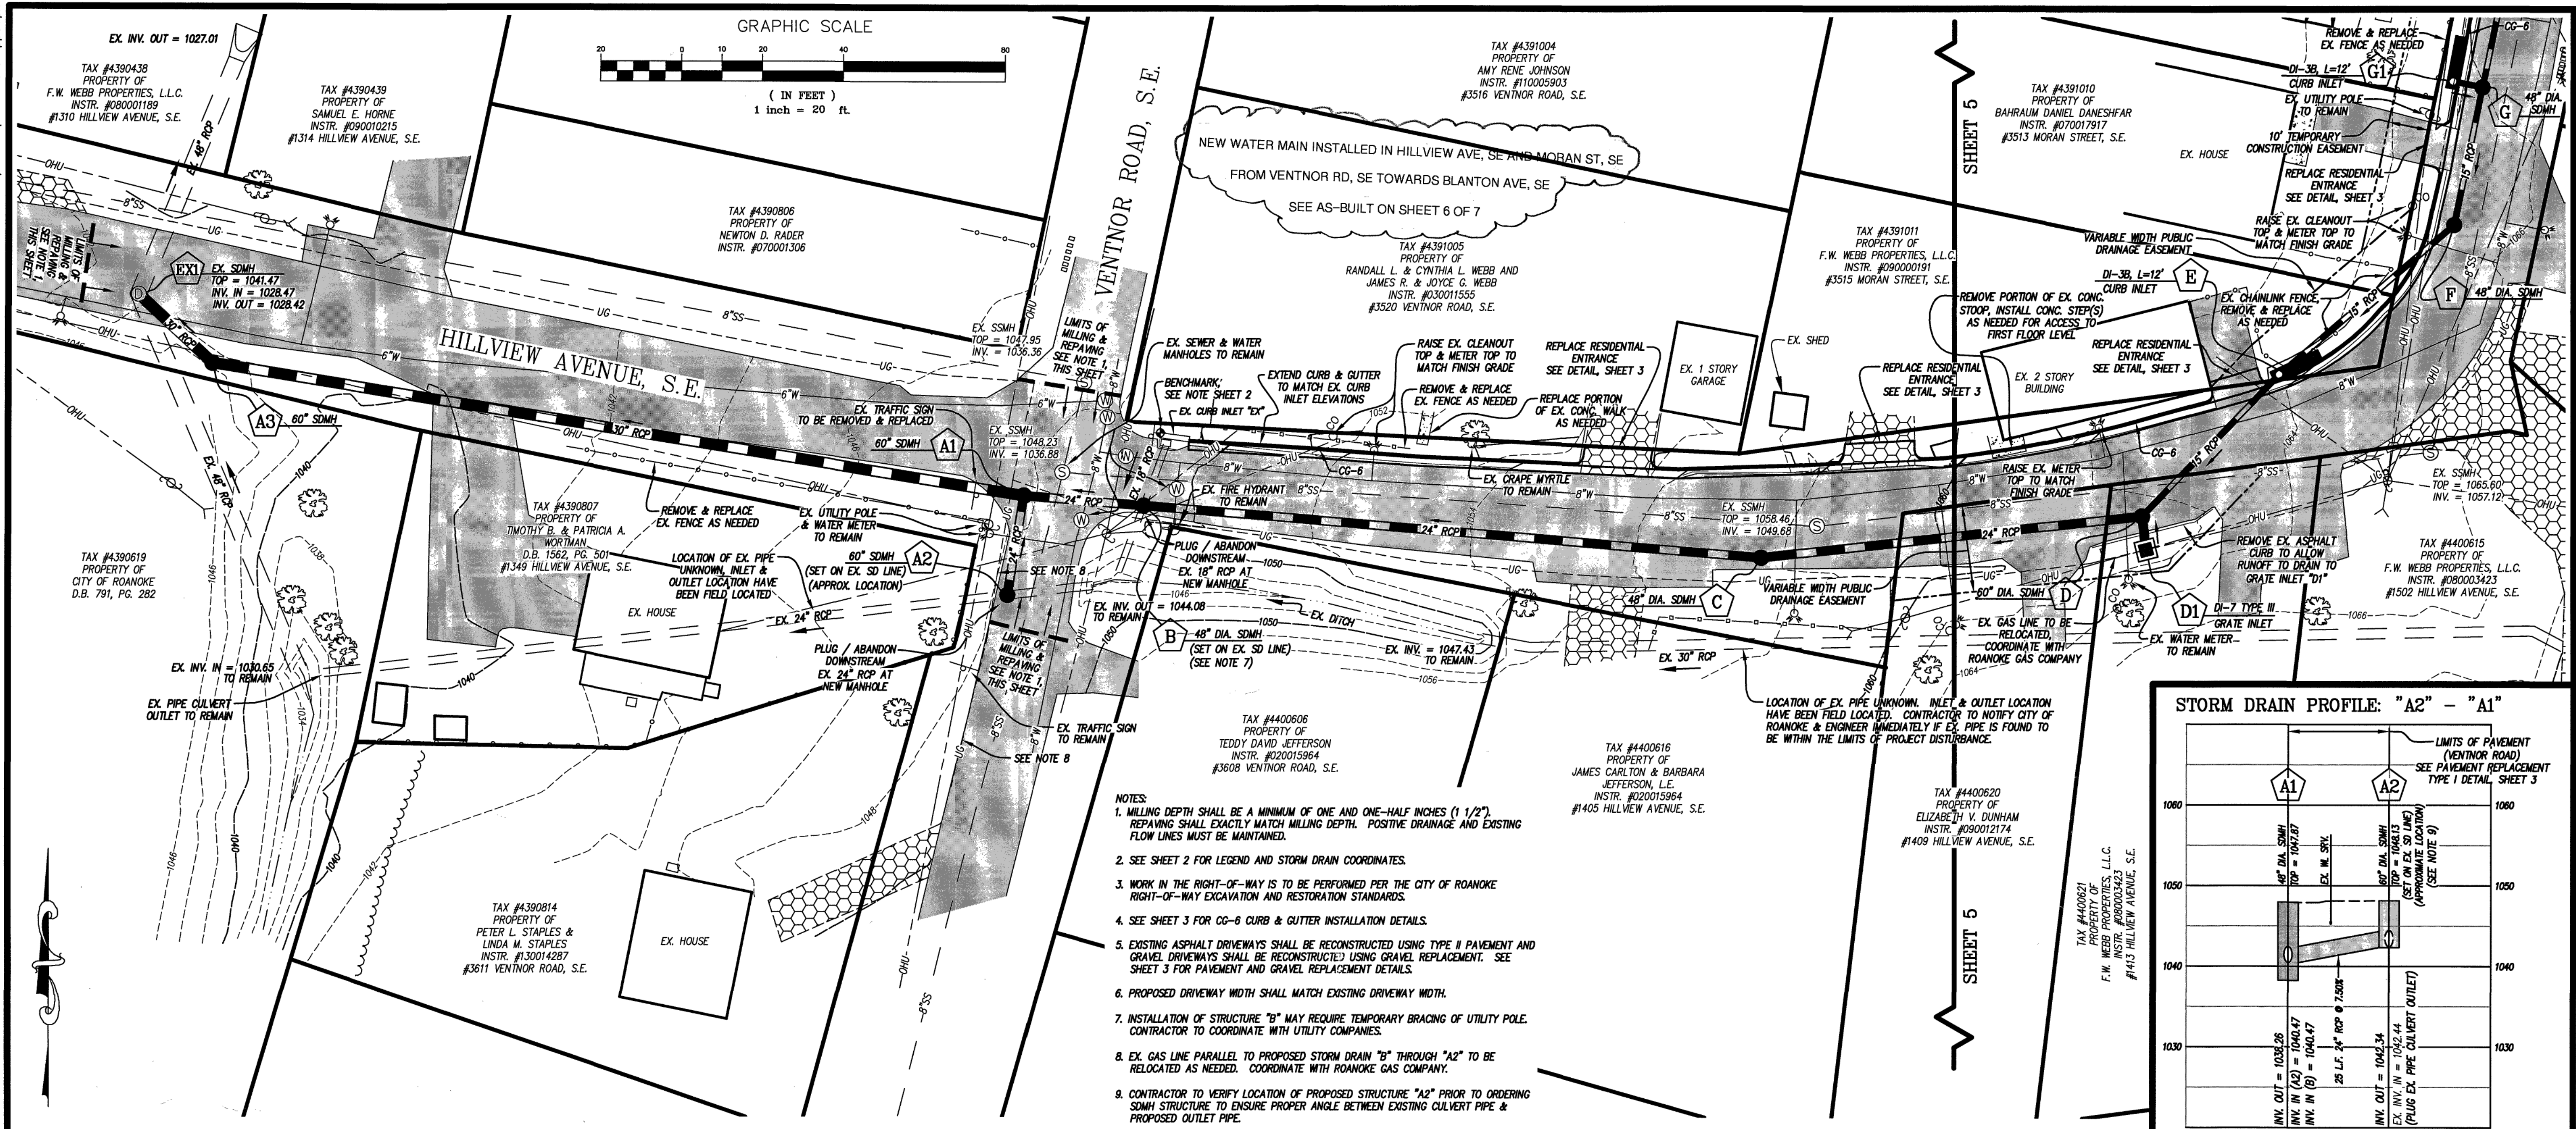

LUMSDEN ASSOCIATES, P.C.
ENGINEERS-SURVEYORS-PLANNERS
ROANOKE, VIRGINIA

4664 BRAMBLETON AVENUE
P.O. BOX 20669
ROANOKE, VIRGINIA 24018
PHONE: (540) 774-4411
FAX: (540) 773-9445
E-MAIL: MAIL@LUMSDENPC.COM

COMMONWEALTH OF VIRGINIA
Andrew P. Lumsden
Lic. No. 0502216
4/1/14
PROFESSIONAL ENGINEER

STORM DRAIN
PLAN AND PROFILE
(HILLVIEW AVENUE)

STORMWATER DRAINAGE IMPROVEMENTS
FOR
PHASE 2
MORAN STREET / BLANTON AVENUE, S.E.
PREPARED FOR
THE CITY OF ROANOKE, VIRGINIA

REVISIONS	
NO.	DESCRIPTION
1	
2	
3	
4	
5	

DATE: April 1, 2014

SCALE:
1" = 20' (H); 1" = 10' (V)

COMMISSION NO.: 13-162

SHEET 4 OF 7