


PROJECT LOCATION MAP

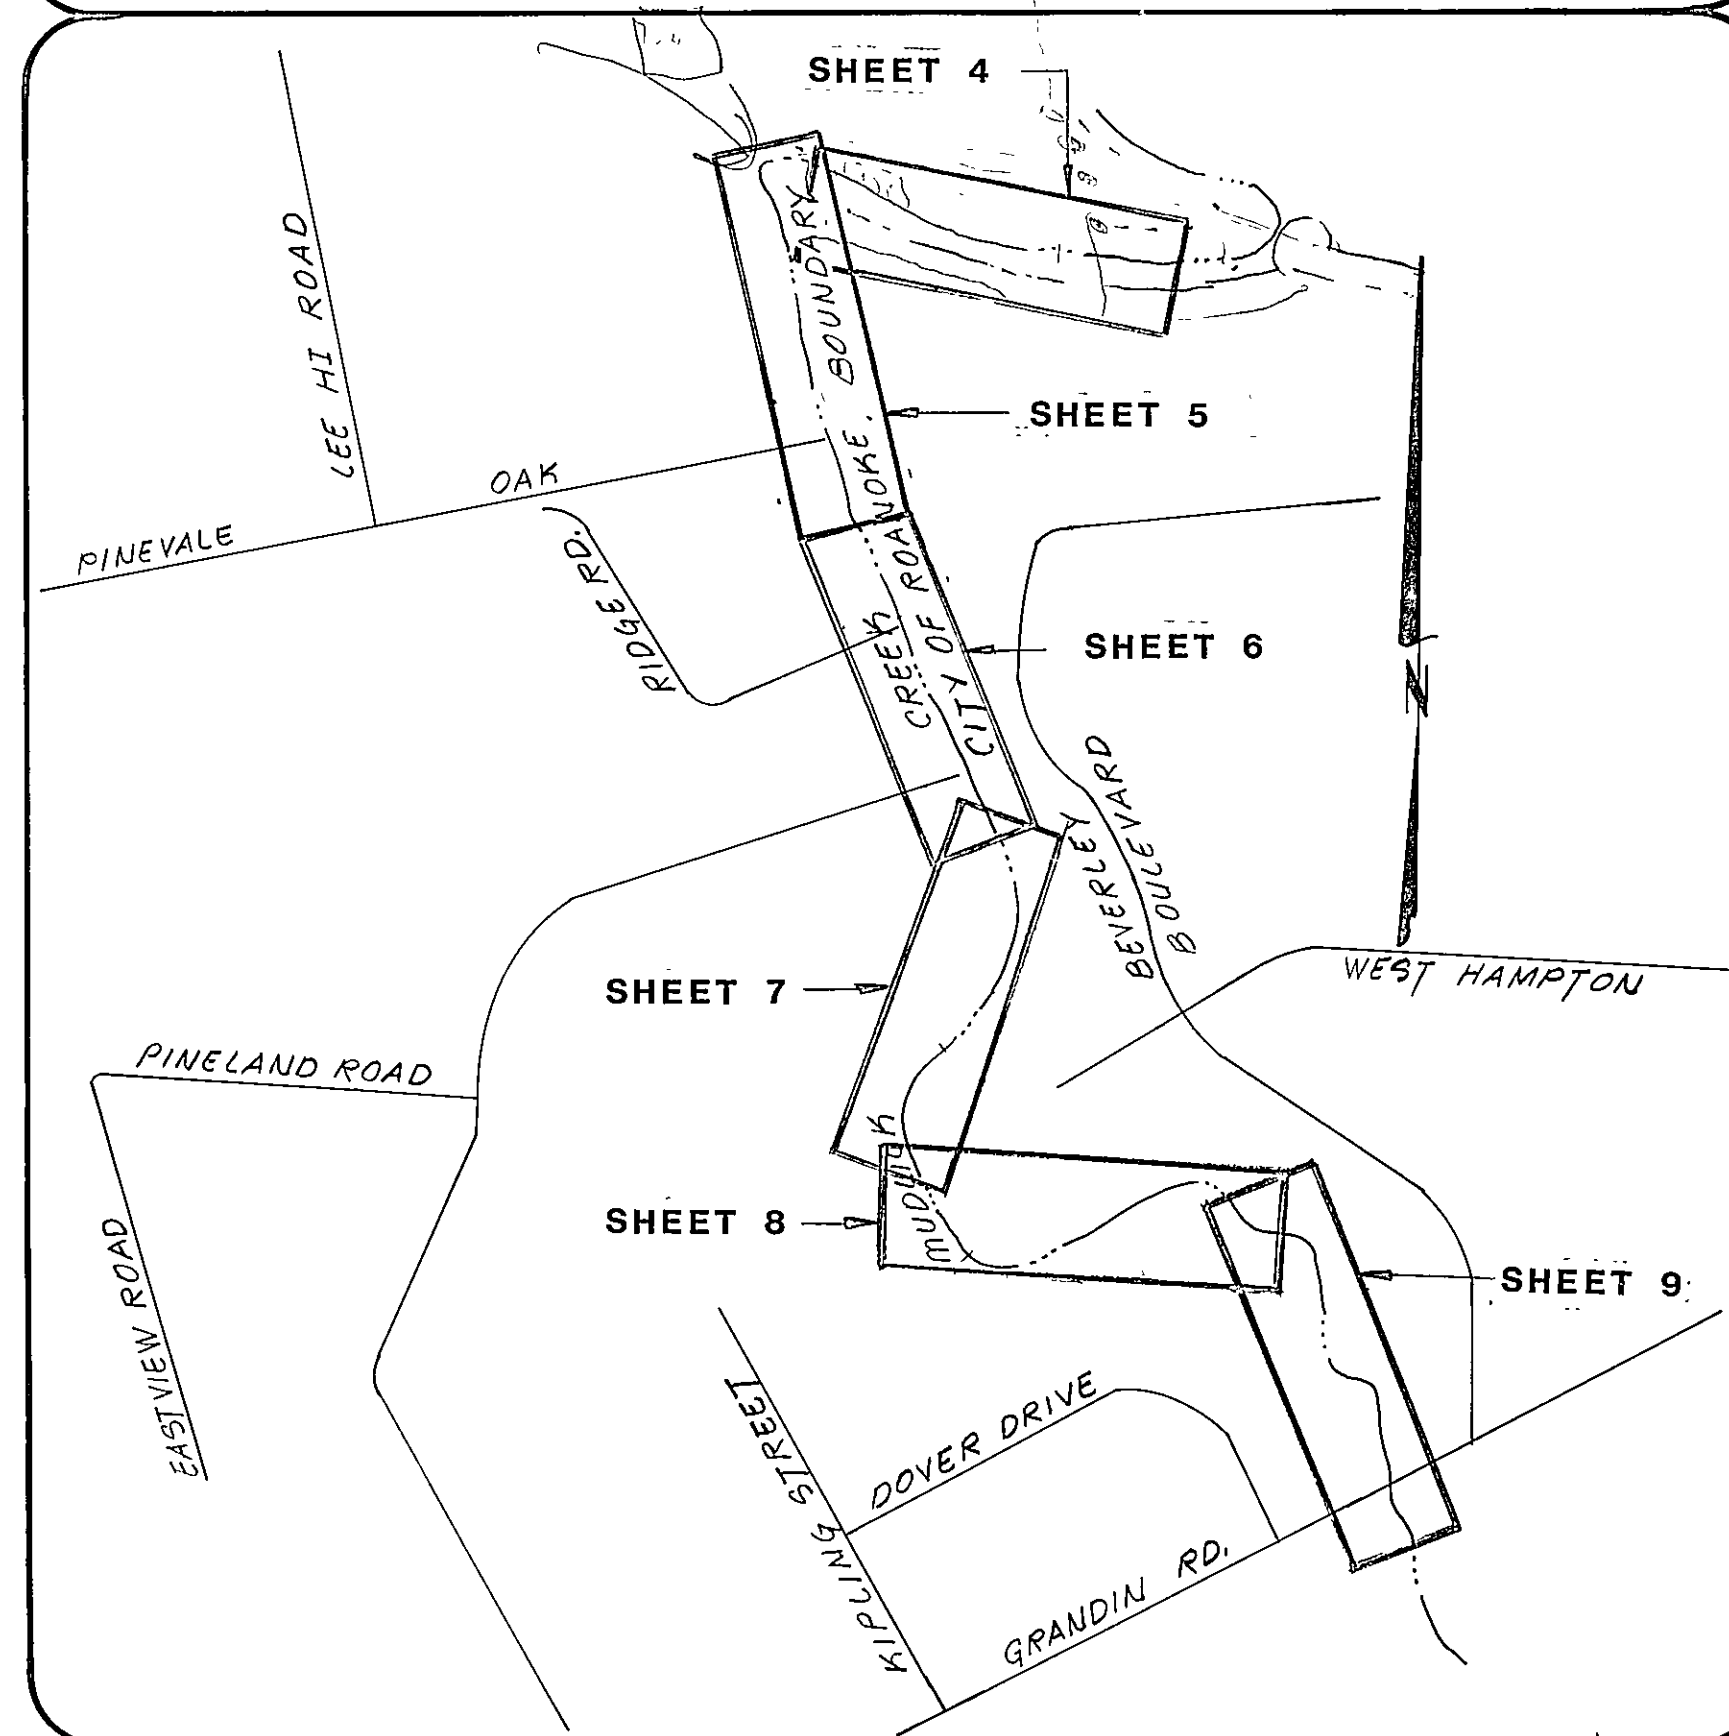

OFFICE OF CITY ENGINEER
ROOM 350
MUNICIPAL BUILDING
215 CHURCH AVENUE, S.W.
ROANOKE, VIRGINIA 24011


INDEX OF SHEETS

SHEET 1 TITLE SHEET
SHEET 2 QUANTITY SHEET
SHEET 3 ABBREVIATIONS, LEGEND AND
GENERAL NOTES
SHEET 4 PLAN AND PROFILE
SHEET 5 PLAN AND PROFILE
SHEET 6 PLAN AND PROFILE
SHEET 7 PLAN AND PROFILE
SHEET 8 PLAN AND PROFILE
SHEET 9 PLAN AND PROFILE

CONSULTING ENGINEERS

**MATTERN AND CRAIG
CONSULTING ENGINEERS
ROANOKE, VIRGINIA**

COMMISSION NUMBER: **571**

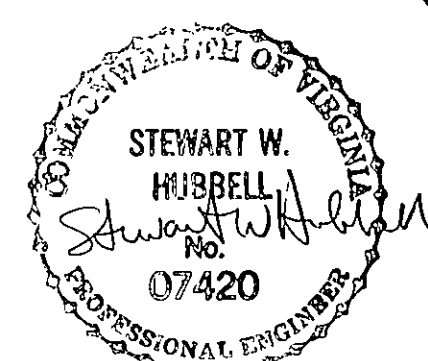

PROJECT NAME

**MUDLICK CREEK SANITARY SEWER
PHASE II**

PROJECT NUMBER: **5937-II**

REVISION	BY	DESCRIPTION:	DATE
REVISION	BY	DESCRIPTION:	DATE
REVISION	BY	DESCRIPTION:	DATE
REVISION	BY	DESCRIPTION:	DATE

APPROVED FOR CONSTRUCTION

<i>Stewart W. Hubbell</i> ROANOKE CITY ENGINEER	<i>6/1/88</i> DATE
DIRECTOR OF PUBLIC WORKS	DATE
DIRECTOR OF UTILITIES AND OPERATIONS	DATE
	DATE
	DATE

ADVERTISED DATE: **JUNE 5, 1988**

SET NUMBER: **11**

SHEET NUMBER: **1** OF **9**