
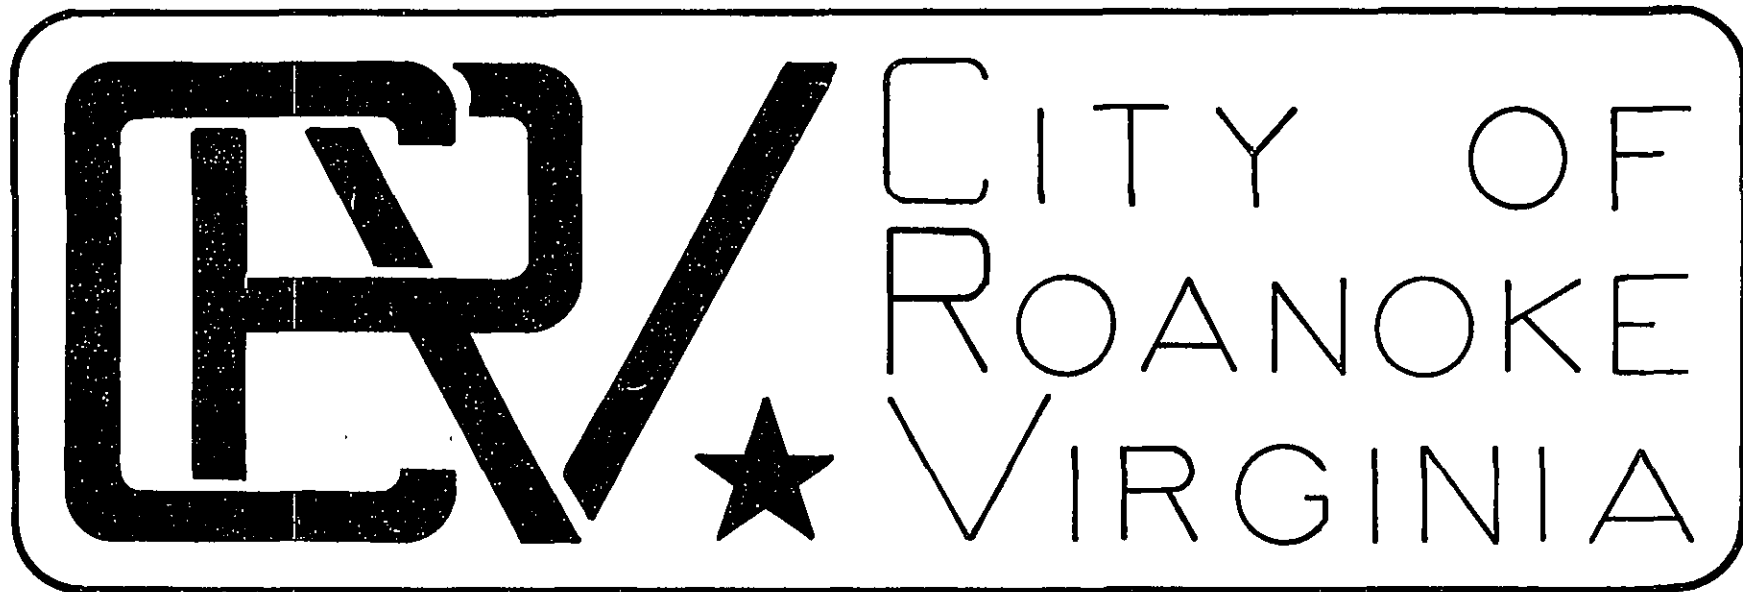


PROJECT LOCATION MAP

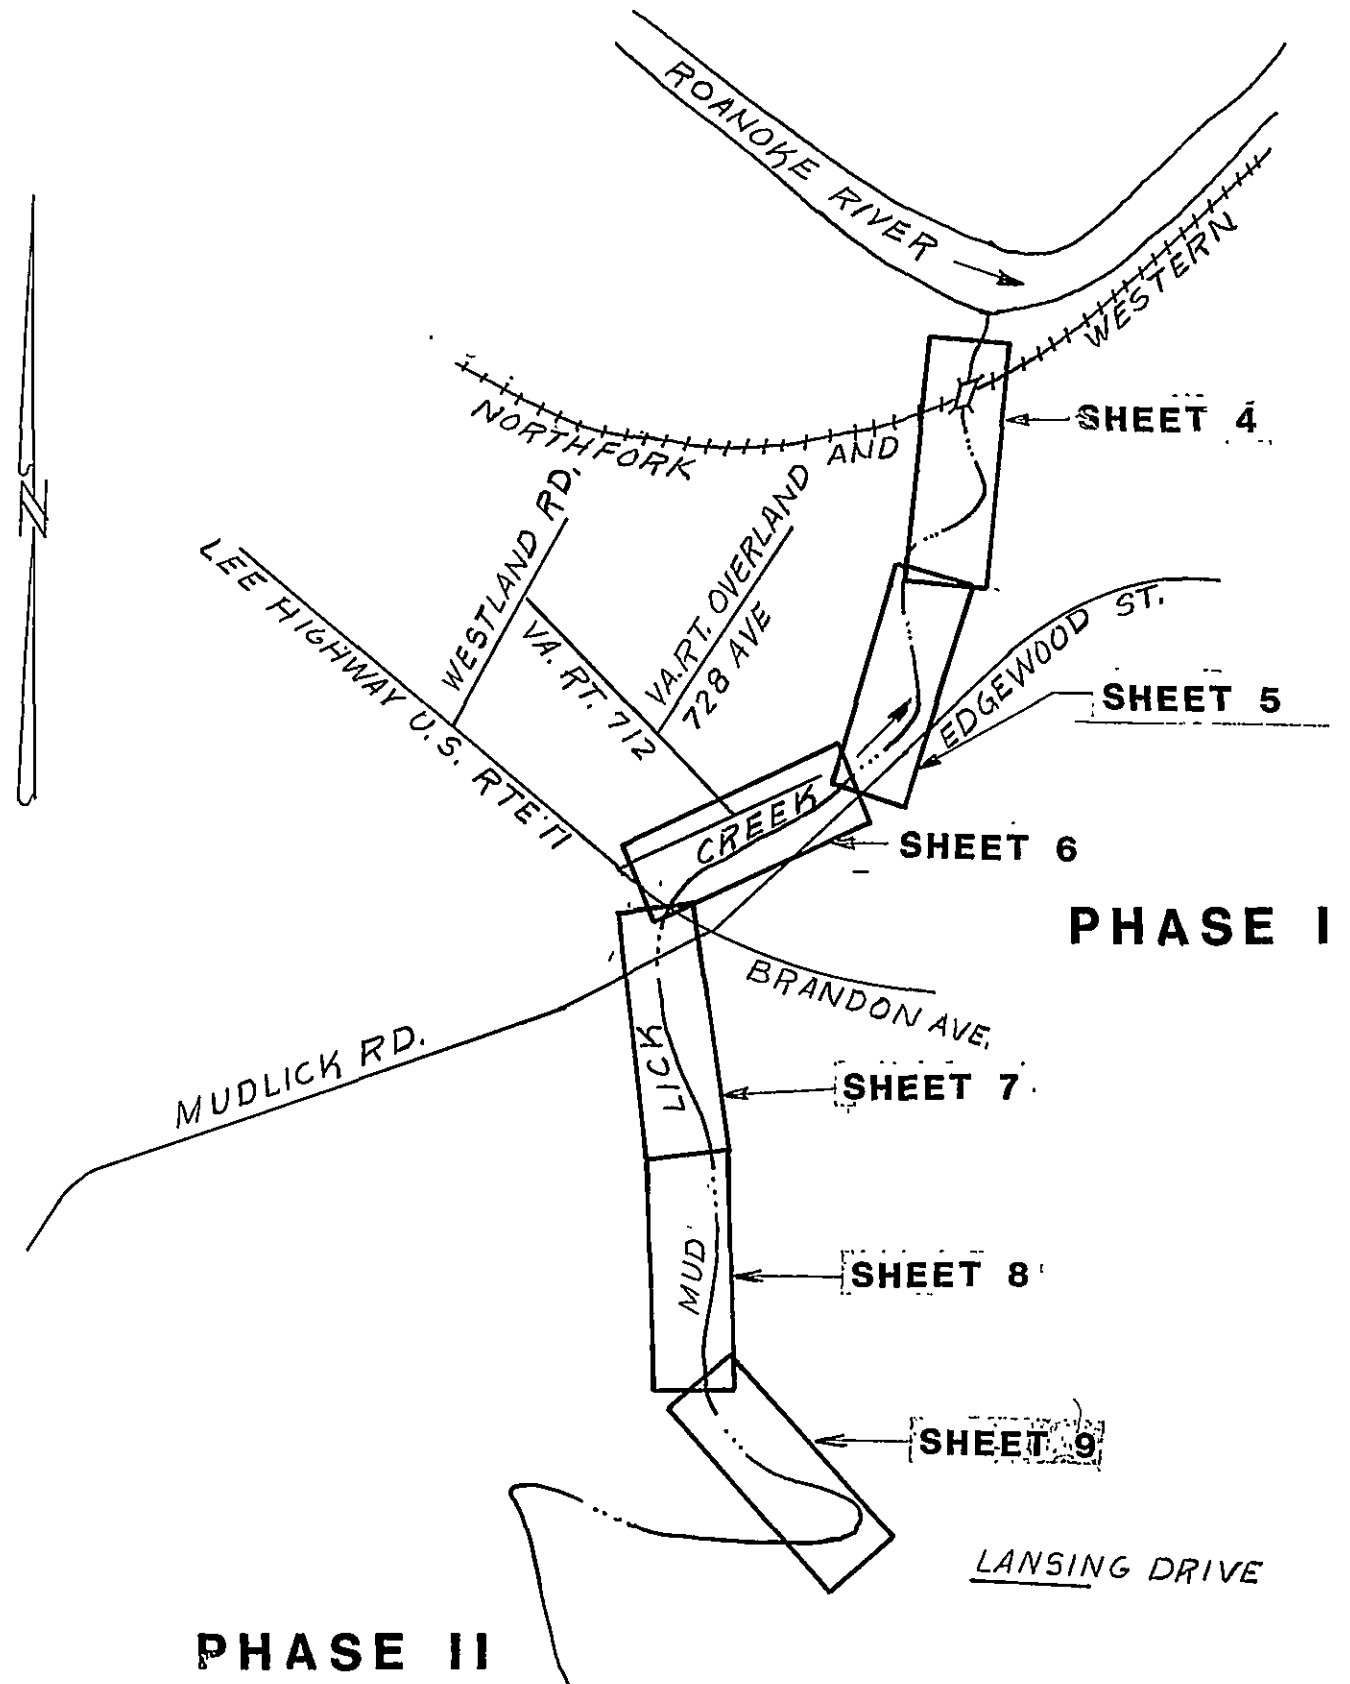

OFFICE OF CITY ENGINEER
ROOM 350
MUNICIPAL BUILDING
215 CHURCH AVENUE, S.W.
ROANOKE, VIRGINIA 24011


INDEX OF SHEETS

- SHEET 1 TITLE SHEET
- SHEET 2 QUANTITY SHEET
- SHEET 3 ABBREVIATIONS, LEGEND AND GENERAL NOTES
- SHEET 4 PLAN AND PROFILE
- SHEET 5 PLAN AND PROFILE
- SHEET 6 PLAN AND PROFILE
- SHEET 7 PLAN AND PROFILE
- SHEET 8 PLAN AND PROFILE
- SHEET 9 PLAN AND PROFILE
- SHEET 10 PROFILES AND DETAILS

CONSULTING ENGINEERS

MATTERN AND CRAIG
CONSULTING ENGINEERS
ROANOKE , VIRGINIA

COMMISSION NUMBER: **473**

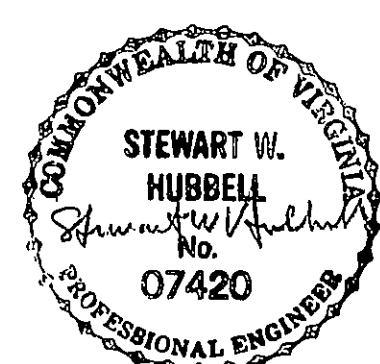

PROJECT NAME

MUDLICK CREEK SANITARY SEWER
PHASE I

PROJECT NUMBER: **5937**

REVISION	BY	DESCRIPTION:	DATE
REVISION	BY	DESCRIPTION:	DATE
REVISION	BY	DESCRIPTION:	DATE
REVISION	BY	DESCRIPTION:	DATE

RECORD DRAWING

6/15/88
DATE

APPROVED FOR CONSTRUCTION

Charles M. Huffine
ROANOKE CITY ENGINEER

2-9-87
DATE

William D. Clark
DIRECTOR OF PUBLIC WORKS

2-9-87
DATE

Pat B. L.
DIRECTOR OF UTILITIES AND OPERATIONS

2/9/87
DATE

DATE

DATE

ADVERTISED DATE: **FEB 22, 1987**

SET NUMBER:

SHEET NUMBER: **1** OF **10**