
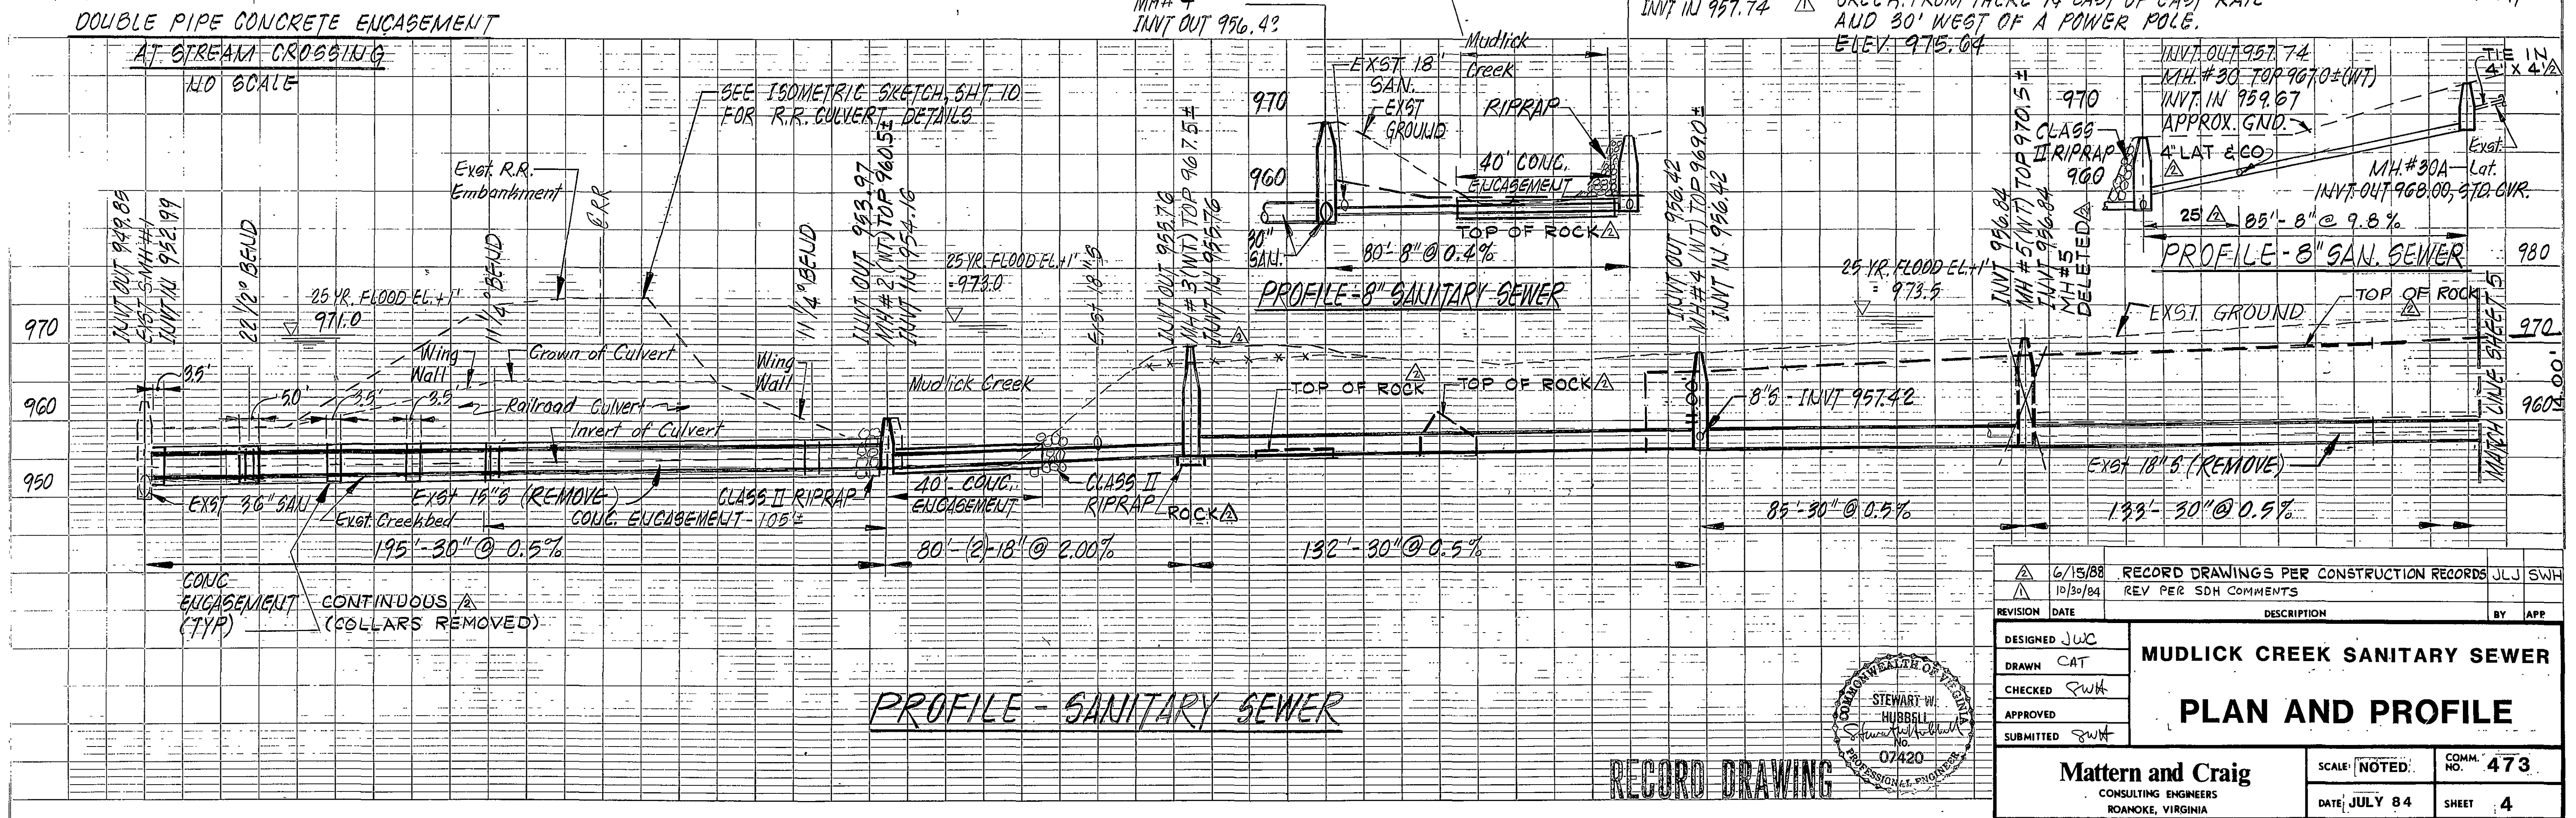


DATE	10/30/84
BY	JWC
CHECKED	SWH
APPROVED	SWH
SUBMITTED	SWH

DATE	10/30/84
BY	JWC
CHECKED	SWH
APPROVED	SWH
SUBMITTED	SWH

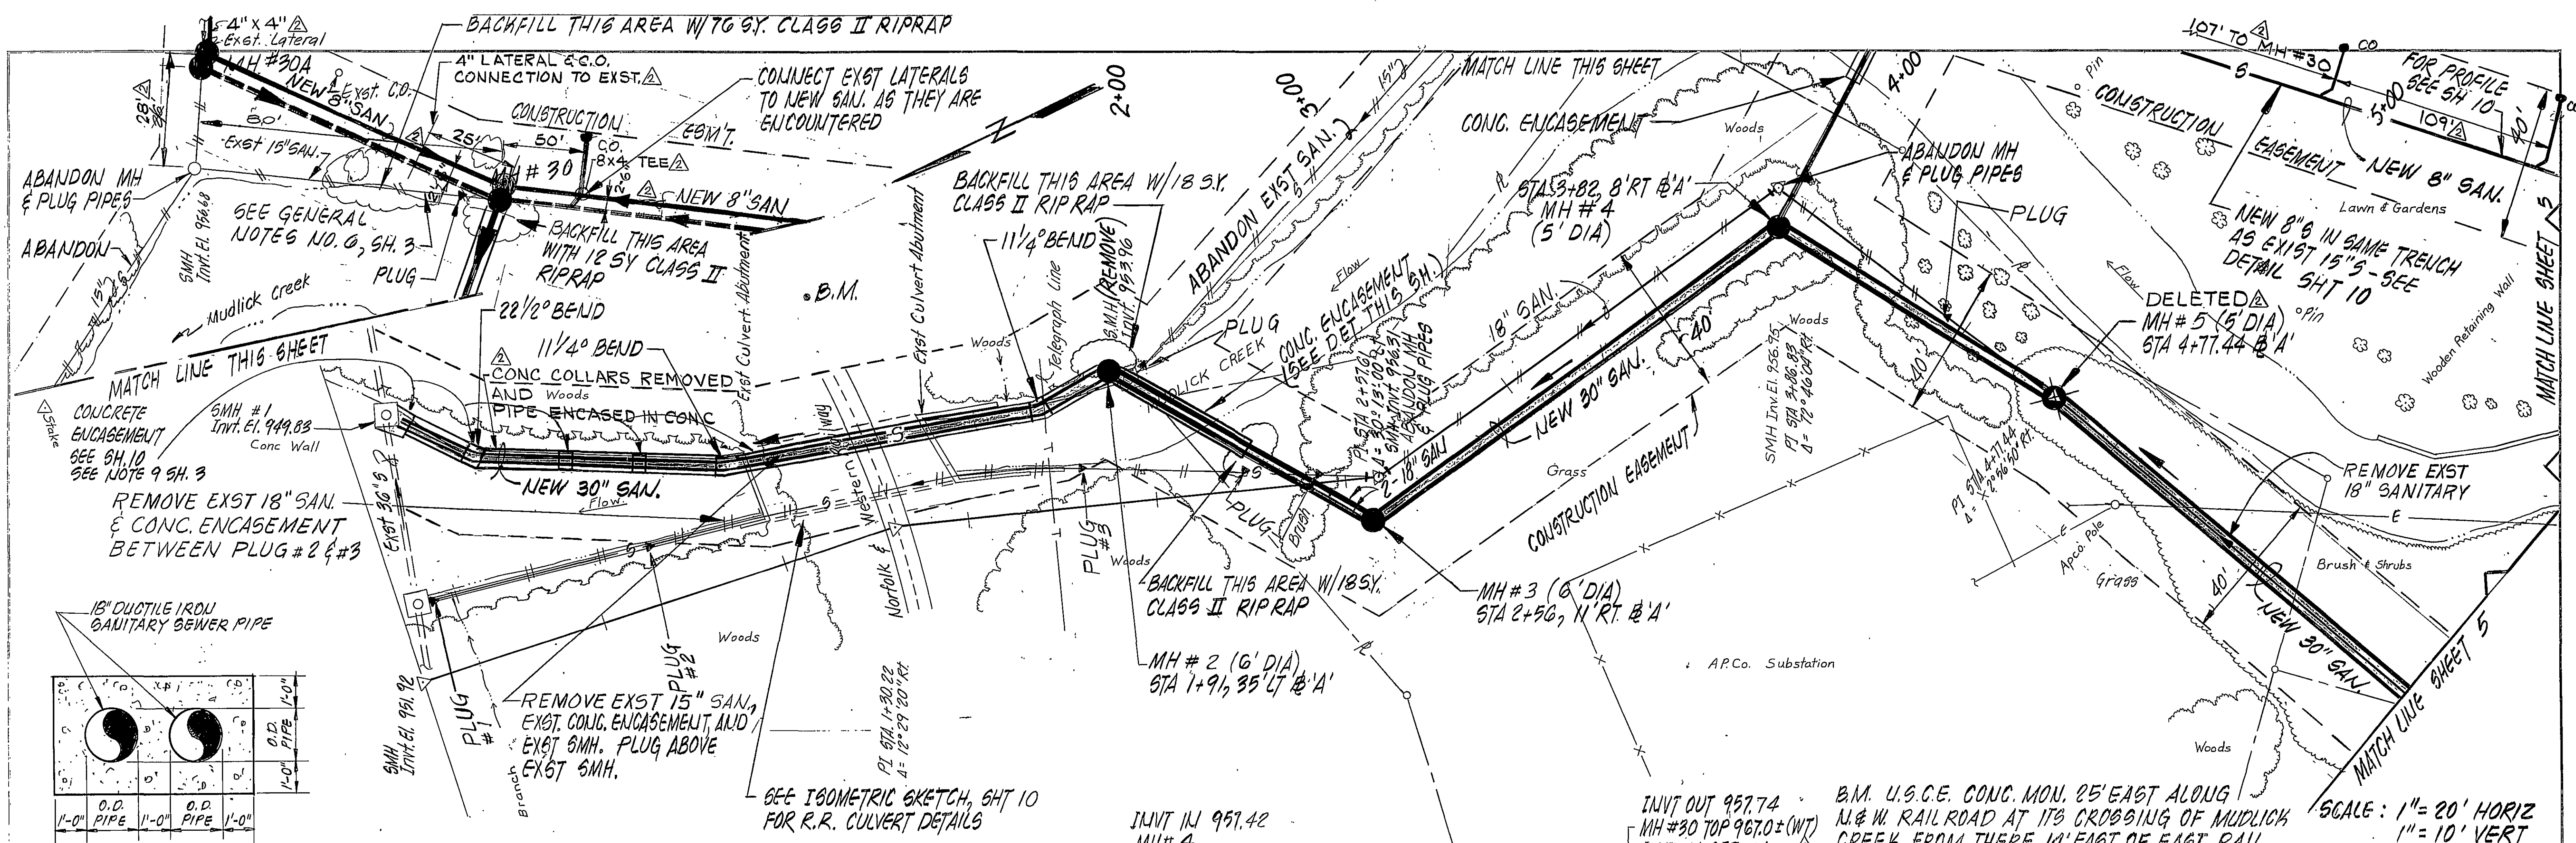

REVISION	DATE	DESCRIPTION	BY	APP
1	6/15/88	RECORD DRAWINGS PER CONSTRUCTION RECORDS	JUL	SWH
2	10/30/84	REV PER SDH COMMENTS		
DESIGNED JWC DRAWN CAT CHECKED SWH APPROVED SWH SUBMITTED SWH MUDLICK CREEK SANITARY SEWER PLAN AND PROFILE				
Mattern and Craig CONSULTING ENGINEERS ROANOKE, VIRGINIA			SCALE: NOTED DATE: JULY 84	COMM. NO. 473 SHEET 4