


PROJECT LOCATION MAP

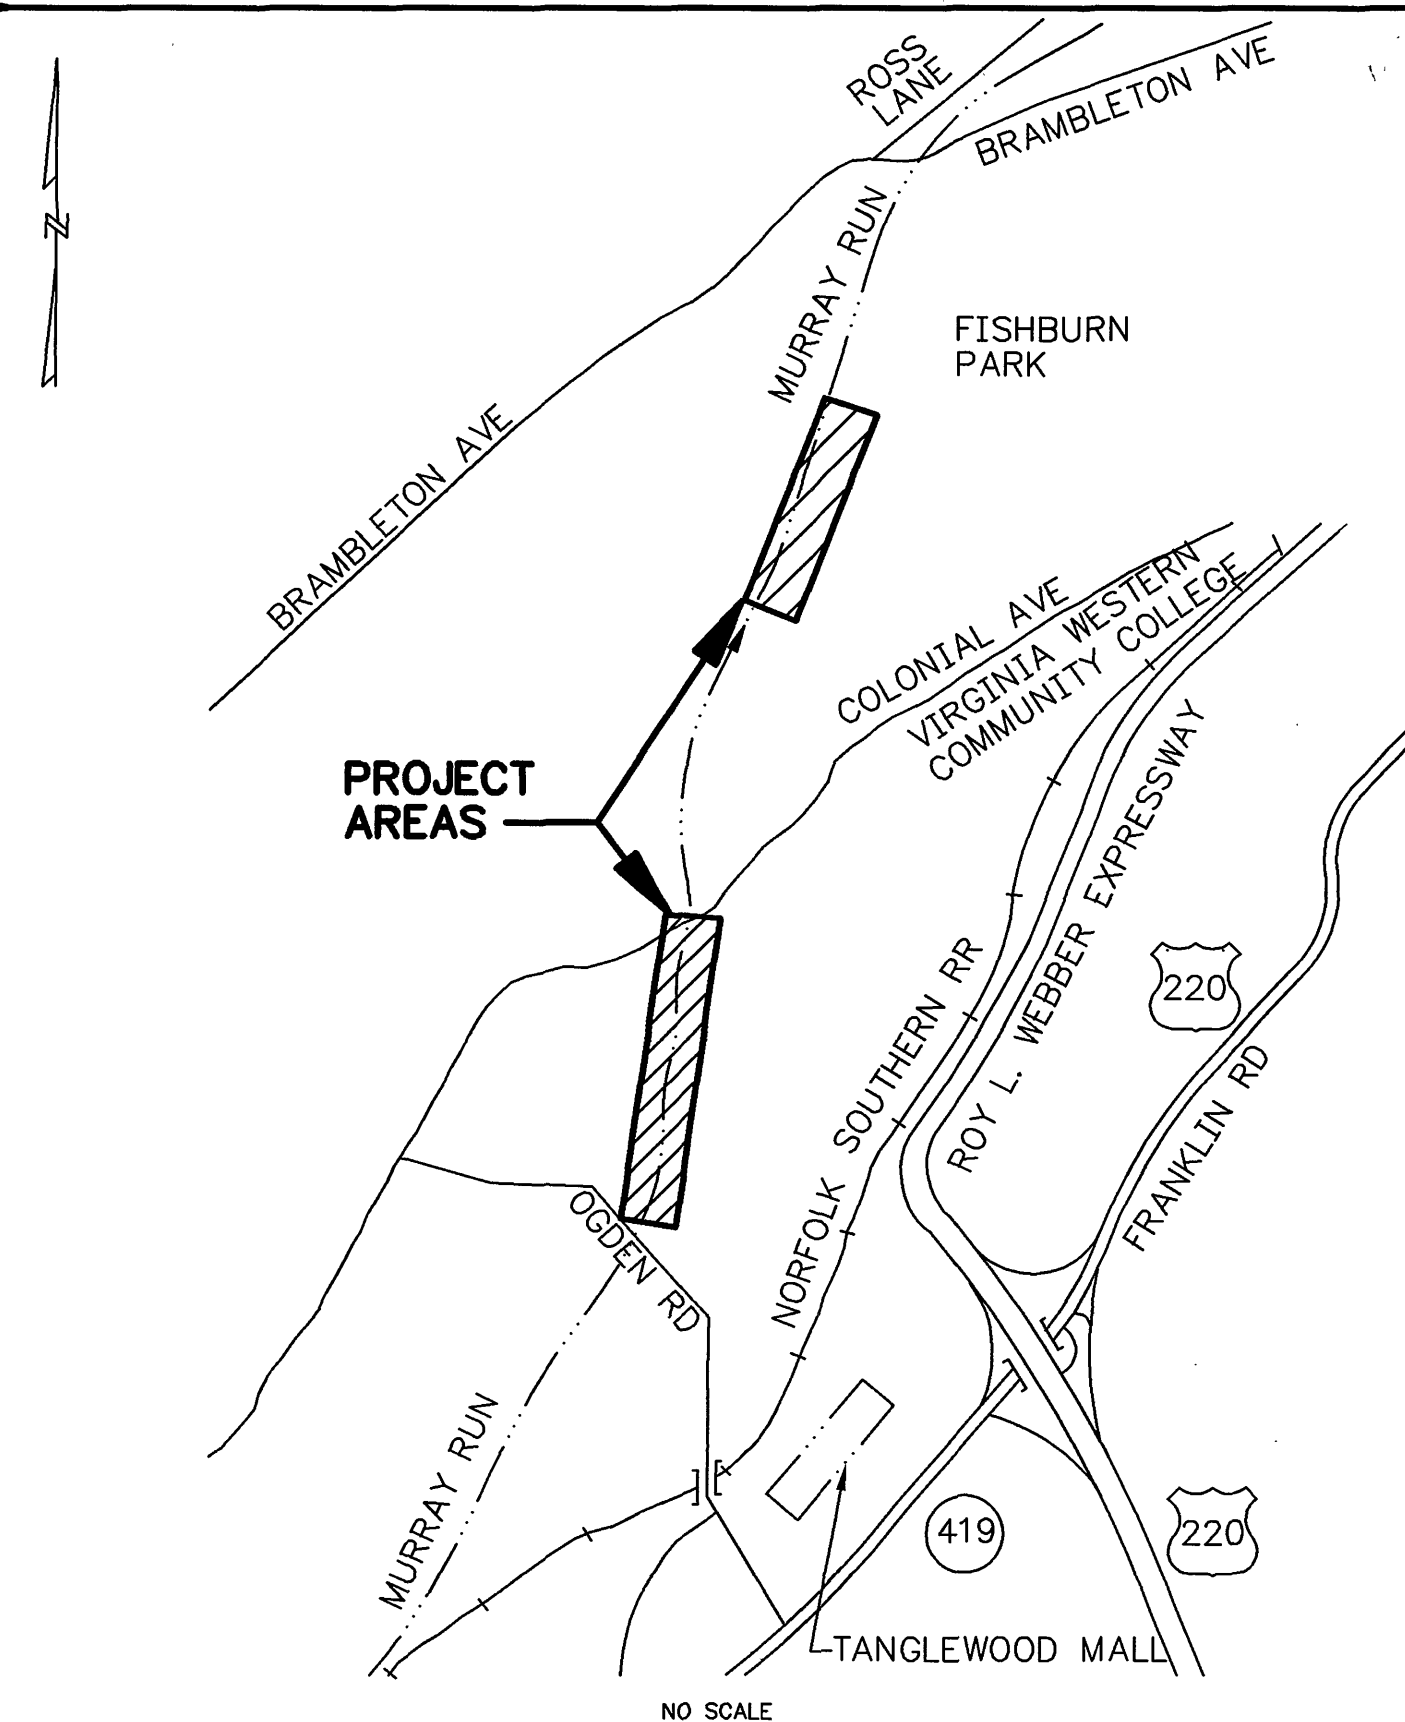

OFFICE OF CITY ENGINEER
ROOM 350
MUNICIPAL BUILDING
215 CHURCH AVENUE, S.W.
ROANOKE, VIRGINIA 24011

RECORD DRAWINGS PREPARED
BASED ON INFORMATION PROVIDED BY
AARON J. CONNER GENERAL CONTRACTOR, INC.,
NOT FIELD VERIFIED BY HSMM, INC.

INDEX OF SHEETS


1. TITLE
2. ABBREVIATIONS, NOTES, LEGEND & SUMMARY OF QUANTITIES
3. PLAN AND PROFILE
4. PLAN AND PROFILE
5. PLAN AND PROFILE
6. MANHOLE REPLACEMENT

CONSULTING ENGINEERS

HAYES, SEAY, MATTERN AND MATTERN
ARCHITECTS - ENGINEERS - PLANNERS

1315 FRANKLIN ROAD
ROANOKE, VIRGINIA

COMMISSION NUMBER: 7122E

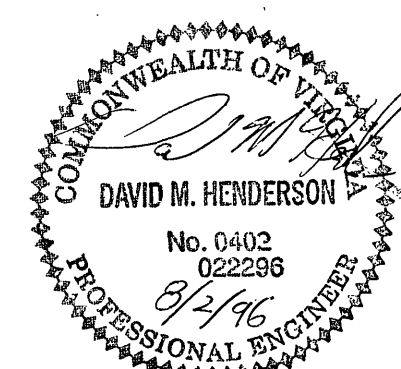

PROJECT NAME

SEWER REPLACEMENT MR-1
ROANOKE, VIRGINIA

PROJECT NUMBER: 6307

REVISION BY	DESCRIPTION:	DATE
REVISION BY	DESCRIPTION:	DATE
REVISION BY	DESCRIPTION:	DATE
REVISION BY	DESCRIPTION:	DATE

APPROVED FOR CONSTRUCTION

ROANOKE CITY ENGINEER

DATE

DIRECTOR OF PUBLIC WORKS

DATE

DIRECTOR OF UTILITIES AND OPERATIONS

DATE

DATE

DATE

ADVERTISED DATE:

SET NUMBER:

SHEET NUMBER: 1 OF 6