


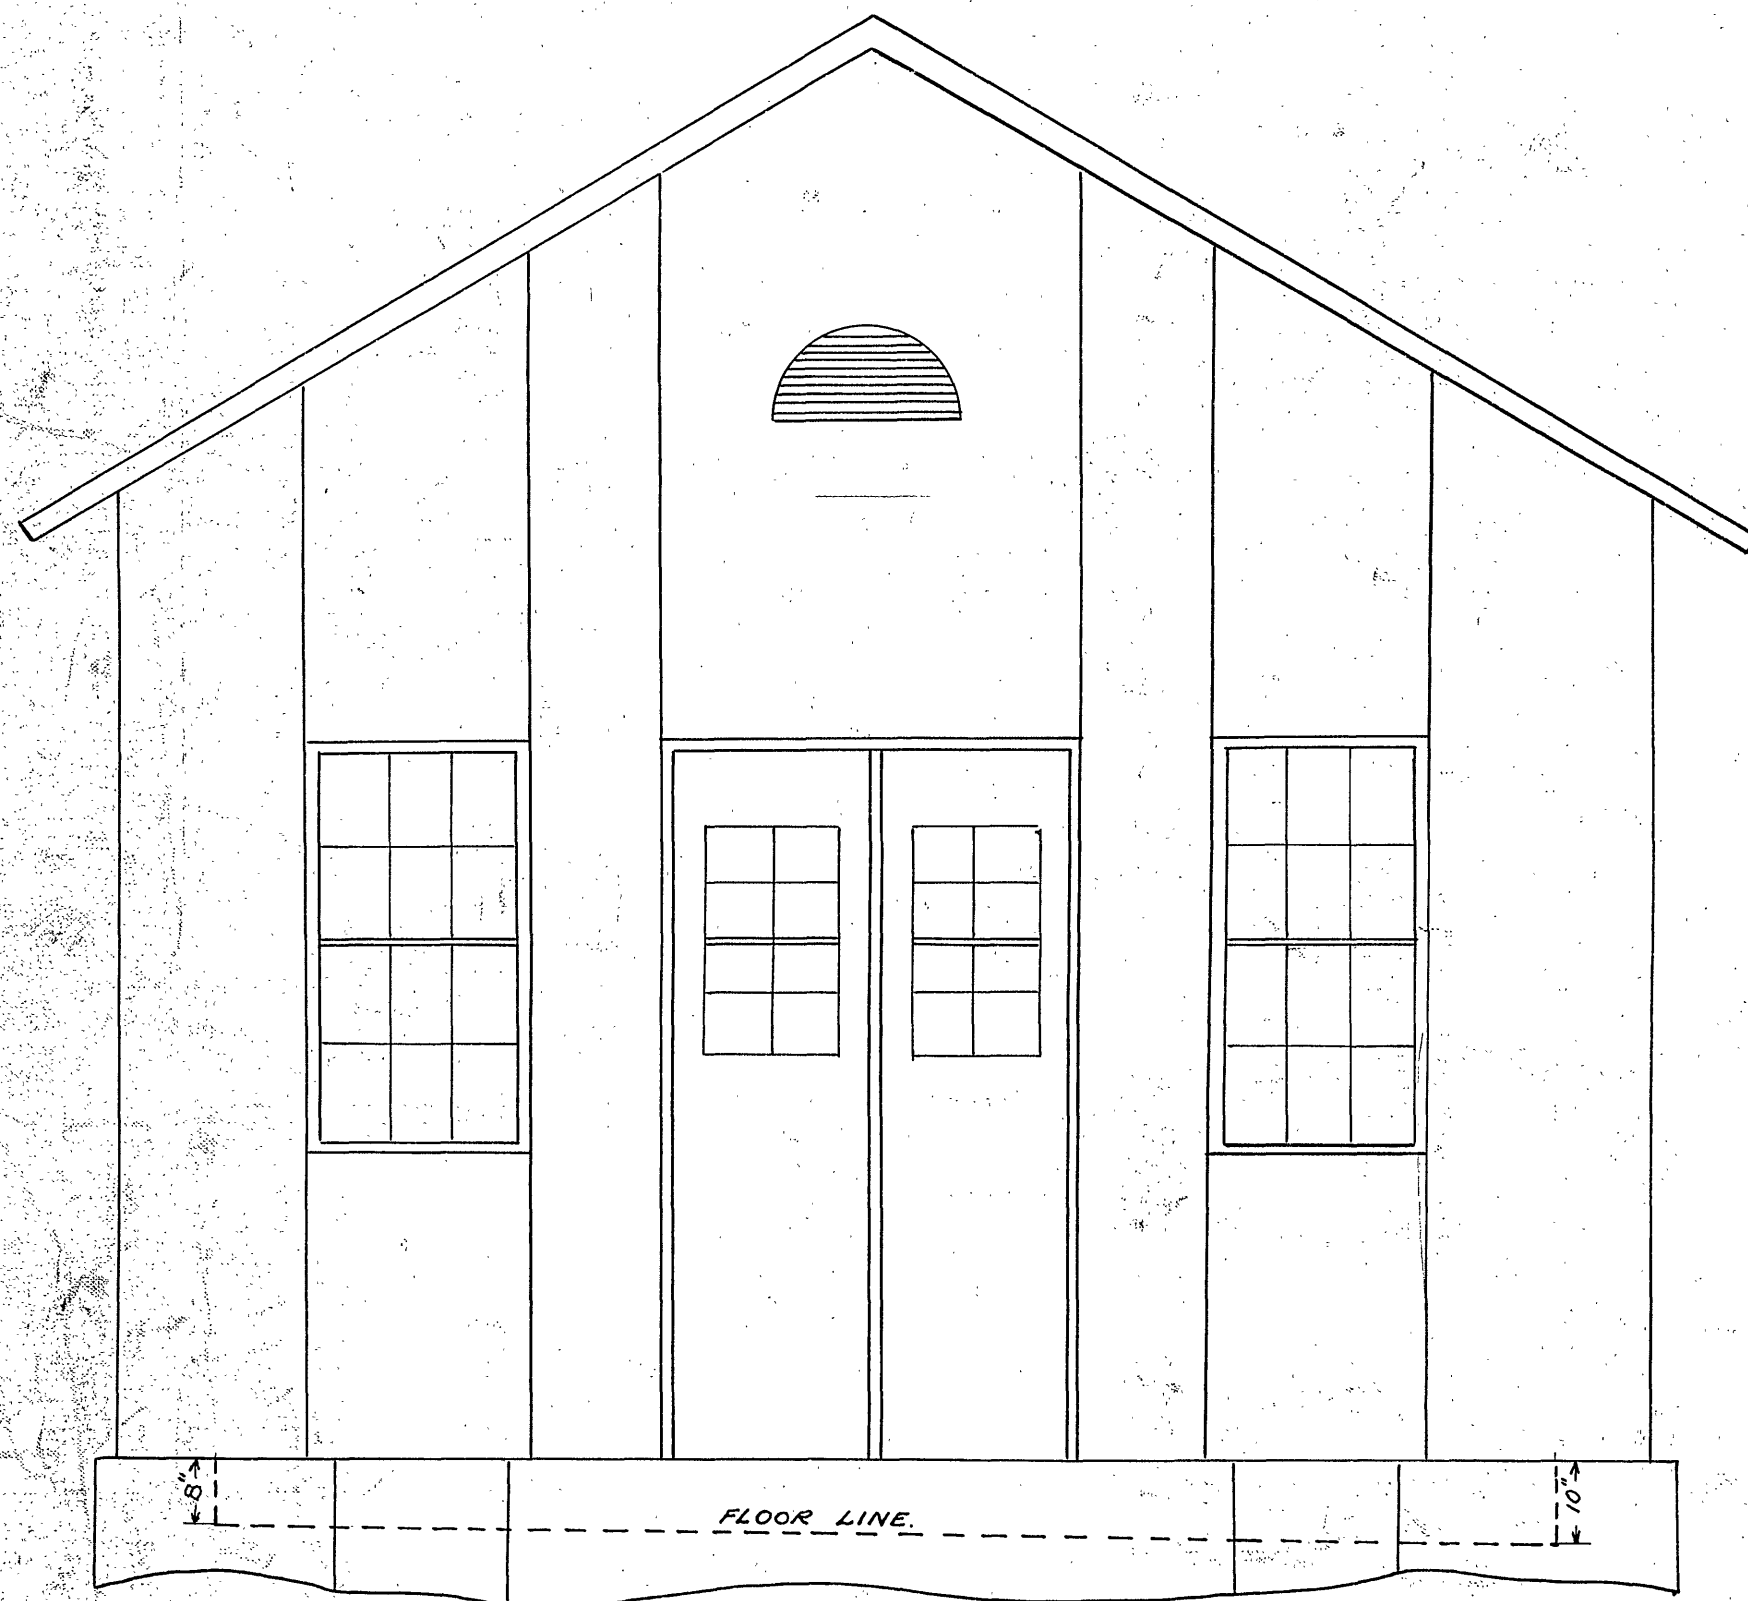

EAST ELEVATION PLAN
PUMPING STATION
MUSE SPRING
ROANOKE WATER WORKS CO.
ROANOKE, VIRGINIA,

SCALE 1" = 2 FT. DATE AUG. 7. 17
DRAWN BY M ISSUED [REDACTED]
TRACED BY