


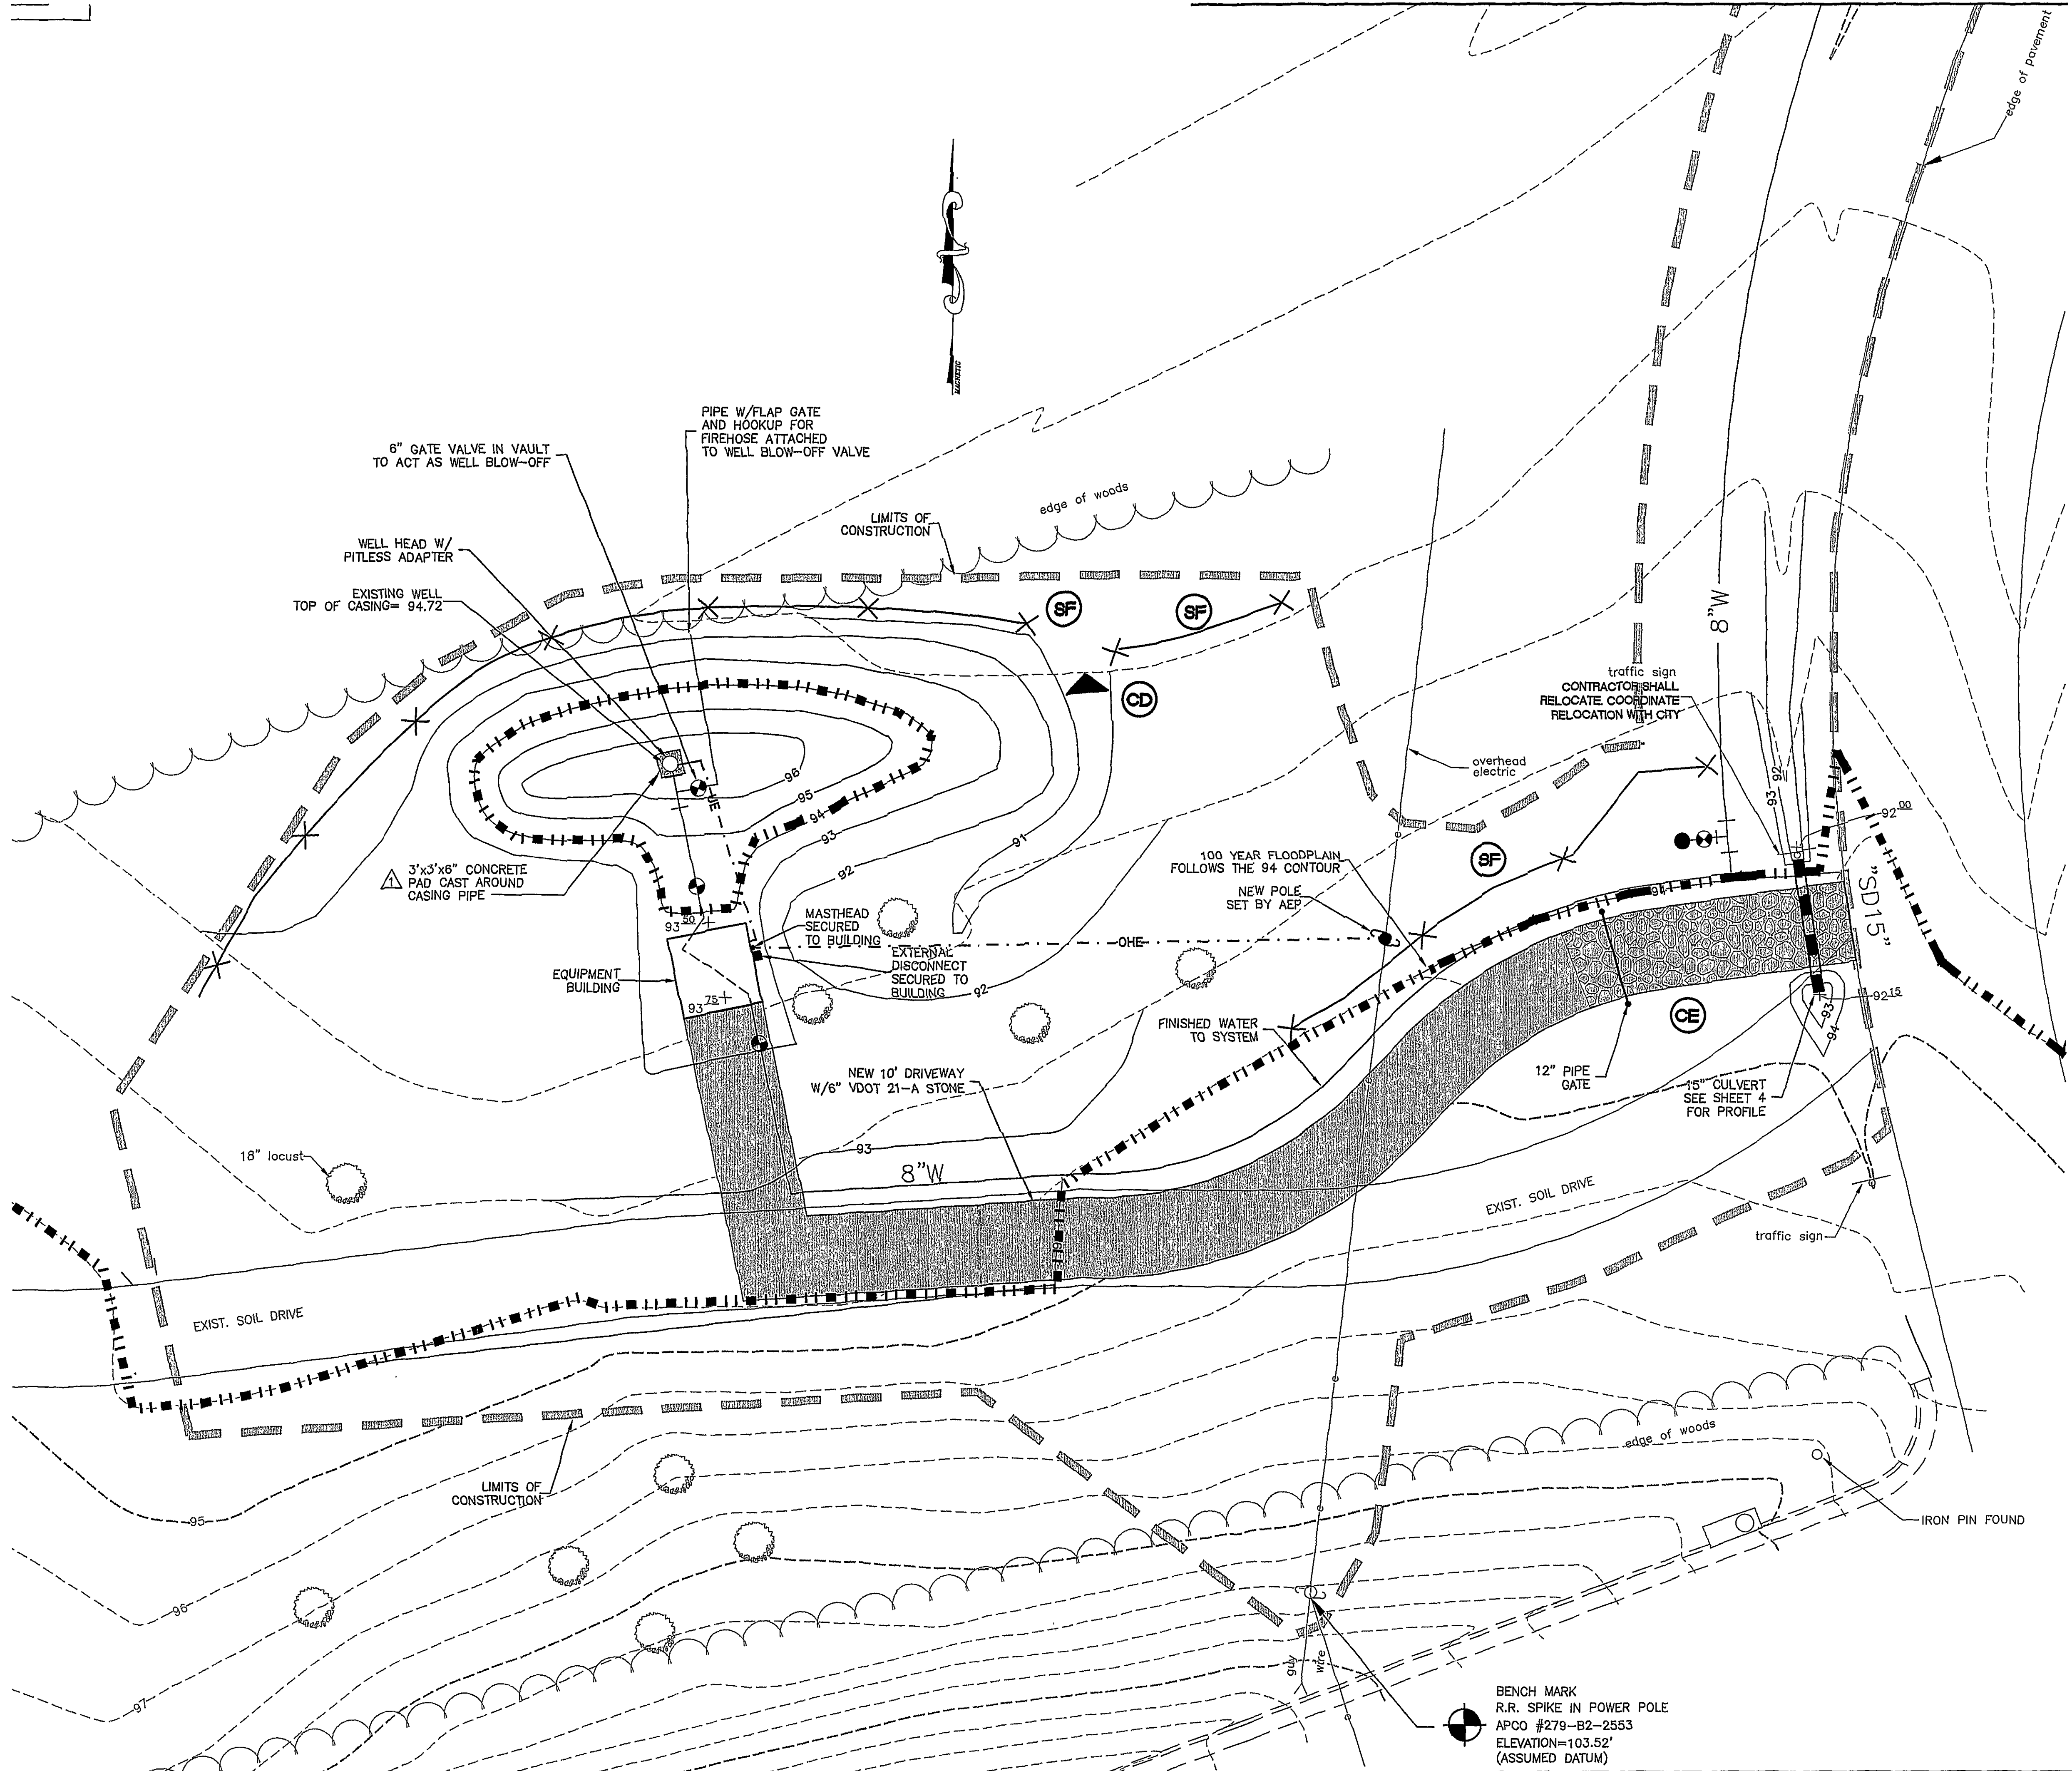

COMMONWEALTH OF VIRGINIA
4/18/02
STEWART W. HUBBELL
Professional Engineer
07420

Revisions	Date	Comments
1	4/16/02	REVISED PER VDOT COMMENTS

Issue Date: APRIL, 2001
Drawn By: HAY
Designed By: HAY
Checked By: SWH
Date:

Mattem & Craig
CONSULTING ENGINEERS • SURVEYORS
701 FIRST STREET, S.W.
ROANOKE, VIRGINIA 24016
(540) 345-9342
FAX (540) 345-7691

MUSE WELL FACILITY
TEMPORARY
SITE PLAN
CITY OF ROANOKE, VIRGINIA

Vertical Scale: N/A
Horizontal Scale: 1" = 10'
Commission Number: 1869
Sheet No.: