


S:\2004 Projects\S04064-01 New Hope Christian Church\Site Plan (4) 2nd Submittal.dwg, C03 - OVERALL PLAN, 8/16/2005 3:40:57 PM

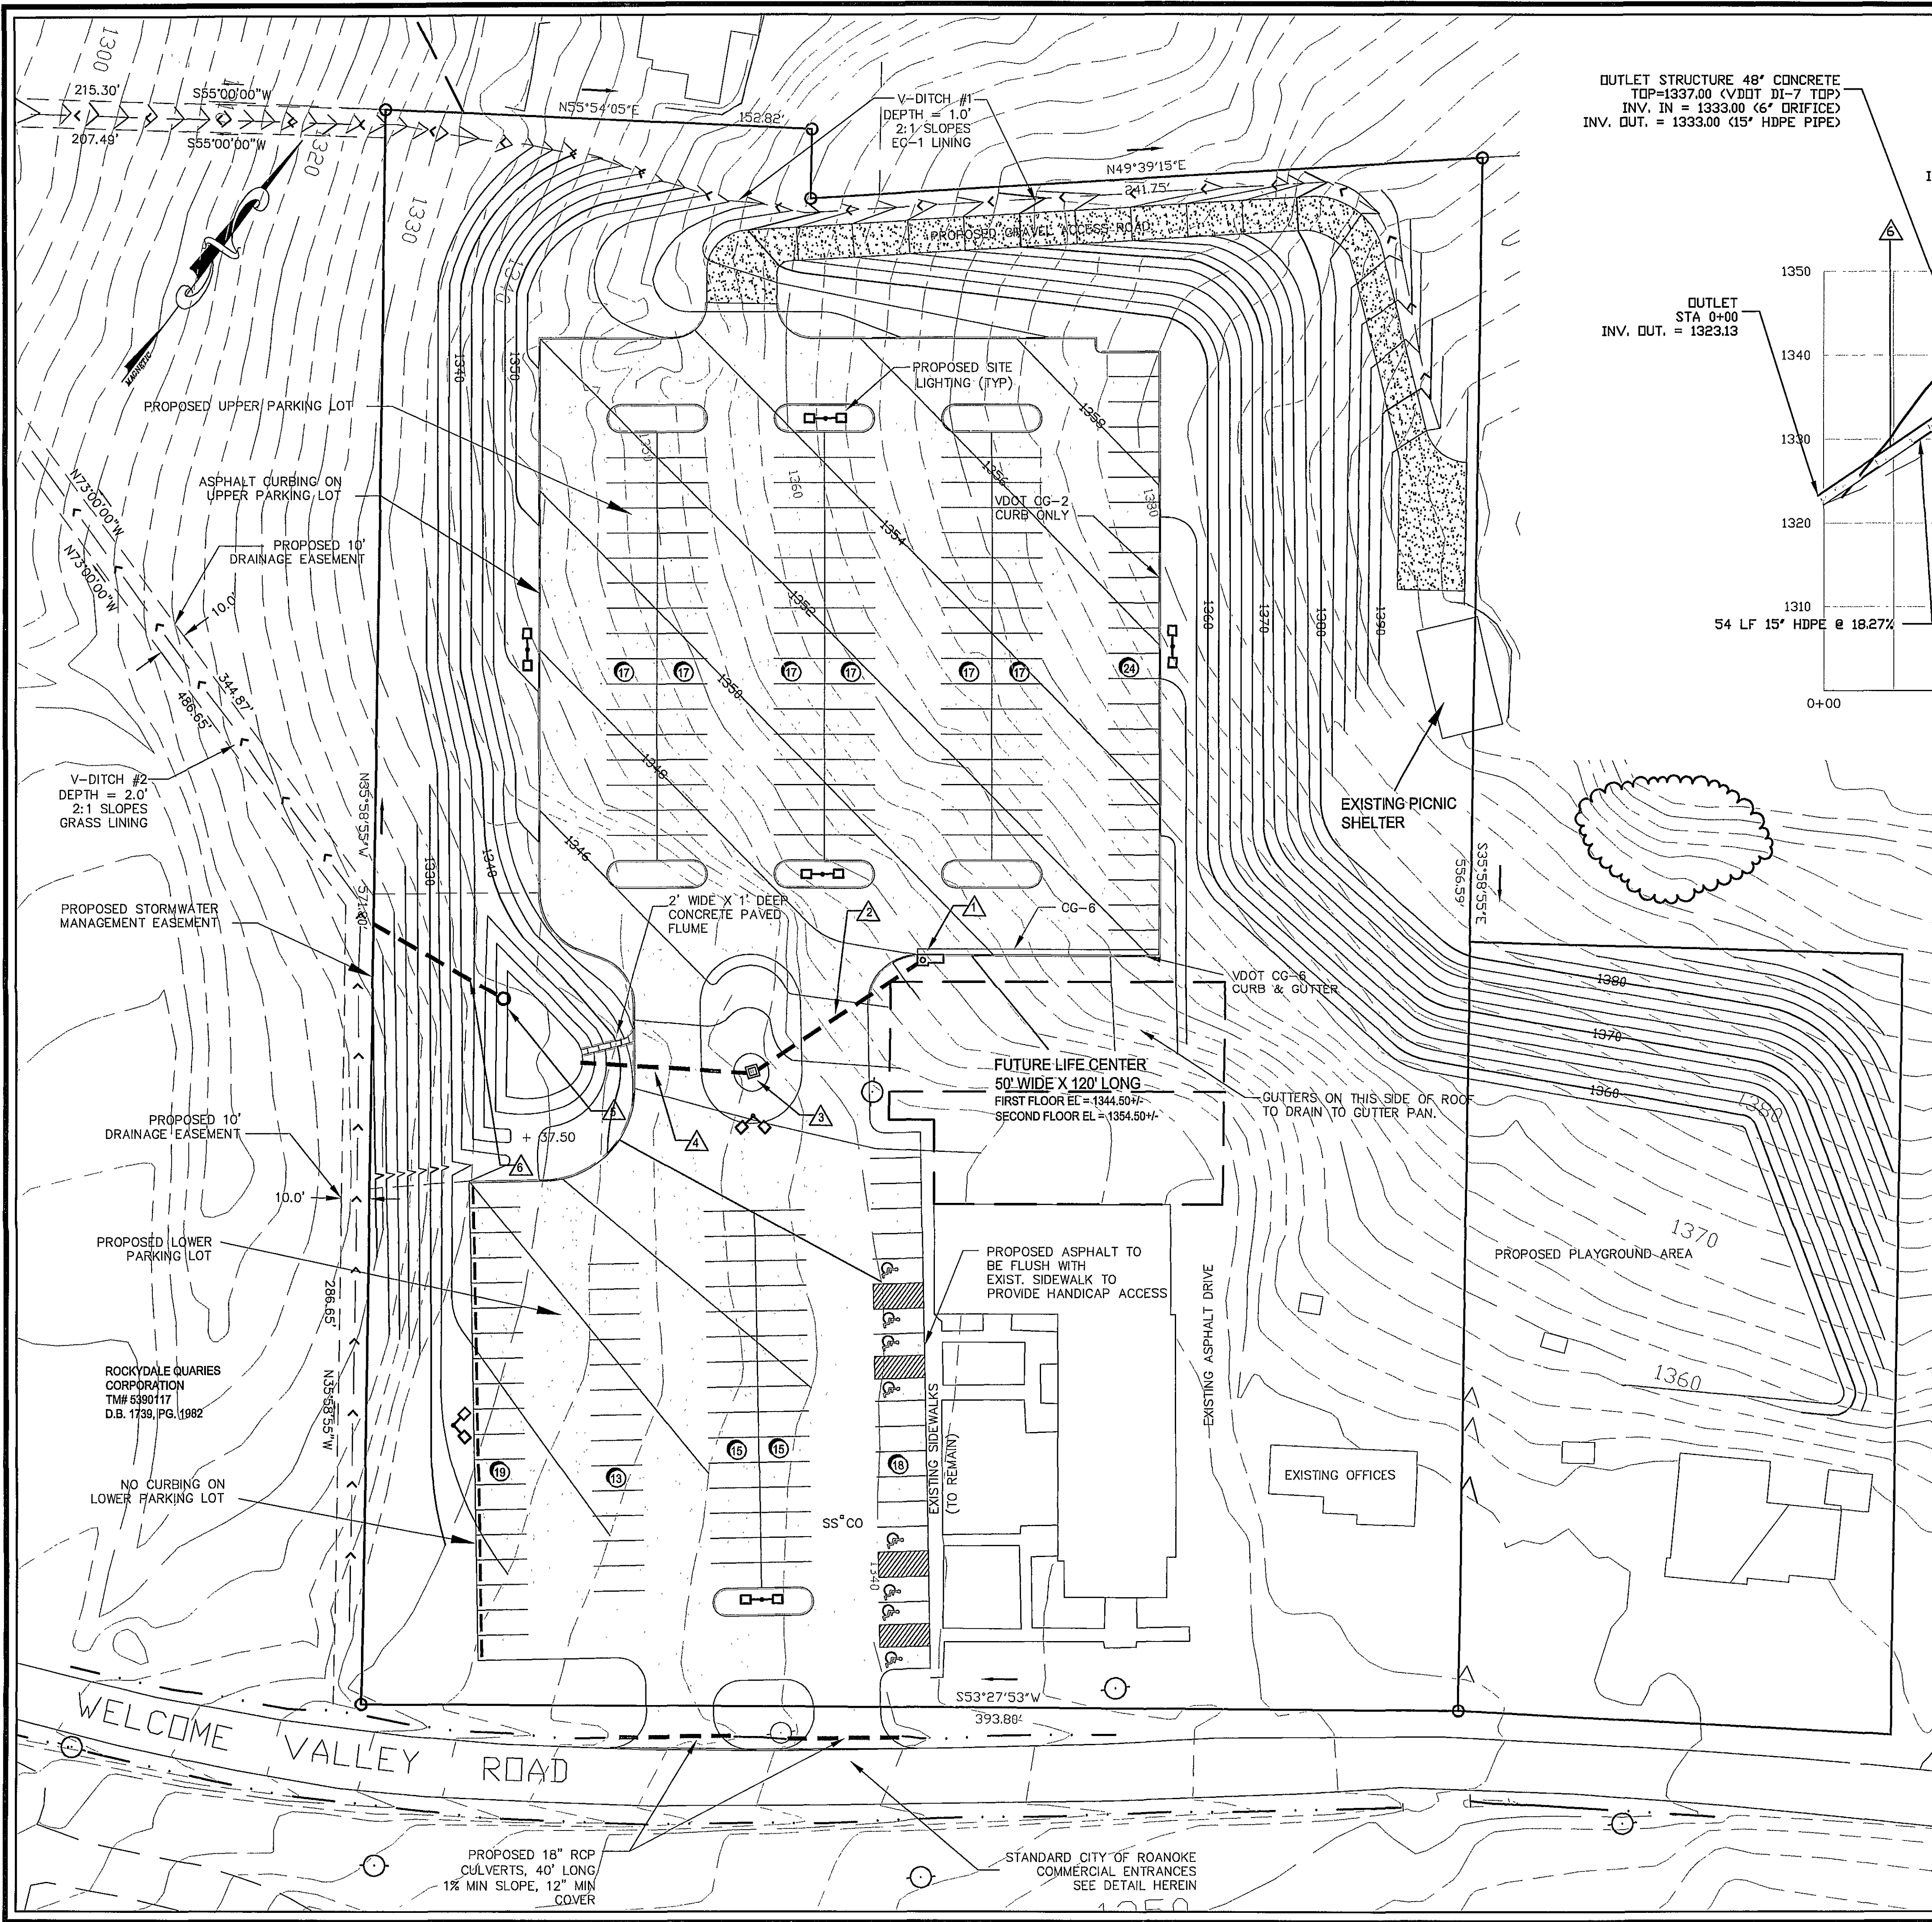

OUTLET STRUCTURE 48" CONCRETE
TOP=1337.00 (VDOT DI-7 TOP)
INV. IN = 1333.00 (6" ORIFICE)
INV. OUT. = 1333.00 (15' HDPE PIPE)

DI-1
TOP=1342.00
INV. IN = 1338.00
INV. OUT. = 1337.90

DI-3B L=10'
TOP=1348.50
INV. OUT. = 1344.50

OUTLET
INV. OUT. = 1333.20

OUTLET
STA 0+00
INV. OUT. = 1323.13

54 LF 15' HDPE @ 18.27%

STORM SEWER PROFILE
SCALE: 1"=10' VERT.
1"=30' HORIZ.



GENERAL NOTES:

BOUNDARY INFORMATION PROVIDED BY PLAT PREPARED BY BALZER & ASSOCIATES, INC DATED APRIL 3, 2000.
TOPOGRAPHIC INFORMATION PROVIDED BY CITY OF ROANOKE GIS WEBSITE.

SITE LIGHTING LOCATIONS ARE APPROX. THESE PLANS TO NOT PROVIDE DESIGN FOR A SITE LIGHTING PLAN. THE OWNER
SHOULD COORDINATE WITH THE CONTRACTOR TO PLAN FOR SITE LIGHTING.


BLANKET MATTING IS REQUIRED FOR ALL SLOPES GREATER THAN 3:1. TEMPORARY SEEDING IS REQUIRED IN ALL AREAS
WHERE PERMANENT SEEDING IS SHOWN.

A PORTION OF THE LOWER PARKING LOT WILL NOT BE GRADED. THIS AREA WILL REQUIRE THAT THE ASPHALT BE
REMOVED AND REPLACED IN KIND.

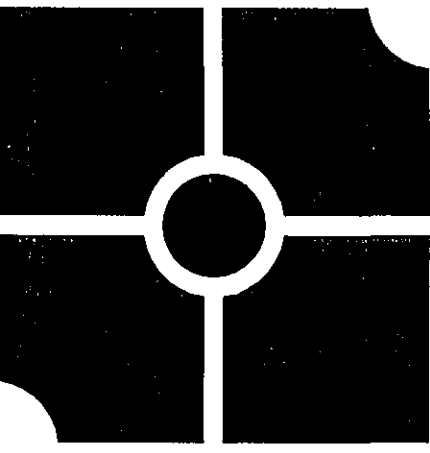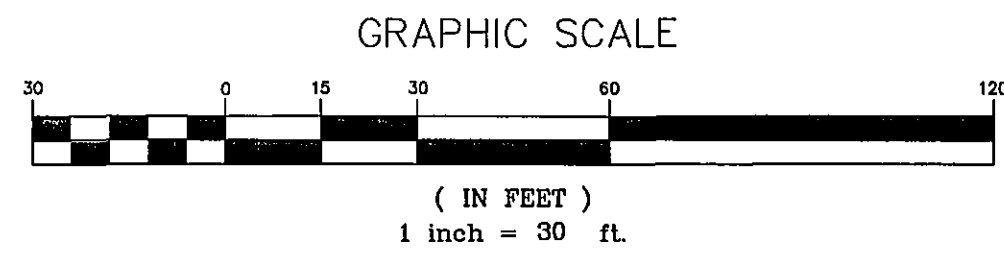

■ Barnes Grogan Bower & Taylor ■
DESIGN GROUP, PC
LANDSCAPE ARCHITECTS • ENGINEERS • PLANNERS
201 E. Main Street
Suite 100
Salem, Virginia 24153
Phone: 540.387.9100
Fax: 540.387.9101
www.bgbt-design.com

These documents are the property of Barnes Grogan Bower & Taylor DESIGN GROUP (BG&T) and may not be reproduced or used without the express permission of BG&T. Any reuse of these documents without authorization of BG&T will be at the sole risk of the individual or entity utilizing said documents.

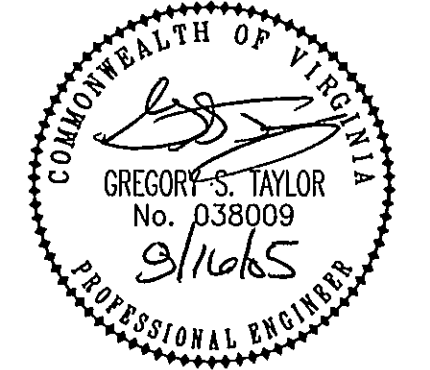

New Hope Christian Church Parking Lot Expansion

City Roanoke, Virginia

REVISIONS:	
	City Comments
	July 29, 2005
	City Comments
	August 16, 2005

DESIGNED BY:	JCG
DRAWN BY:	GST
CHECKED BY:	GST
SCALE:	1" = 30'
DATE:	July 15, 2005

SHEET TITLE:
**Overall Site
&
Grading Plan**

C03
03 OF 08
PROJECT NUMBER:
S04064-01