


NEW YORK AVENUE
WATERLINE REPLACEMENT
WESTERN VIRGINIA WATER AUTHORITY
CITY OF ROANOKE, VIRGINIA
APRIL 20, 2018
COMM. NO. 3814

SHEET LIST


- 1 TITLE SHEET
2 ABBREVIATIONS AND LEGEND
3 WATERLINE GENERAL NOTES AND SURVEY DATA
4 PLAN AND PROFILE- 8" WATERLINE
5 PLAN AND PROFILE- 8" WATERLINE
6 PLAN AND PROFILE- 8" WATERLINE
7 PLAN AND PROFILE- 8" WATERLINE
8 PLAN AND PROFILE- 8" WATERLINE
9 DETAILS
10 DETAILS
11 FIRE HYDRANT SERVICE RANGE EXHIBIT
12 MAINTENANCE OF TRAFFIC - PROJECT LIMITS SIGNAGE
13 MAINTENANCE OF TRAFFIC - CRESCENT STREET- PHASE A
14 MAINTENANCE OF TRAFFIC - NEW YORK AVENUE- PHASE B
15 MAINTENANCE OF TRAFFIC - MARYLAND AVENUE- PHASE C

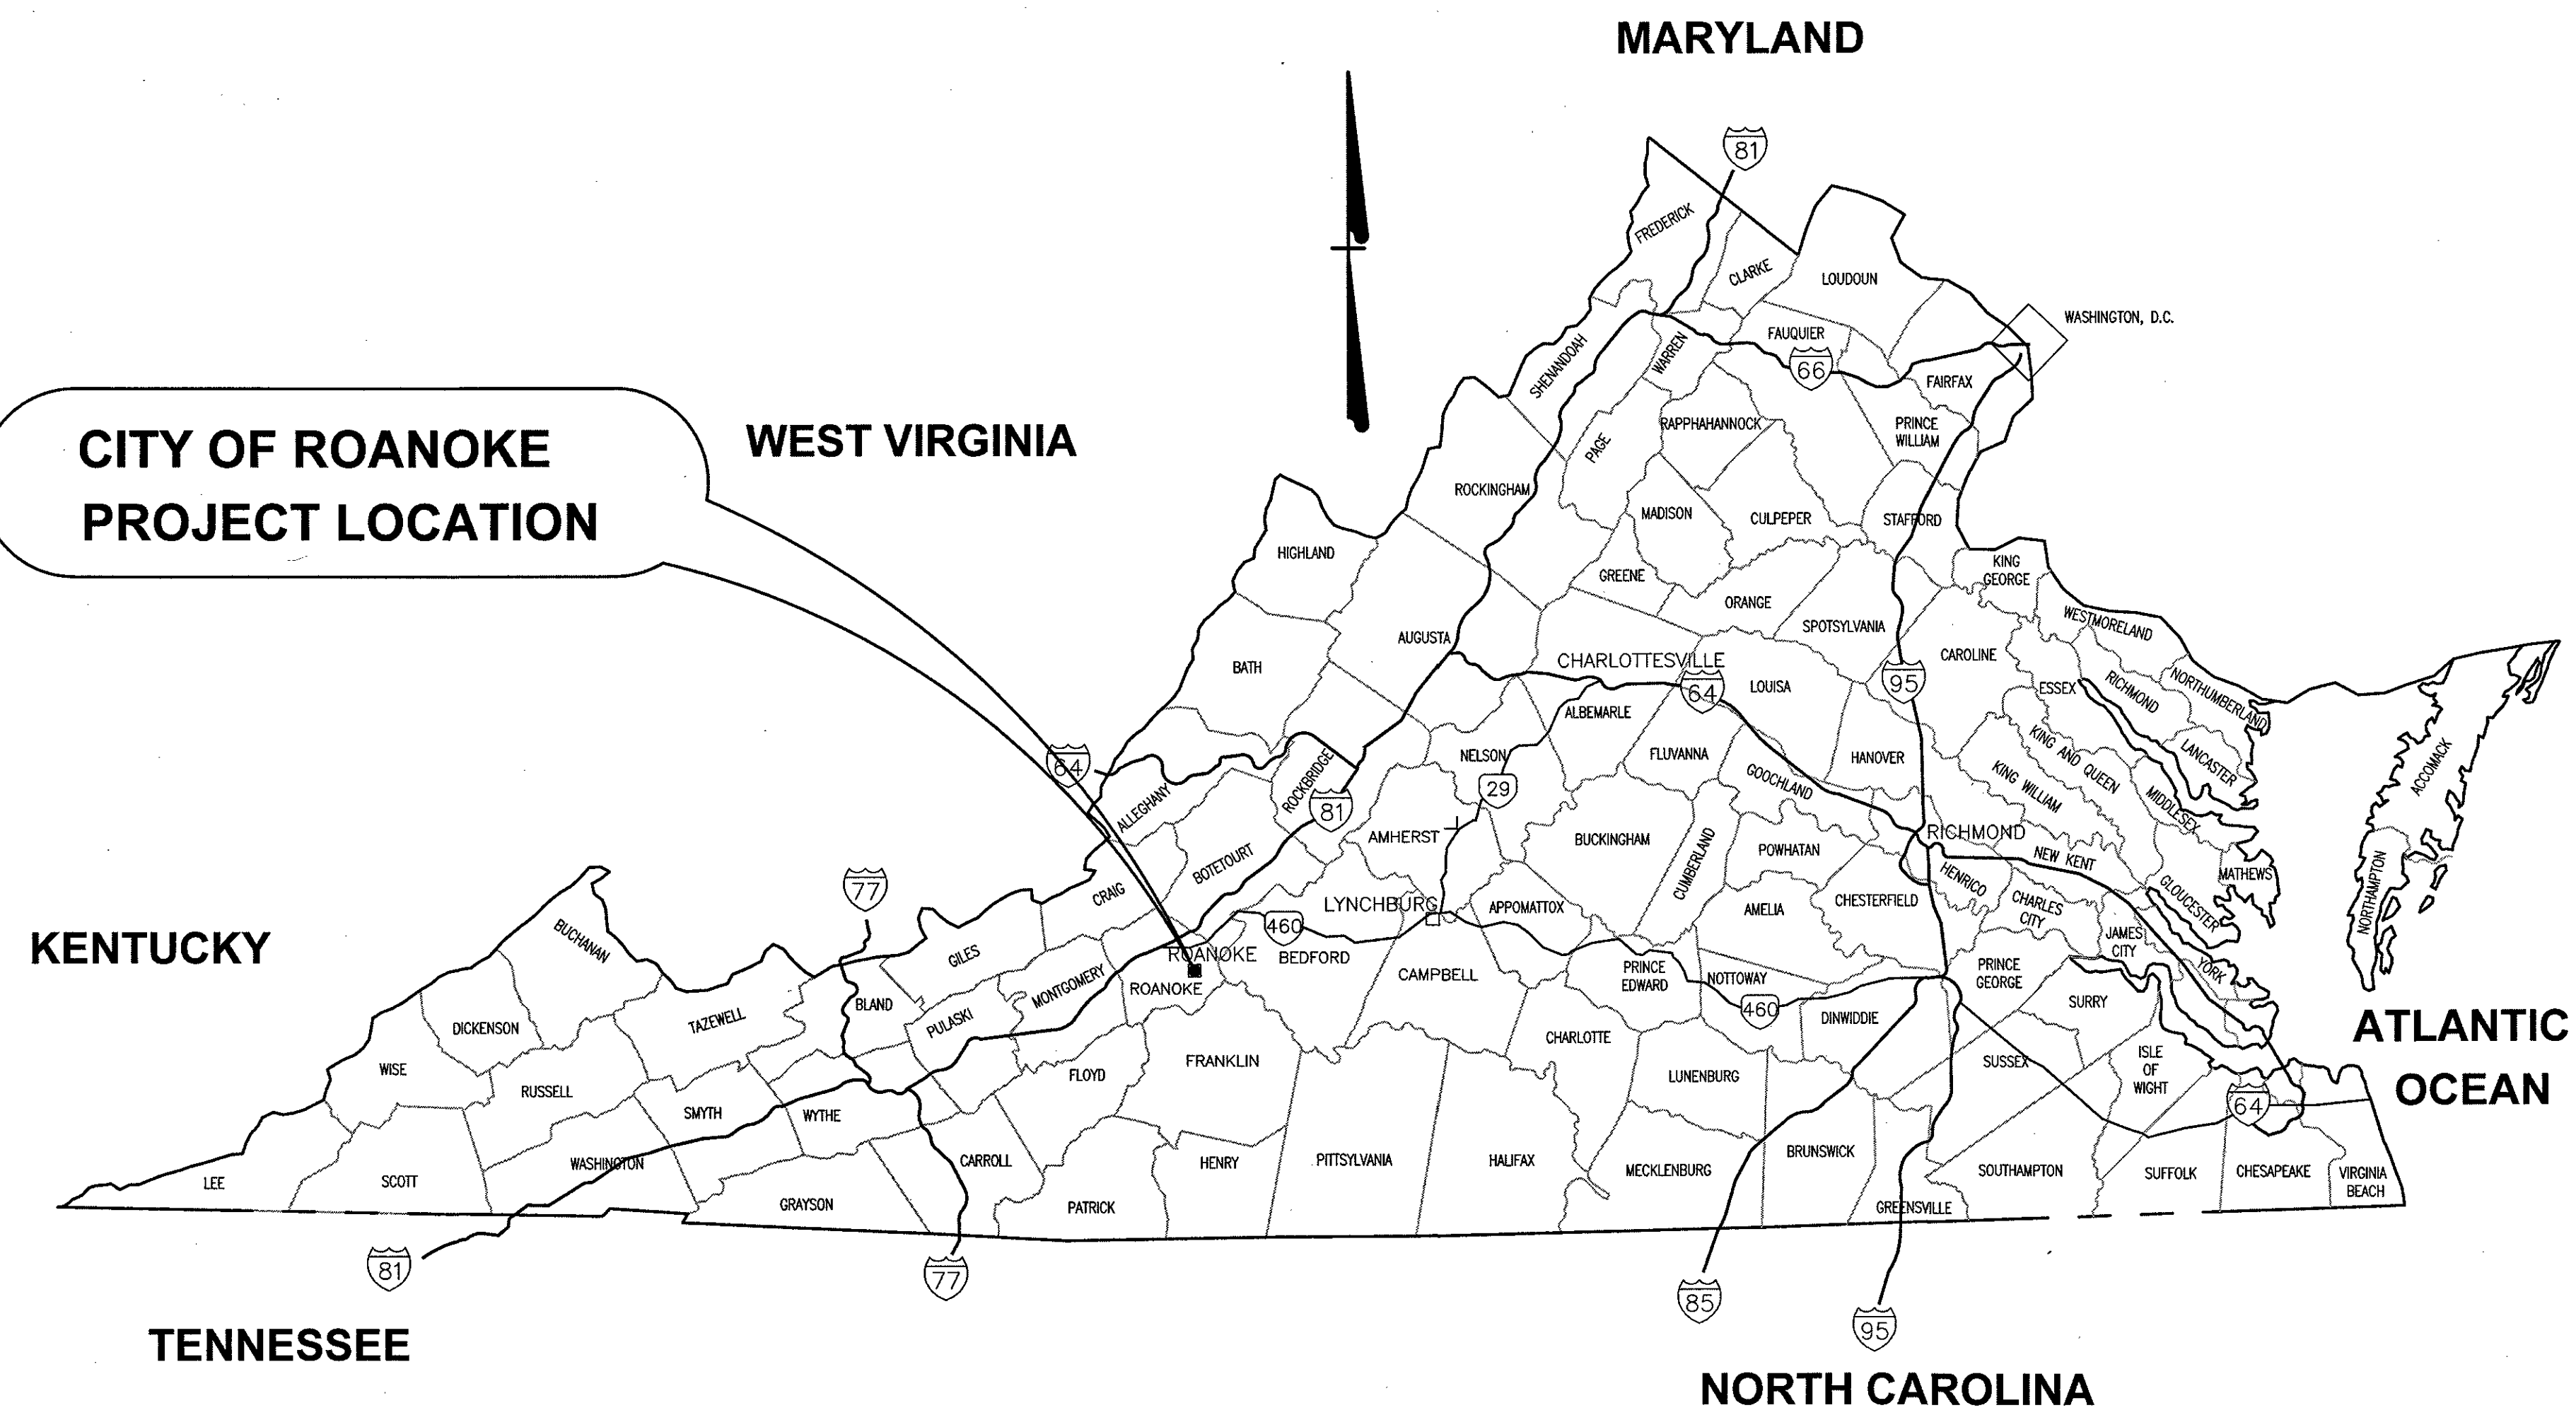

PREPARED FOR:



APPROVED FOR CONSTRUCTION

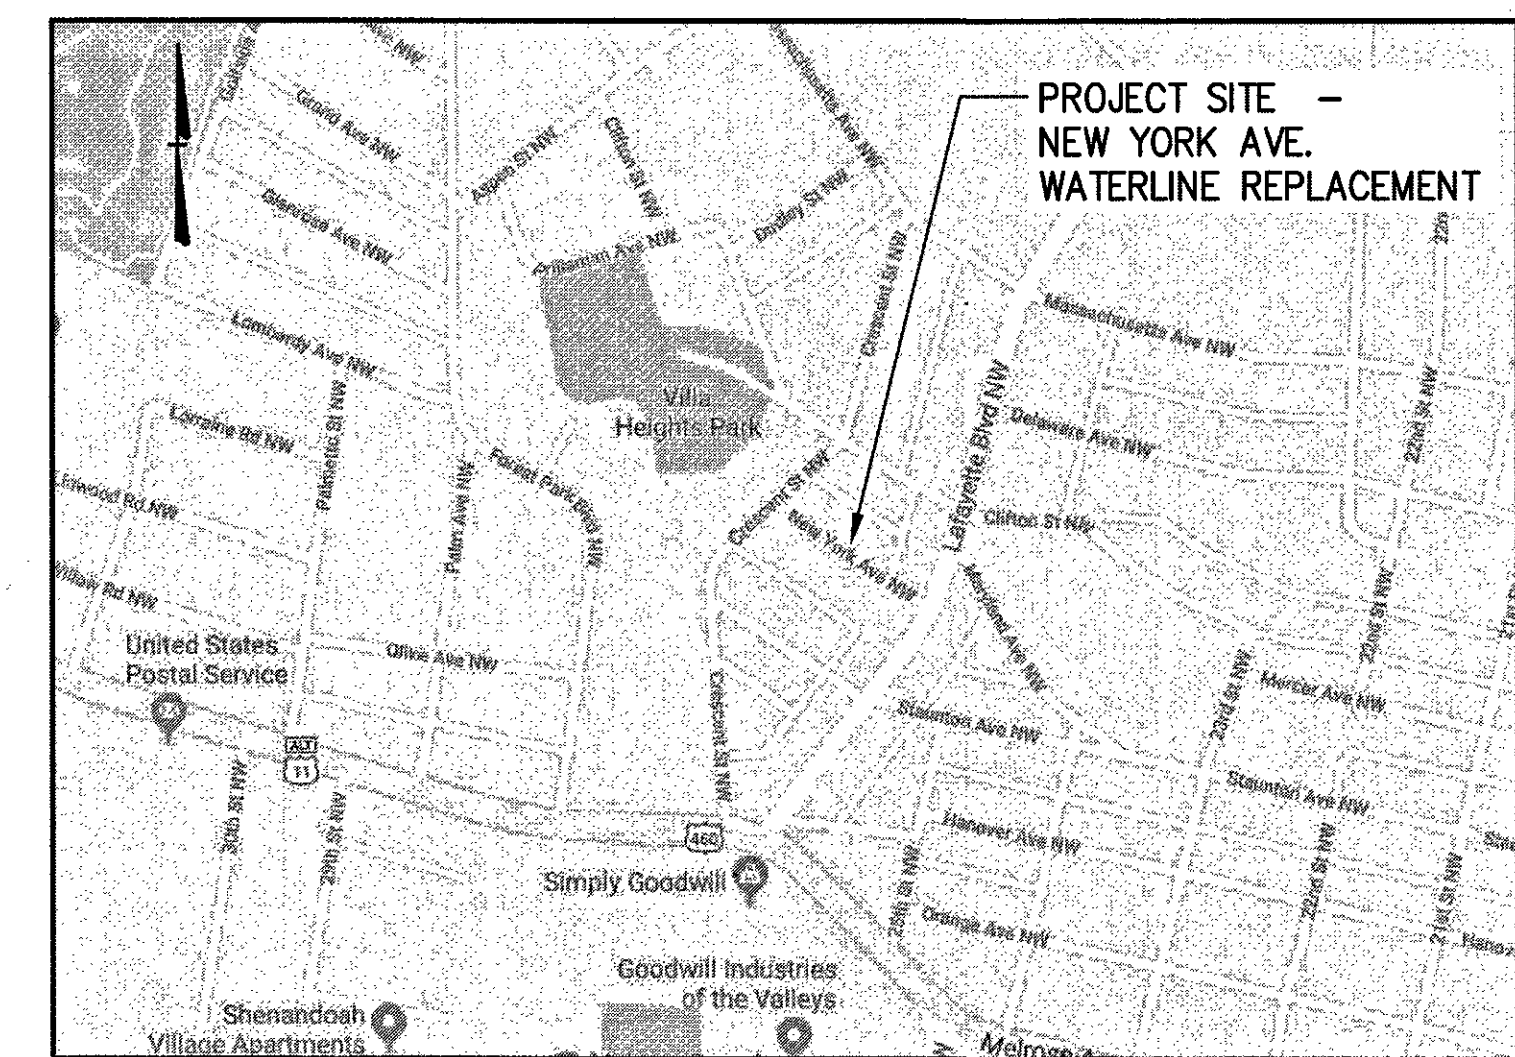

LOCATION MAP
NOT TO SCALE

COMMONWEALTH OF VIRGINIA
 BRADLEY C. CRAIG
 Lic. No. 023879
 4/20/18
 PROFESSIONAL ENGINEER

[illegible]

Issue Date: APRIL 20, 2018	Drawn By: ARB Designed By: DBL	Checked By: BCC Date: 4/20/18
--------------------------------------	-----------------------------------	----------------------------------

Mattern & Craig
ENGINEERS-SURVEYORS

701 FIRST STREET, S.W.
ROANOKE, VIRGINIA 24016
(540) 343-9342
FAX (540) 343-7891

NEW YORK AVENUE

WATERLINE REPLACEMENT

TITLE SHEET

WESTERN VIRGINIA WATER AUTHORITY

Vertical Scale:
N/A

Horizontal Scale:
N/A

Commission Number:
3814

Sheet No.:

1

CHARLES CRUSH
AG- BUILTS
11-28-18