
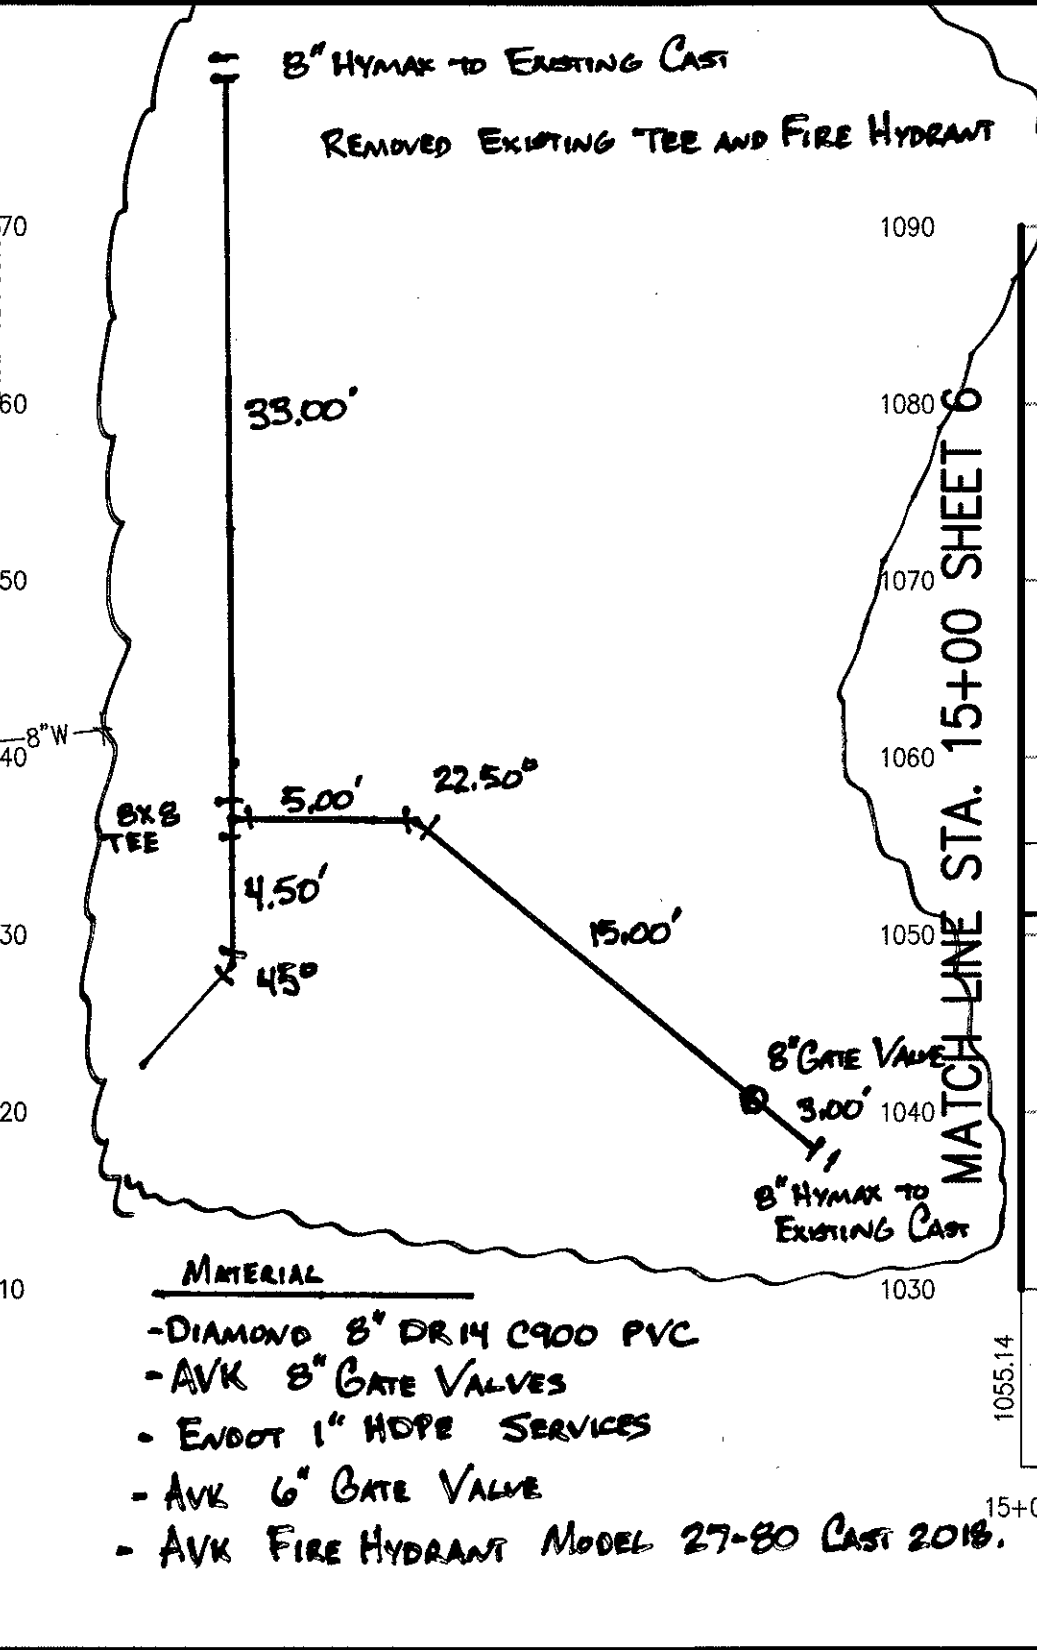
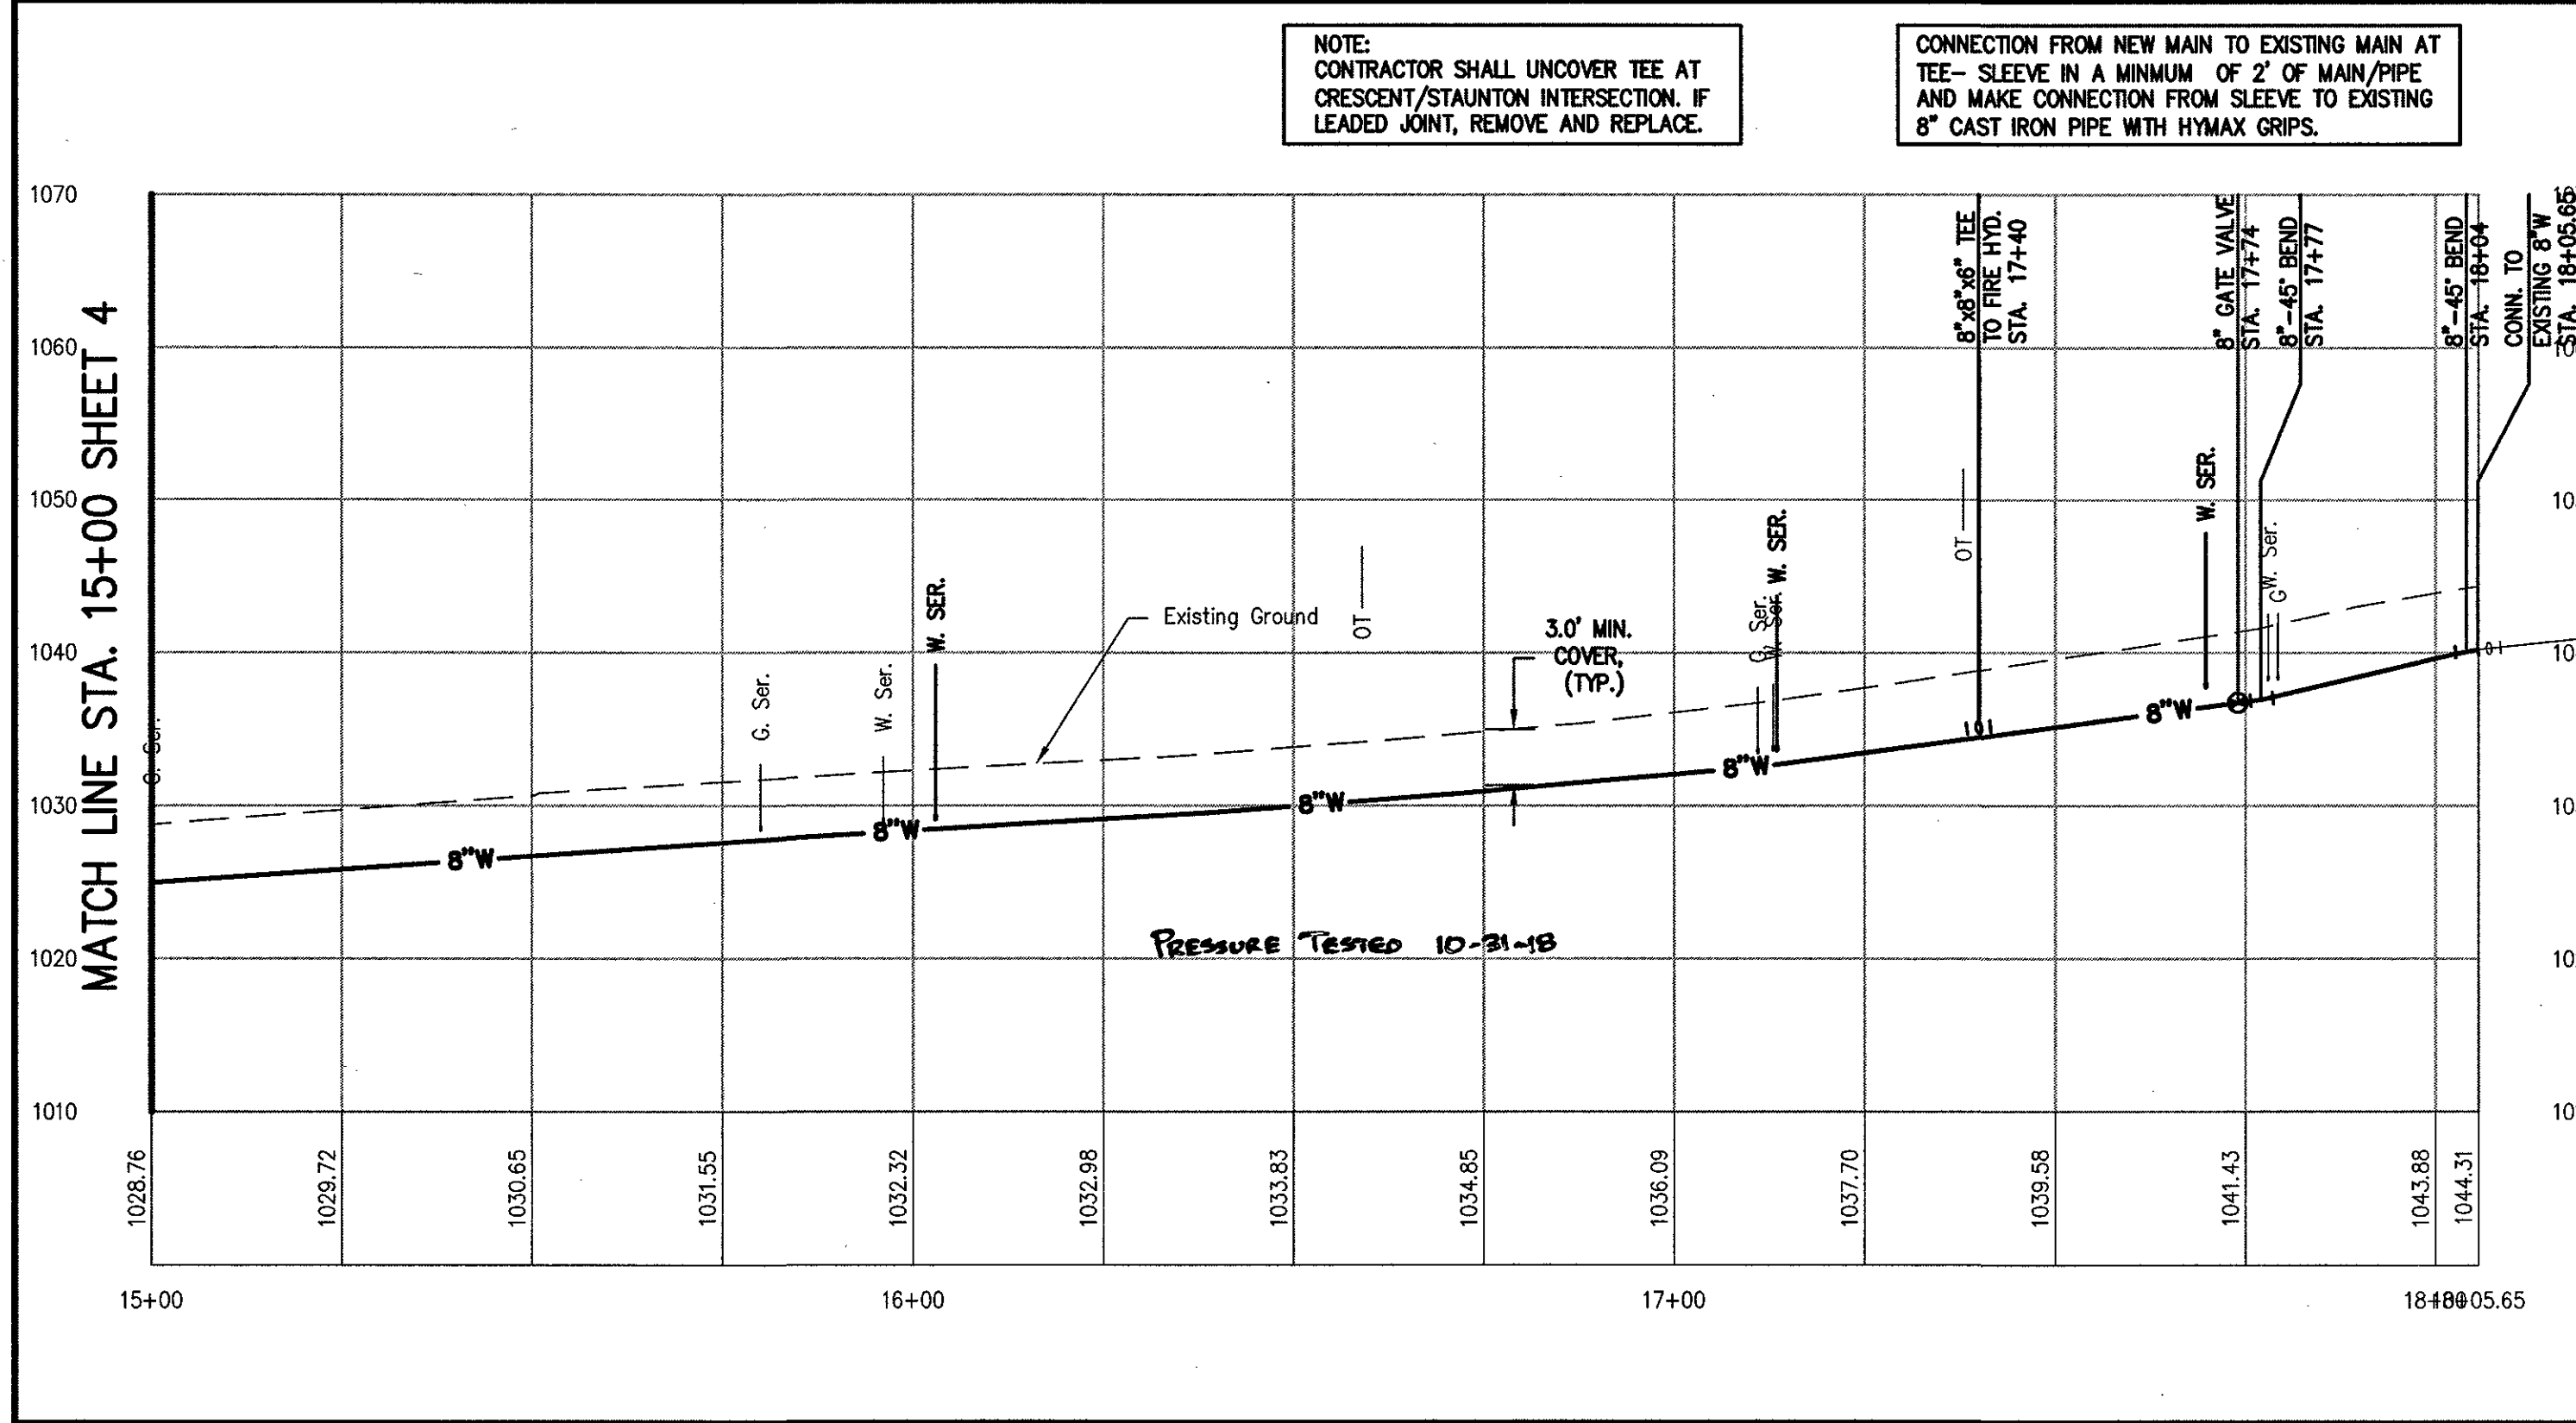
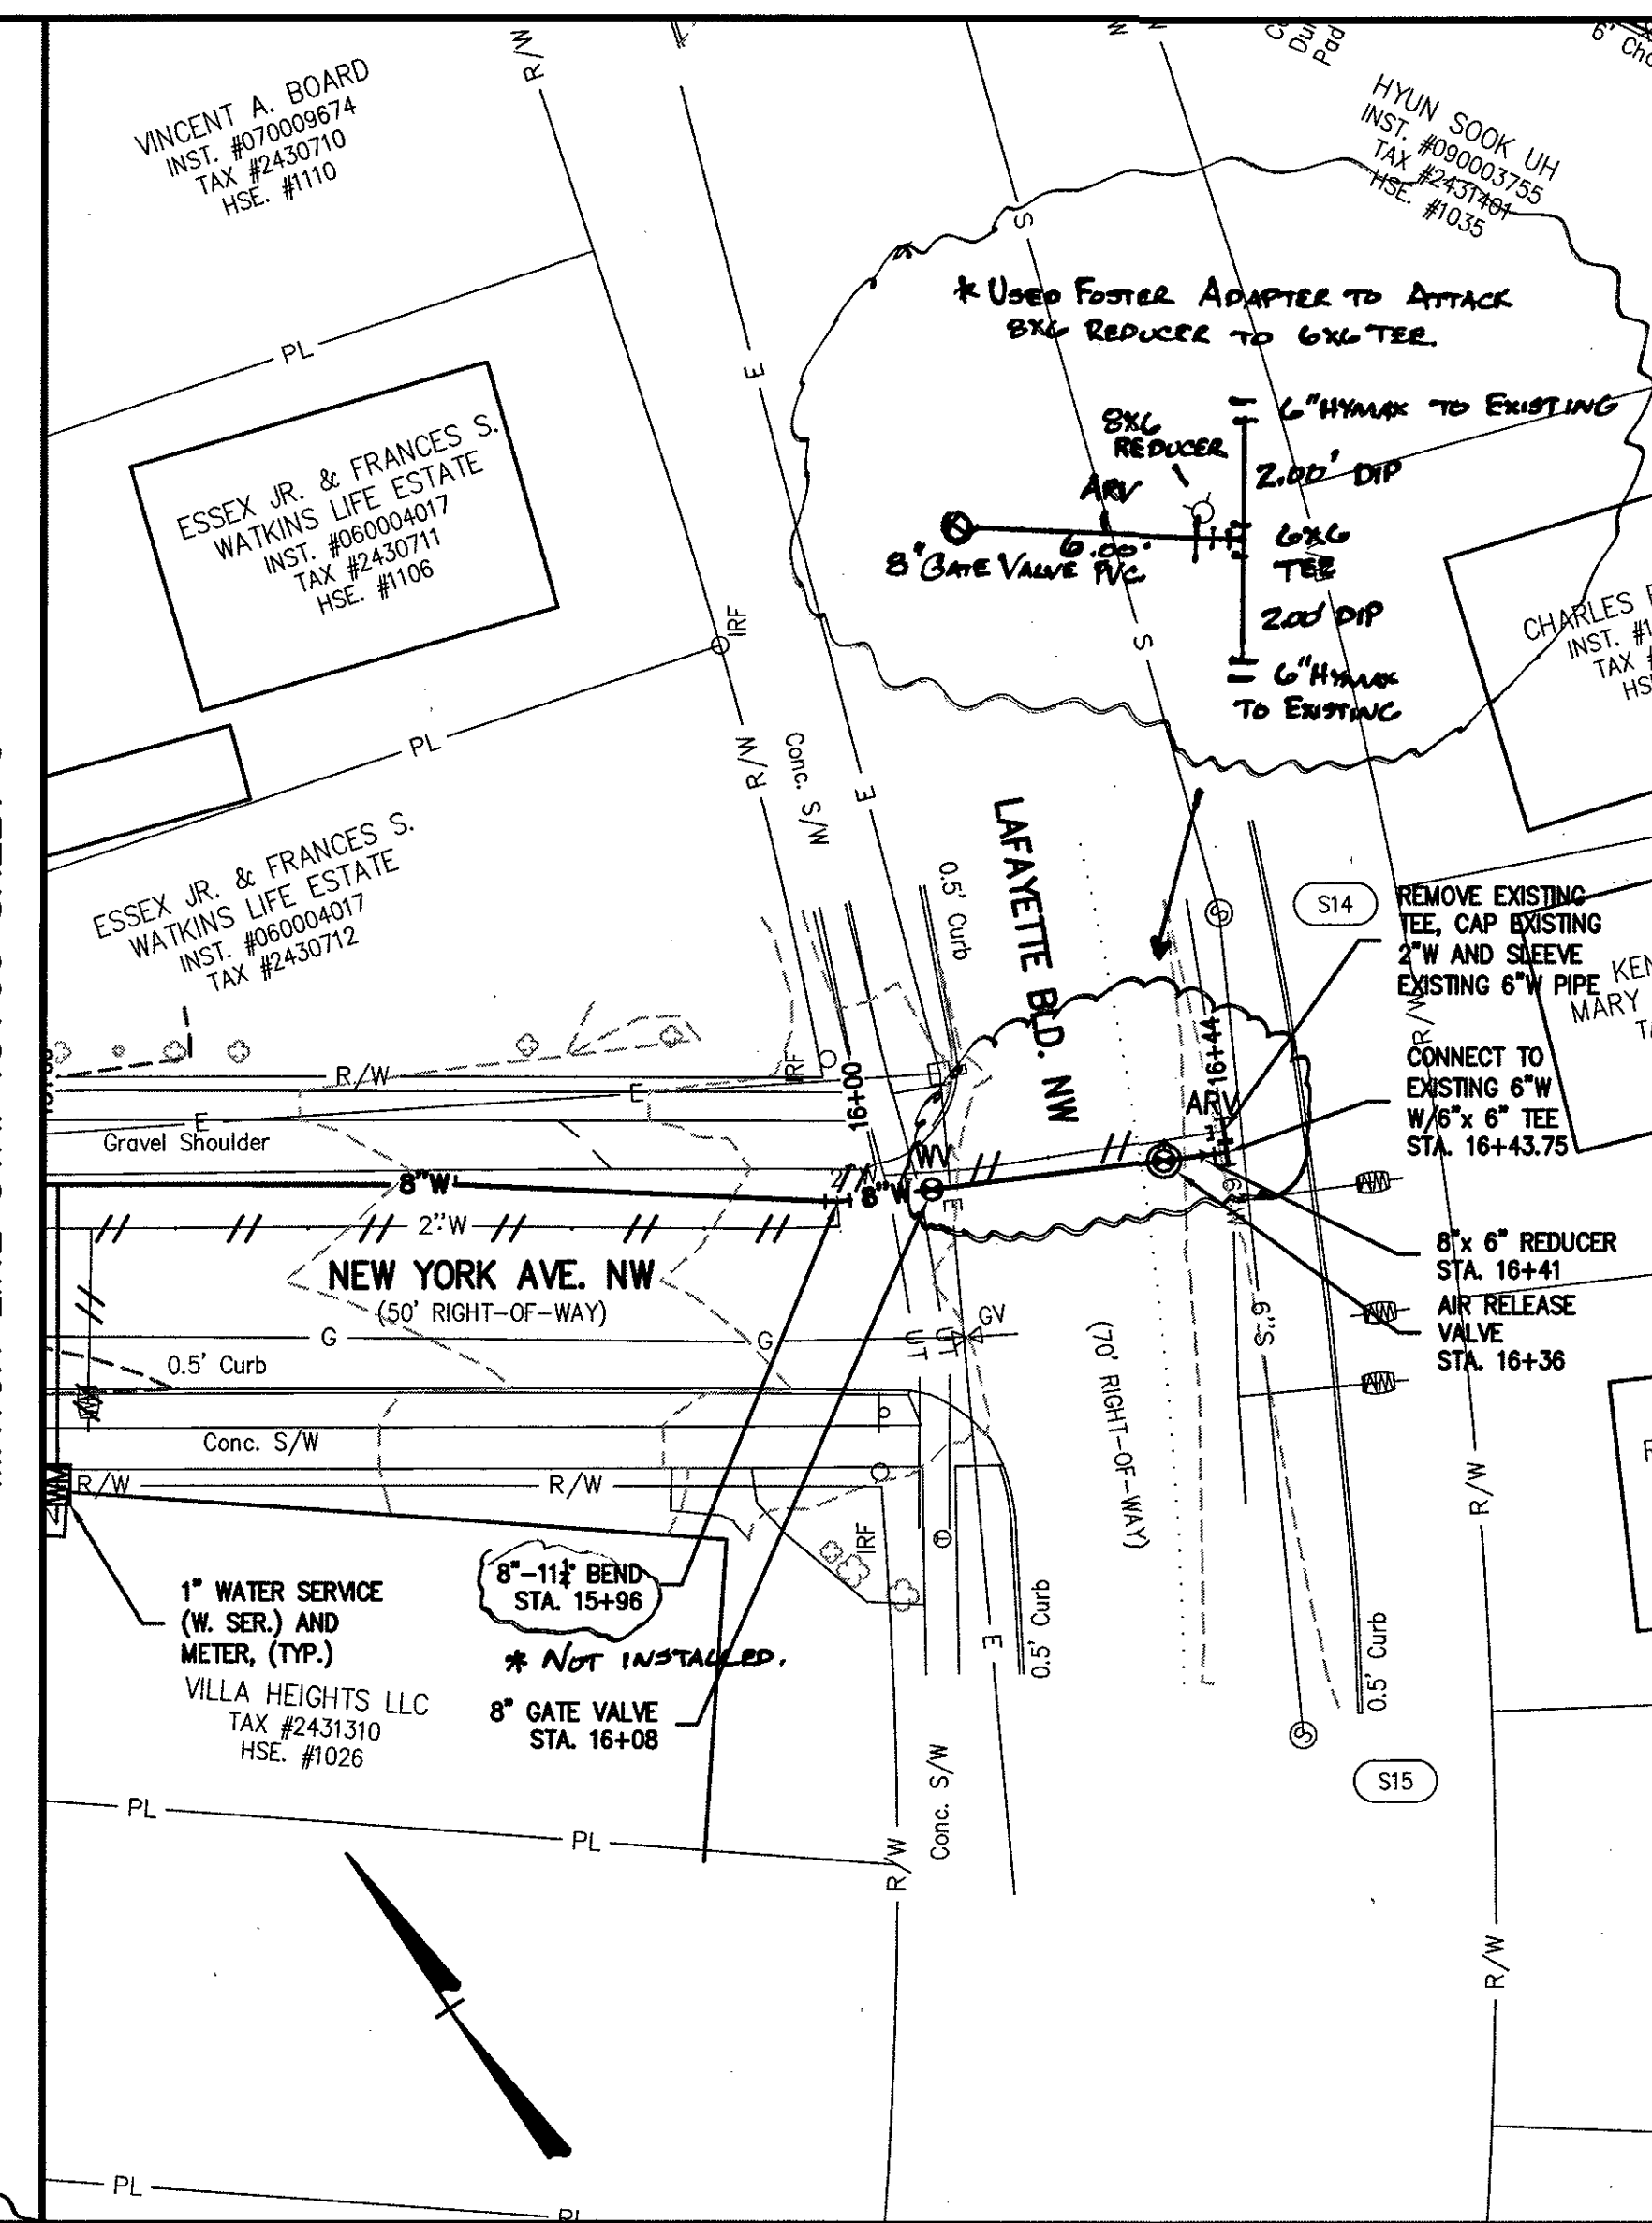


L:\3814\New York Avenue\DWG\3814-SHEETS.dwg, 4/23/2018 4:22:25 PM, gfo

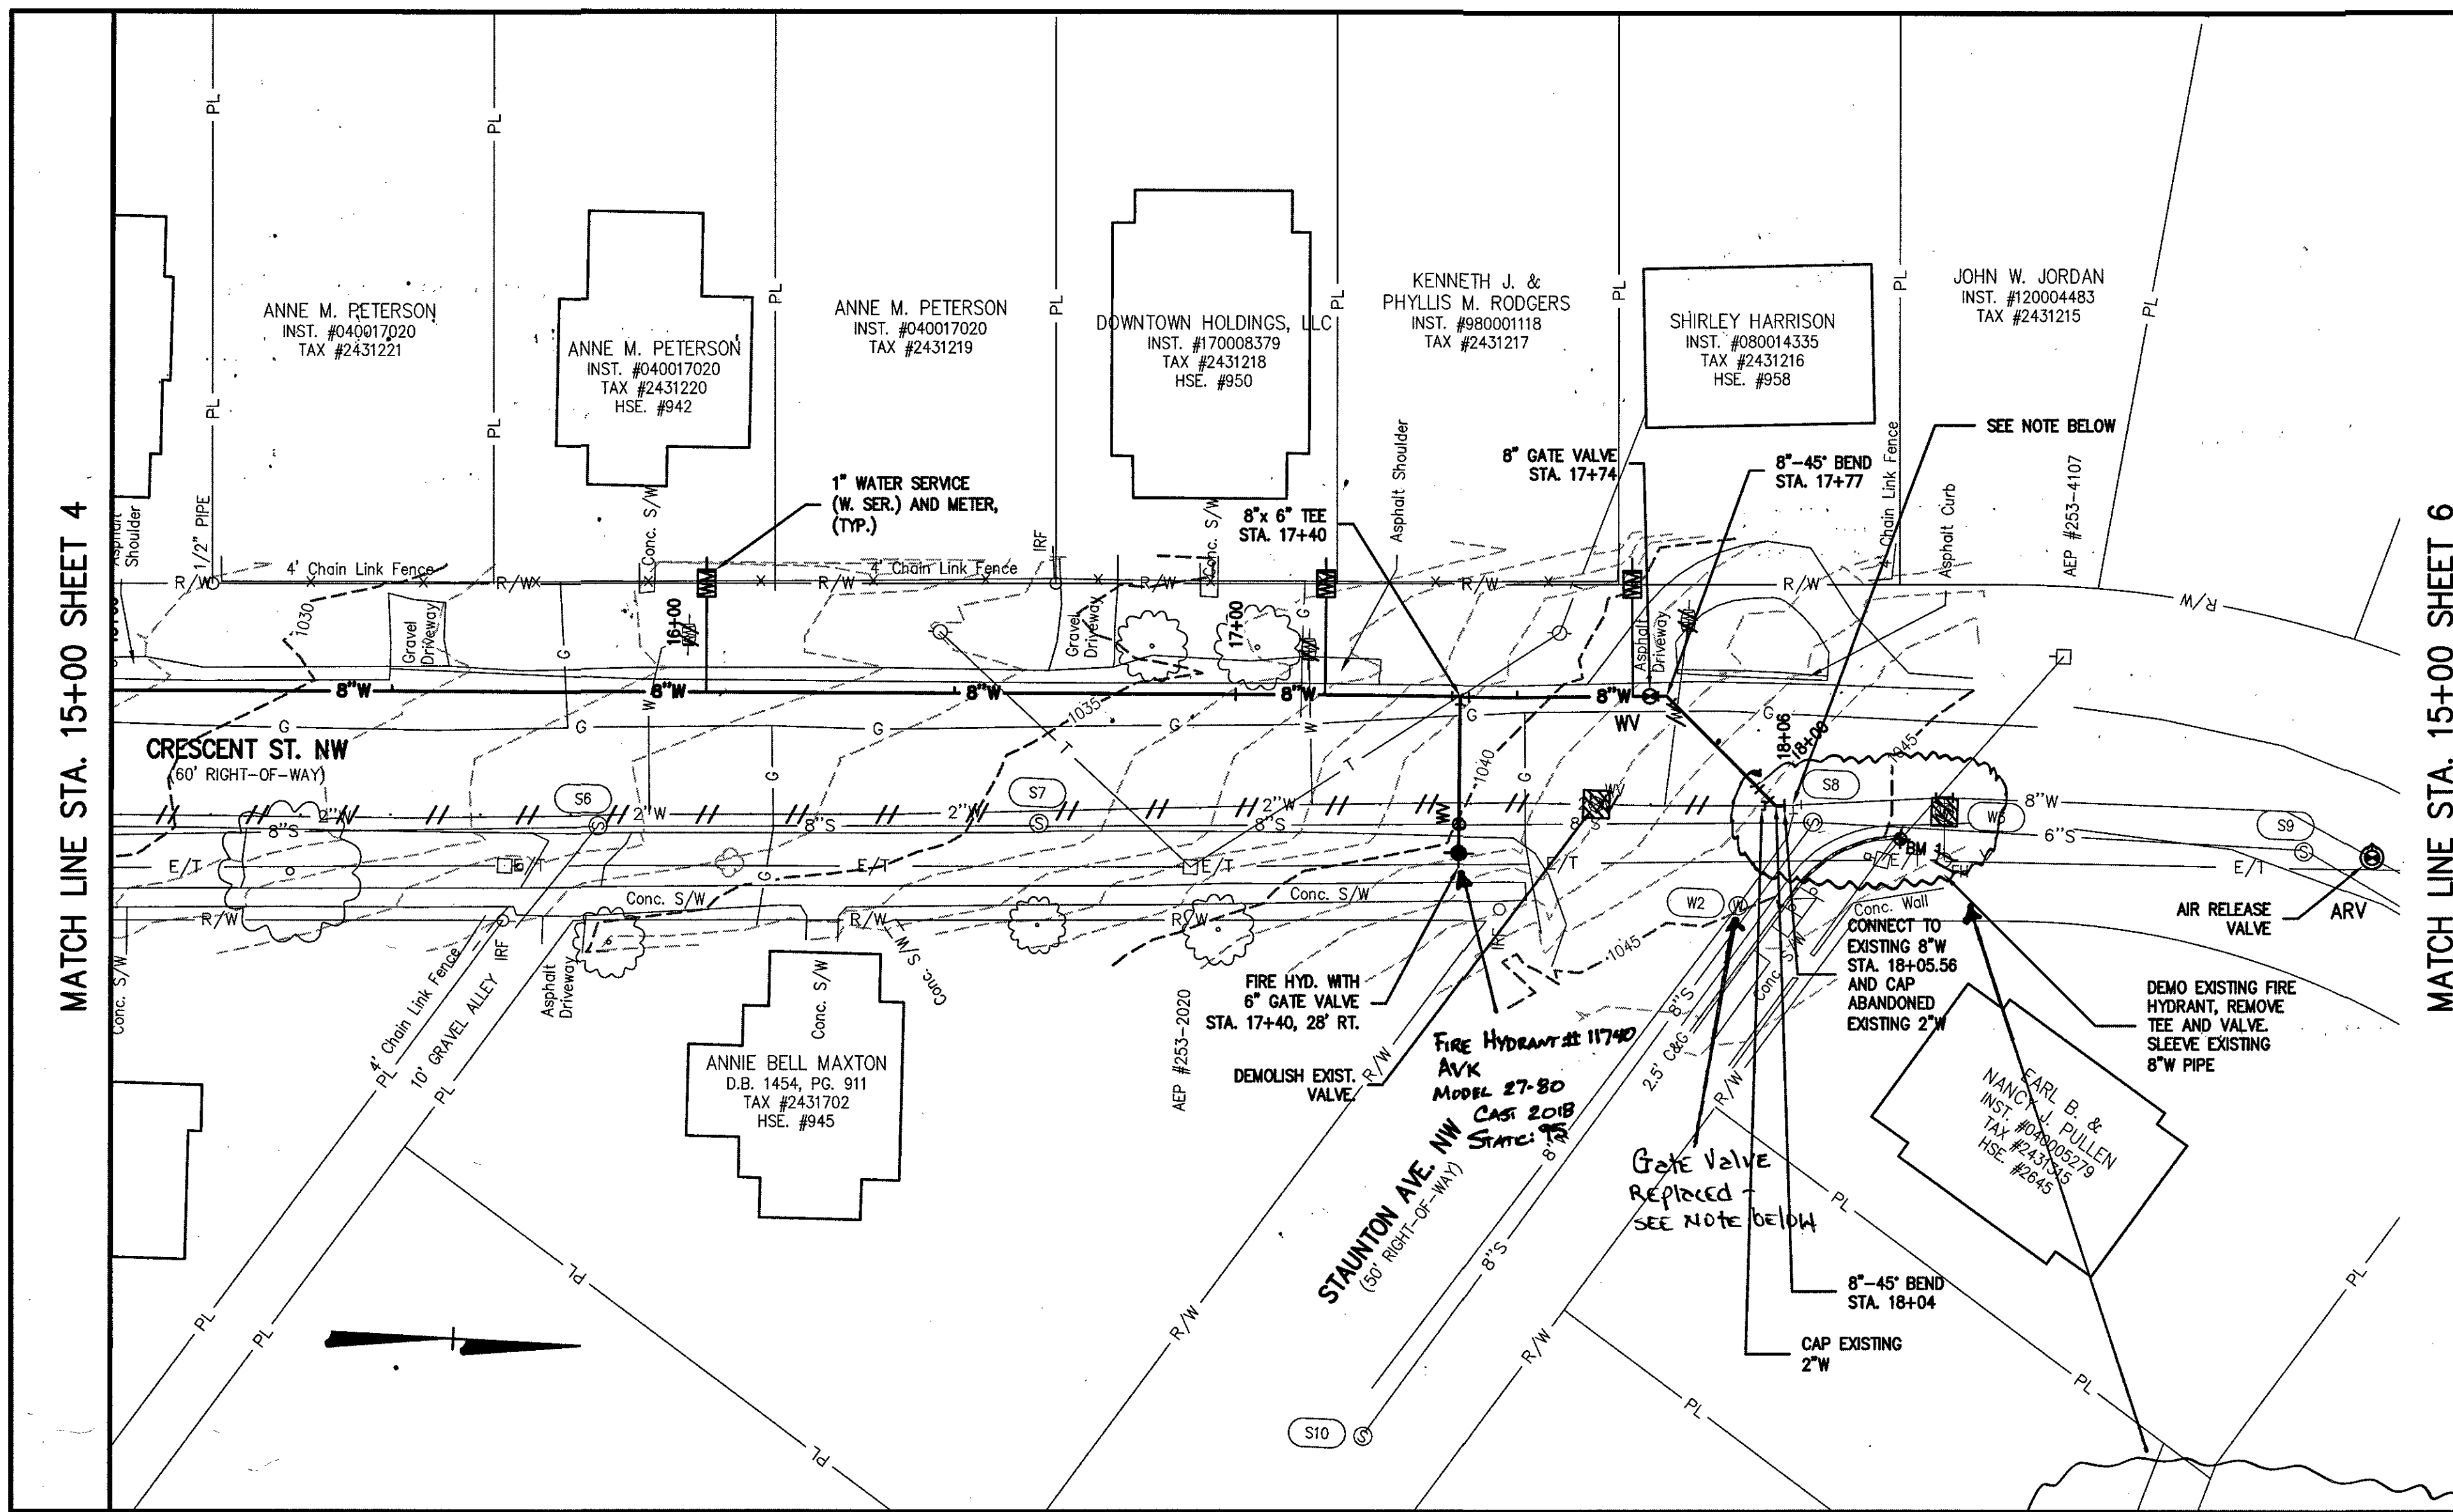

- MATERIAL**
- DIAMOND 8" DR14 C900 PVC
 - AVK 8" GATE VALVES
 - ENDOT 1" HOPE SERVICES
 - AVK 6" GATE VALVE
 - AVK FIRE HYDRANT MODEL 27-80 CAST 2018

REVISIONS

Date	By	Description

Issue Date: **APRIL 20, 2018**

Drawn By: **ARB**

Designed By: **DBL**

Checked By: **BOC**

Date: **4/20/18**

Mattern & Craig
ENGINEERS/SURVEYORS

701 FIRST STREET, S.W.
ROANOK, VIRGINIA 24016
(540) 345-9342
FAX (540) 345-7881

**NEW YORK AVENUE
WATERLINE REPLACEMENT
PLAN AND PROFILE - 8" WATERLINE**

WESTERN VIRGINIA WATER AUTHORITY

Vertical Scale:
1" = 10'

Horizontal Scale:
1" = 20'

Commission Number:
3814

Sheet No.:
5