



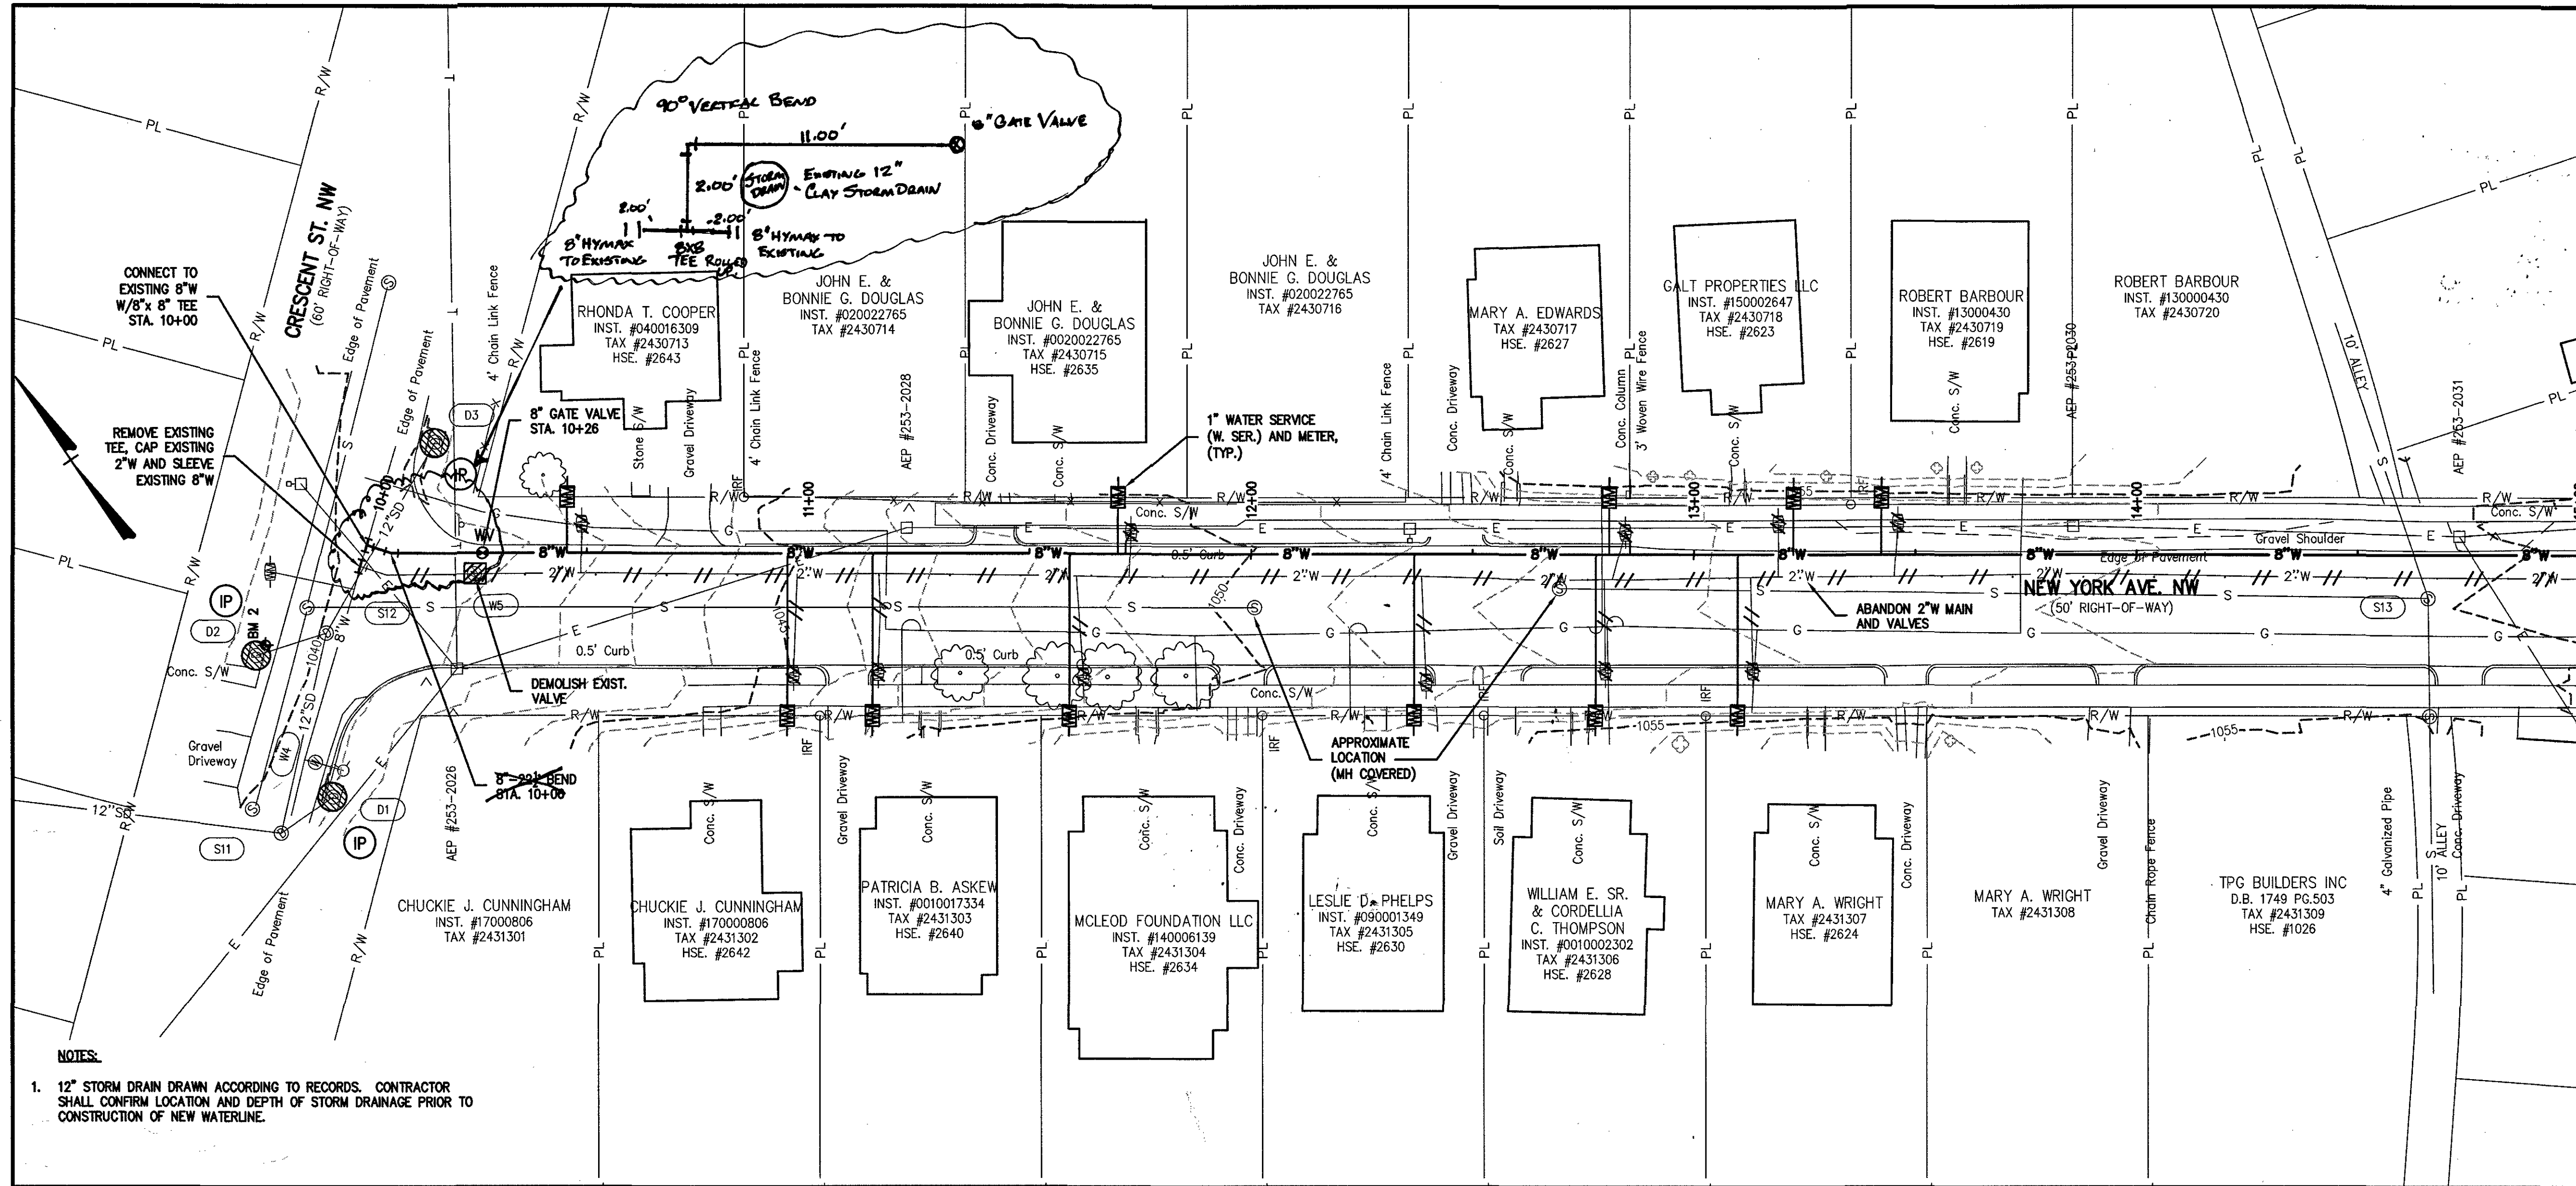


MATCH LINE STA. 15+00 SHEET 5

- MATERIAL**
- DIAMOND 8" DRP C900 PVC
 - AVK 8" Gate Valves
 - EXIST 1" HDPE SERVICES

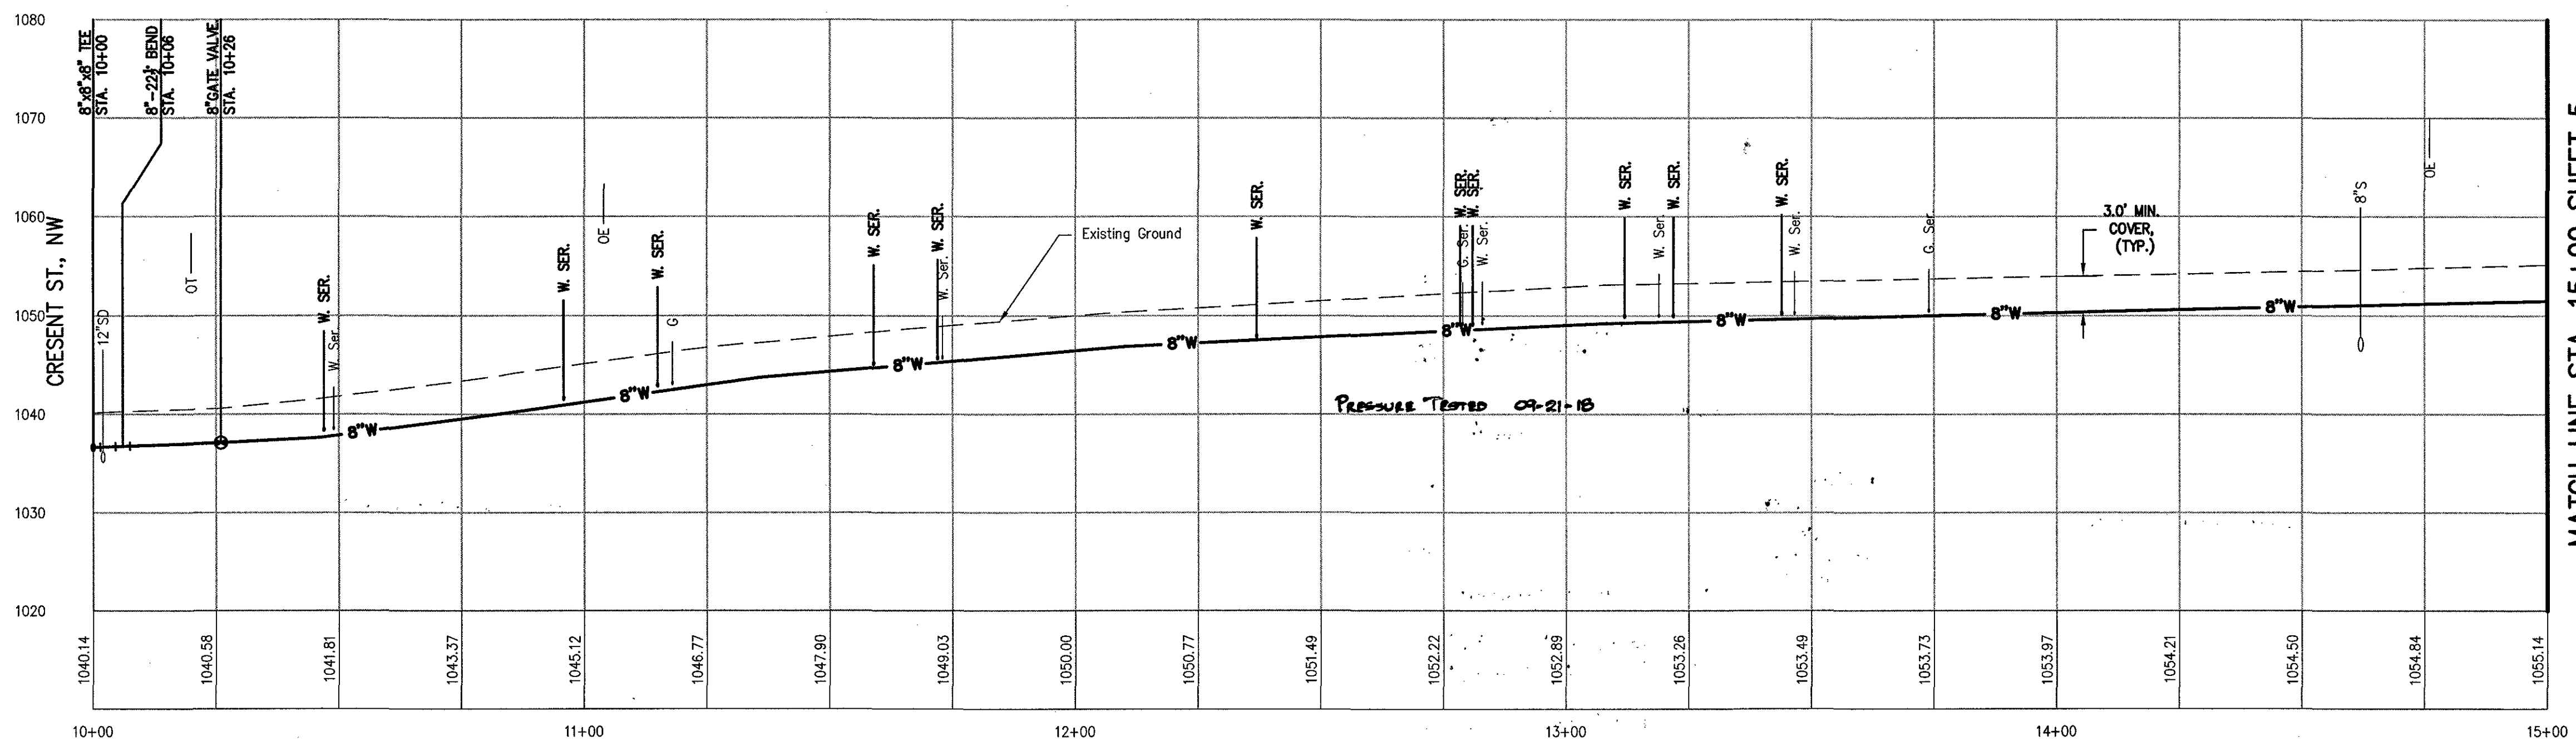

MATCH LINE STA. 15+00 SHEET 5

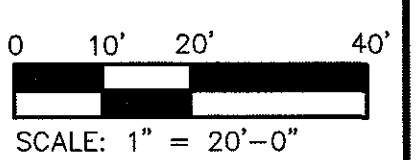

Professional Seal

BRADLEY C. CRAIG

Professional Engineer

License No. 028879

State of Virginia

4/20/18

Issue Date:

APRIL 20, 2018

Drawn By:

AKB

Designed By:

DBL

Checked By:

BCC

Date:

4/20/18

Matthew & Craig

ENGINEERS/SURVEYORS

701 FIRST STREET, S.W.

ROANOK, VA 24016

PHONE (540) 346-7841

FAX (540) 346-7881

NEW YORK AVENUE

WATERLINE REPLACEMENT

PLAN AND PROFILE - 8" WATERLINE

WESTERN VIRGINIA WATER AUTHORITY

Vertical Scale:

1" = 10'

Horizontal Scale:

1" = 20'

Commission Number:

3814

Sheet No.:

6