
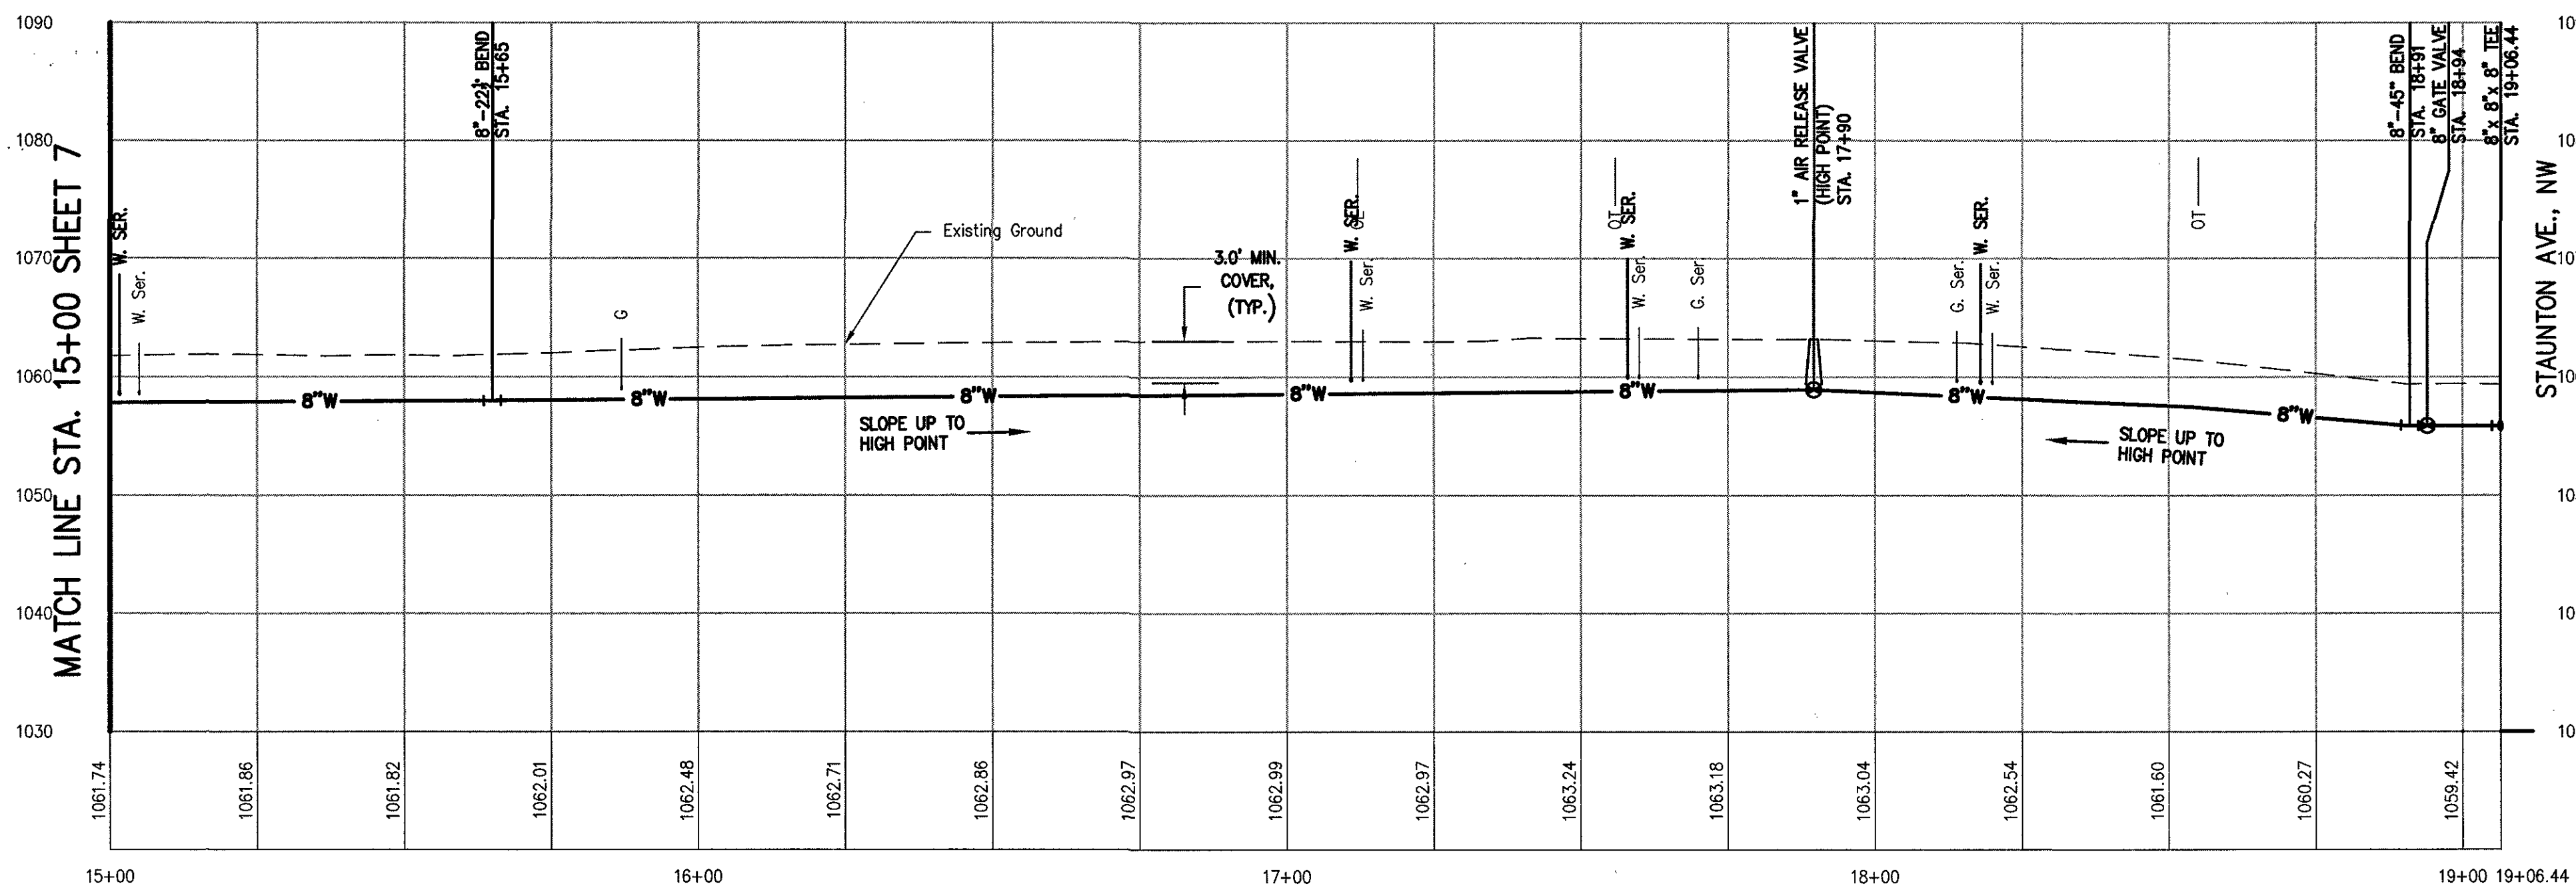


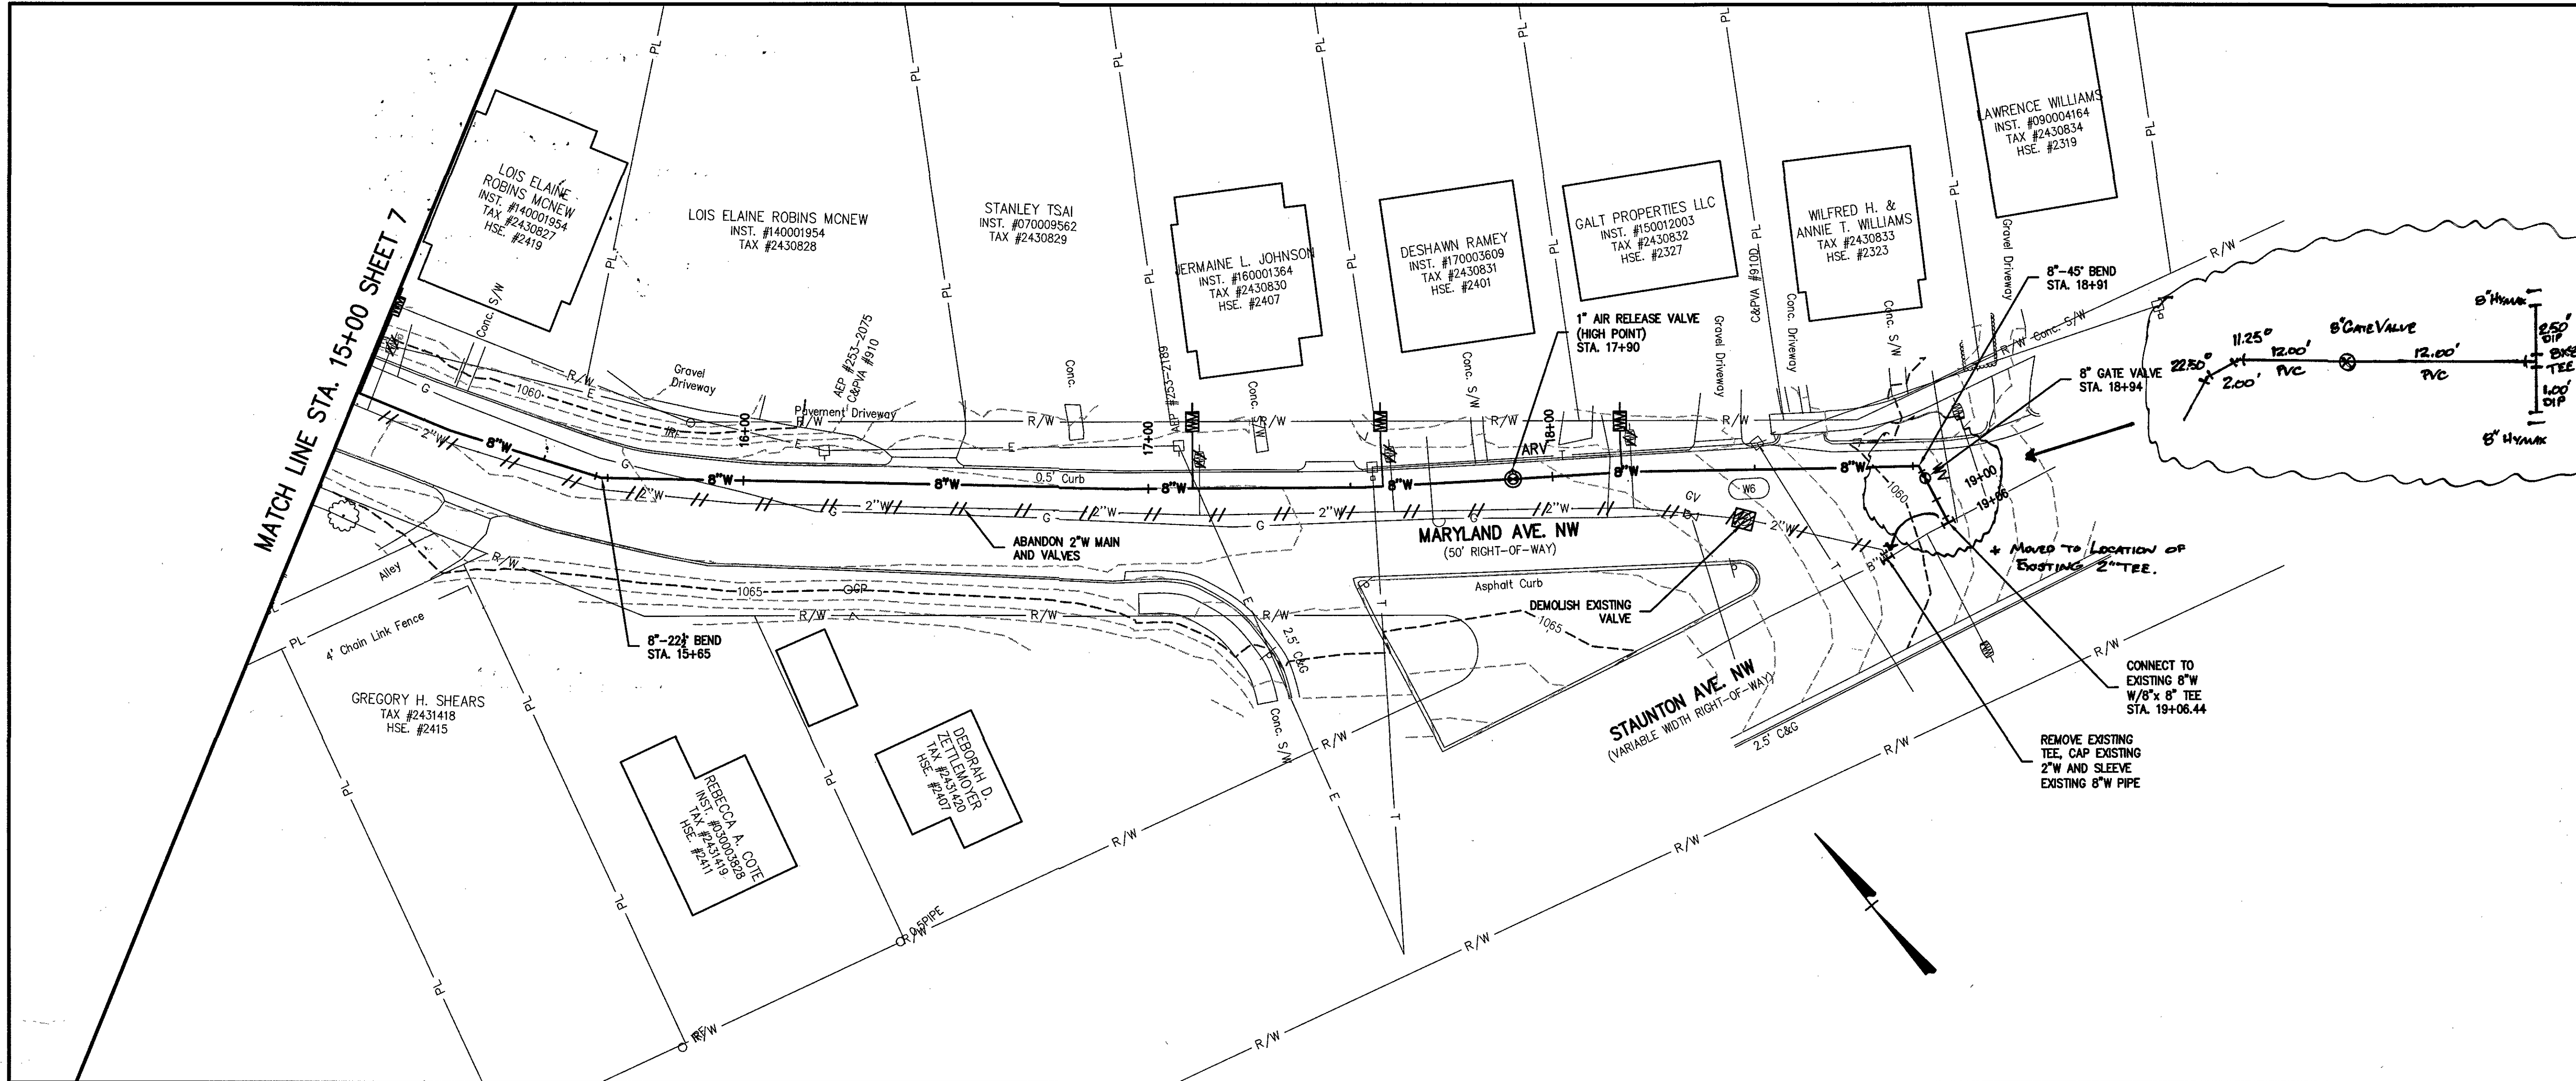

- MATERIALS**
- DIAMOND 8" DR14 C900 PVC
 - AVK 8" Gate Valves
 - ENDOT 1" HDPE SERVICES
 - + Pressure Tested 08-16-18.

NEW YORK AVENUE
WATERLINE REPLACEMENT
PLAN AND PROFILE- 8" WATERLINE
WESTERN VIRGINIA WATER AUTHORITY


Vertical Scale:
1" = 10'

Horizontal Scale:
1" = 20'

Commission Number:
3814

Sheet No.:

8

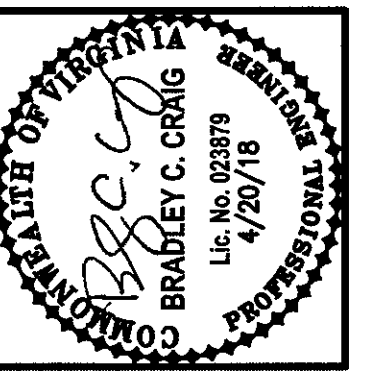

Date	
Revisions	

Issue Date: **APRIL 20, 2018**
Drawn By: ARB
Designed By: DBL
Checked By: BOC
Date: 4/20/18

Mattern & Craig
ENGINEERS/SURVEYORS
701 FIRST STREET, S.W.
ROANOKE, VIRGINIA 24016
(540) 346-9342
FAX (540) 346-7891