



CITY OF ROANOKE, VIRGINIA

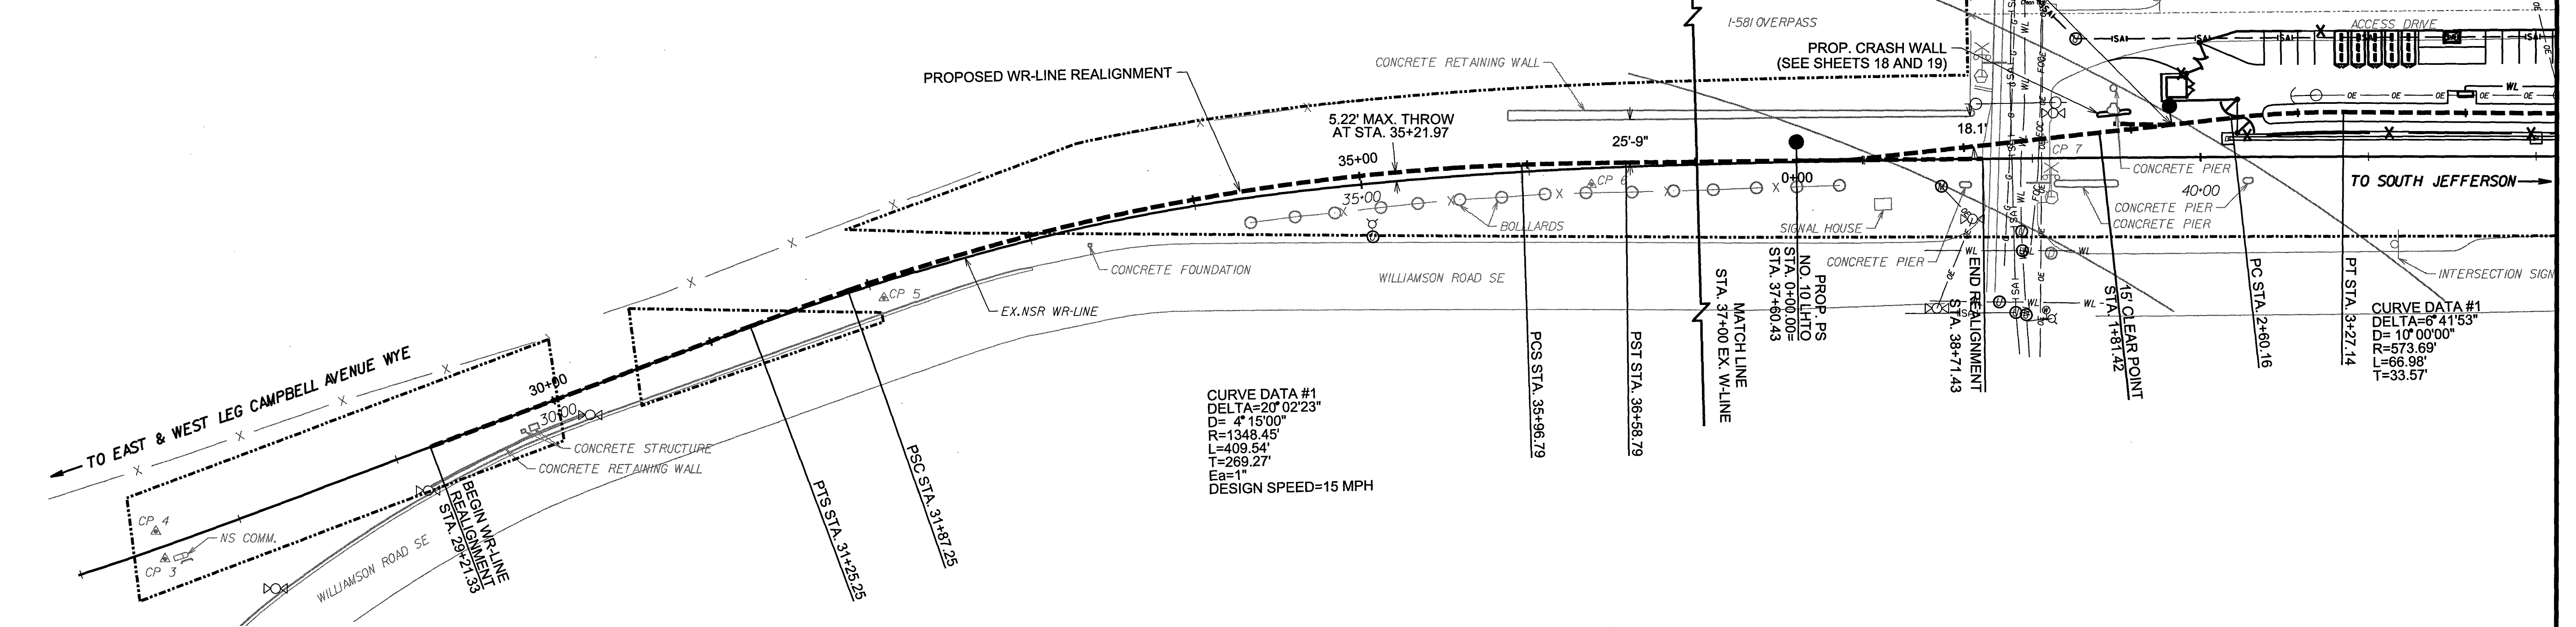


CURVE DATA #1
DELTA=20° 02' 23"
DS=4' 15' 00"
R=1348.45'
L=409.54'
T=269.27'
Ea=1'
DESIGN SPEED=15 MPH

CURVE DATA #1
DELTA=6° 41' 53"
D=10' 00' 00"
R=573.69'
L=66.98'
T=33.57'

 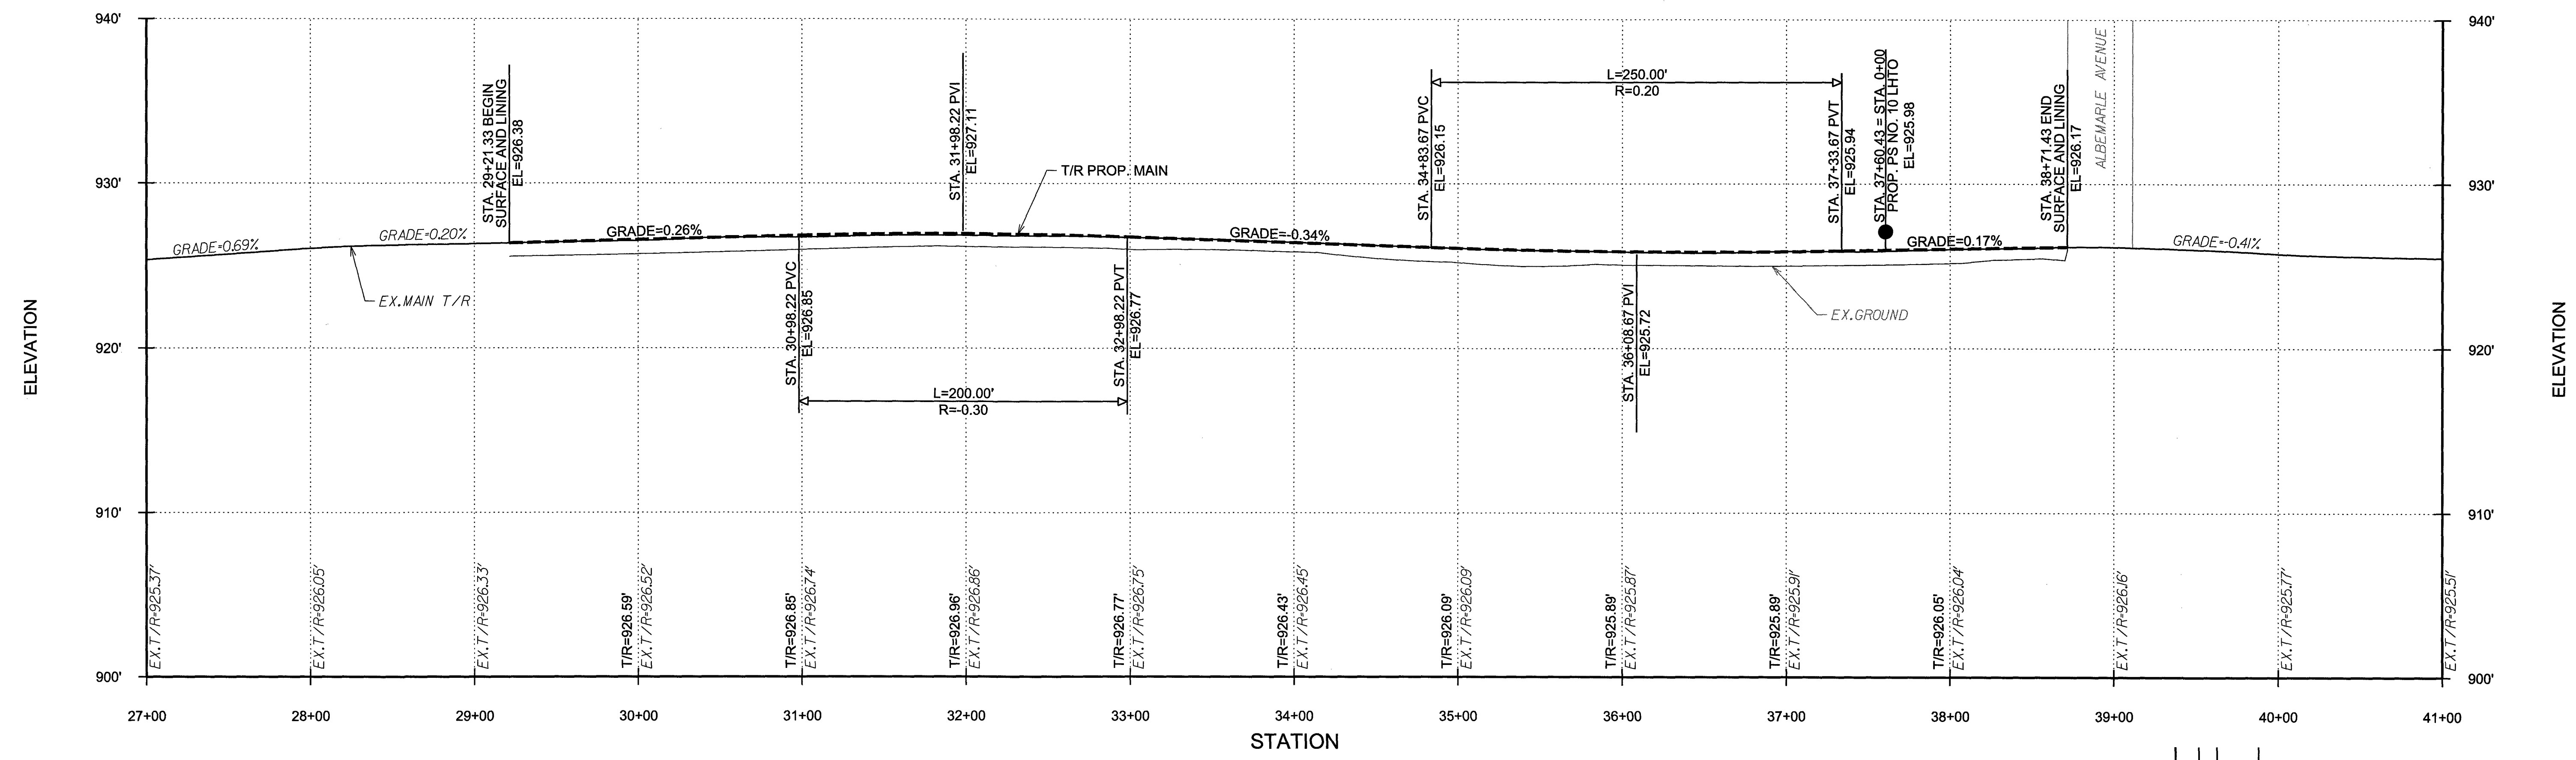


PROJECT NO. 13016
DATE:
DRAWN BY: EVU
CHECKED BY: HAC
REVISIONS:

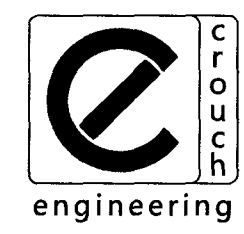

CROUCH ENGINEERING®
428 WILSON PIKE CIRCLE
BRENTWOOD, TN 37027
PHONE NO. (615) 791-0630
COPYRIGHT CROUCH ENGINEERING® ALL RIGHTS RESERVED.
REPRODUCTION AND DISTRIBUTION ONLY UNDER PERMISSION AND LICENSE BY CROUCH ENGINEERING.
FOR PERMISSION, CONTACT HARVEY A. CROUCH.

SCALE: 1" = 50'



POCAHONTAS
OFFICE OF THE CHIEF ENGINEER - DESIGN AND CONSTRUCTION - ATLANTA, GA.

BY: EVU 05/20/18	ADDED DIMENSION TO EXISTING CRASH WALL
REV: 1	DATE: 05/20/18
LOCATION:	ROANOKE, VIRGINIA
TITLE:	PROPOSED SERVING FACILITY - ALBEMARLE AVENUE TRACK PLAN AND PROFILE - STA 27+00 TO 41+00 MAIN LINE
OWN: EVU	FILE NO.: D1940
CHK: BLP	DATE: APRIL 28, 2016
PROJECT NO. 13016	DRAWING NUMBER TD-2015-105-R1
SCALE: 1" = 50'	DATE: APRIL 28, 2016