
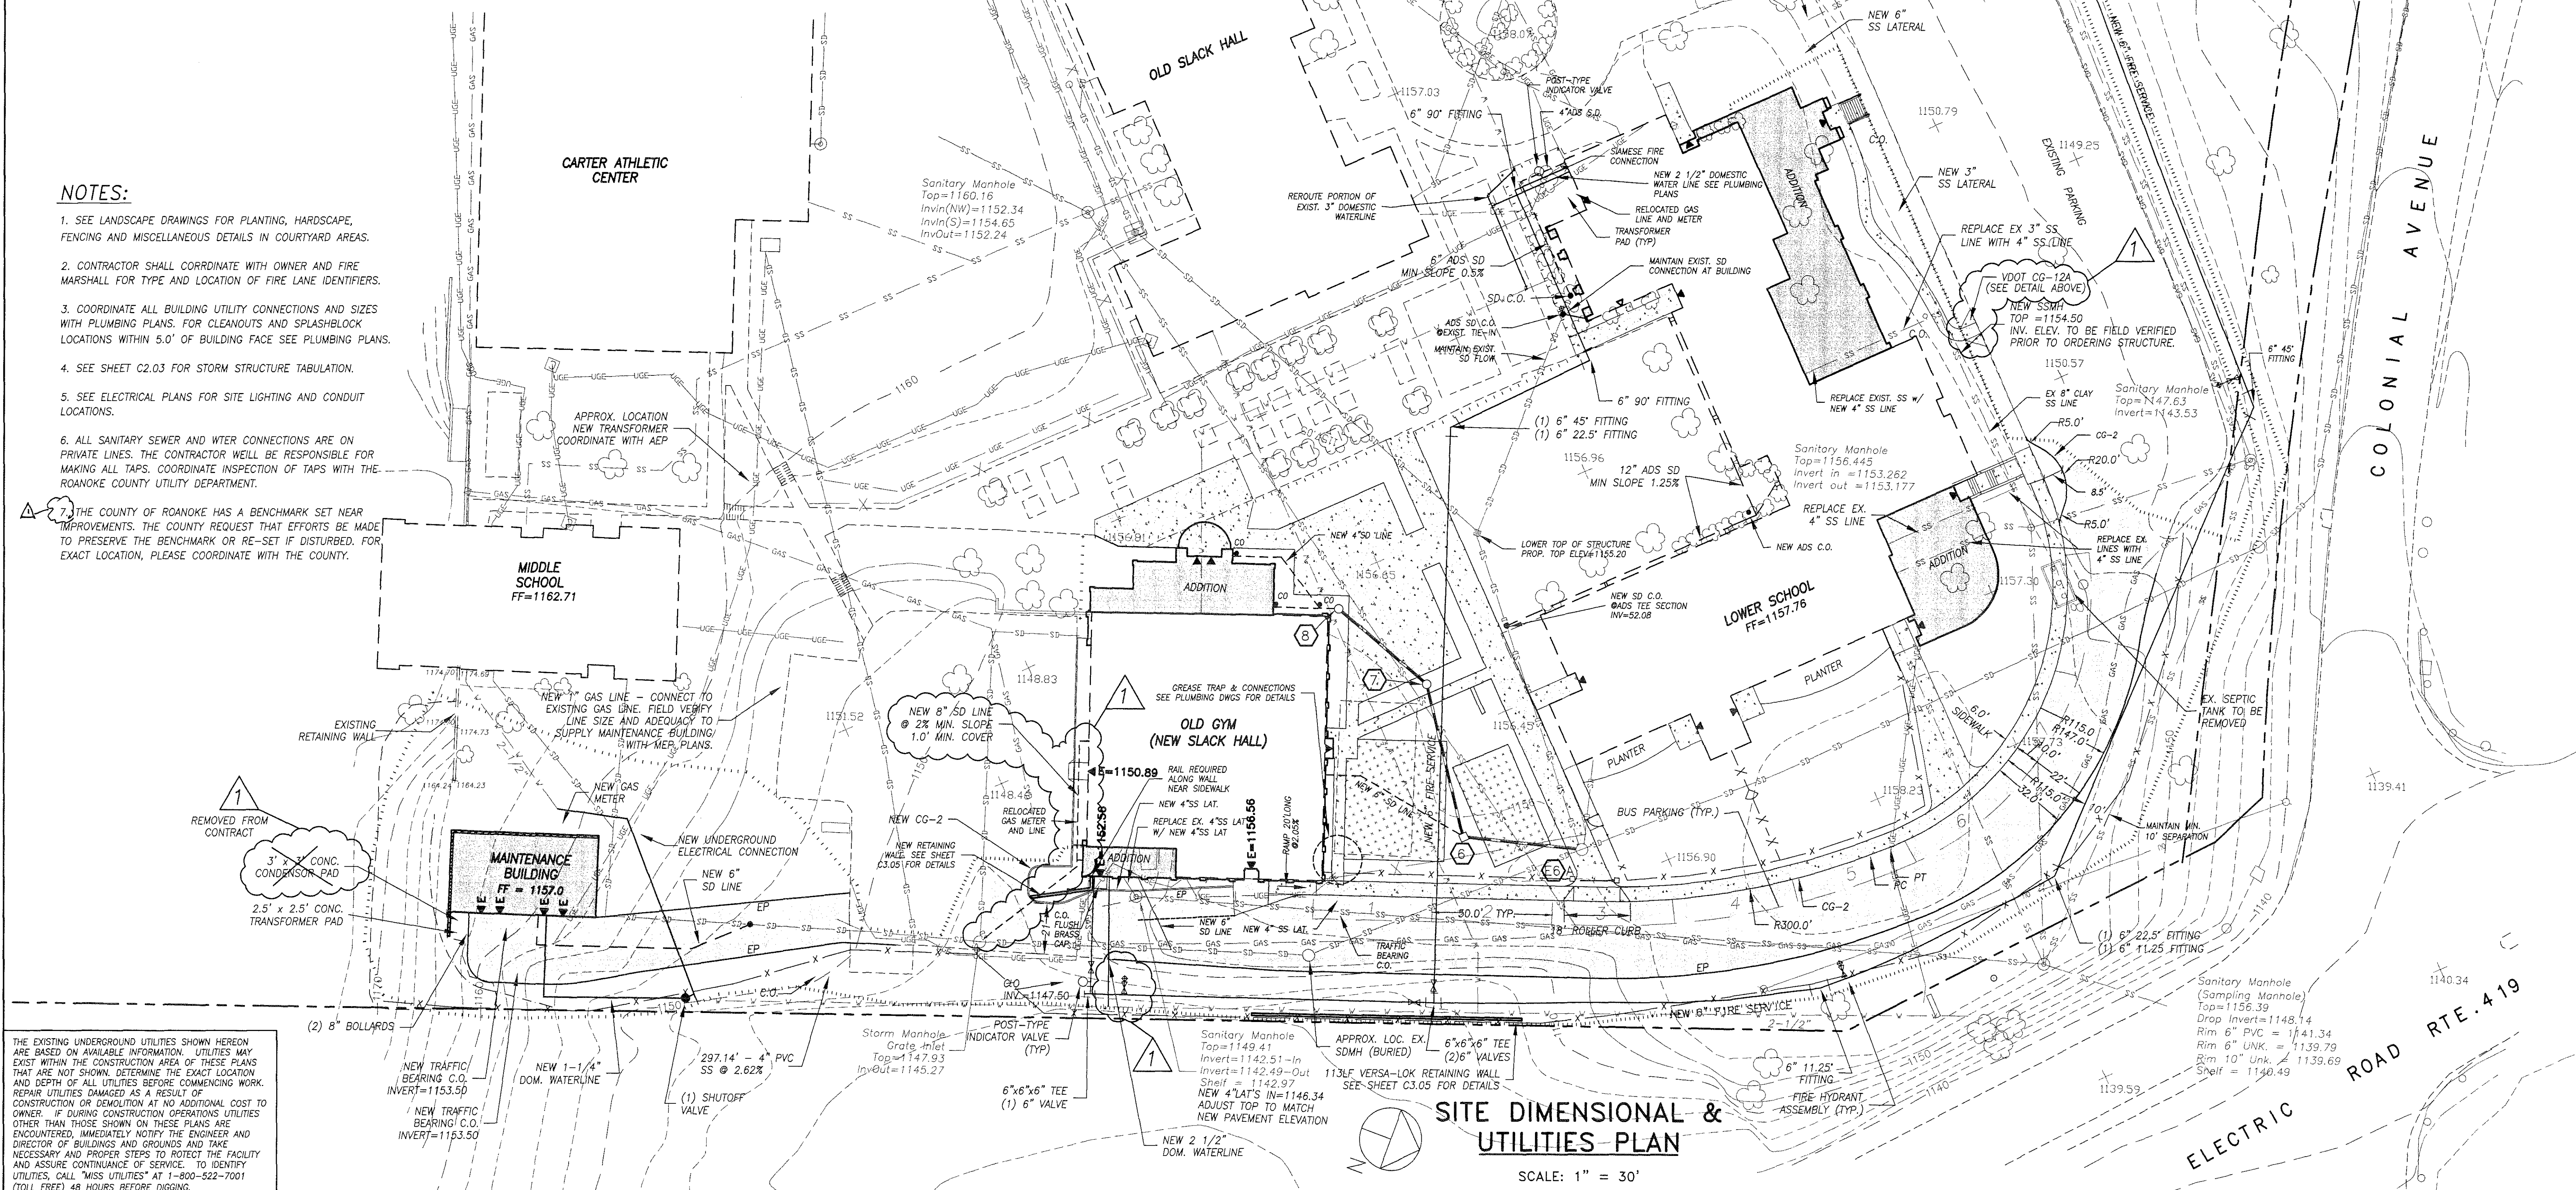


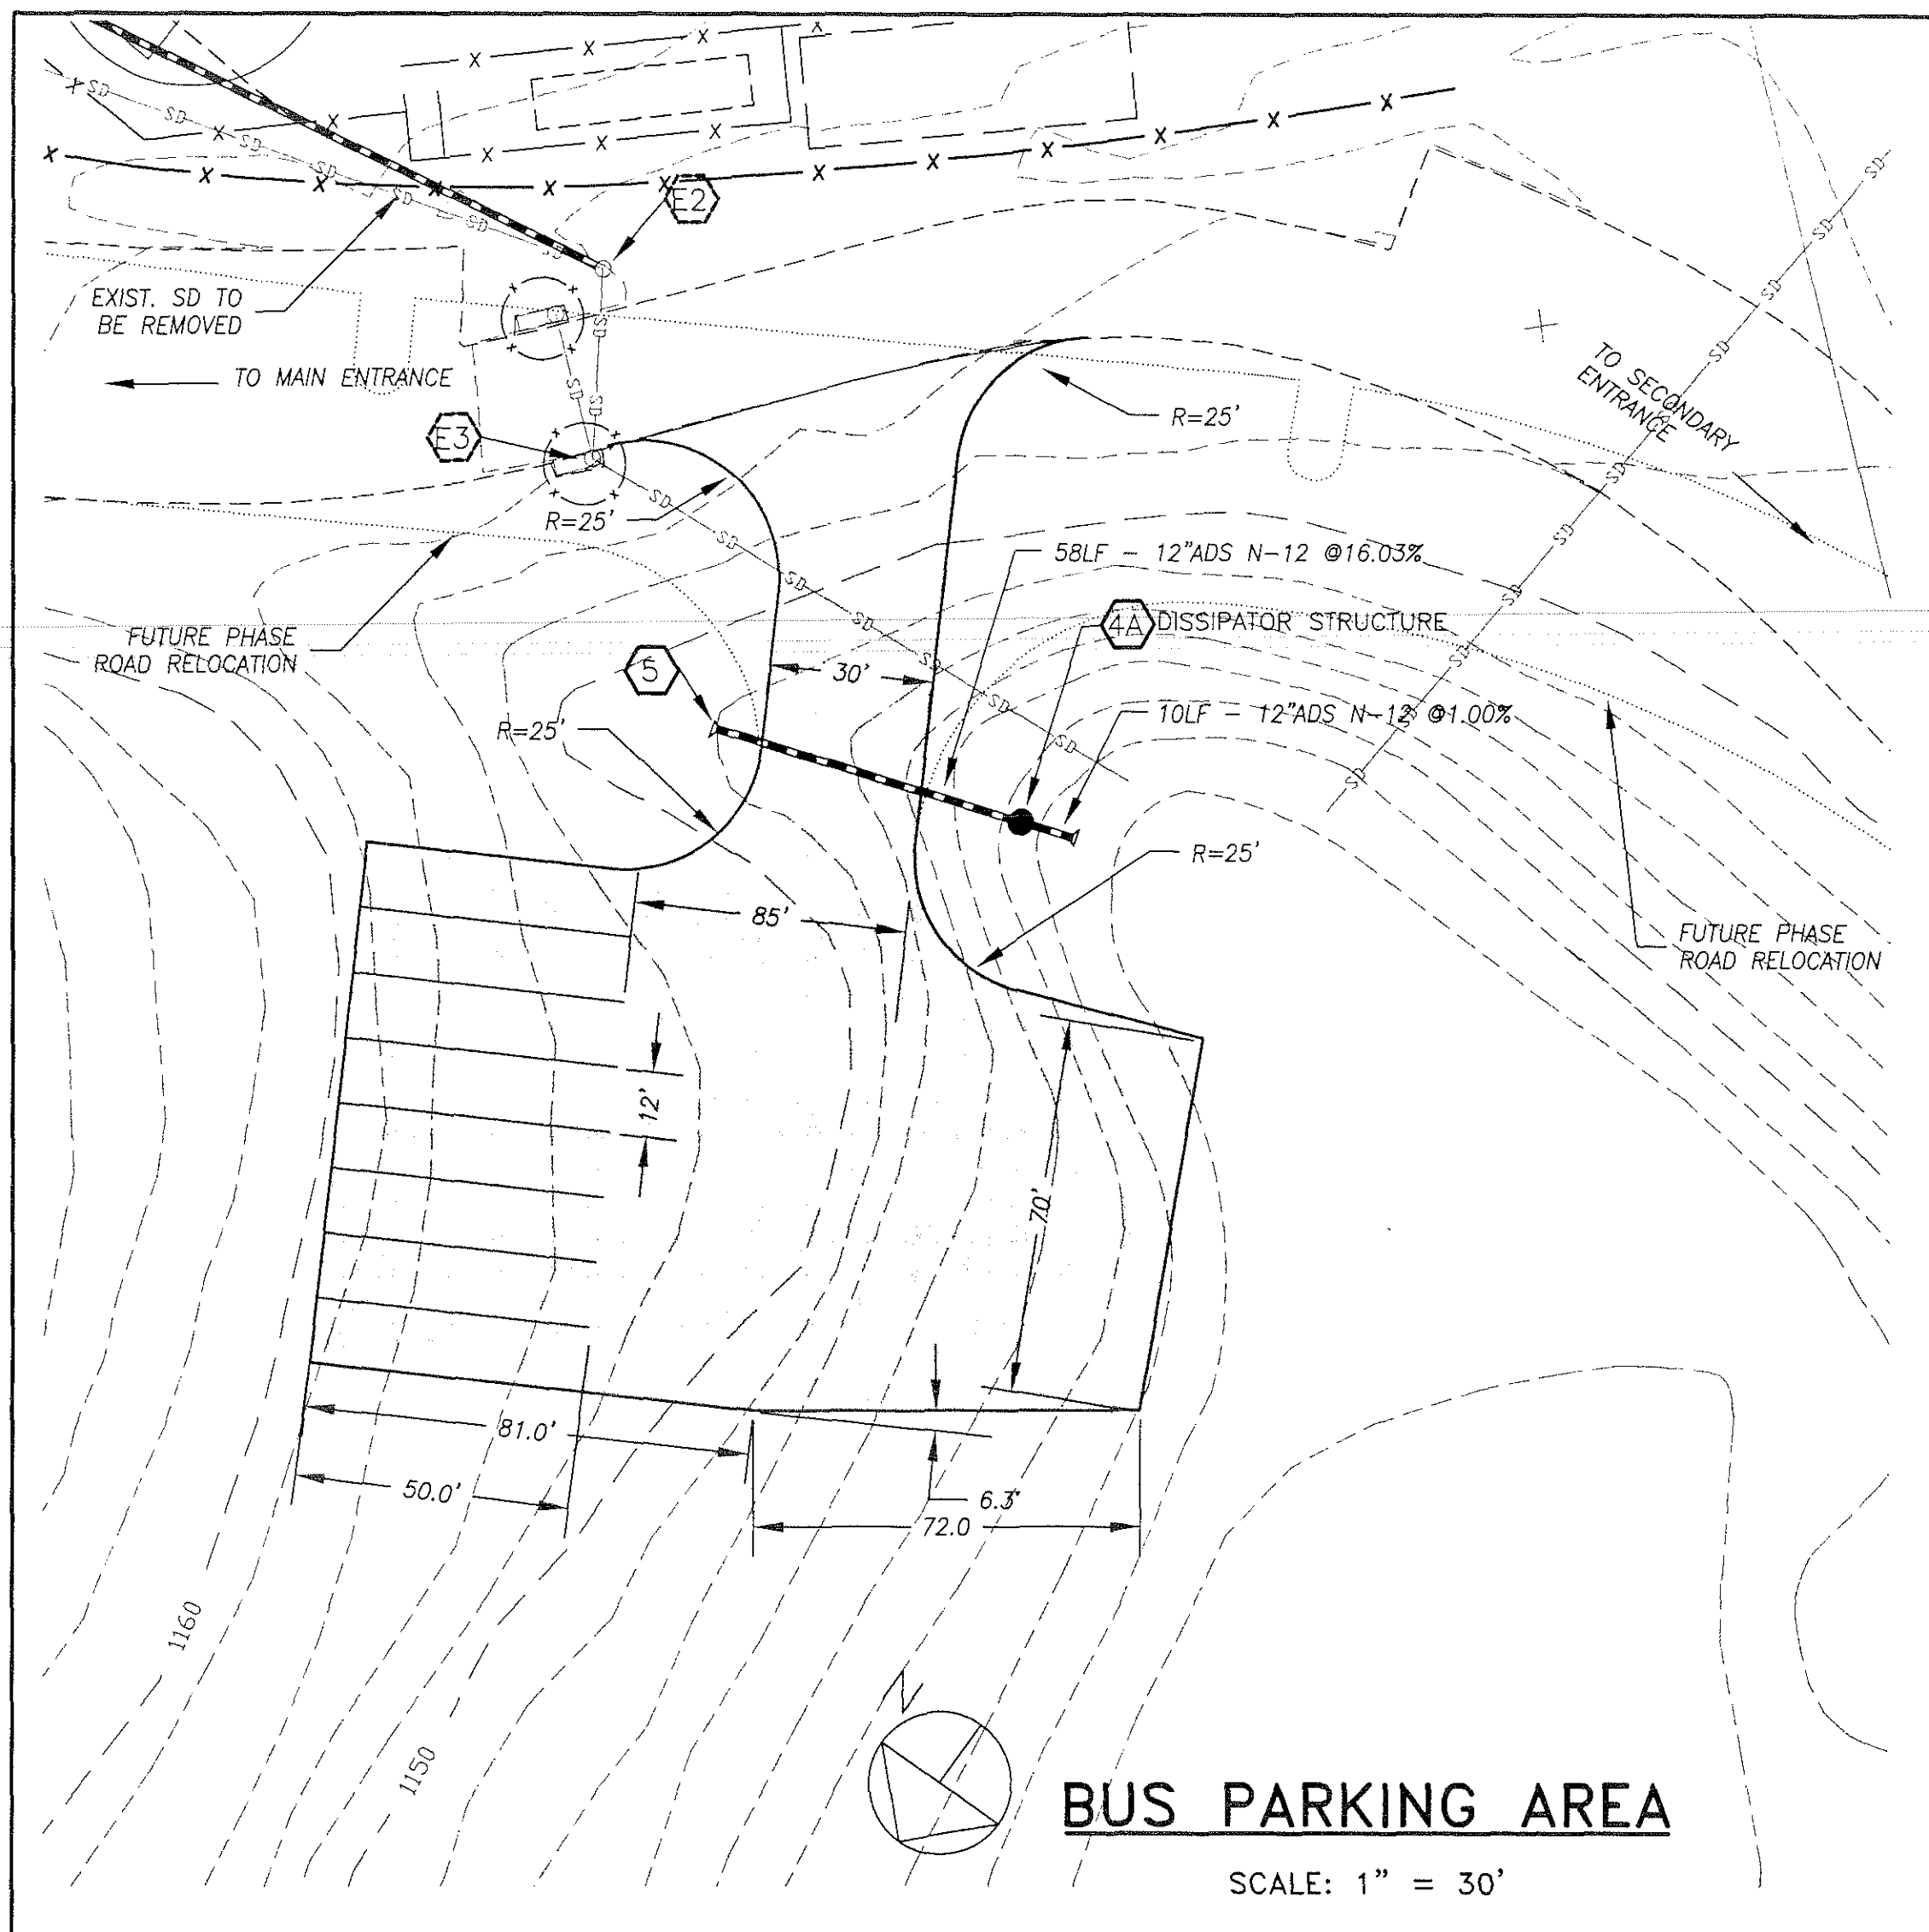

- NOTES:**
1. SEE LANDSCAPE DRAWINGS FOR PLANTING, HARDSCAPE, FENCING AND MISCELLANEOUS DETAILS IN COURTYARD AREAS.
 2. CONTRACTOR SHALL COORDINATE WITH OWNER AND FIRE MARSHALL FOR TYPE AND LOCATION OF FIRE LANE IDENTIFIERS.
 3. COORDINATE ALL BUILDING UTILITY CONNECTIONS AND SIZES WITH PLUMBING PLANS. FOR CLEANOUTS AND SPLASHBLOCK LOCATIONS WITHIN 5.0' OF BUILDING FACE SEE PLUMBING PLANS.
 4. SEE SHEET C2.03 FOR STORM STRUCTURE TABULATION.
 5. SEE ELECTRICAL PLANS FOR SITE LIGHTING AND CONDUIT LOCATIONS.
 6. ALL SANITARY SEWER AND WATER CONNECTIONS ARE ON PRIVATE LINES. THE CONTRACTOR WILL BE RESPONSIBLE FOR MAKING ALL TAPS. COORDINATE INSPECTION OF TAPS WITH THE ROANOKE COUNTY UTILITY DEPARTMENT.
- THE COUNTY OF ROANOKE HAS A BENCHMARK SET NEAR IMPROVEMENTS. THE COUNTY REQUEST THAT EFFORTS BE MADE TO PRESERVE THE BENCHMARK OR RE-SET IF DISTURBED. FOR EXACT LOCATION, PLEASE COORDINATE WITH THE COUNTY.

THE EXISTING UNDERGROUND UTILITIES SHOWN HEREON ARE BASED ON AVAILABLE INFORMATION. UTILITIES MAY EXIST WITHIN THE CONSTRUCTION AREA OF THESE PLANS THAT ARE NOT SHOWN. DETERMINE THE EXACT LOCATION AND DEPTH OF ALL UTILITIES BEFORE COMMENCING WORK. REPAIR UTILITIES DAMAGED AS A RESULT OF CONSTRUCTION OR DEMOLITION AT NO ADDITIONAL COST TO OWNER. IF DURING CONSTRUCTION OPERATIONS UTILITIES OTHER THAN THOSE SHOWN ON THESE PLANS ARE ENCOUNTERED, IMMEDIATELY NOTIFY THE ENGINEER AND DIRECTION OF BUILDINGS AND GROUNDS AND TAKE NECESSARY AND PROPER STEPS TO PROTECT THE FACILITY AND ASSURE CONTINUANCE OF SERVICE. TO IDENTIFY UTILITIES, CALL "MISS UTILITIES" AT 1-800-522-7001 (TOLL FREE) 48 HOURS BEFORE DIGGING.

MOTLEY + ASSOCIATES

ARCHITECTURE
PLANNING
INTERIORS

P.O. BOX 2811 ROANOKE, VA 24010
540-344-1212 FAX 344-1321

ENGINEERING CONCEPTS INC.

20 South Roanoke St.
Fincastle, Virginia 24090
540.473.1253 540.473.1254 (Fax)
email@engineeringconcepts.com

DATE 2/5/01
DRAWN BY MPC/MSM CHECKED BY HTB/ADE
REVISION DATE REVISION DATE
1 02/22/01

NORTH CROSS SCHOOL PHASE I

SITE DESIGN DOCUMENTS

SITE DIMENSIONAL & UTILITIES PLAN

MHA PROJECT NO. 0001500 SHEET NO. C2.02