



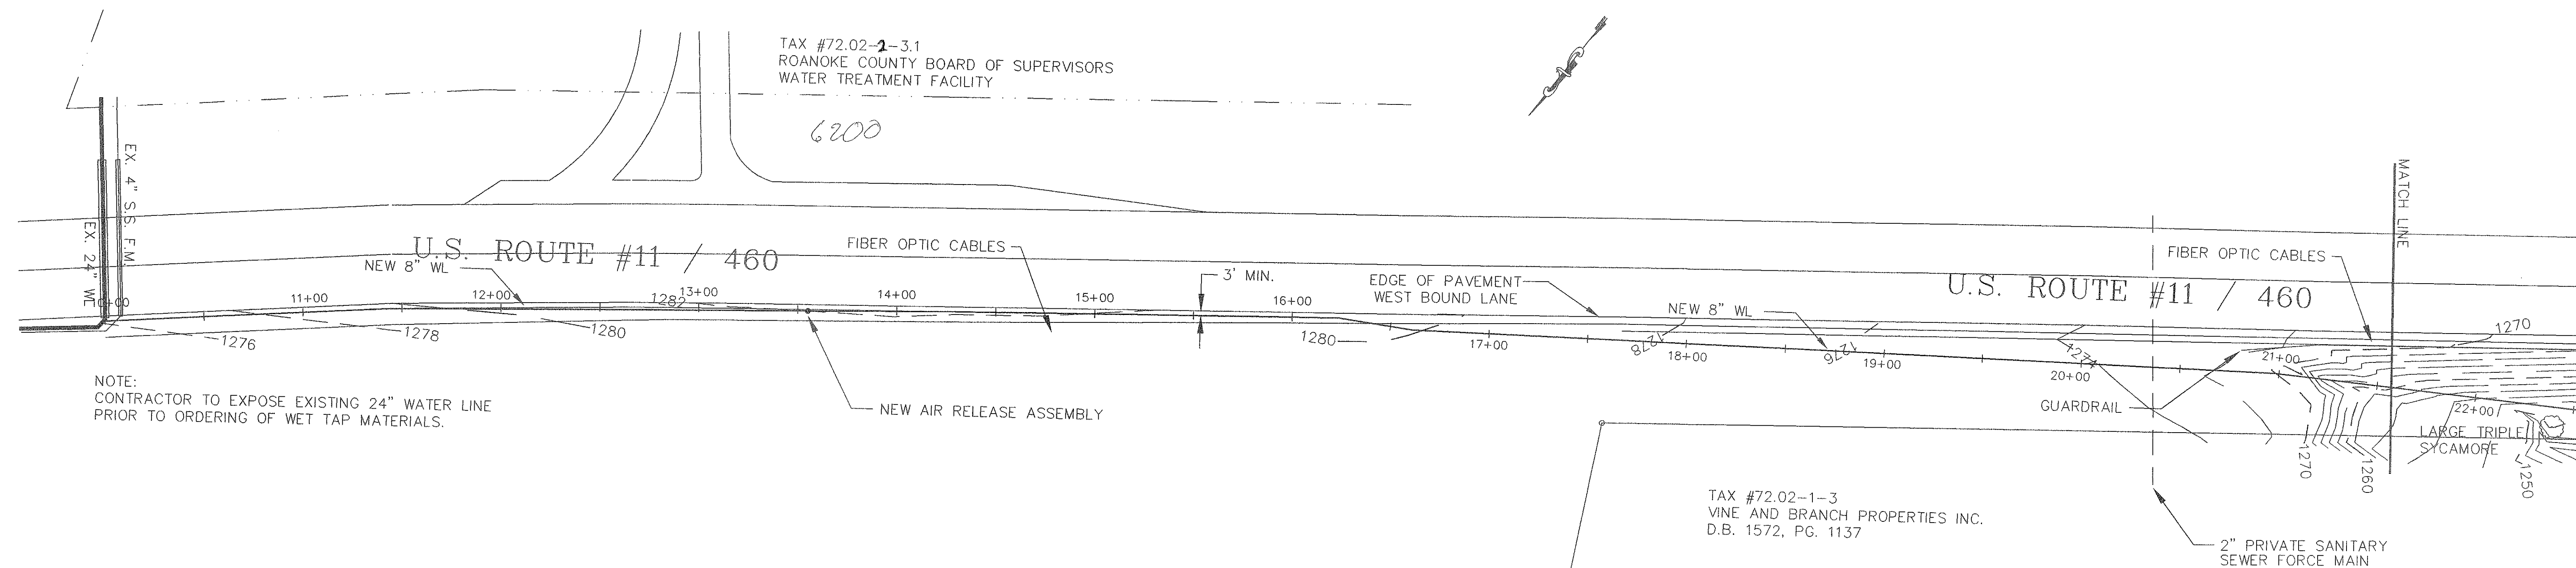

PLAN
SCALE: 1"=40'

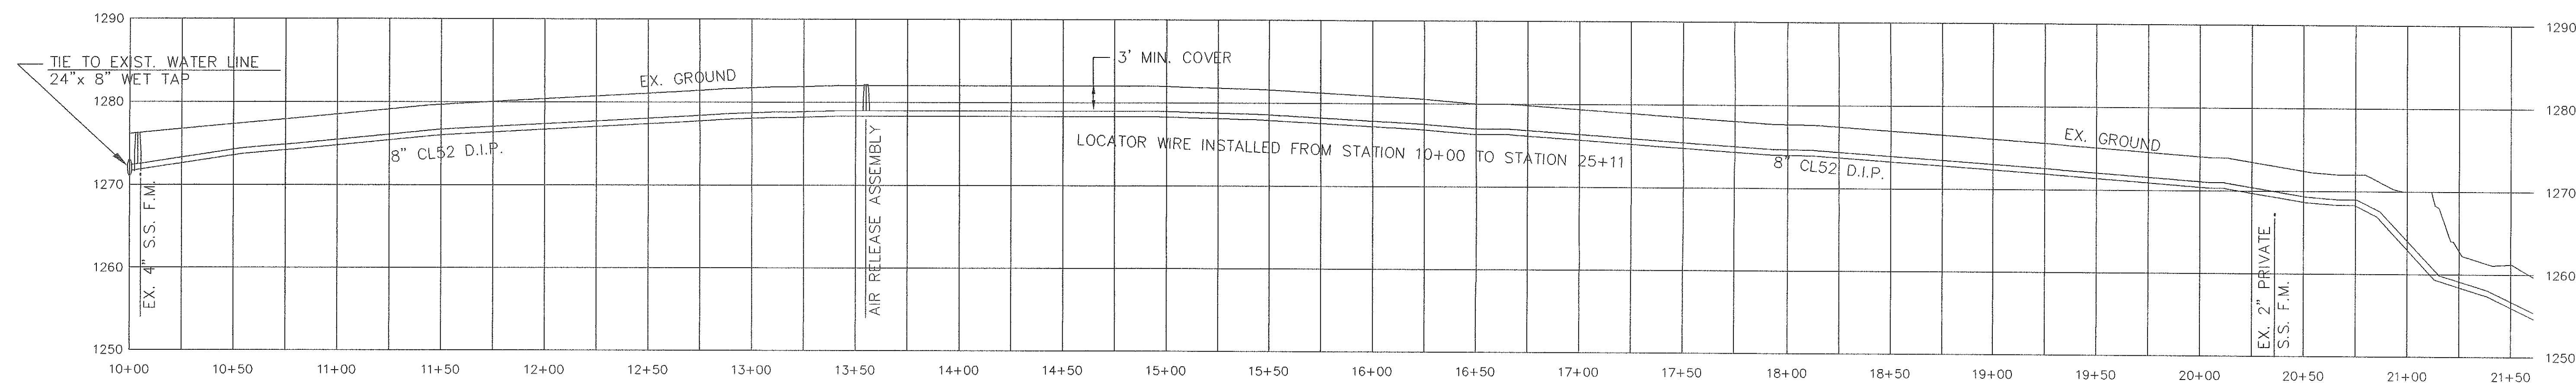

PROFILE
SCALE:
HORZ.: 1"=40'
VERT.: 1"=10'

NOTE:
ALL WORK TO BE PERFORMED IN COMPLIANCE WITH ROANOKE COUNTY WATER AND SEWER REGULATIONS, 2nd ED.
ALL FRAME & COVERS IN VDOT RIGHT-OF-WAY SHALL BE INSTALLED 2" BELOW FINISHED GRADE.
LOCATOR WIRE INSTALLED FROM STATION 10+00 TO STATION 25+11


AS-BUILT DRAWING
MAY 15, 2001

SHEET 1 OF 4

PLAN AND PROFILE FOR
CAMPBELL HILLS
WATER LINE
EXTENSION PROJECT

CATAWBA MAGISTERIAL DISTRICT
ROANOKE COUNTY, VIRGINIA

DRAWN BY: R.C.F.
DESIGNED BY: R.C.F.
CHECKED BY:
DATE: AUGUST 20, 2009
SCALE: AS SHOWN

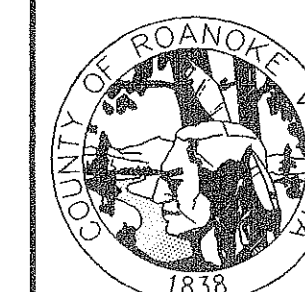

ROANOKE COUNTY
UTILITY DEPARTMENT
1206 KESSLER MILL ROAD
SALEM, VA 24153

G:\DRAWINGS\BROWNA\AS-BUILT