
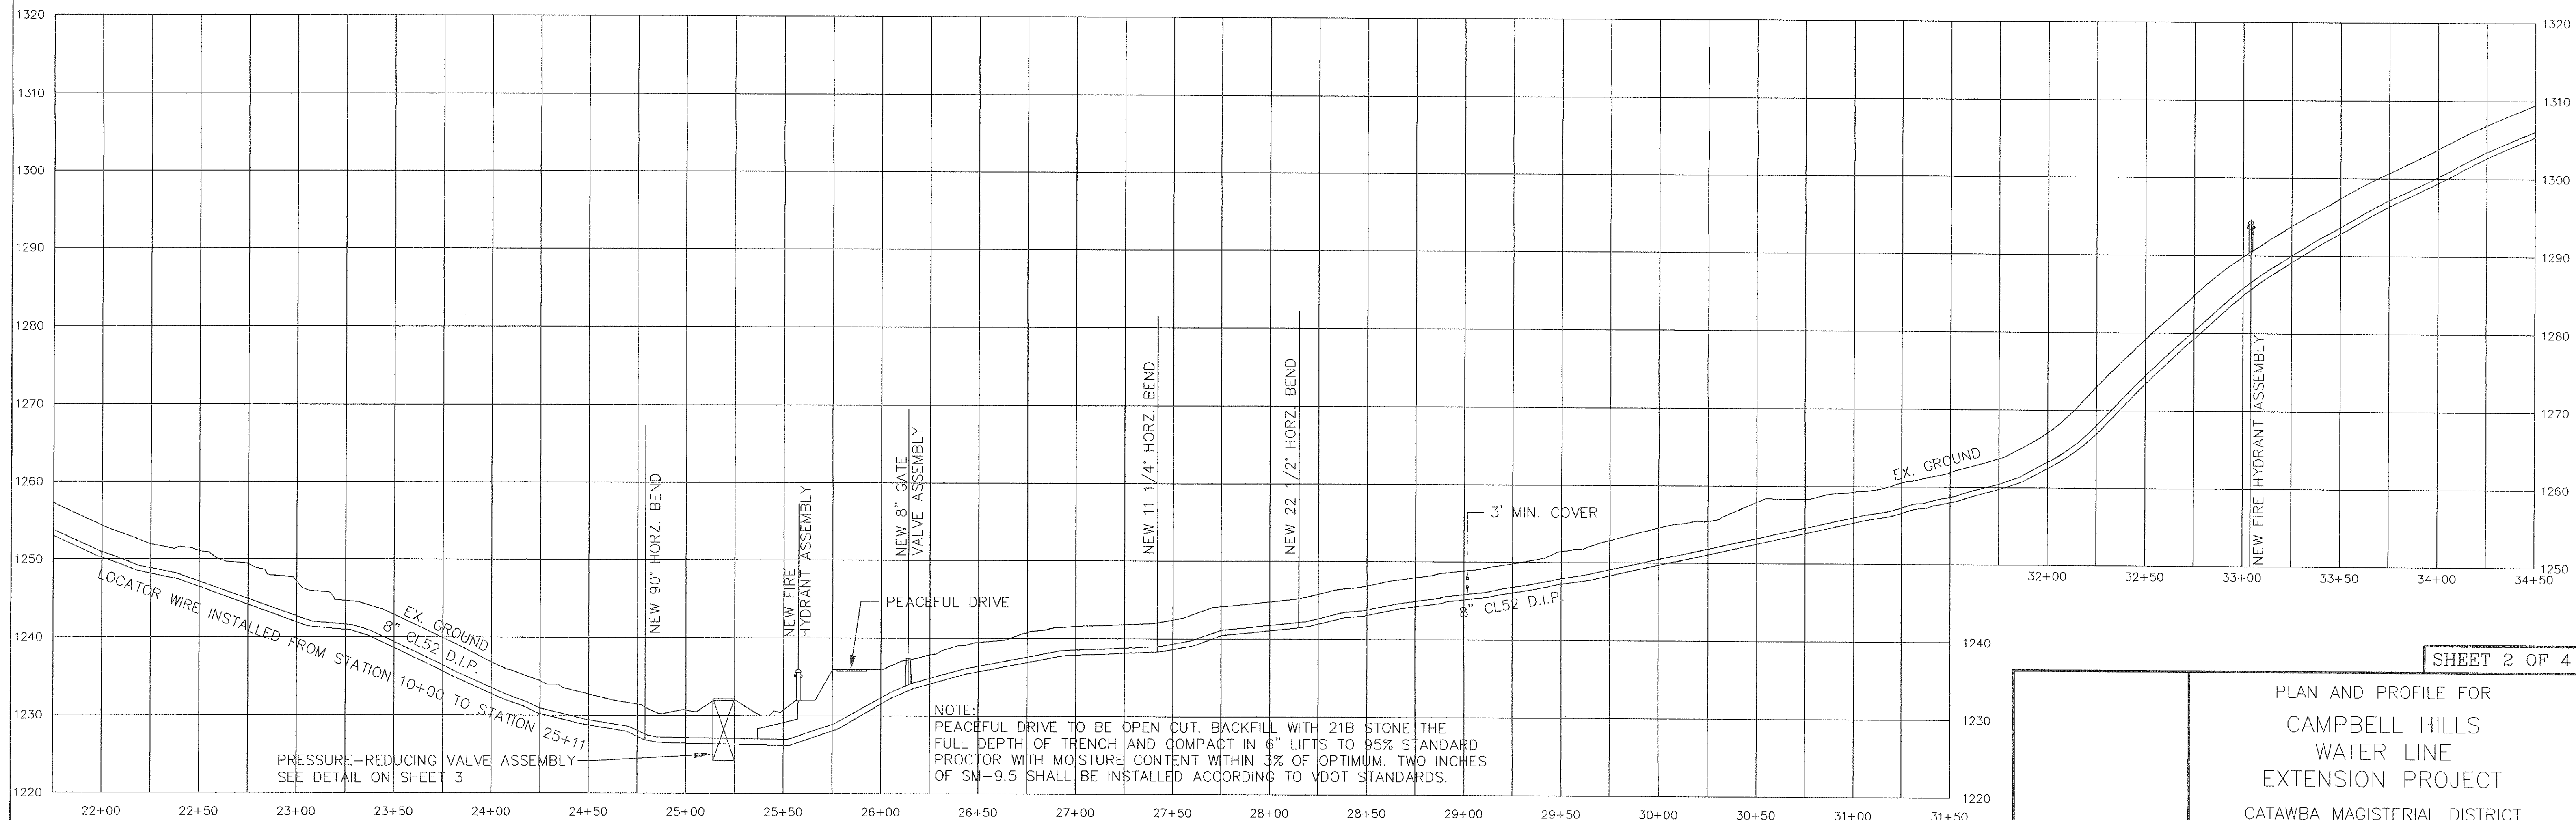
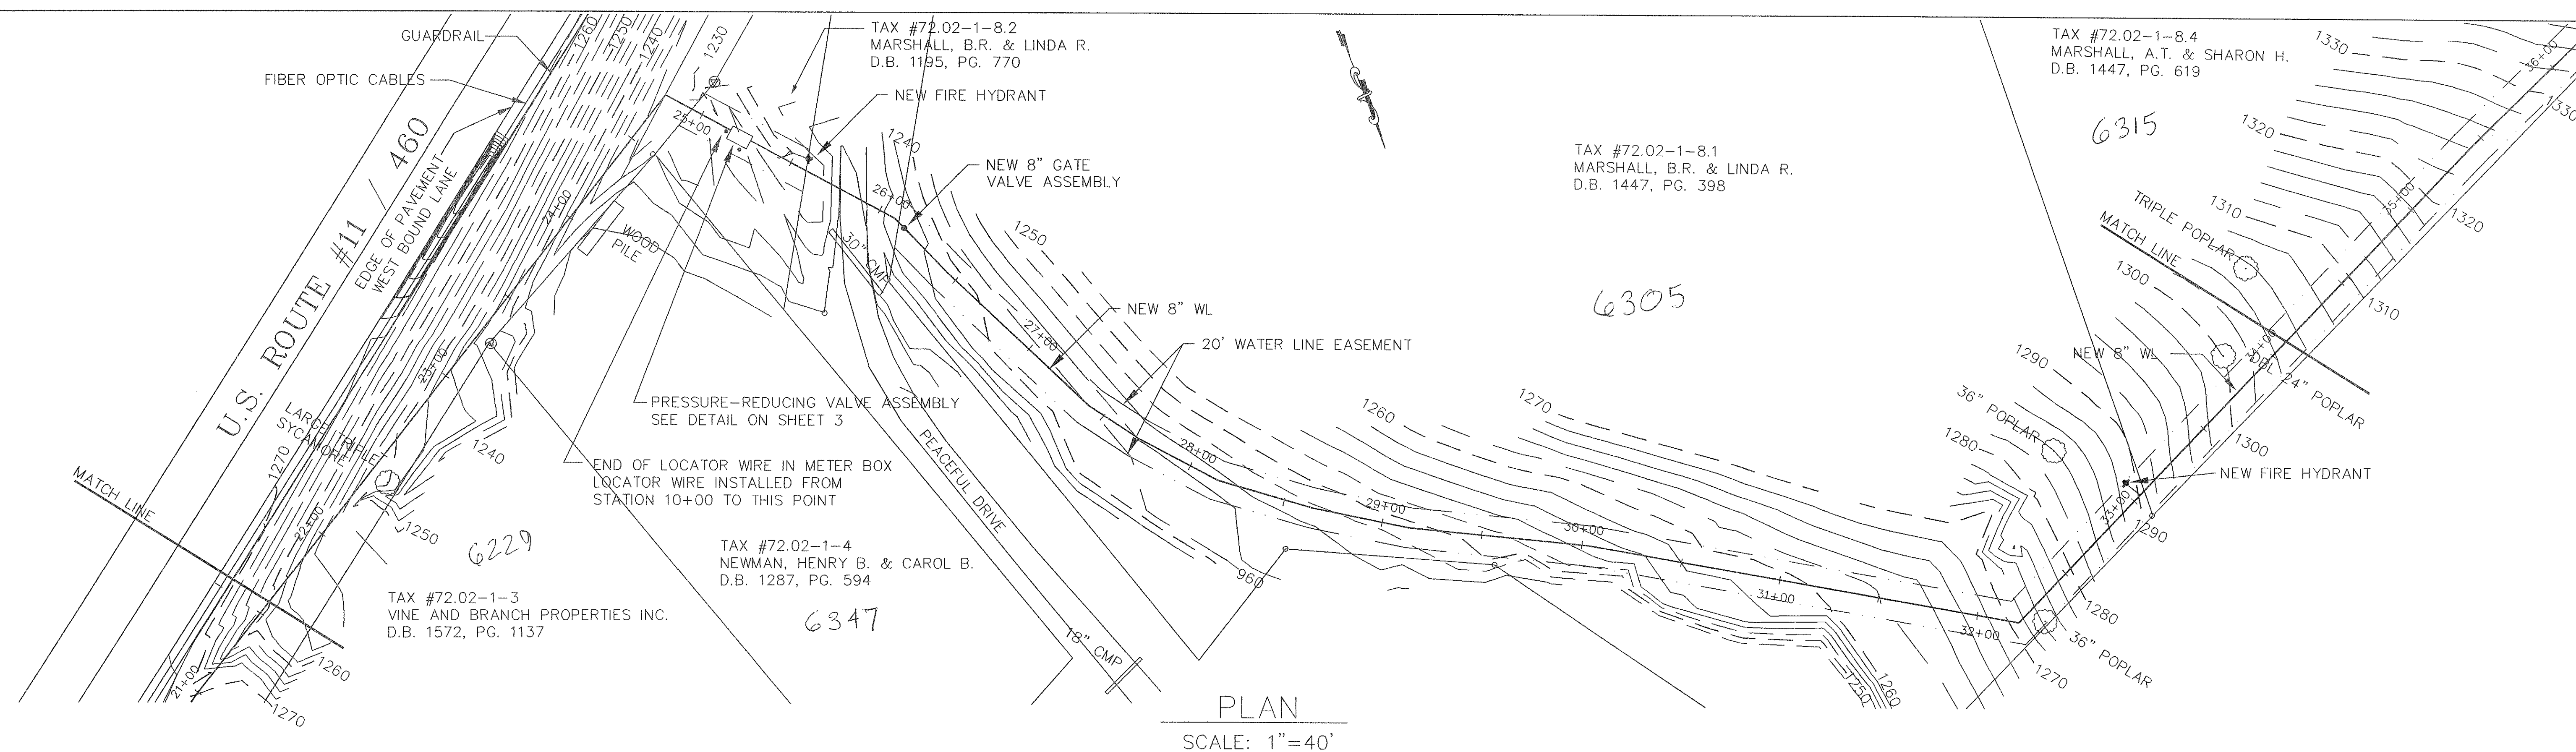


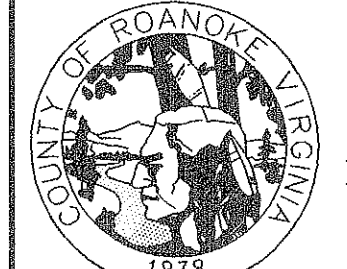

NOTE:
ALL WORK TO BE PERFORMED IN COMPLIANCE WITH ROANOKE COUNTY WATER AND SEWER REGULATIONS, 2nd ED.
ALL FRAME & COVERS IN VDOT RIGHT-OF-WAY SHALL BE INSTALLED 2" BELOW FINISHED GRADE.

PROFILE
SCALE:
HORZ.: 1"=40'
VERT.: 1"=10'

AS-BUILT DRAWING
MAY 15, 2001

SHEET 2 OF 4	
PLAN AND PROFILE FOR CAMPBELL HILLS WATER LINE EXTENSION PROJECT CATAWBA MAGISTERIAL DISTRICT ROANOKE COUNTY, VIRGINIA	
DRAWN BY: R.C.F. DESIGNED BY: R.C.F. CHECKED BY: DATE: AUGUST 20, 2000 SCALE: AS SHOWN	 ROANOKE COUNTY UTILITY DEPARTMENT 1206 KESSLER MILL ROAD SALEM, VA 24153