

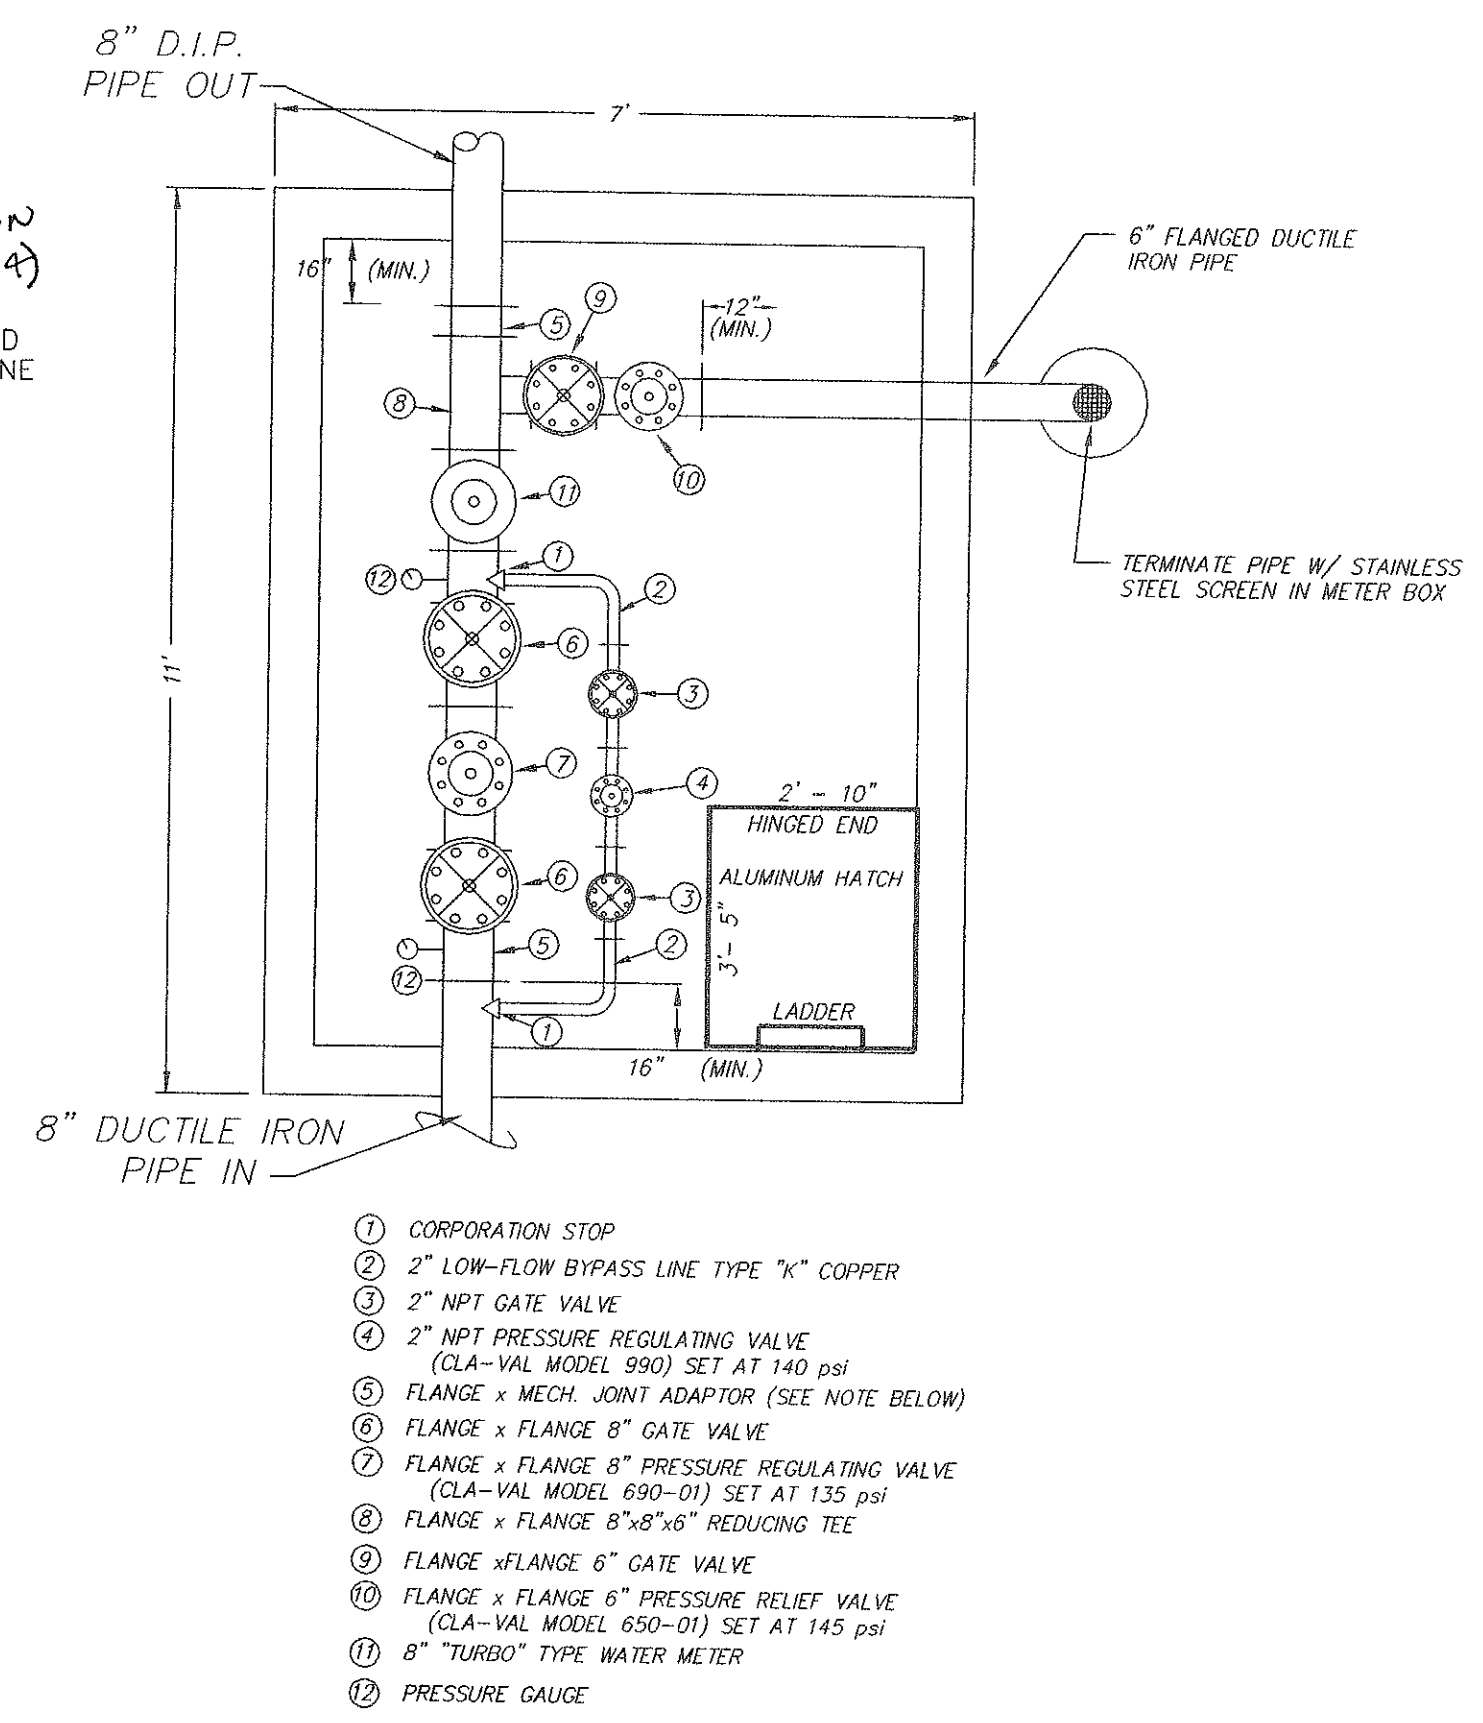


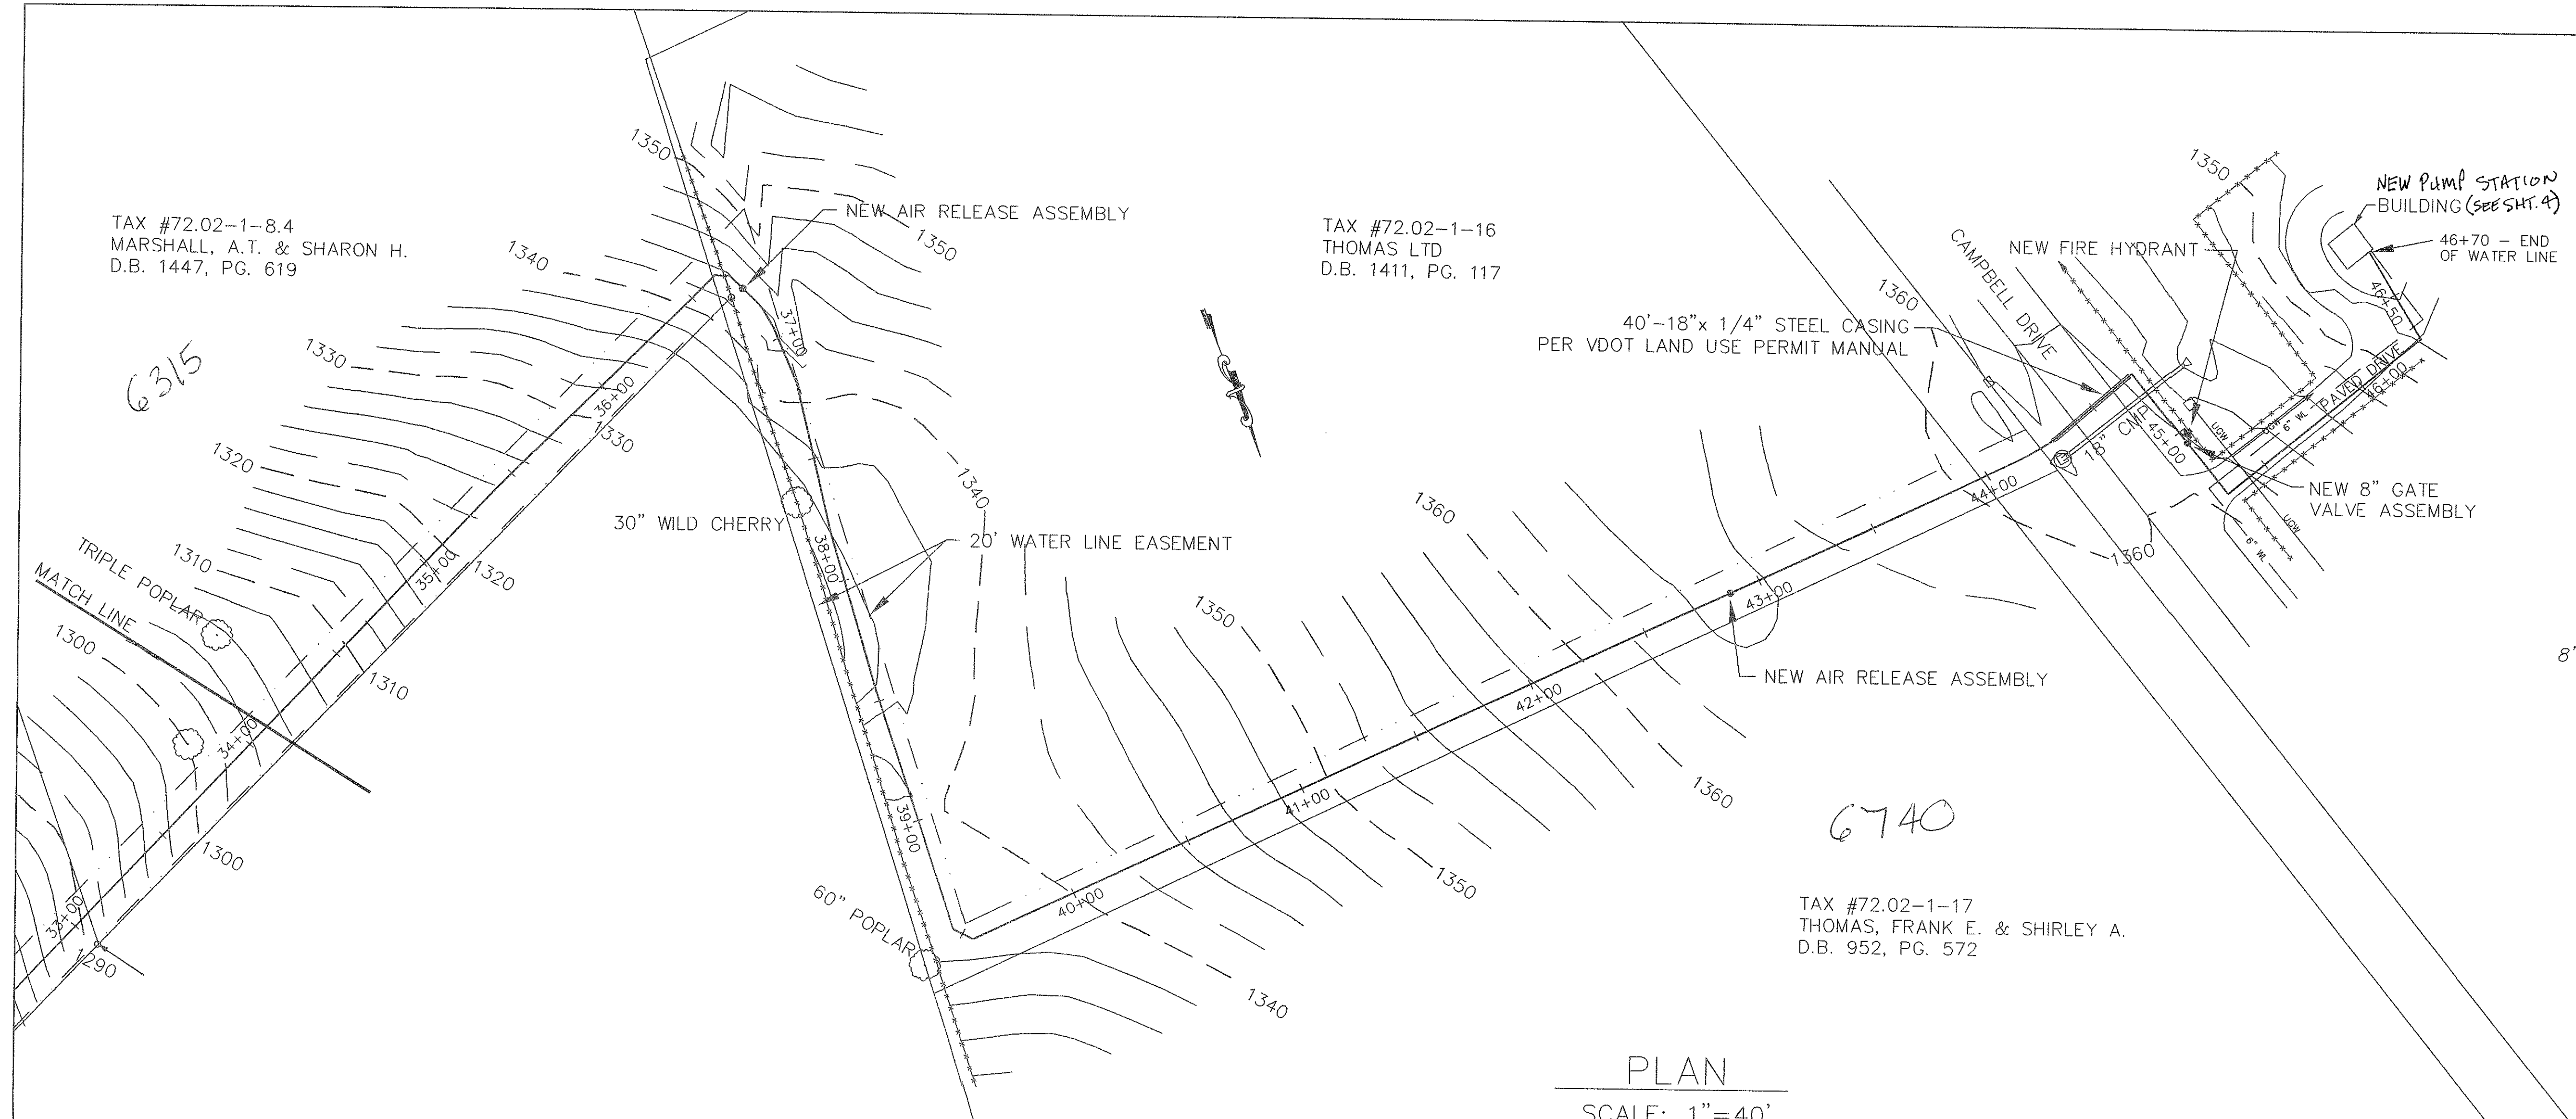

PRESSURE-REDUCING VALVE ASS'Y.
& PRECAST CONCRETE WATER VAULT
NO SCALE

PLAN
SCALE: 1"=40'

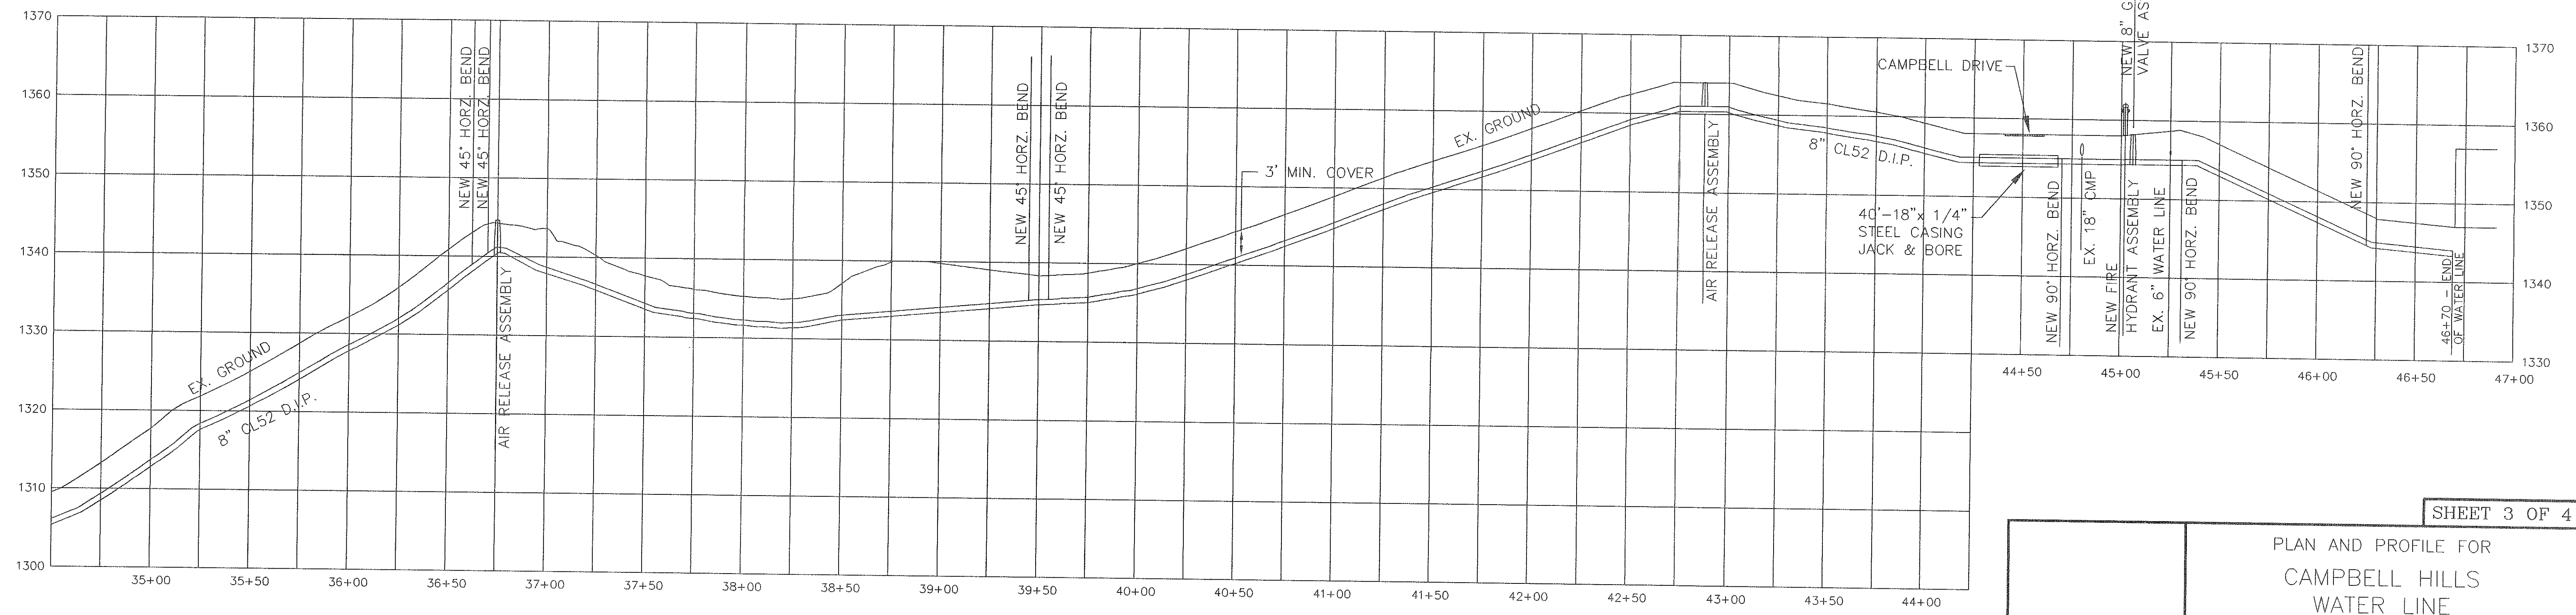

PROFILE
SCALE:
HORZ.: 1"=40'
VERT.: 1"=10'

NOTE:
ALL WORK TO BE PERFORMED IN COMPLIANCE WITH ROANOKE COUNTY WATER AND SEWER REGULATIONS, 2nd ED.
ALL FRAME & COVERS IN VDOT RIGHT-OF-WAY SHALL BE INSTALLED 2" BELOW FINISHED GRADE.

AS-BUILT DRAWING
MAY 15, 2001

SHEET 3 OF 4

PLAN AND PROFILE FOR
CAMPBELL HILLS
WATER LINE
EXTENSION PROJECT
CATAWBA MAGISTERIAL DISTRICT
ROANOKE COUNTY, VIRGINIA


DRAWN BY: R.C.F.

DESIGNED BY: R.C.F.

CHECKED BY:

DATE: AUGUST 20, 2000

SCALE: AS SHOWN

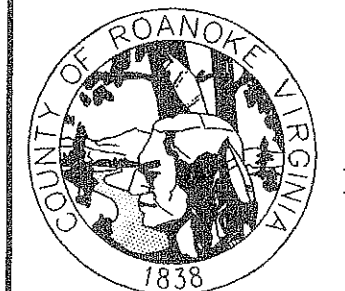

ROANOKE COUNTY
UTILITY DEPARTMENT
1206 KESSLER MILL ROAD
SALEM, VA 24153