


SEWER & WATER EXTENSION FOR **CENTER FOR RESEARCH AND TECHNOLOGY**

SITUATED IN
CATAWBA MAGISTERIAL DISTRICT
ROANOKE COUNTY, VIRGINIA

DATE: 26 JANUARY 2001

PREPARED FOR
THE COUNTY OF ROANOKE, VIRGINIA

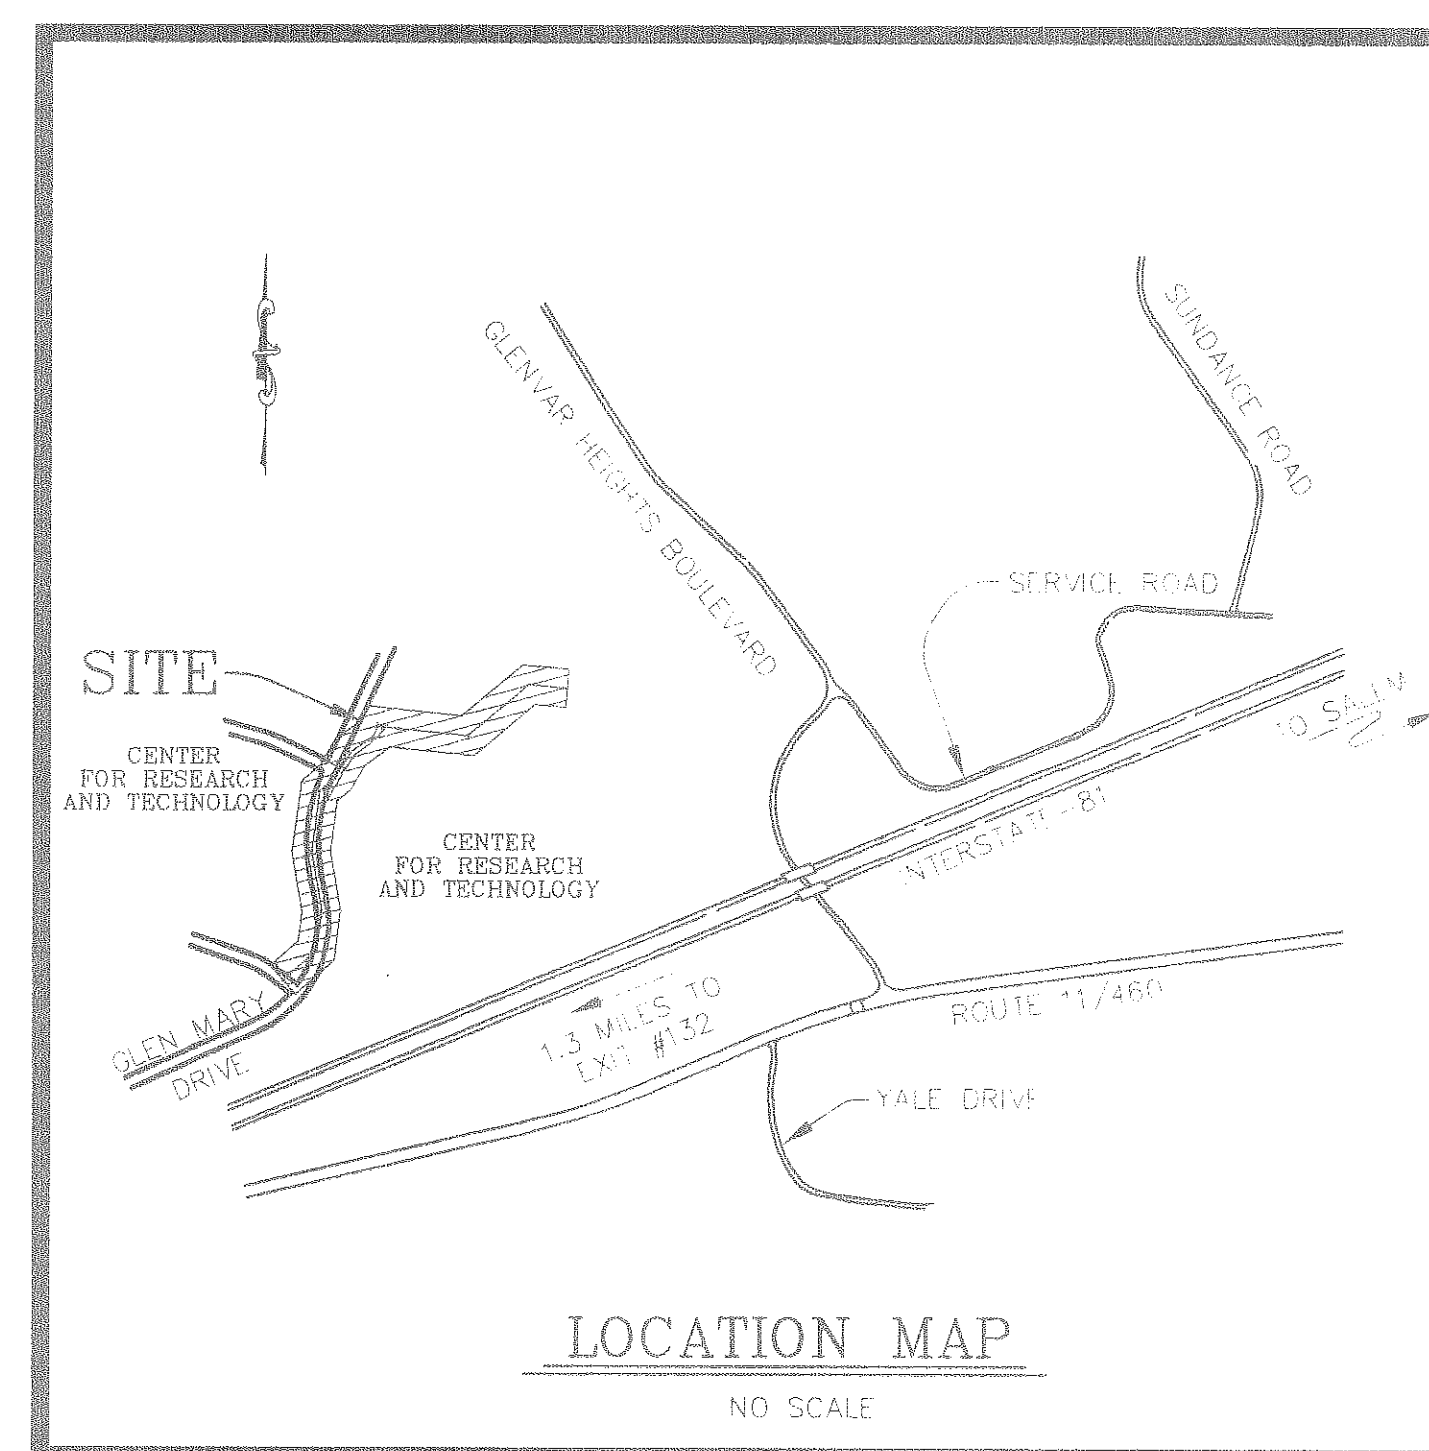

INDEX OF DRAWINGS

SHEET No.	DESCRIPTION
1.	LUMSDEN ASSOCIATES COVER SHEET
2.	SHEET LAYOUT
3.	SEWER PLAN & PROFILES
4.	SEWER PLAN & PROFILES
5.	WATER PLAN & PROFILES
6.	EROSION CONTROL PLAN
7.	SEWER DETAILS
8.	WATER DETAILS
9.	EROSION CONTROL DETAILS

LUMSDEN ASSOCIATES, P.C.
ENGINEERS-SURVEYORS-PLANNERS
ROANOKE, VIRGINIA

LUMSDEN ASSOCIATES, P.C.
ENGINEERS-SURVEYORS-PLANNERS
ROANOKE, VIRGINIA

4664 BRAMBLETON AVENUE
P.O. BOX 20869
ROANOKE, VIRGINIA 24018

PHONE (540) 774-4411
FAX (540) 772-9445
E-MAIL LUMSDENPC@AOL.COM



REV	DATE	REMARKS
5		
4		
3		
2		
1		

COVER
SHEET

SEWER & WATER EXTENSION
CENTER FOR RESEARCH
AND TECHNOLOGY
PREPARED FOR
THE COUNTY OF ROANOKE, VIRGINIA
CATAWBA MAGISTERIAL DISTRICT
ROANOKE COUNTY, VIRGINIA

DATE: 26 JANUARY 2001
COMMISSION NO.: *00-231
CADD FILE: \\ARDV0221\ENGIN\0221_CVR_GLDWG
SHEET NO.

1/9