
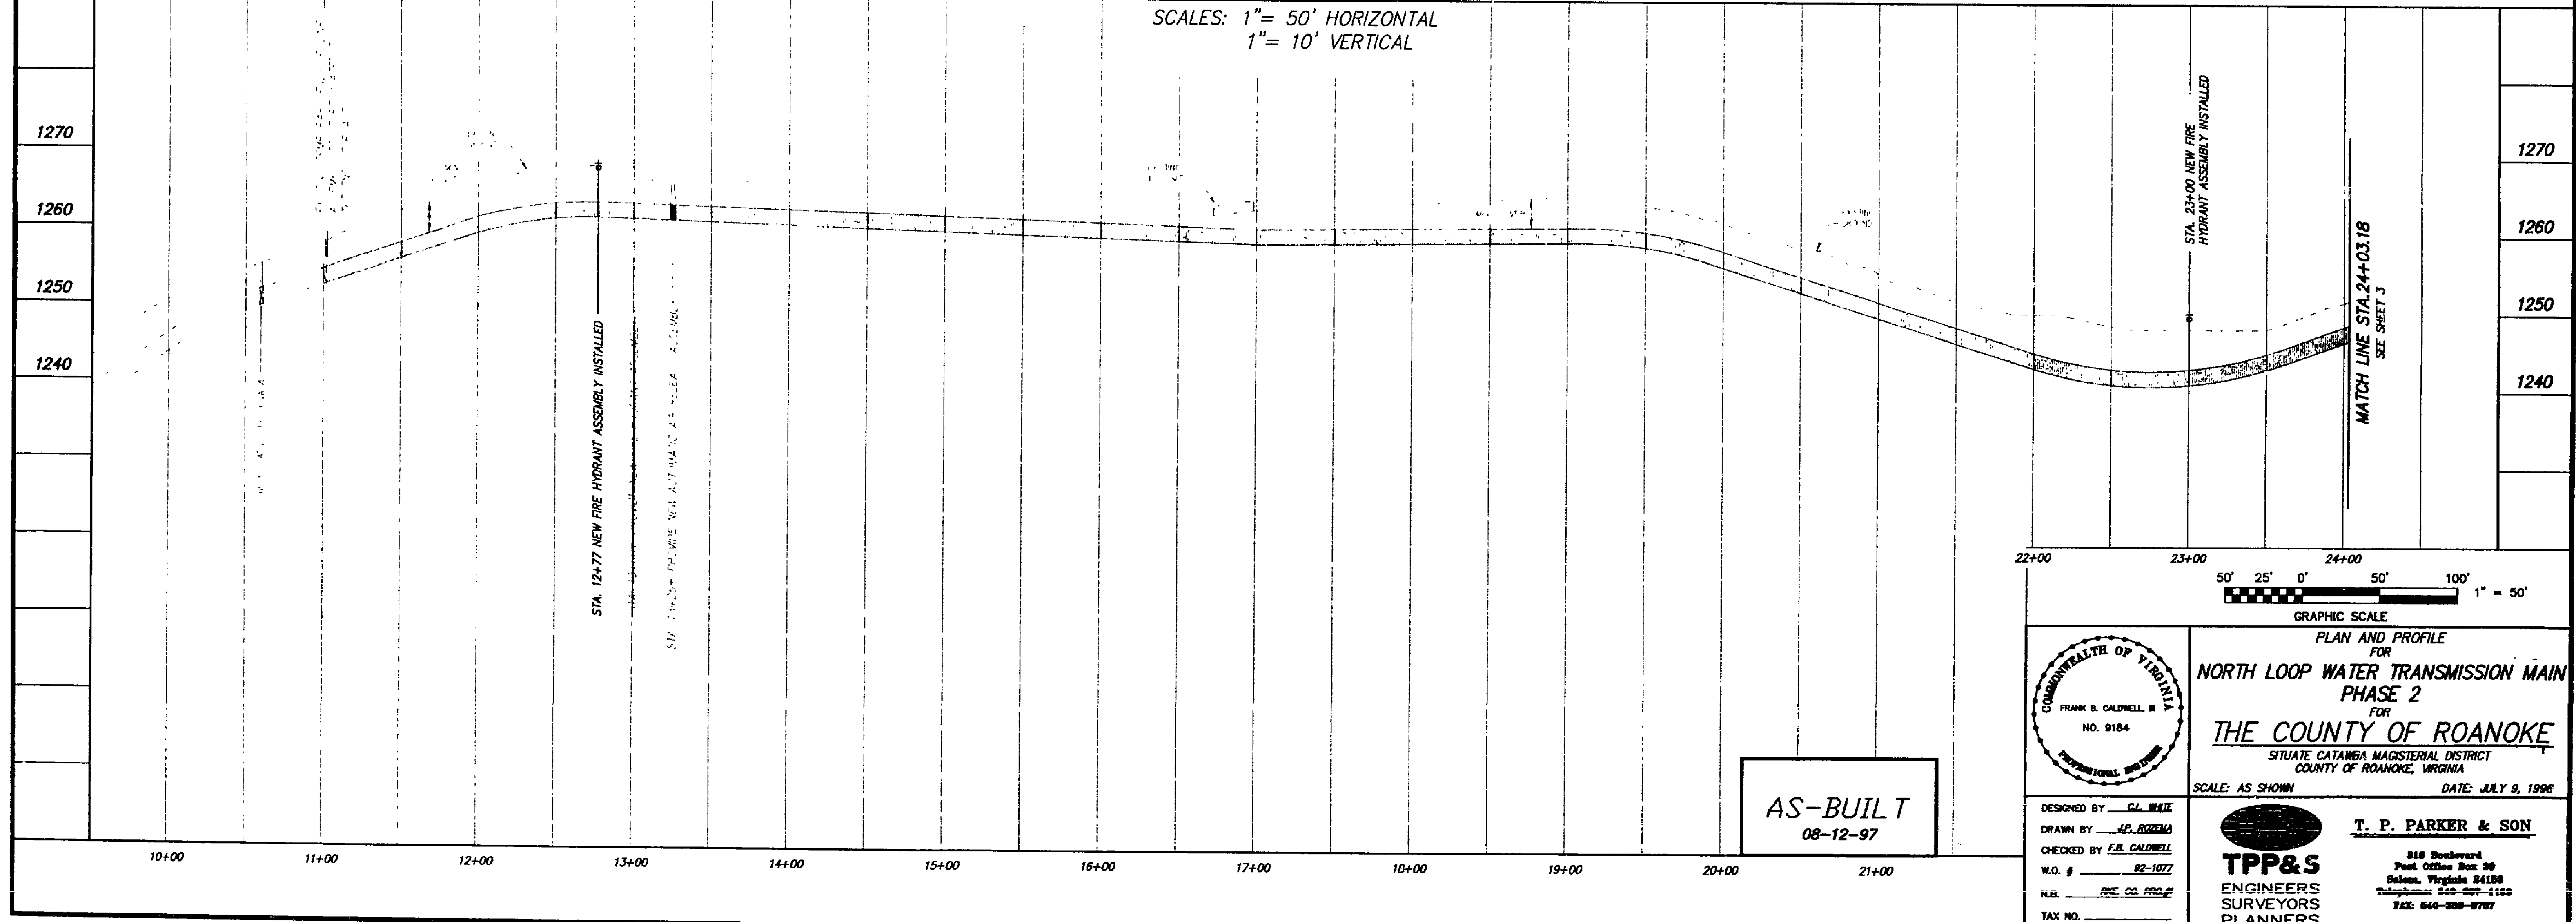


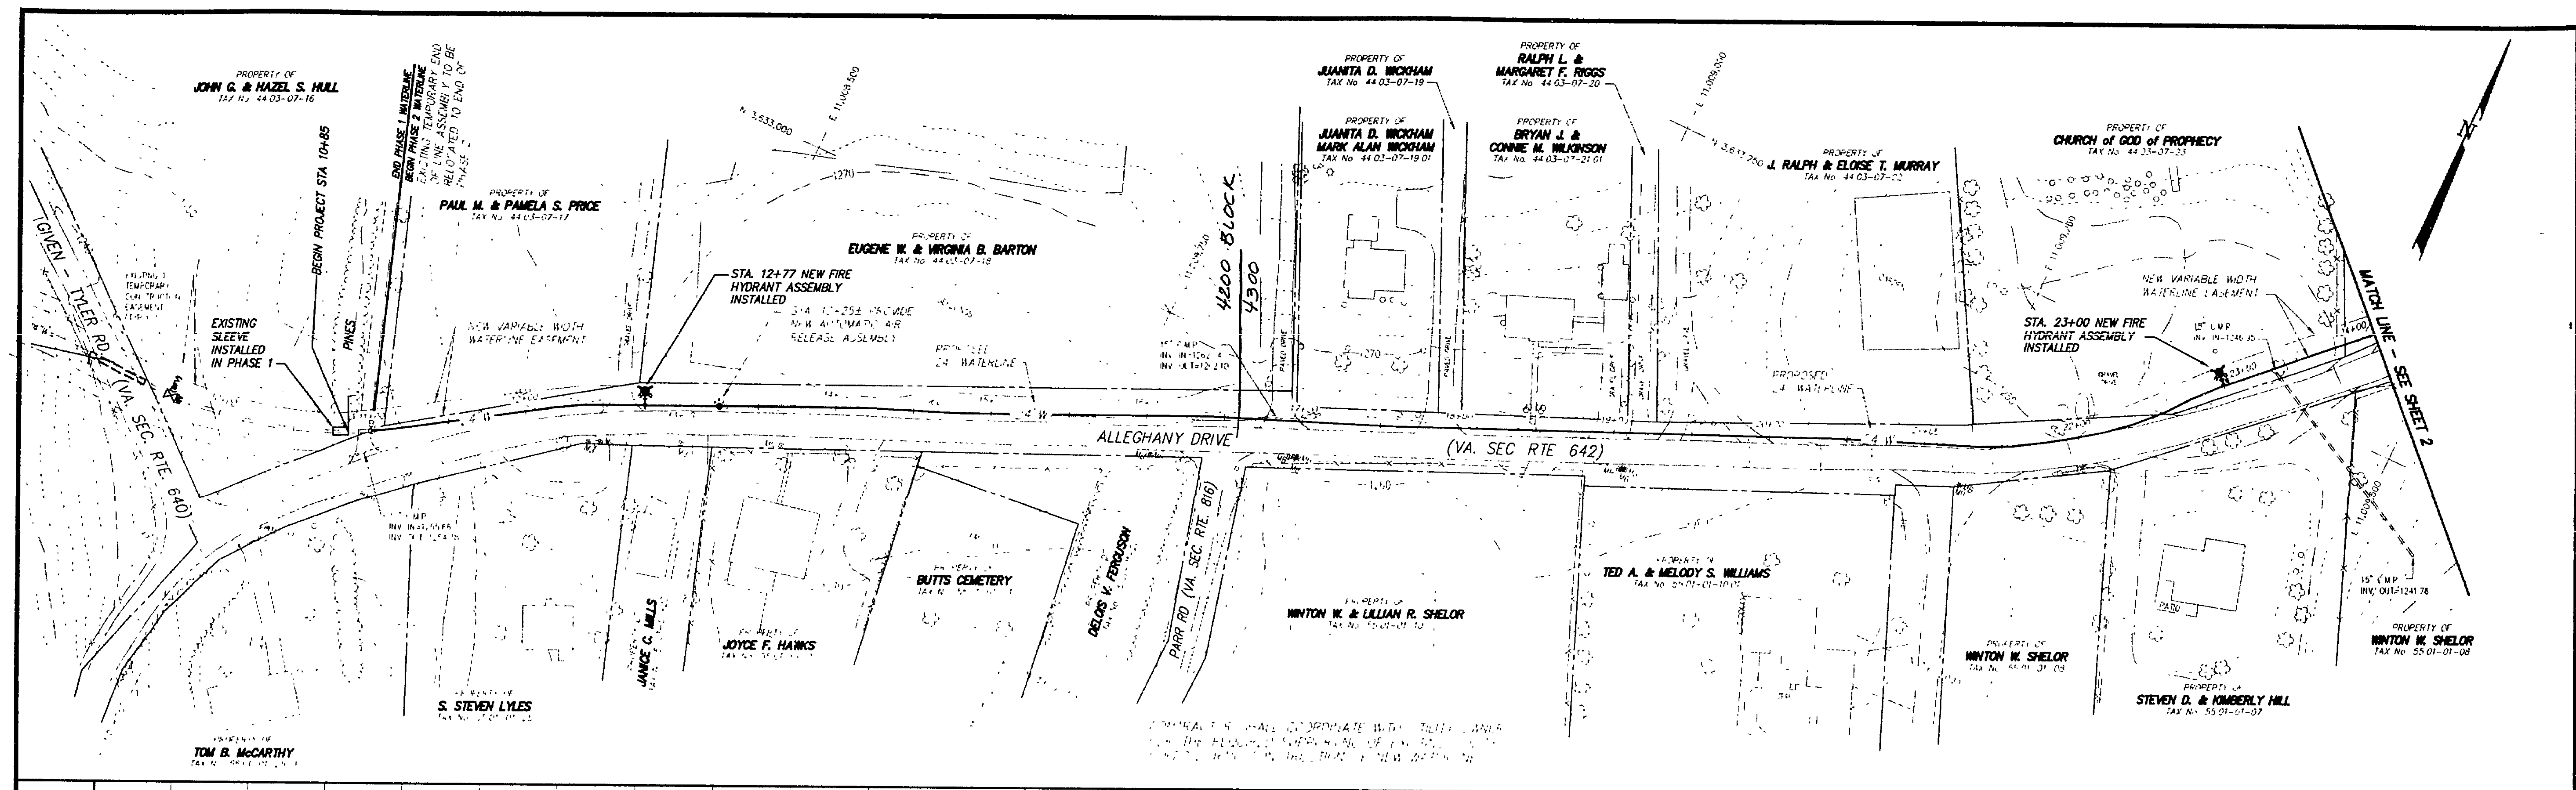

AS-BUILT
08-12-97

GRAPHIC SCALE
50' 25' 0' 50' 100' 1" = 50'

COMMONWEALTH OF VIRGINIA
FRANK B. CALDWELL, III
NO. 9184
PROFESSIONAL ENGINEER

PLAN AND PROFILE
FOR
NORTH LOOP WATER TRANSMISSION MAIN
PHASE 2
FOR
THE COUNTY OF ROANOKE
SITUATE CATAMBA MAGISTERIAL DISTRICT
COUNTY OF ROANOKE, VIRGINIA
SCALE: AS SHOWN DATE: JULY 9, 1996

DESIGNED BY: CL. WHITE
DRAWN BY: AP. ROZEMA
CHECKED BY: FB. CALDWELL
W.D. # 82-1077
H.B. REC. CO. PROJ. #
TAX NO.

T. P. PARKER & SON
318 Boulevard
Post Office Box 96
Salmon, Virginia 24158
Telephone: 540-387-1155
FAX: 540-388-8787

TPP&S
ENGINEERS
SURVEYORS
PLANNERS