
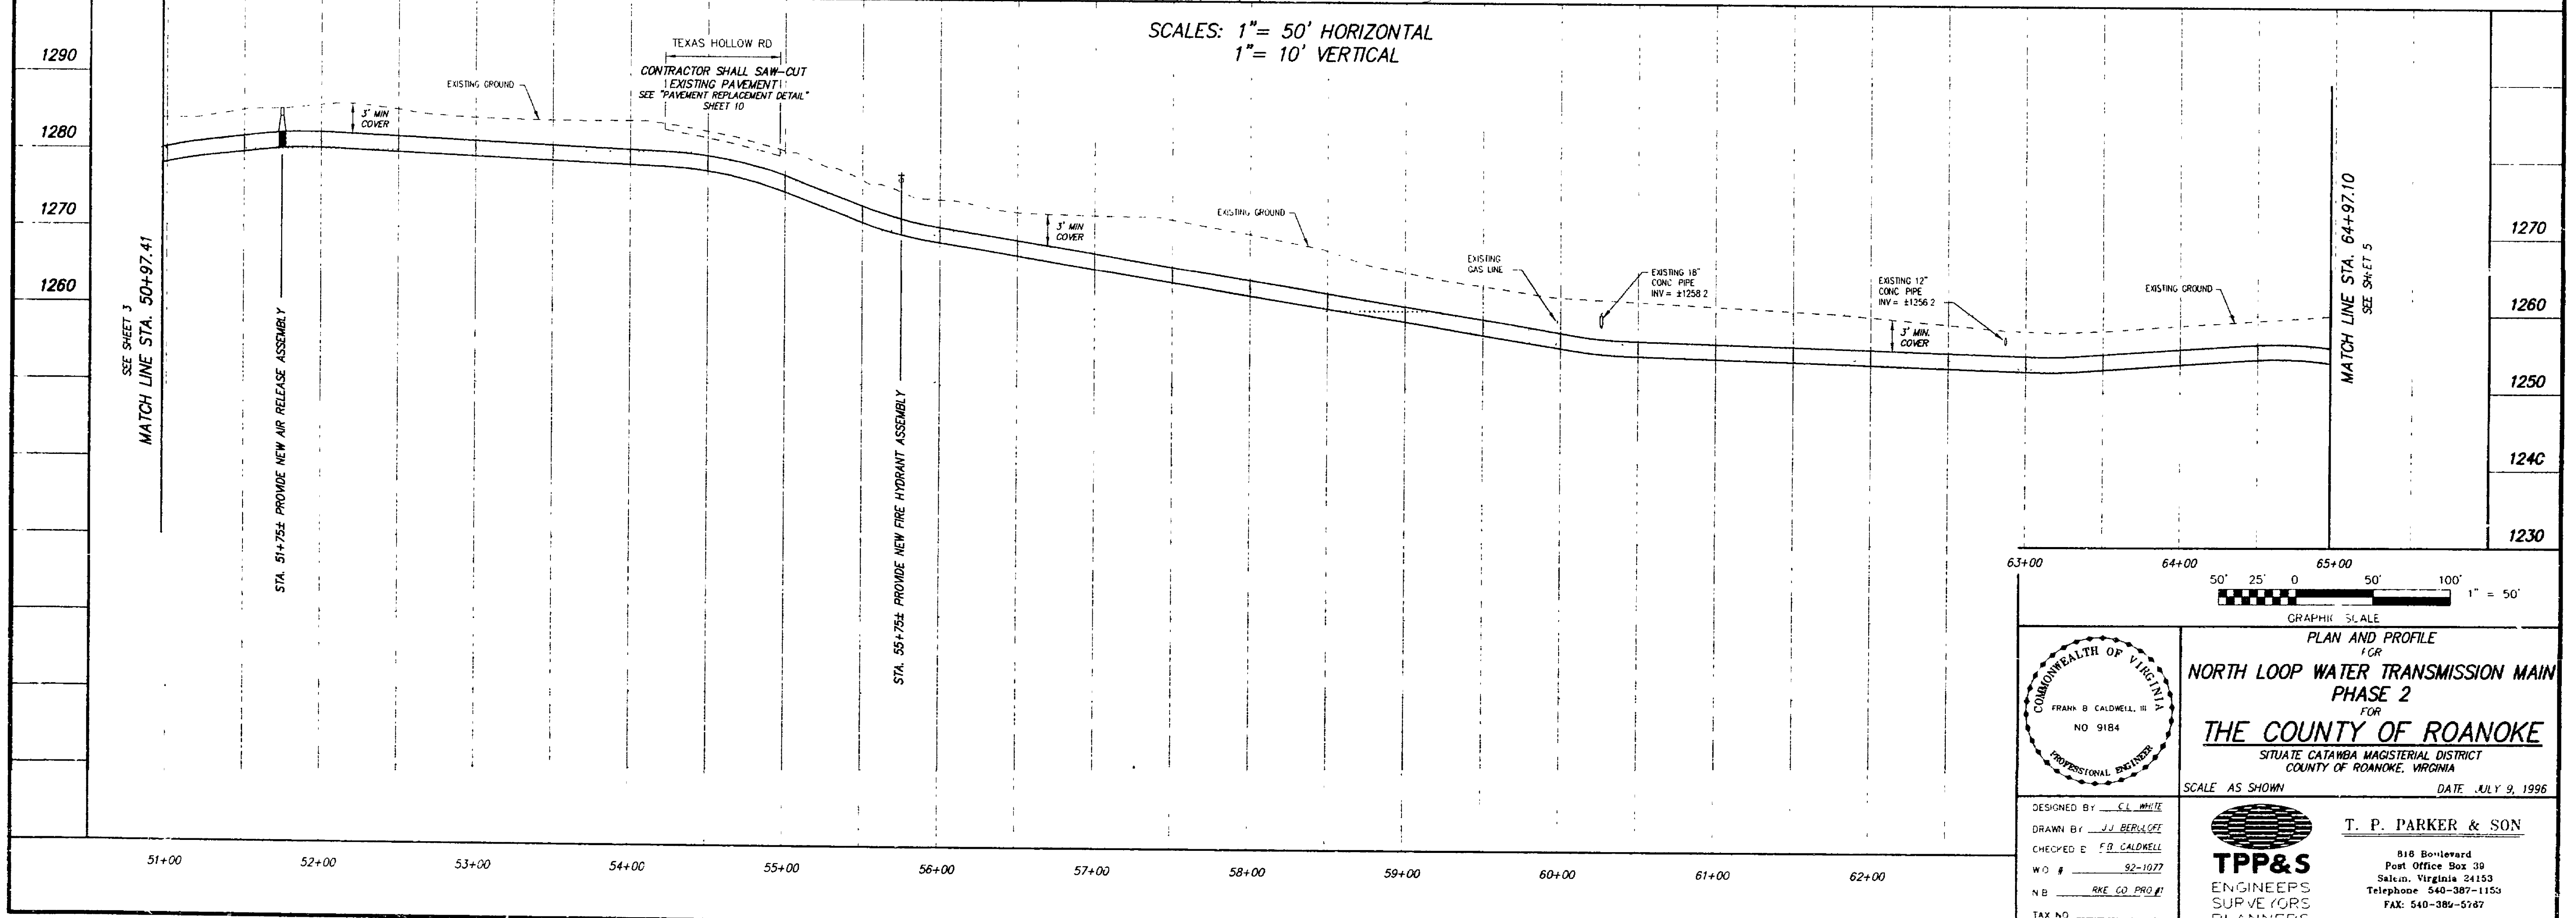


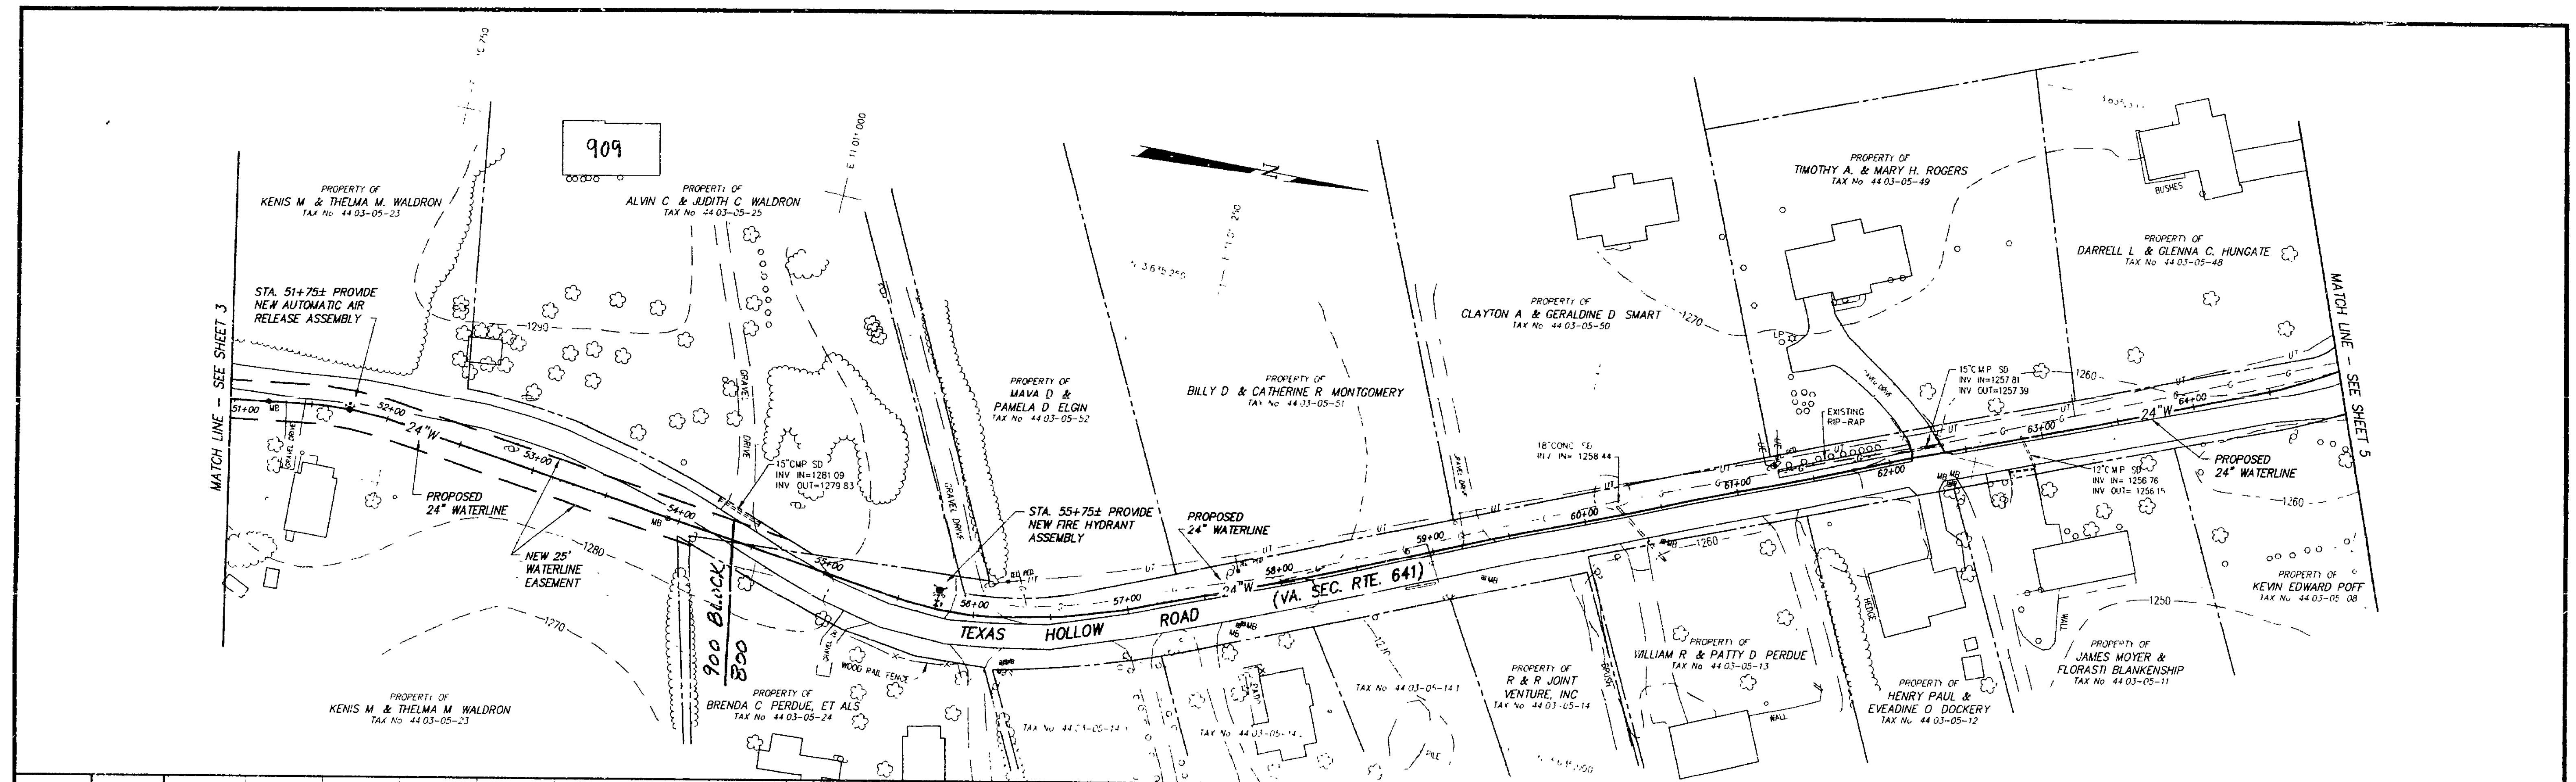

GRAPHIC SCALE: 1" = 50'

DESIGNED BY: C.L. WHITE
 DRAWN BY: J.J. BERLETT
 CHECKED BY: F.B. CALDWELL
 W.D. # 92-1077
 N.B. RKE CO. PROJ.
 TAX NO. _____

COMMONWEALTH OF VIRGINIA
 FRANK B. CALDWELL, III
 NO. 9184
 PROFESSIONAL ENGINEER

PLAN AND PROFILE FOR
**NORTH LOOP WATER TRANSMISSION MAIN
 PHASE 2**
 FOR
THE COUNTY OF ROANOKE
 SITUATE CATAMBA MAGISTERIAL DISTRICT
 COUNTY OF ROANOKE, VIRGINIA

SCALE AS SHOWN DATE JULY 9, 1996

T. P. PARKER & SON
 818 Boulevard
 Post Office Box 39
 Salem, Virginia 24153
 Telephone 540-387-1153
 FAX: 540-388-5747

TPP&S
 ENGINEERS
 SURVEYORS
 PLANNERS

SHEET 4 OF 10
 WT-0451