

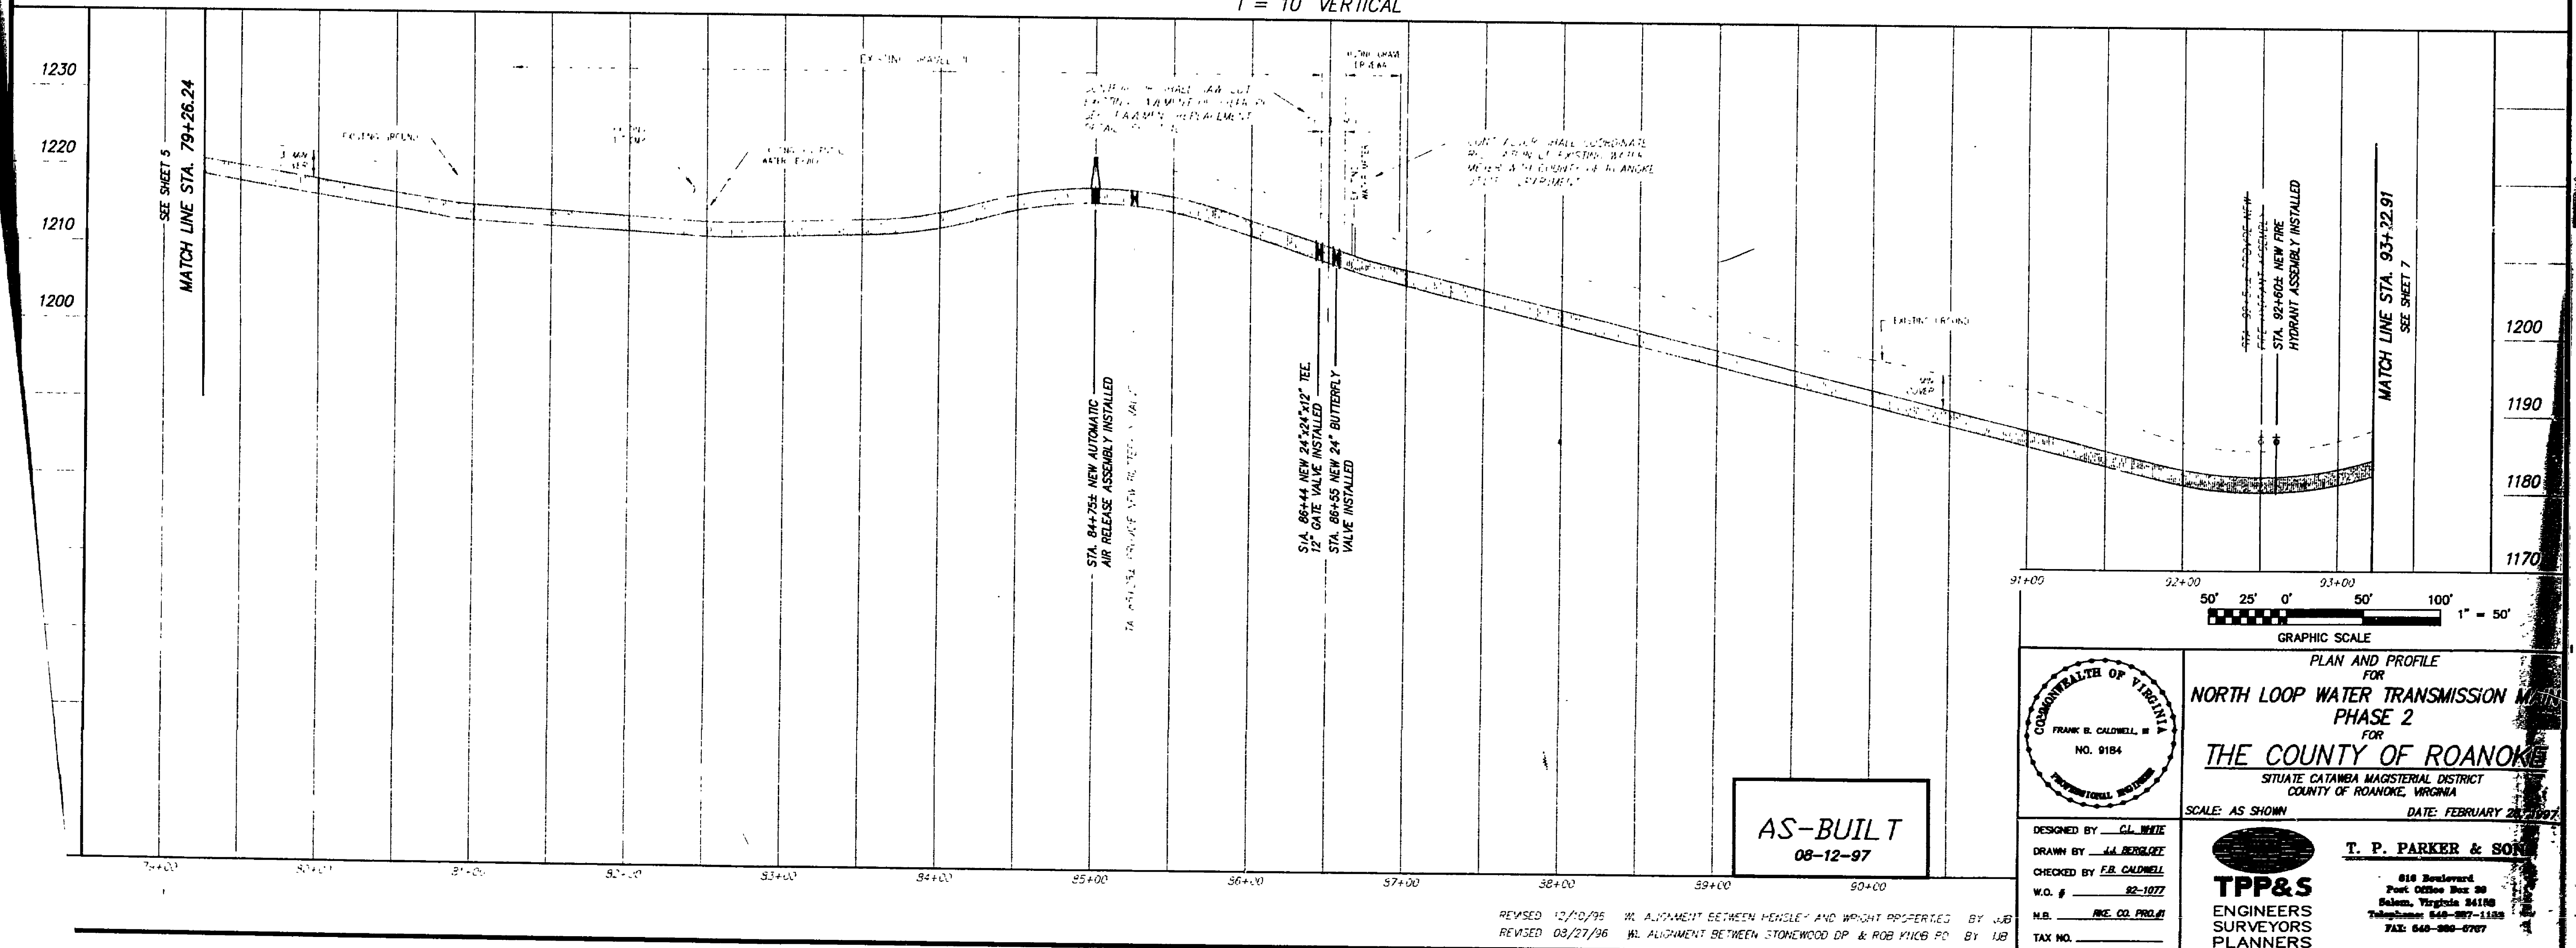


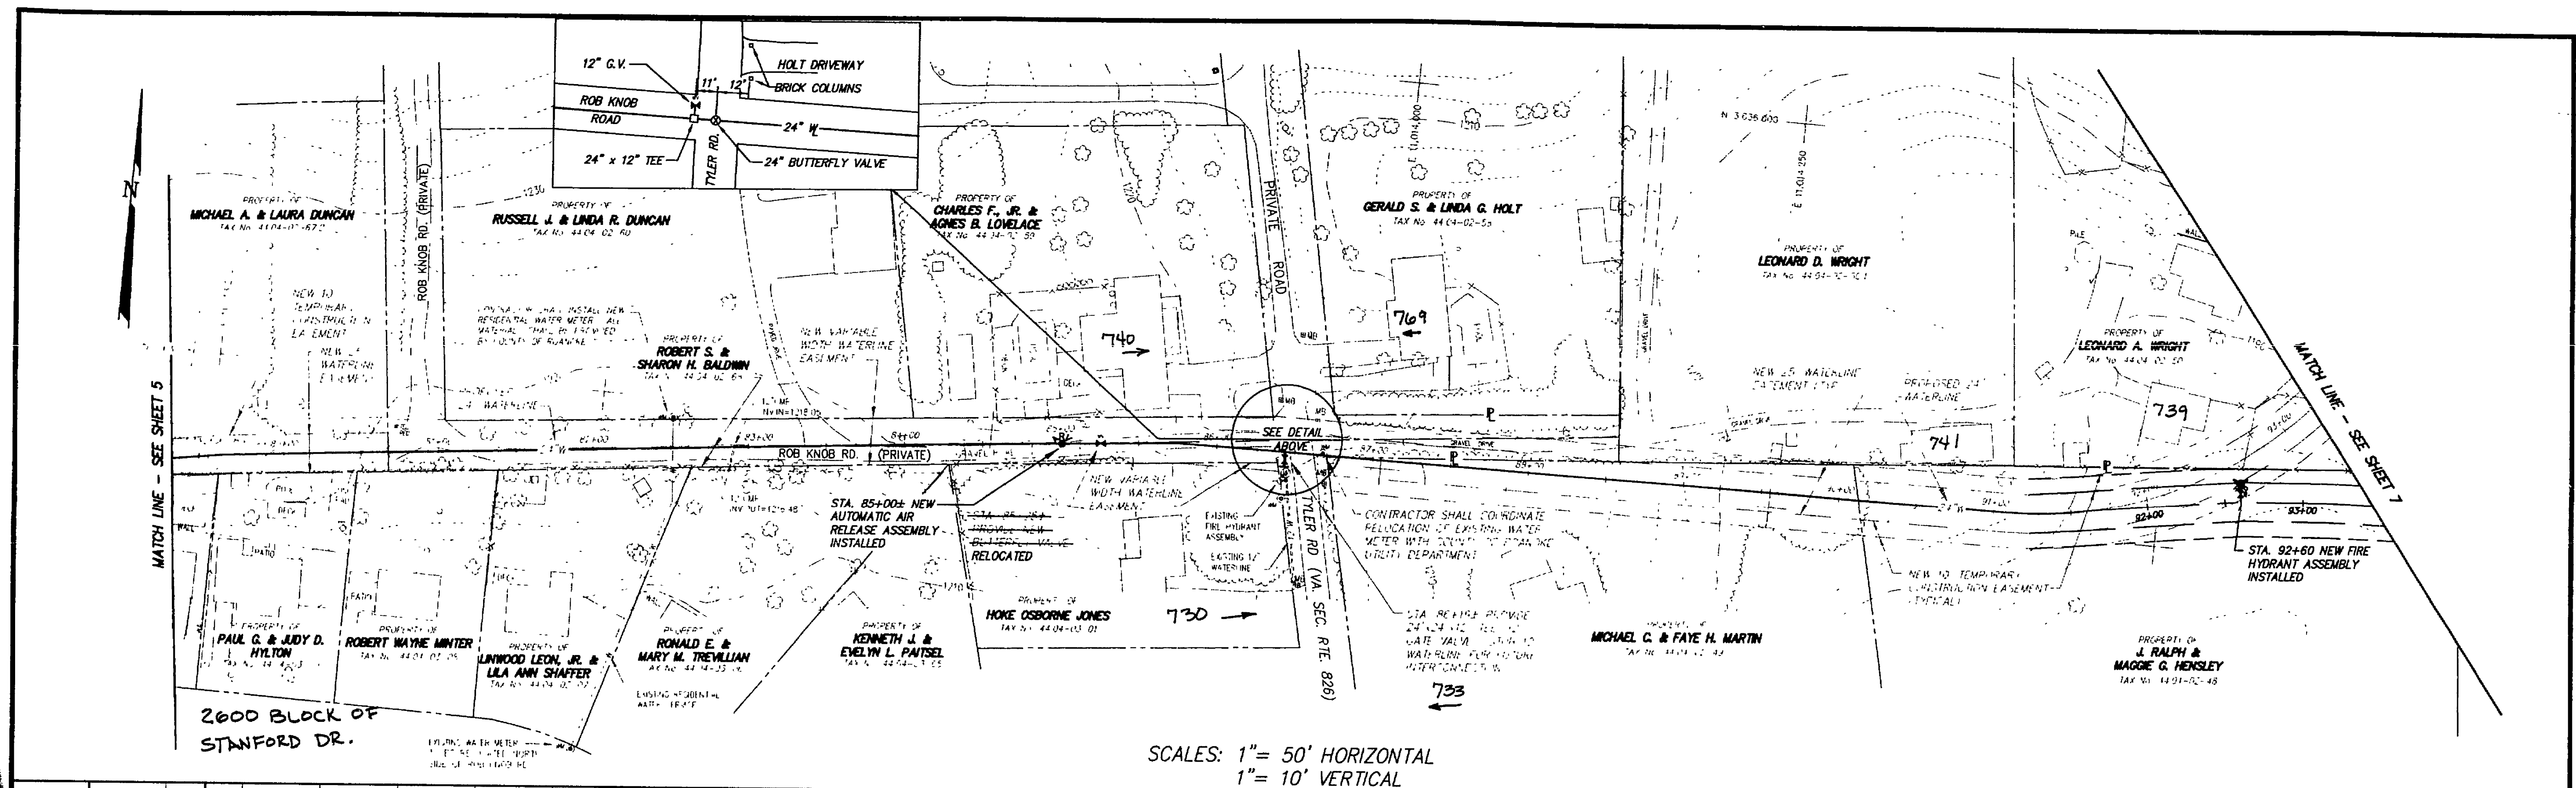

AS-BUILT
08-12-97

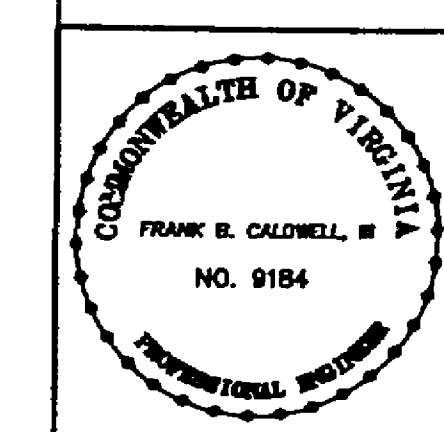

PLAN AND PROFILE
FOR
**NORTH LOOP WATER TRANSMISSION MAIN
PHASE 2**
FOR
THE COUNTY OF ROANOKE
SITUATE CATAMBA MAGISTERIAL DISTRICT
COUNTY OF ROANOKE, VIRGINIA
SCALE: AS SHOWN DATE: FEBRUARY 28, 1997

DESIGNED BY: G. WHITE
DRAWN BY: J. B. BURGESS
CHECKED BY: F. B. CALDWELL
W.O. # 92-1077
H.B. REC. CO. PROJ. #
TAX NO.

T. P. PARKER & SON
616 Boulevard
Post Office Box 28
Salmon, Virginia 24158
Telephone: 540-897-1155
FAX: 540-898-0707

REVISED 12/10/95 IN ALIGNMENT BETWEEN HENSLEY AND WRIGHT PROPERTIES BY J.B.
REVISED 03/21/96 IN ALIGNMENT BETWEEN STONEWOOD DR. & ROB KNOB RD. BY J.B.