



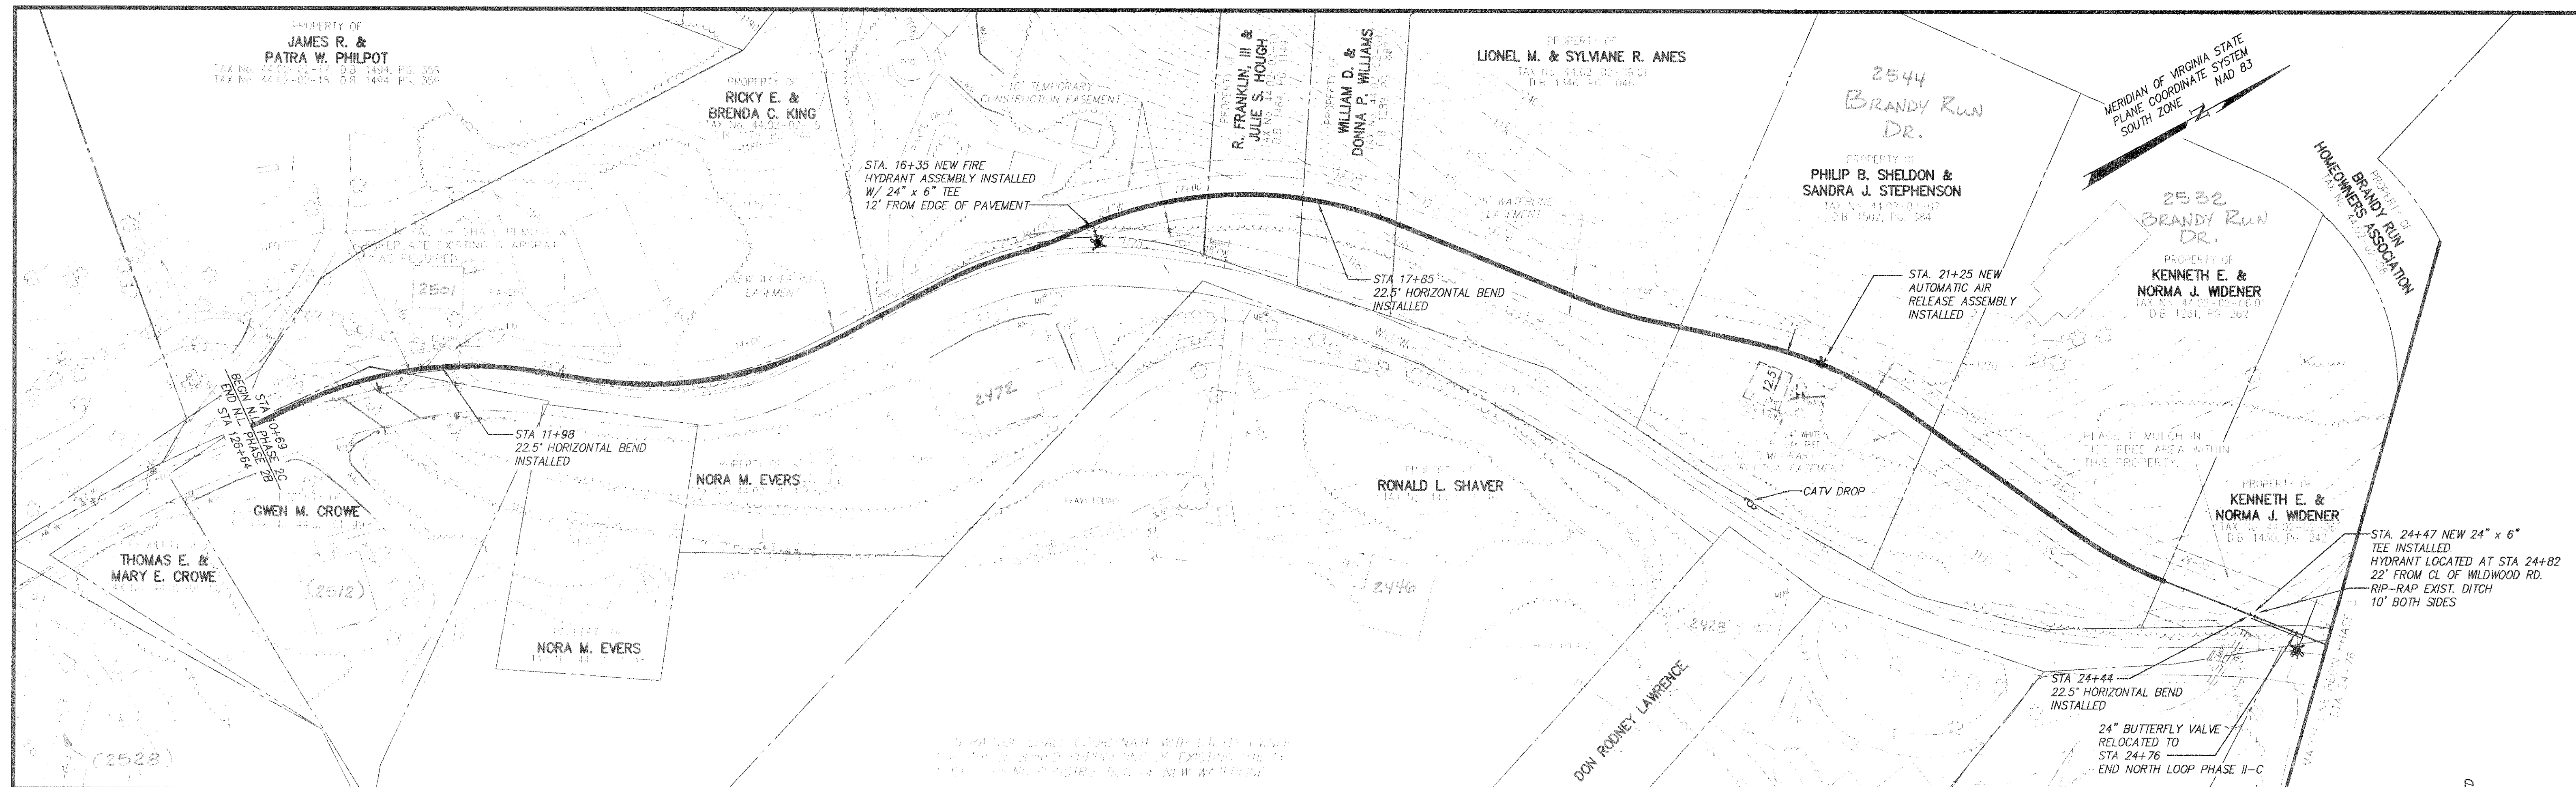

SCALES: 1" = 50' HORIZ.
1" = 10' VERT.

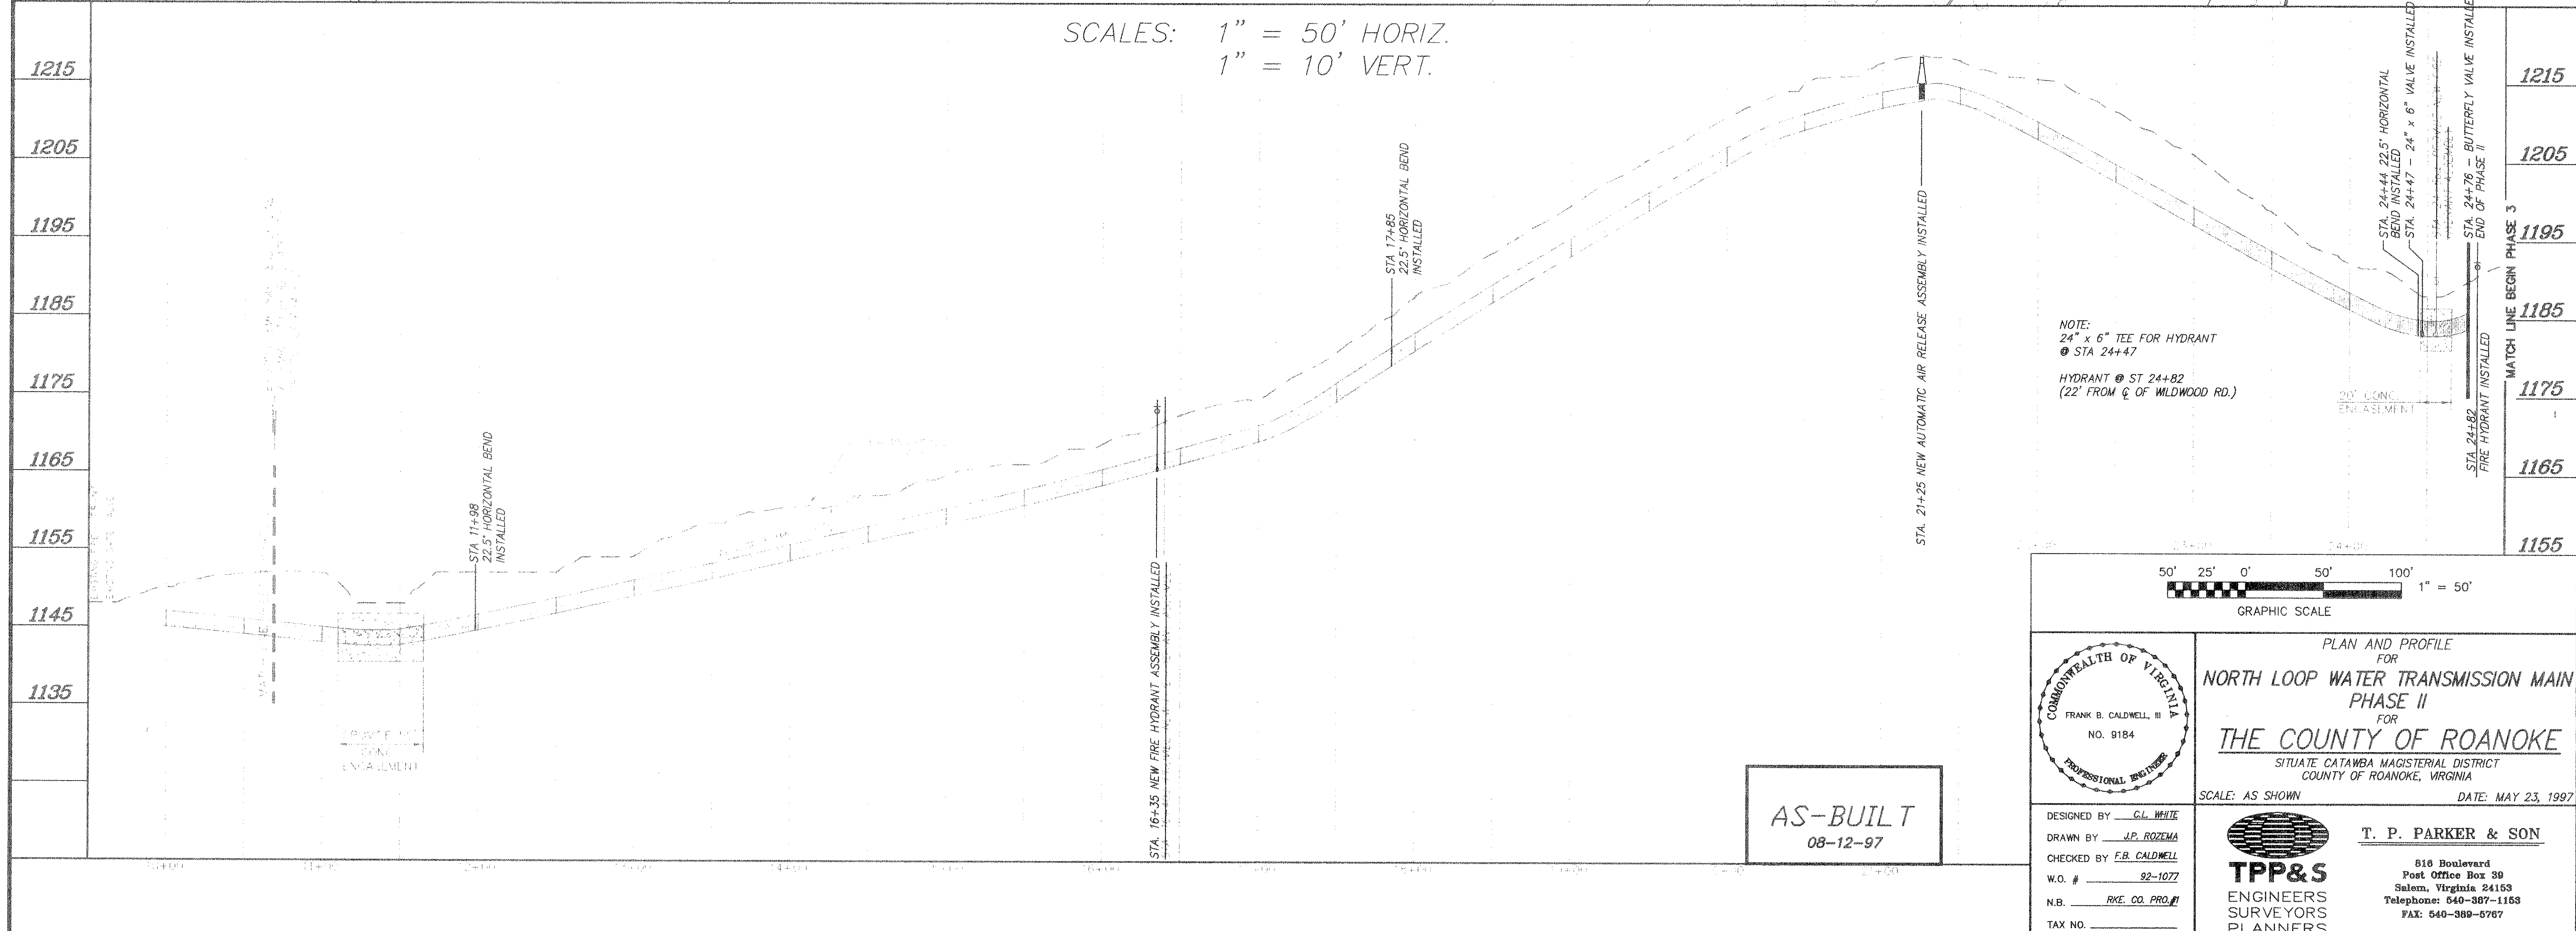

NOTE:
24" x 6" TEE FOR HYDRANT
● STA 24+47
HYDRANT @ ST 24+82
(22' FROM C OF WILDWOOD RD.)

GRAPHIC SCALE
50' 25' 0' 50' 100' 1" = 50'

AS-BUILT
08-12-97

DESIGNED BY: G.L. WHITE
DRAWN BY: J.P. ROZEMA
CHECKED BY: F.B. CALDWELL
W.O. #: 92-1077
N.B.: RKE CO. PROJ. #1
TAX NO.:

COMMONWEALTH OF VIRGINIA
FRANK B. CALDWELL, III
NO. 9184
PROFESSIONAL ENGINEER

PLAN AND PROFILE
FOR
NORTH LOOP WATER TRANSMISSION MAIN
PHASE II
FOR
THE COUNTY OF ROANOKE
SITUATE CATAMBA MAGISTERIAL DISTRICT
COUNTY OF ROANOKE, VIRGINIA
SCALE: AS SHOWN DATE: MAY 23, 1997

T. P. PARKER & SON
516 Boulevard
Post Office Box 30
Salem, Virginia 24153
Telephone: 540-387-1153
FAX: 540-389-5767

TPP&S
ENGINEERS
SURVEYORS
PLANNERS