

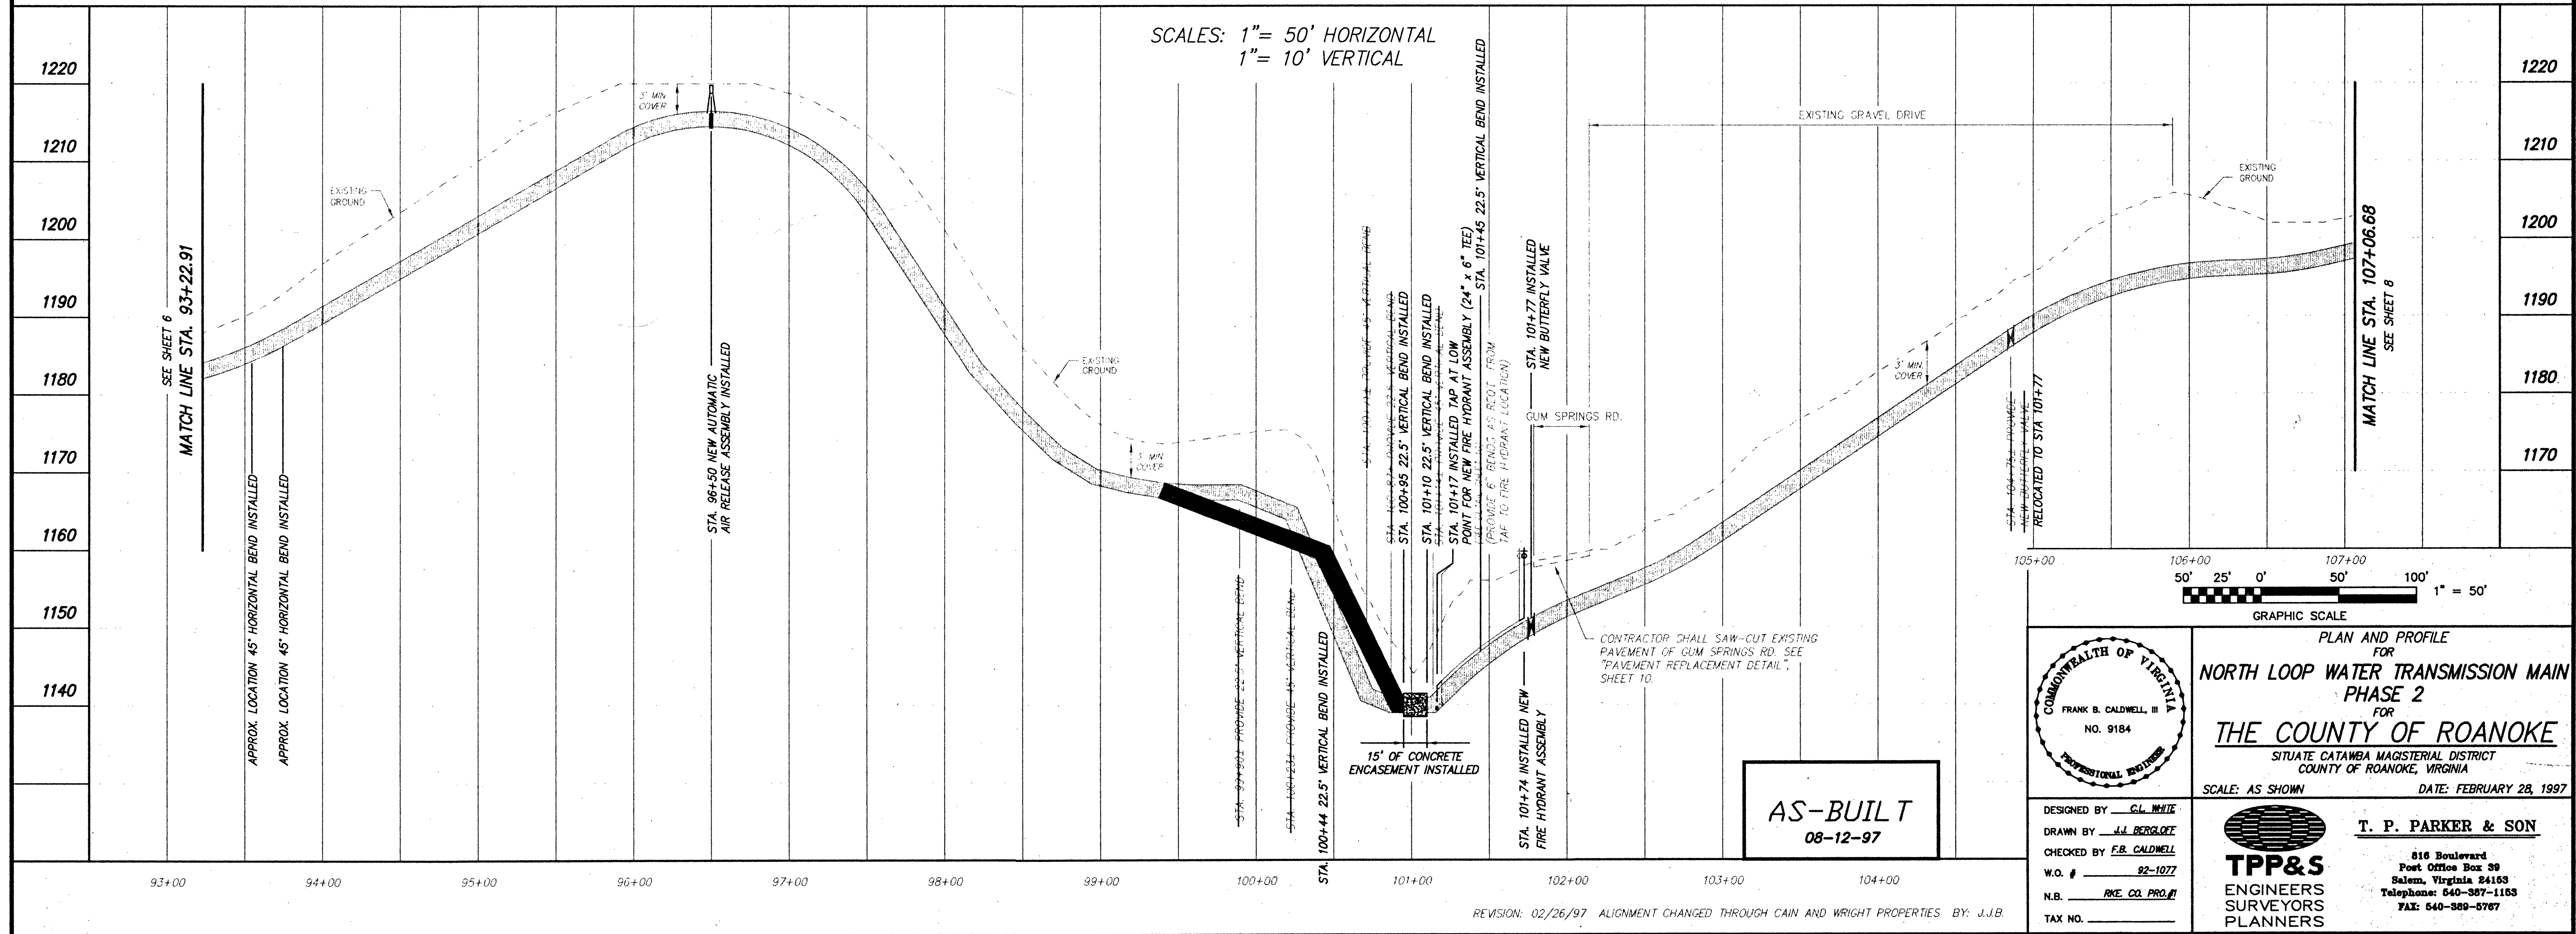


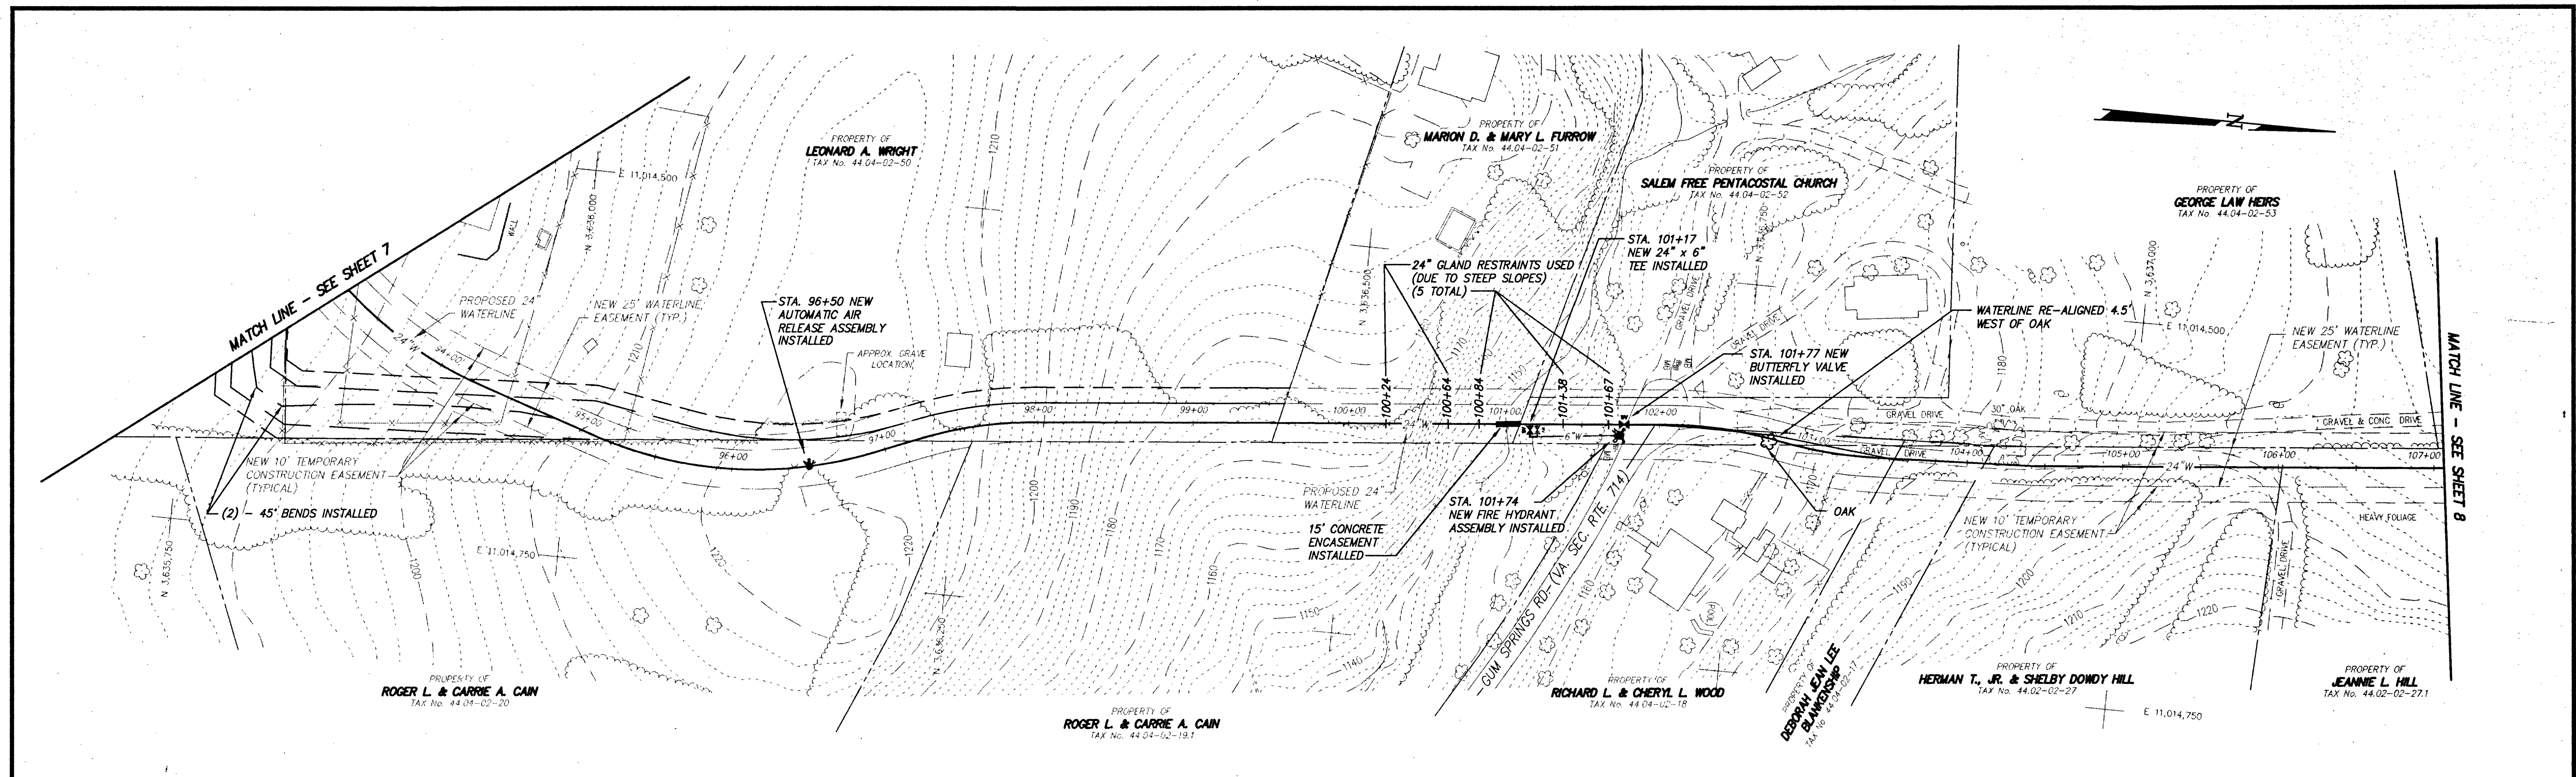

SCALES: 1" = 50' HORIZONTAL
1" = 10' VERTICAL

AS-BUILT
08-12-97

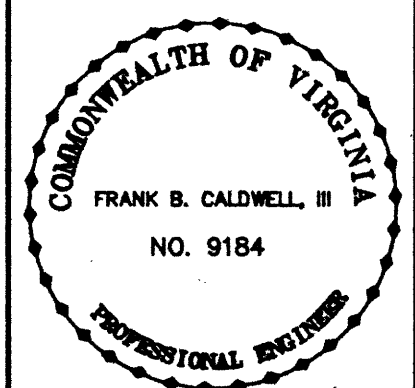

PLAN AND PROFILE
FOR
NORTH LOOP WATER TRANSMISSION MAIN
PHASE 2
FOR
THE COUNTY OF ROANOKE
SITUATE CATAMBA MAGISTERIAL DISTRICT
COUNTY OF ROANOKE, VIRGINIA
SCALE: AS SHOWN DATE: FEBRUARY 28, 1997

DESIGNED BY: C.L. WHITE
DRAWN BY: J.J. BERGLOFF
CHECKED BY: F.B. CALDWELL
W.O. #: 92-1077
N.B. RKE CO. PROJ. #1
TAX NO. _____

T. P. PARKER & SON
816 Boulevard
Post Office Box 39
Salem, Virginia 24163
Telephone: 540-387-1163
FAX: 540-389-5767

REVISION: 02/26/97 ALIGNMENT CHANGED THROUGH CAIN AND WRIGHT PROPERTIES BY: J.J.B.