
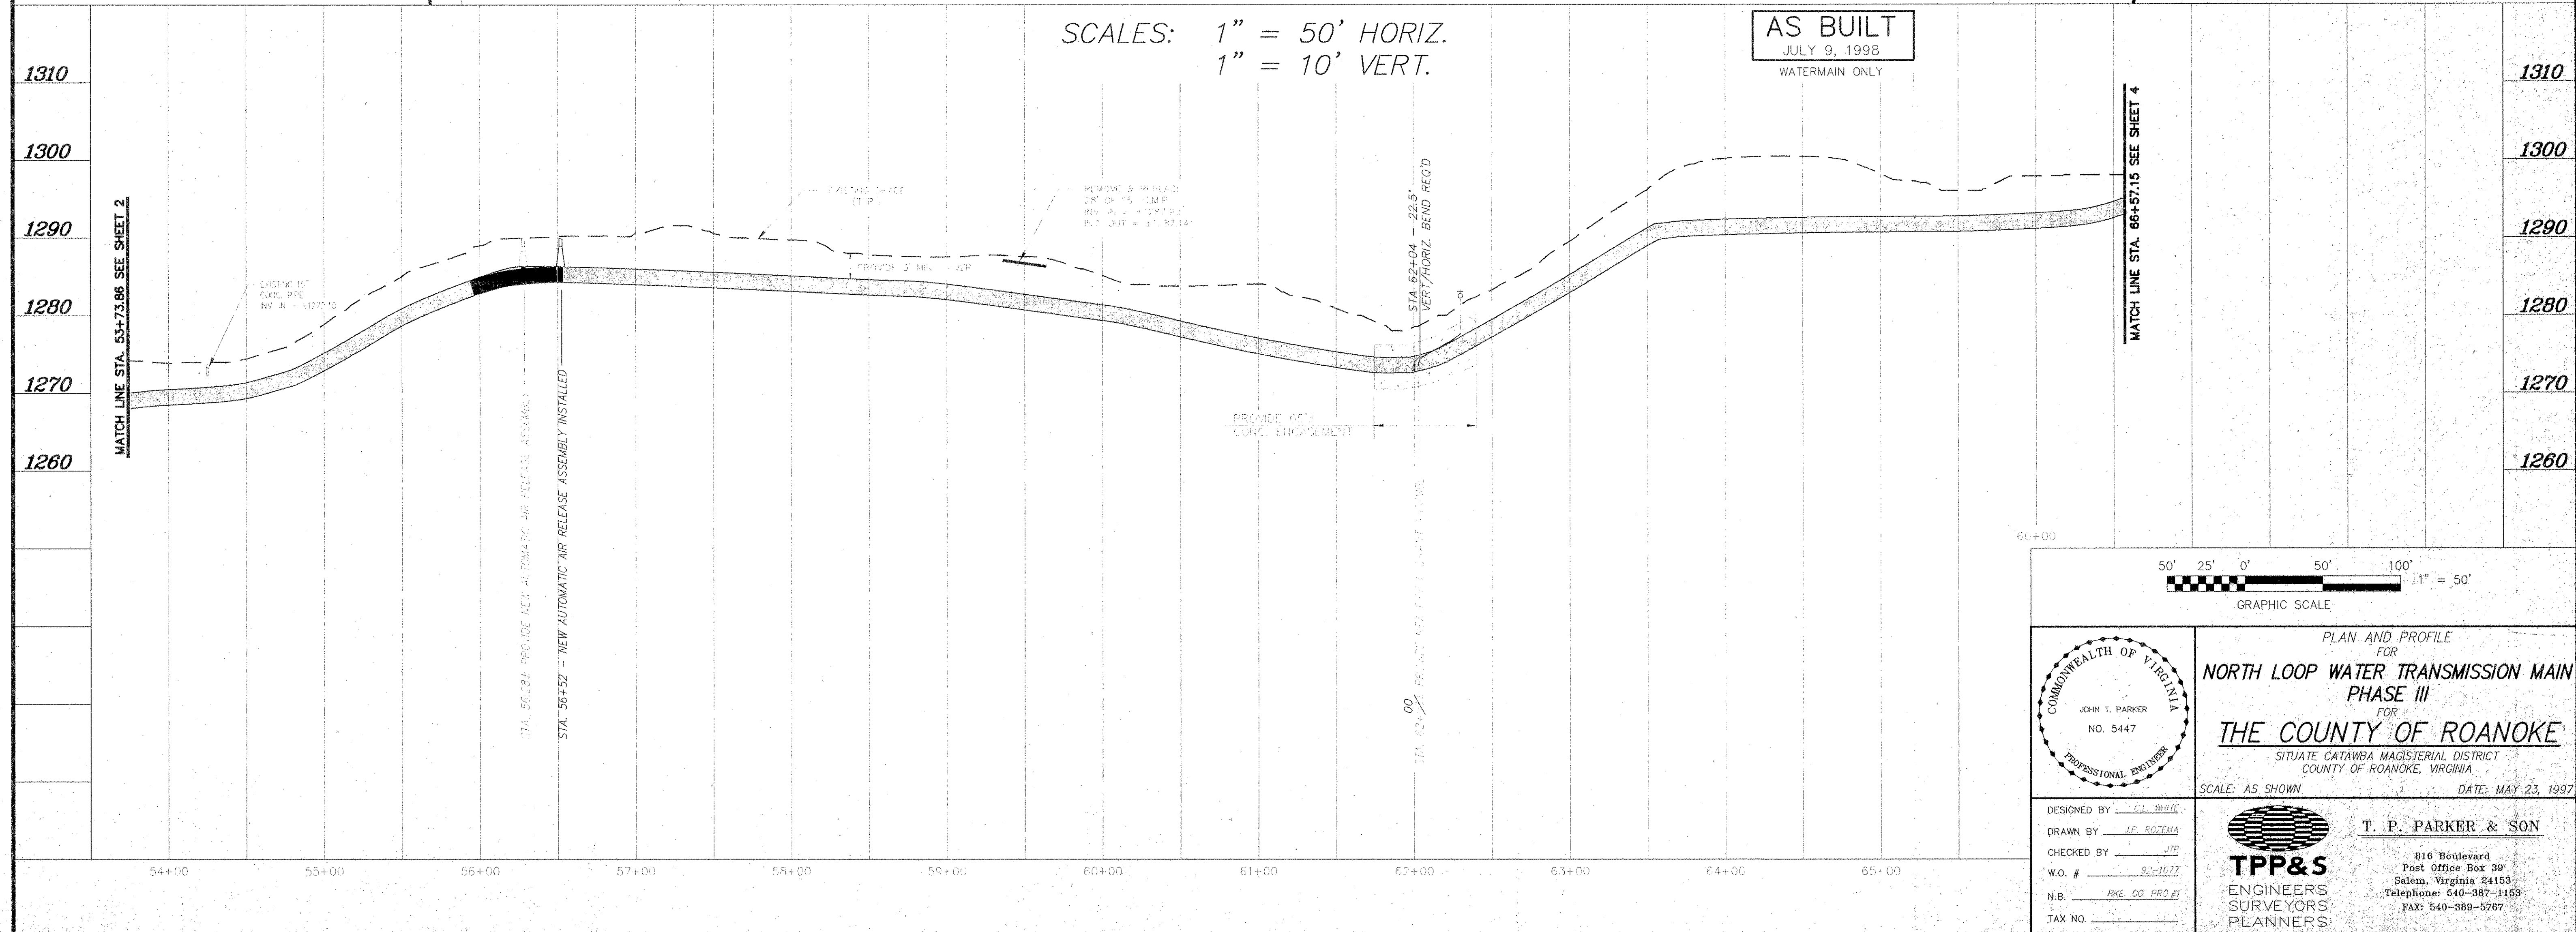


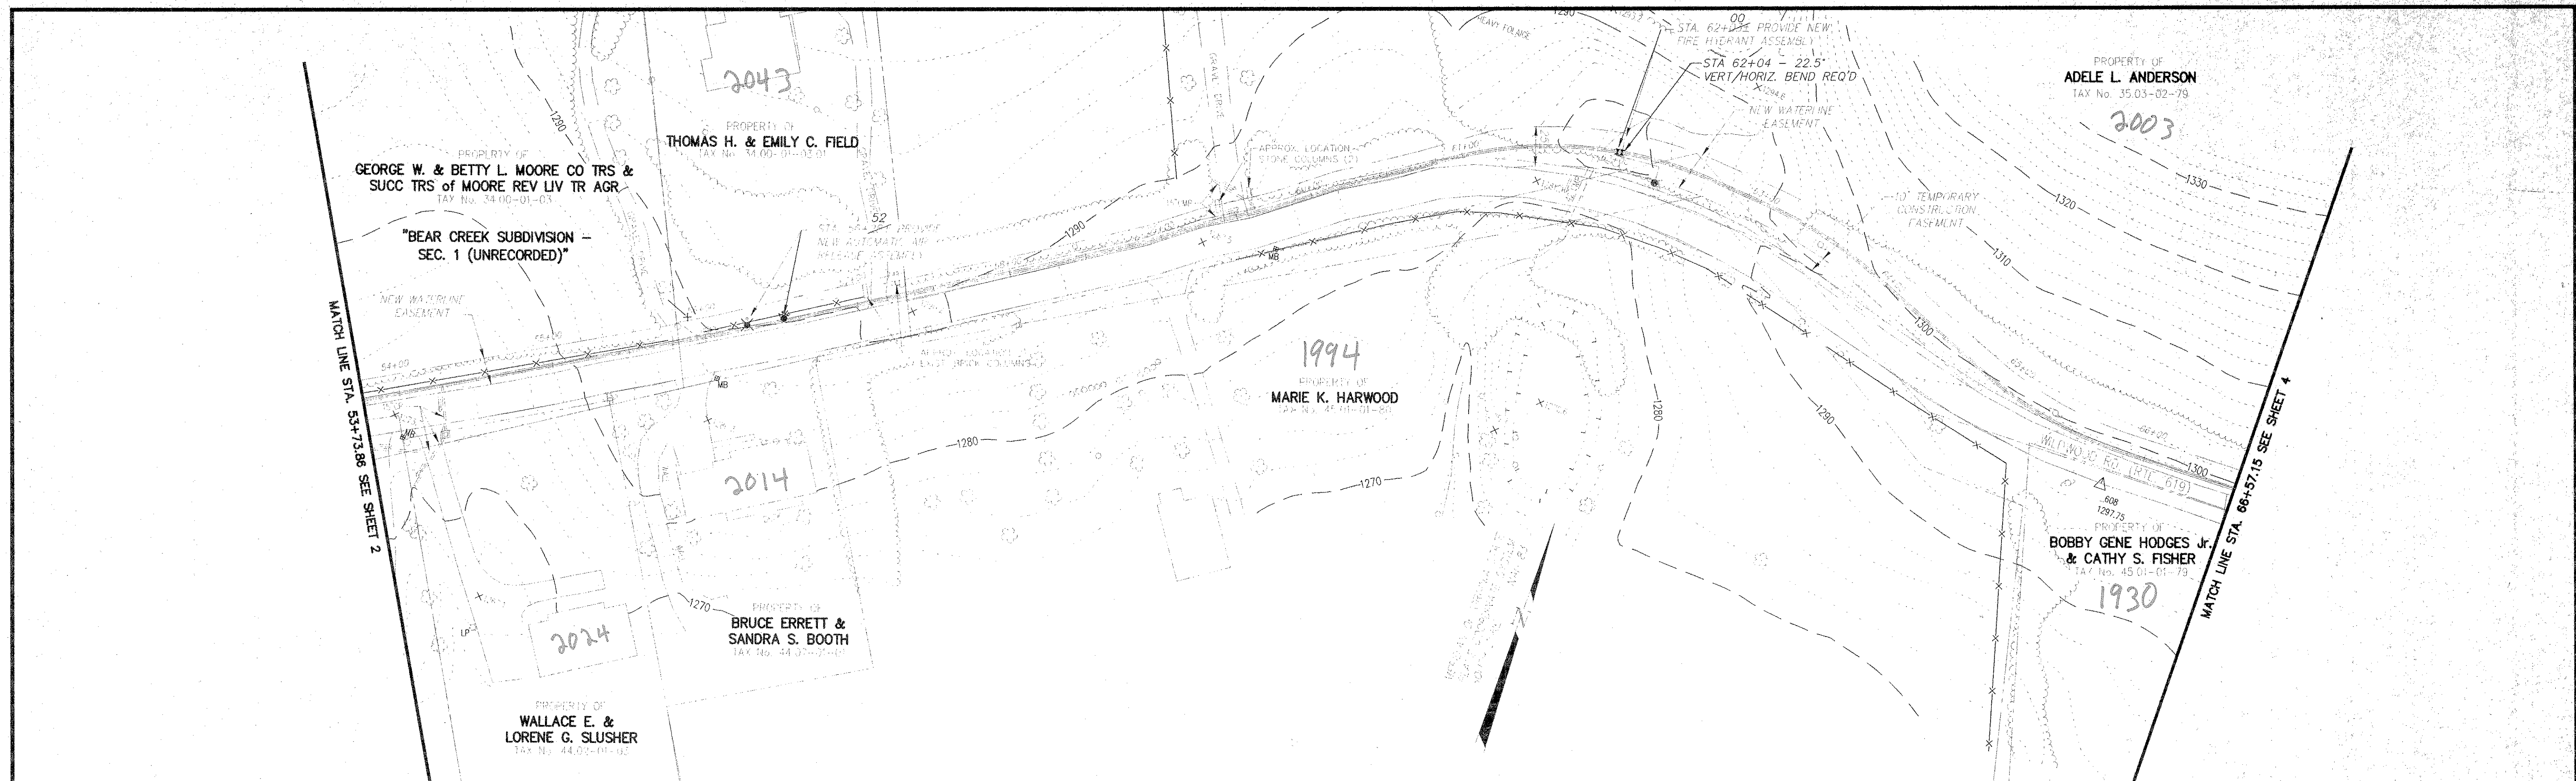

50' 25' 0' 50' 100' 1" = 50'

GRAPHIC SCALE

DESIGNED BY: C.L. WHITE

DRAWN BY: J.P. BOZEMA

CHECKED BY: JTP

W.O. #: 92-1077

N.B.: RWE CO. PROJ. #1

TAX NO.:

PLAN AND PROFILE FOR

NORTH LOOP WATER TRANSMISSION MAIN PHASE III

FOR

THE COUNTY OF ROANOKE

SITUATE CATAWBA MAGISTERIAL DISTRICT COUNTY OF ROANOKE, VIRGINIA

SCALE: AS SHOWN DATE: MAY 23, 1997

T. P. PARKER & SON

816 Boulevard
Post Office Box 39
Salem, Virginia 24153
Telephone: 540-387-1159
FAX: 540-389-5767