
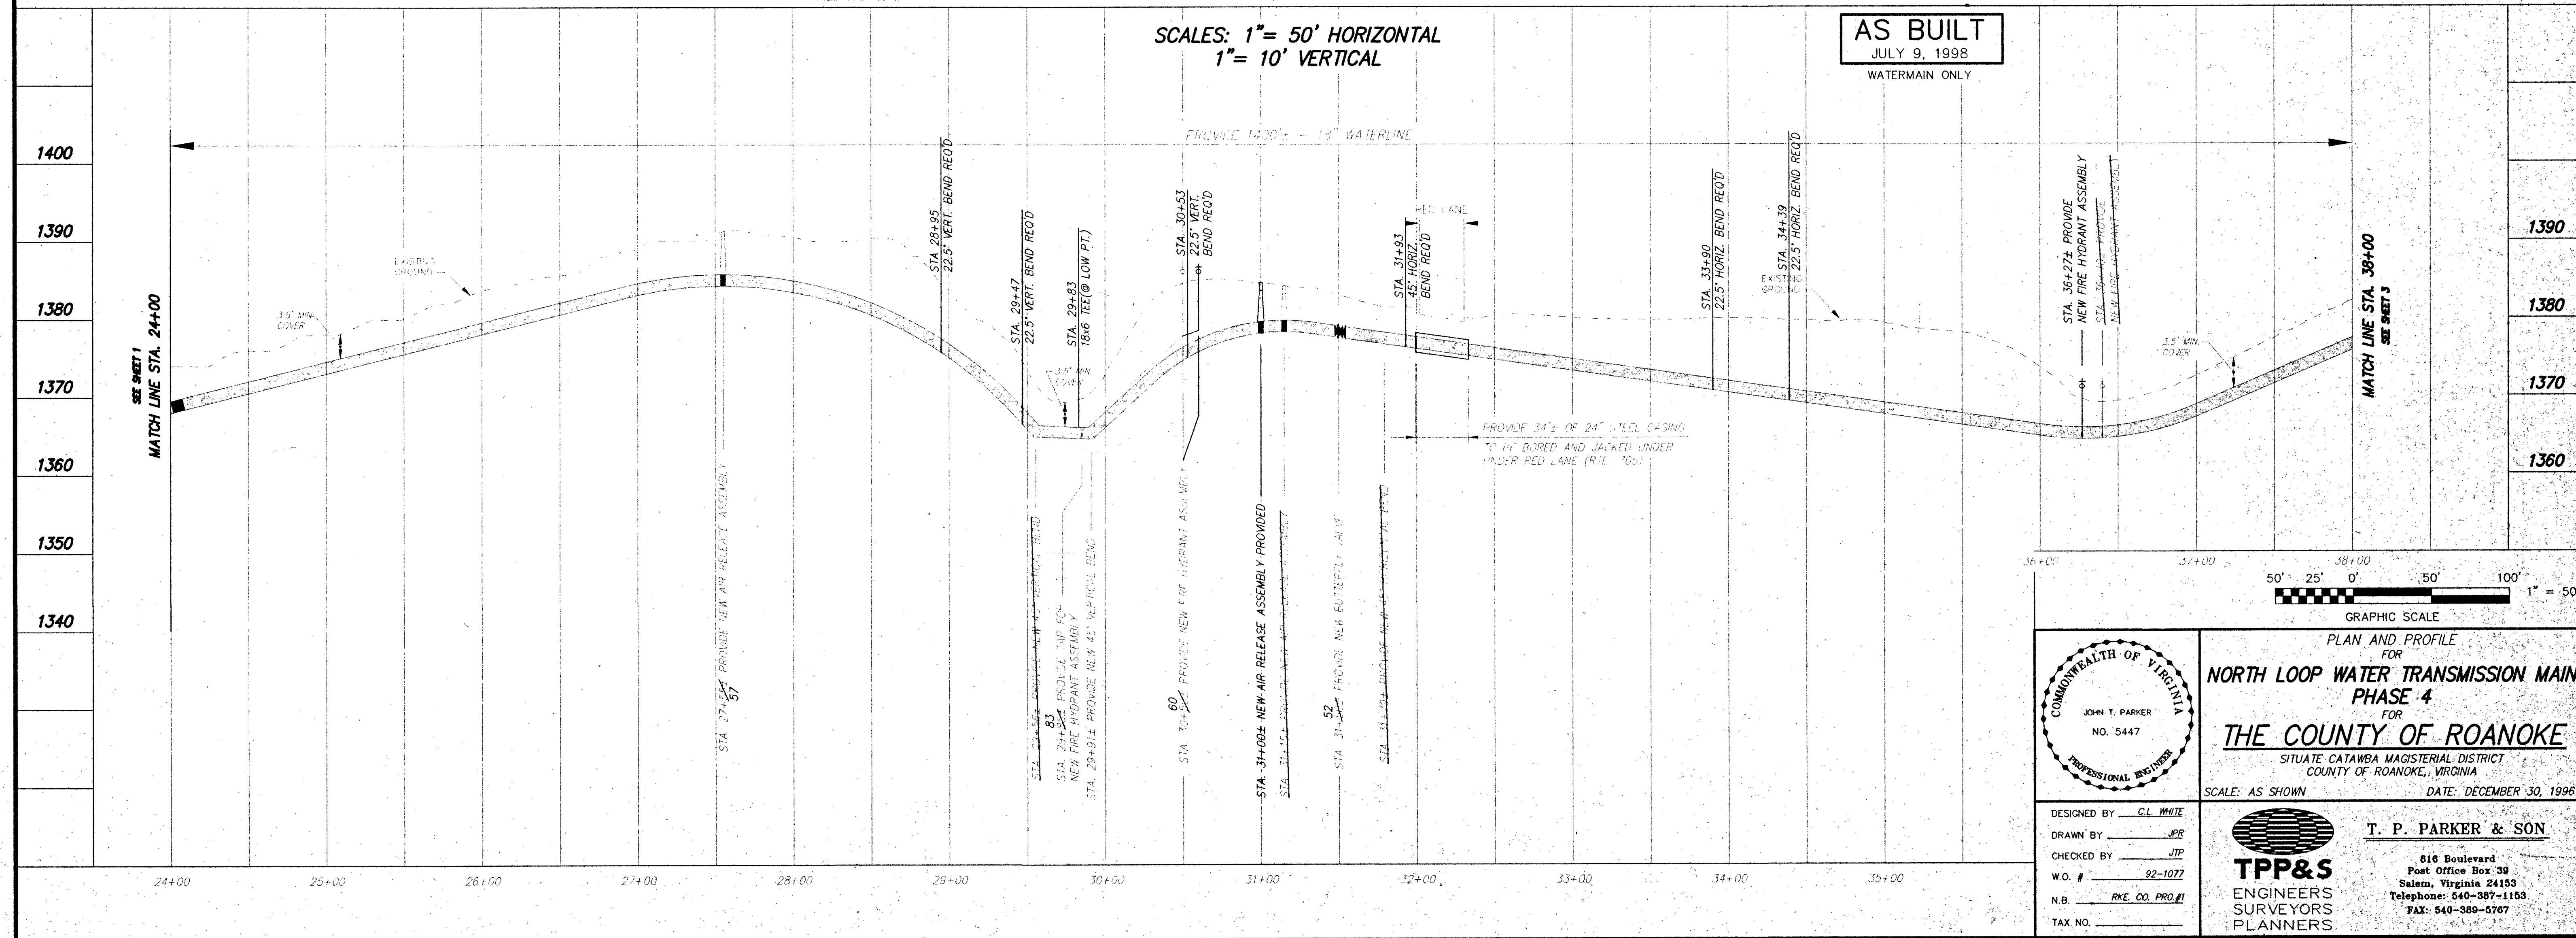


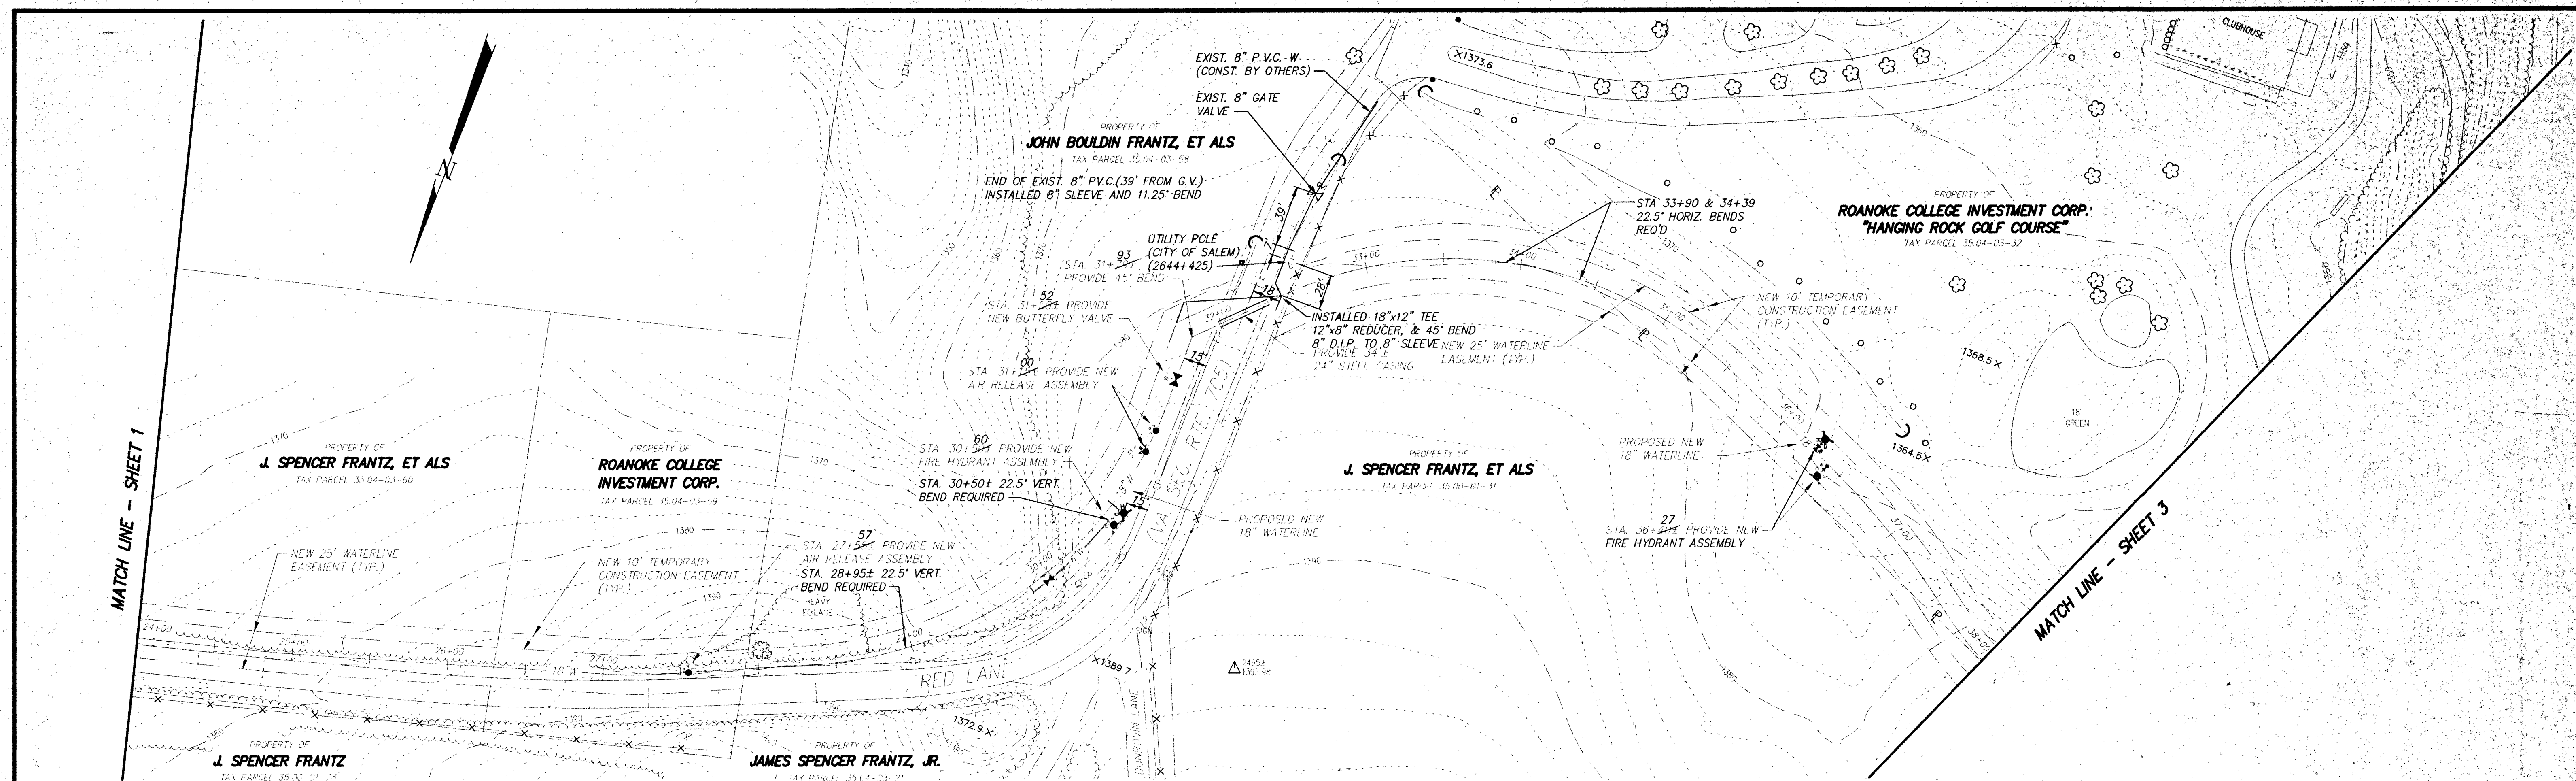

SCALES: 1" = 50' HORIZONTAL  
1" = 10' VERTICAL

AS BUILT  
JULY 9, 1998  
WATERMAIN ONLY

1390  
1380  
1370  
1360

50' 25' 0' 50' 100' 1" = 50'

GRAPHIC SCALE

DESIGNED BY C.L. WHITE  
DRAWN BY J.P.R.  
CHECKED BY J.T.P.  
W.O. # 92-1077  
N.B. RKE CO. PROJ. #  
TAX NO. \_\_\_\_\_

COMMONWEALTH OF VIRGINIA  
JOHN T. PARKER  
NO. 5447  
PROFESSIONAL ENGINEER

PLAN AND PROFILE  
FOR  
**NORTH LOOP WATER TRANSMISSION MAIN  
PHASE 4**  
FOR  
**THE COUNTY OF ROANOKE**  
SITUATE: CATAMBA MAGISTERIAL DISTRICT  
COUNTY OF ROANOKE, VIRGINIA  
SCALE: AS SHOWN DATE: DECEMBER 30, 1996

**T. P. PARKER & SON**  
**TPP&S**  
ENGINEERS  
SURVEYORS  
PLANNERS  
616 Boulevard  
Post Office Box 39  
Salem, Virginia 24153  
Telephone: 540-387-1153  
FAX: 540-389-5767