
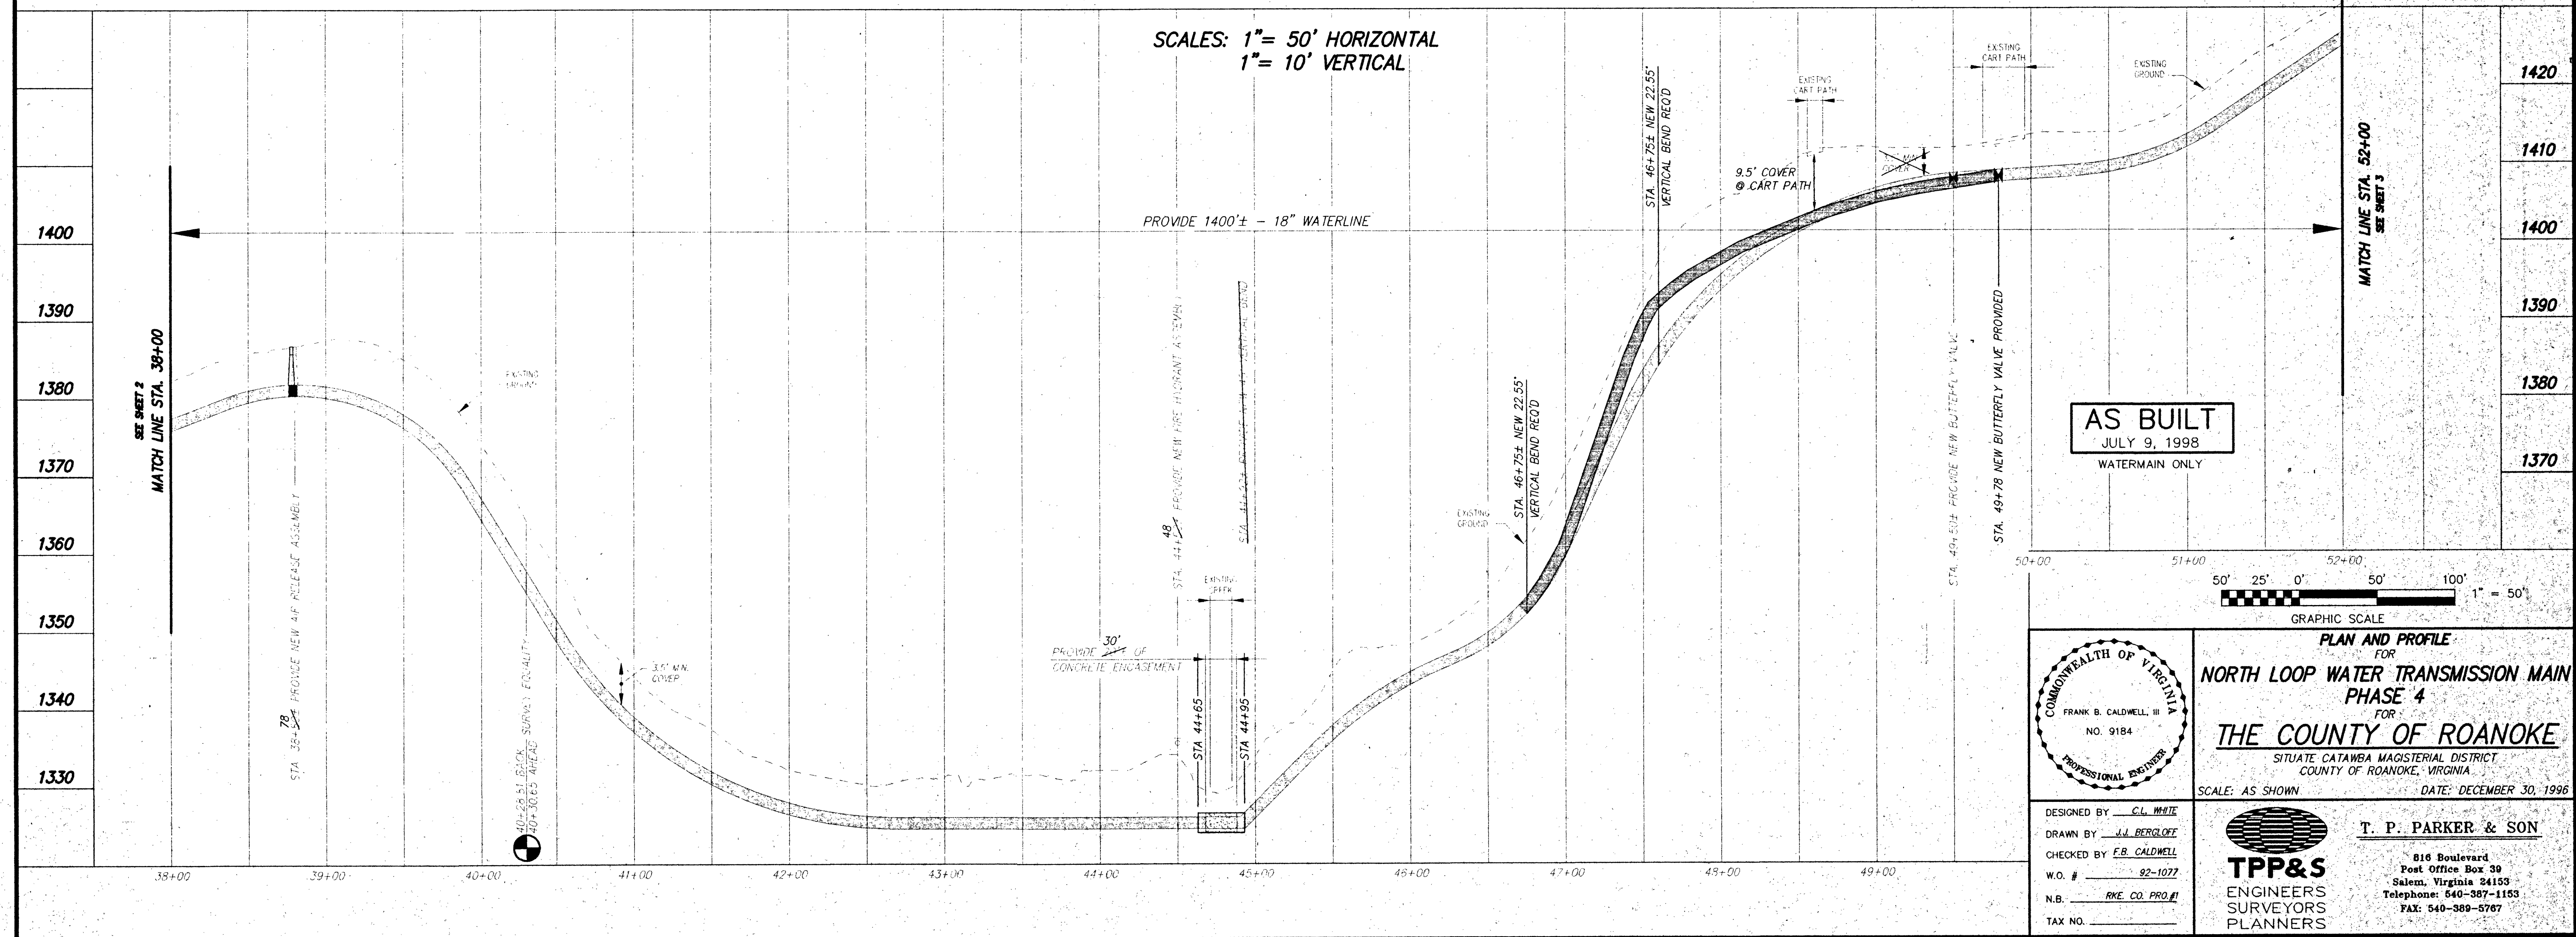


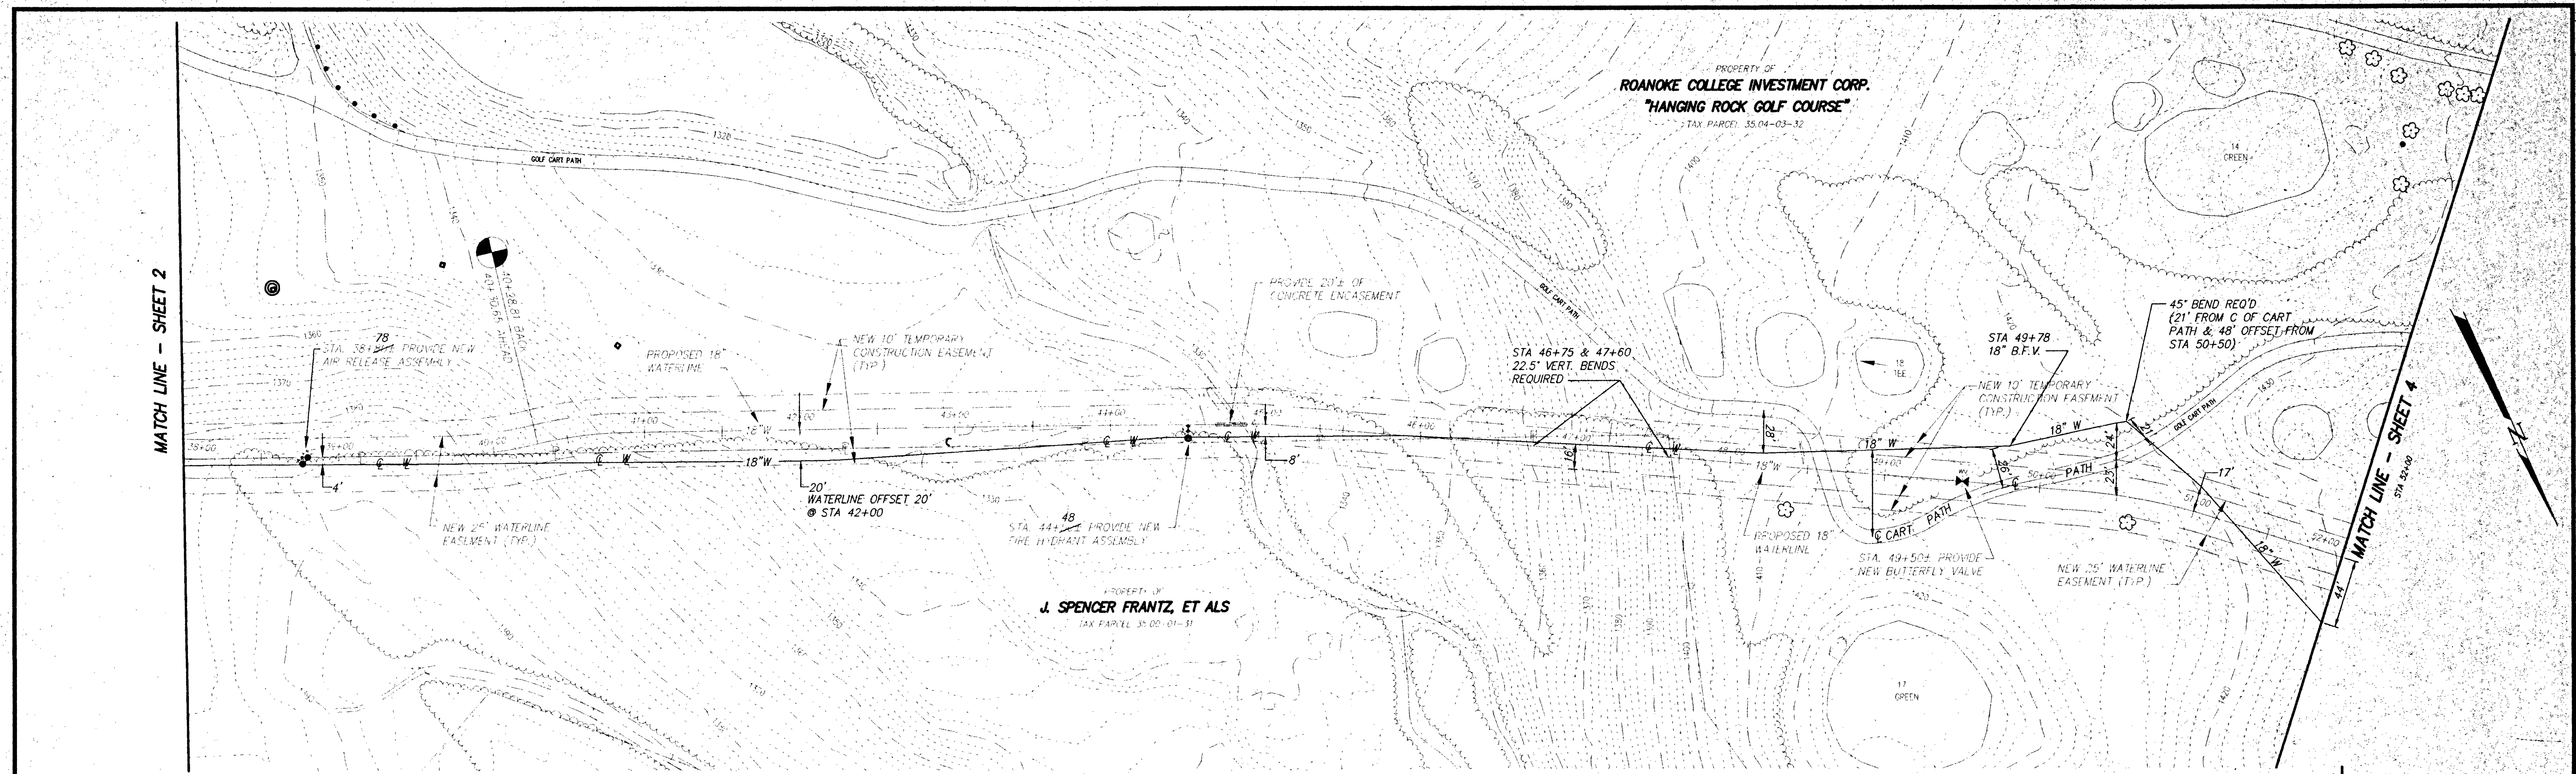

AS BUILT
JULY 9, 1998
WATERMAIN ONLY

GRAPHIC SCALE
50' 25' 0' 50' 100' 1" = 50'

COMMONWEALTH OF VIRGINIA
FRANK B. CALDWELL, III
NO. 9184
PROFESSIONAL ENGINEER

PLAN AND PROFILE FOR
NORTH LOOP WATER TRANSMISSION MAIN
PHASE 4
FOR
THE COUNTY OF ROANOKE
SITUATE CATAMBA MAGISTERIAL DISTRICT
COUNTY OF ROANOKE, VIRGINIA
SCALE: AS SHOWN DATE: DECEMBER 30, 1996

DESIGNED BY: C.L. WHITE
DRAWN BY: J.J. BERGLOFF
CHECKED BY: F.B. CALDWELL
W.O. #: 92-1077
N.B.: RKE CO. PROJ.
TAX NO.:

T. P. PARKER & SON
816 Boulevard
Post Office Box 39
Salem, Virginia 24153
Telephone: 540-387-1153
FAX: 540-389-5767

TPP&S
ENGINEERS
SURVEYORS
PLANNERS