


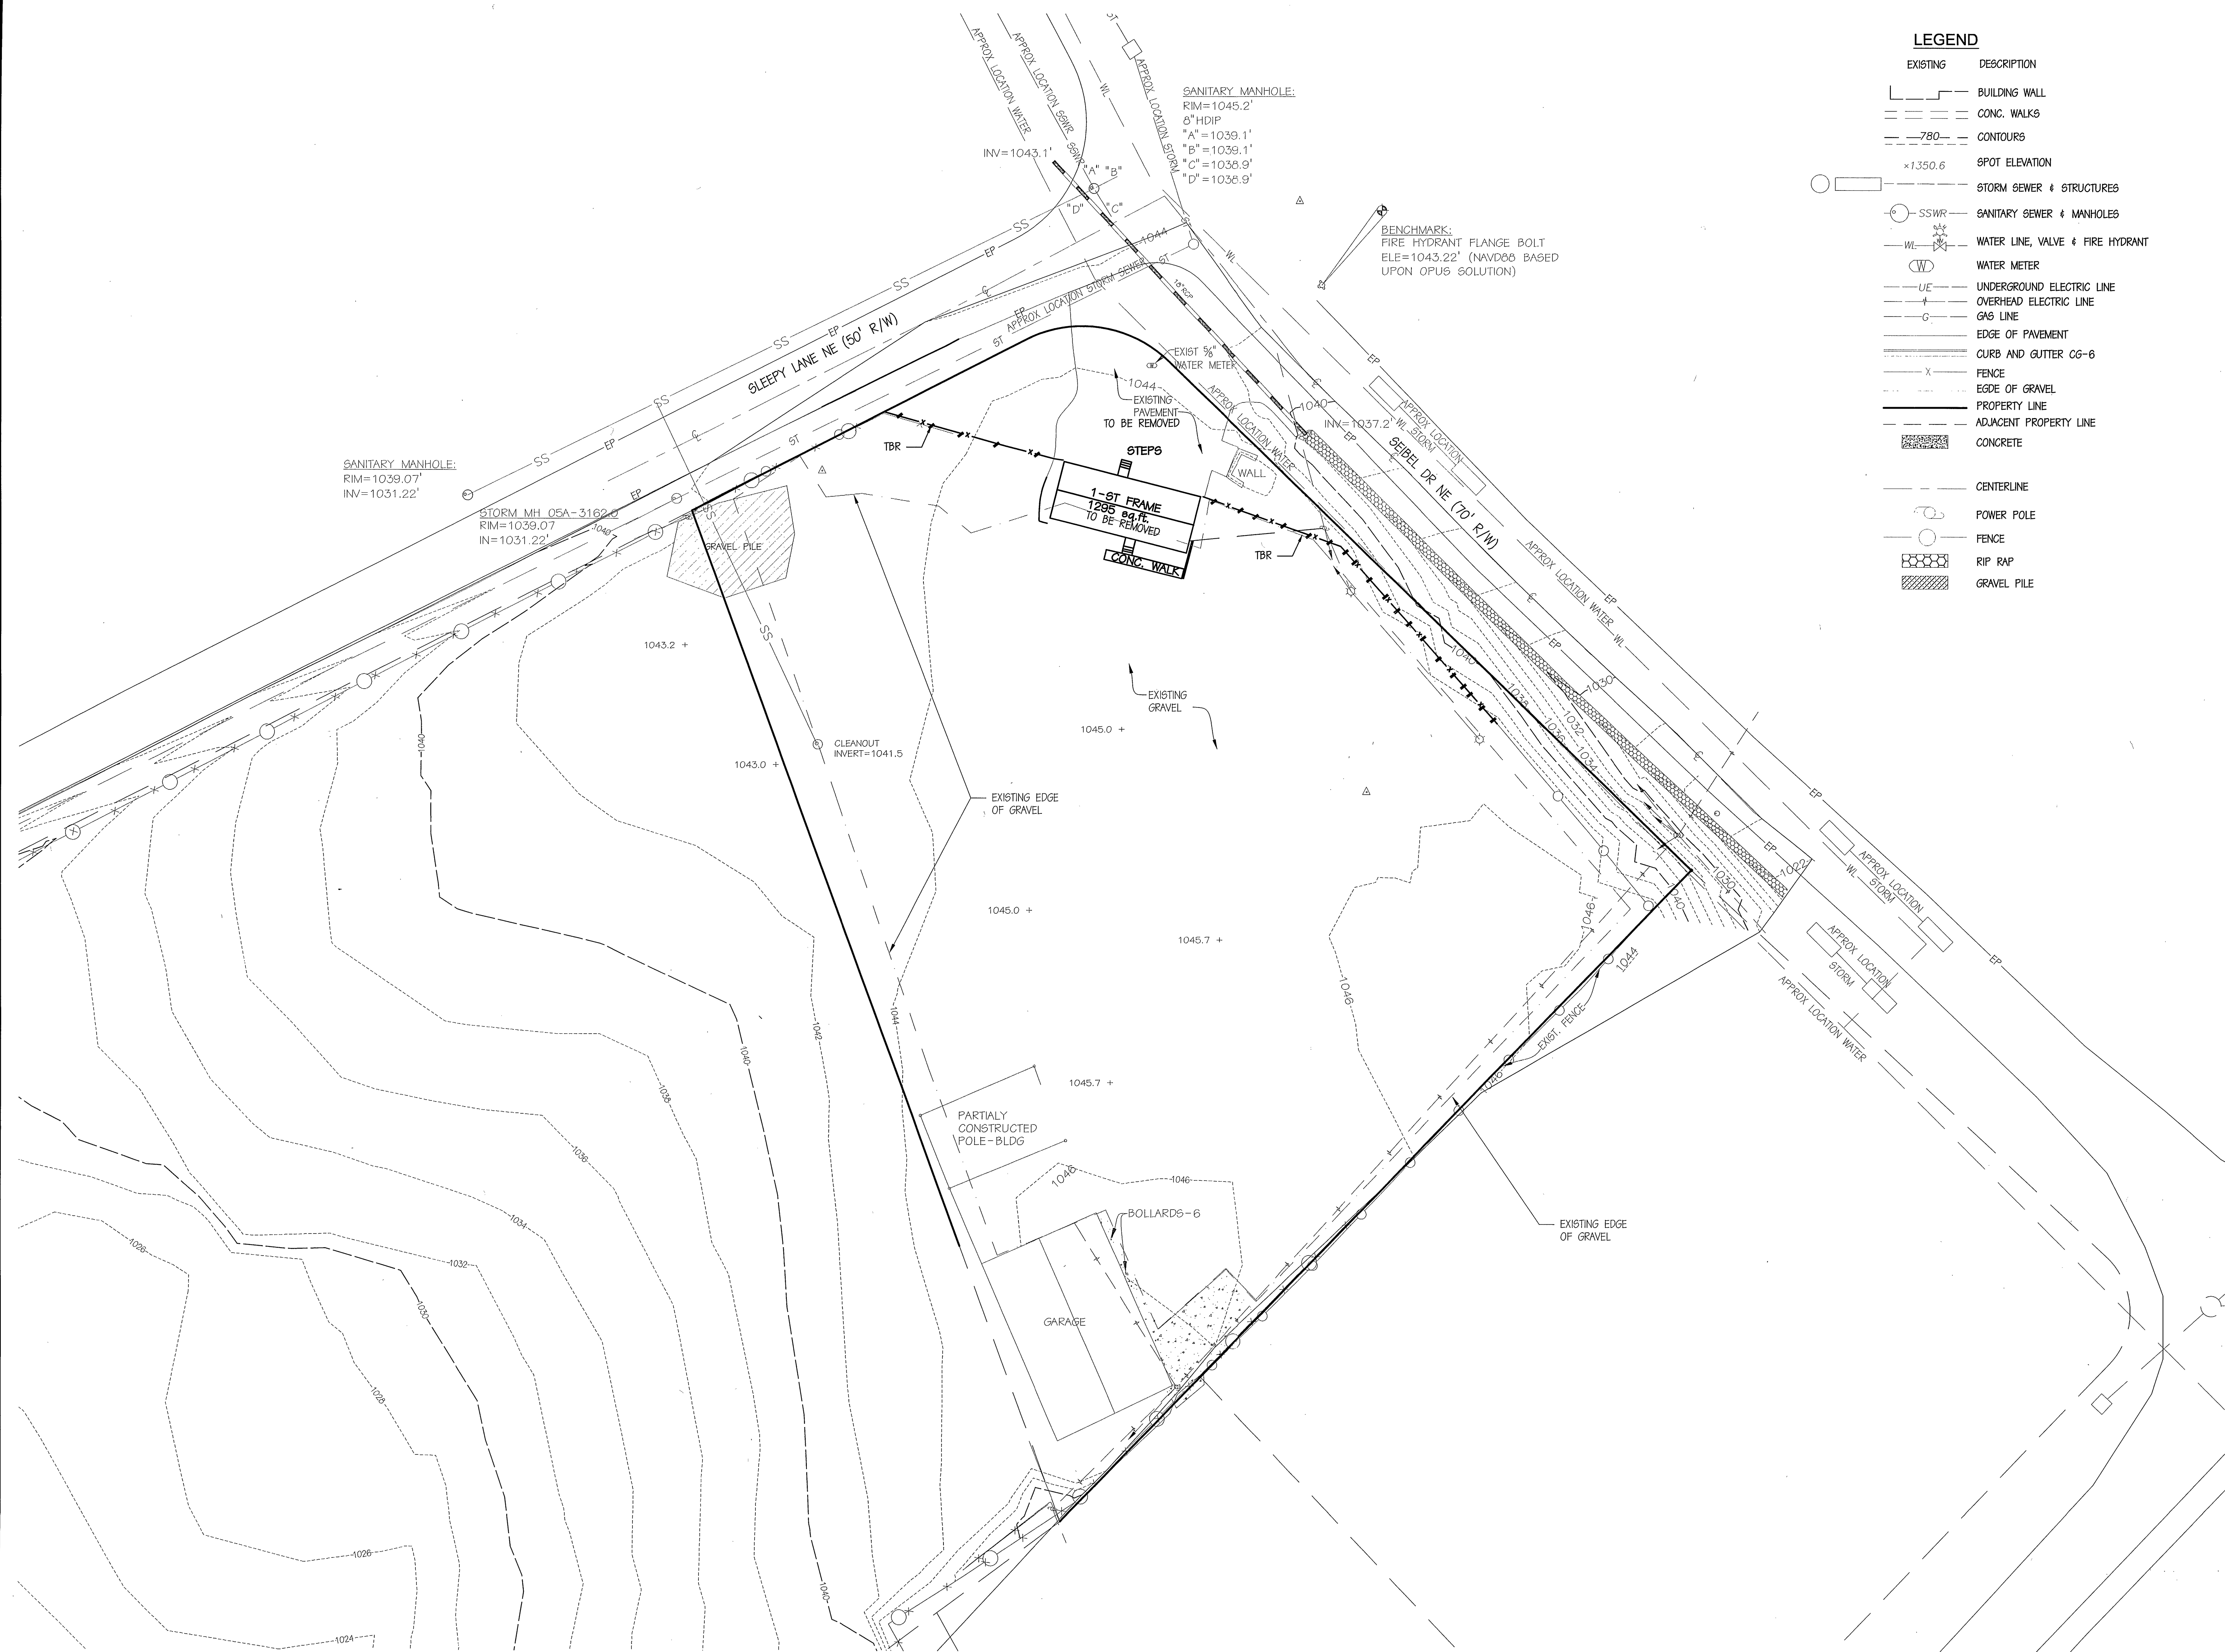

LEGEND



- | EXISTING | DESCRIPTION |
|----------|----------------------------------|
| [Symbol] | BUILDING WALL |
| [Symbol] | CONC. WALKS |
| [Symbol] | CONTOURS |
| [Symbol] | SPOT ELEVATION |
| [Symbol] | STORM SEWER & STRUCTURES |
| [Symbol] | SANITARY SEWER & MANHOLES |
| [Symbol] | WATER LINE, VALVE & FIRE HYDRANT |
| [Symbol] | WATER METER |
| [Symbol] | UNDERGROUND ELECTRIC LINE |
| [Symbol] | OVERHEAD ELECTRIC LINE |
| [Symbol] | GAS LINE |
| [Symbol] | EDGE OF PAVEMENT |
| [Symbol] | CURB AND GUTTER CG-6 |
| [Symbol] | FENCE |
| [Symbol] | EDGE OF GRAVEL |
| [Symbol] | PROPERTY LINE |
| [Symbol] | ADJACENT PROPERTY LINE |
| [Symbol] | CONCRETE |
| [Symbol] | CENTERLINE |
| [Symbol] | POWER POLE |
| [Symbol] | FENCE |
| [Symbol] | RIP RAP |
| [Symbol] | GRAVEL PILE |

PERKINS & ORRISON
ENGINEERS ▲ PLANNERS ▲ SURVEYORS

27 GREEN HILL DRIVE, FOREST, VIRGINIA 24551
PHONE: 434-525-5985 FAX: 434-525-5986
EMAIL: pno@perkins-orrison.com

PO BOX 1567 17 W. NELSON STREET LEXINGTON, VIRGINIA 24450
PHONE: 540-464-9001 FAX: 540-464-5009
EMAIL: PNO@PERKINS-ORRISON.COM

CONSULTANTS

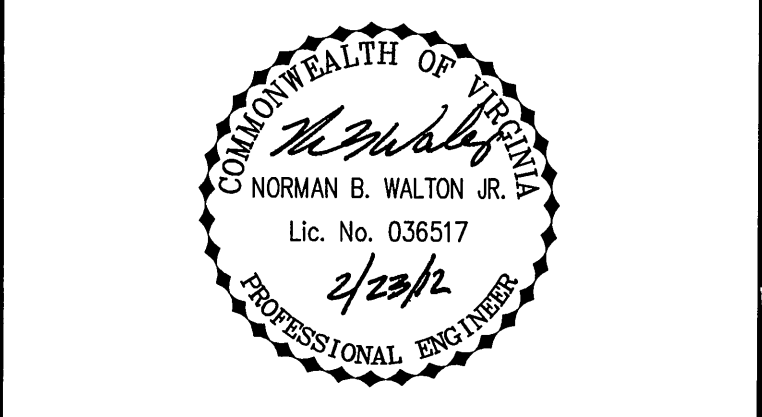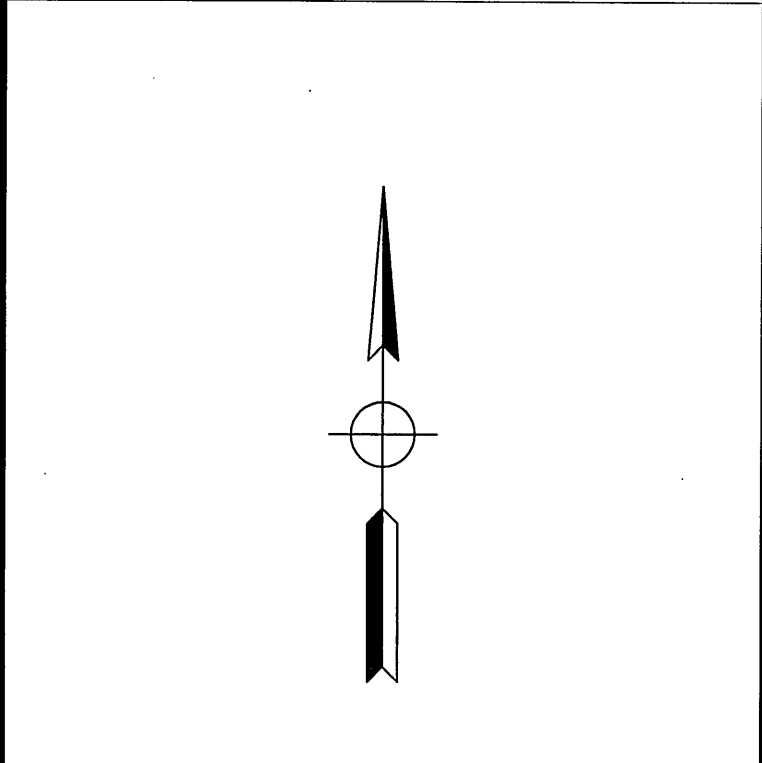

JOB:

**OLD DOMINION AUTO SALVAGE
SITE PLAN
CITY OF ROANOKE, VIRGINIA**

CLIENT:

**W.A. STRATTON
JEFF MOTLEY**

6	2/23/12	PER ROANOKE CITY COMMENTS
5	1/31/12	PER ROANOKE CITY COMMENTS
4	12/06/11	PER ROANOKE CITY COMMENTS
3	09/28/11	PER ROANOKE CITY COMMENTS
2	06/31/11	PER ROANOKE CITY COMMENTS
1	07/29/11	PER ROANOKE CITY COMMENTS

MARK	DATE	DESCRIPTION
ISSUE:	FEBRUARY 14, 2011	
CONTOUR INTERVAL:	2'	
DESIGNED BY:	NBW	
DRAWN BY:	MJD	
CHECKED BY:	NBW	

SHEET TITLE

**EXISTING CONDITIONS
& SITE DEMOLITION**

GRAPHIC SCALE
0 30 60
1"=30'

APPROVED
C-101 APR 25 2012

JOB NO: 10397 SHEET NO: 2 OF 8