


Old Dragon Chemical

FIRE PROTECTION GENERAL NOTES

- [illegible]

FRANKLIN CO. BUILDING INSPECTOR
DALE HOLLAND
(540)-329-3805

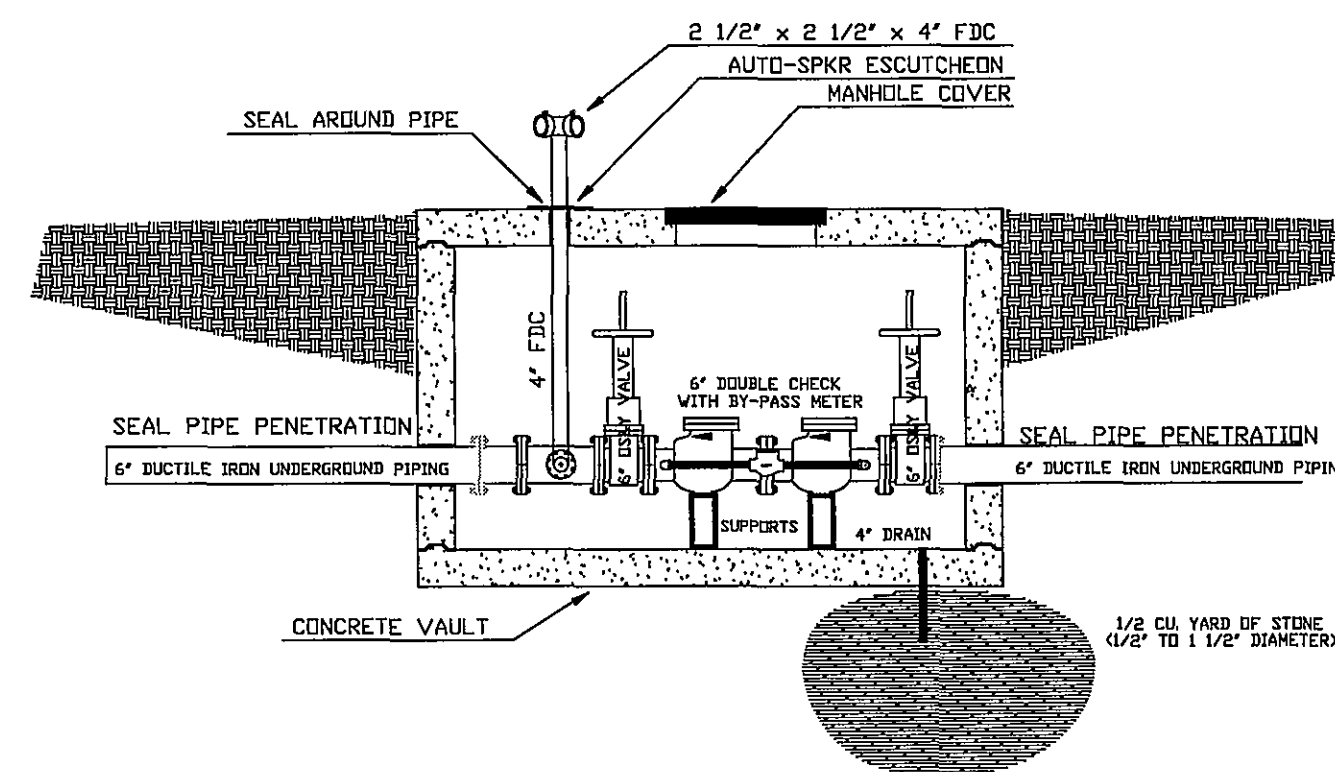


VALVE PIT DETAIL

NOT TO SCALE


WATER INFORMATION

STATIC : 72 p.s.i.
RESIDUAL : 58 p.s.i.
FLOW : 1100 gpm
TEST TAKEN 4-4-08
BY W.V.W.A & M.C.S.

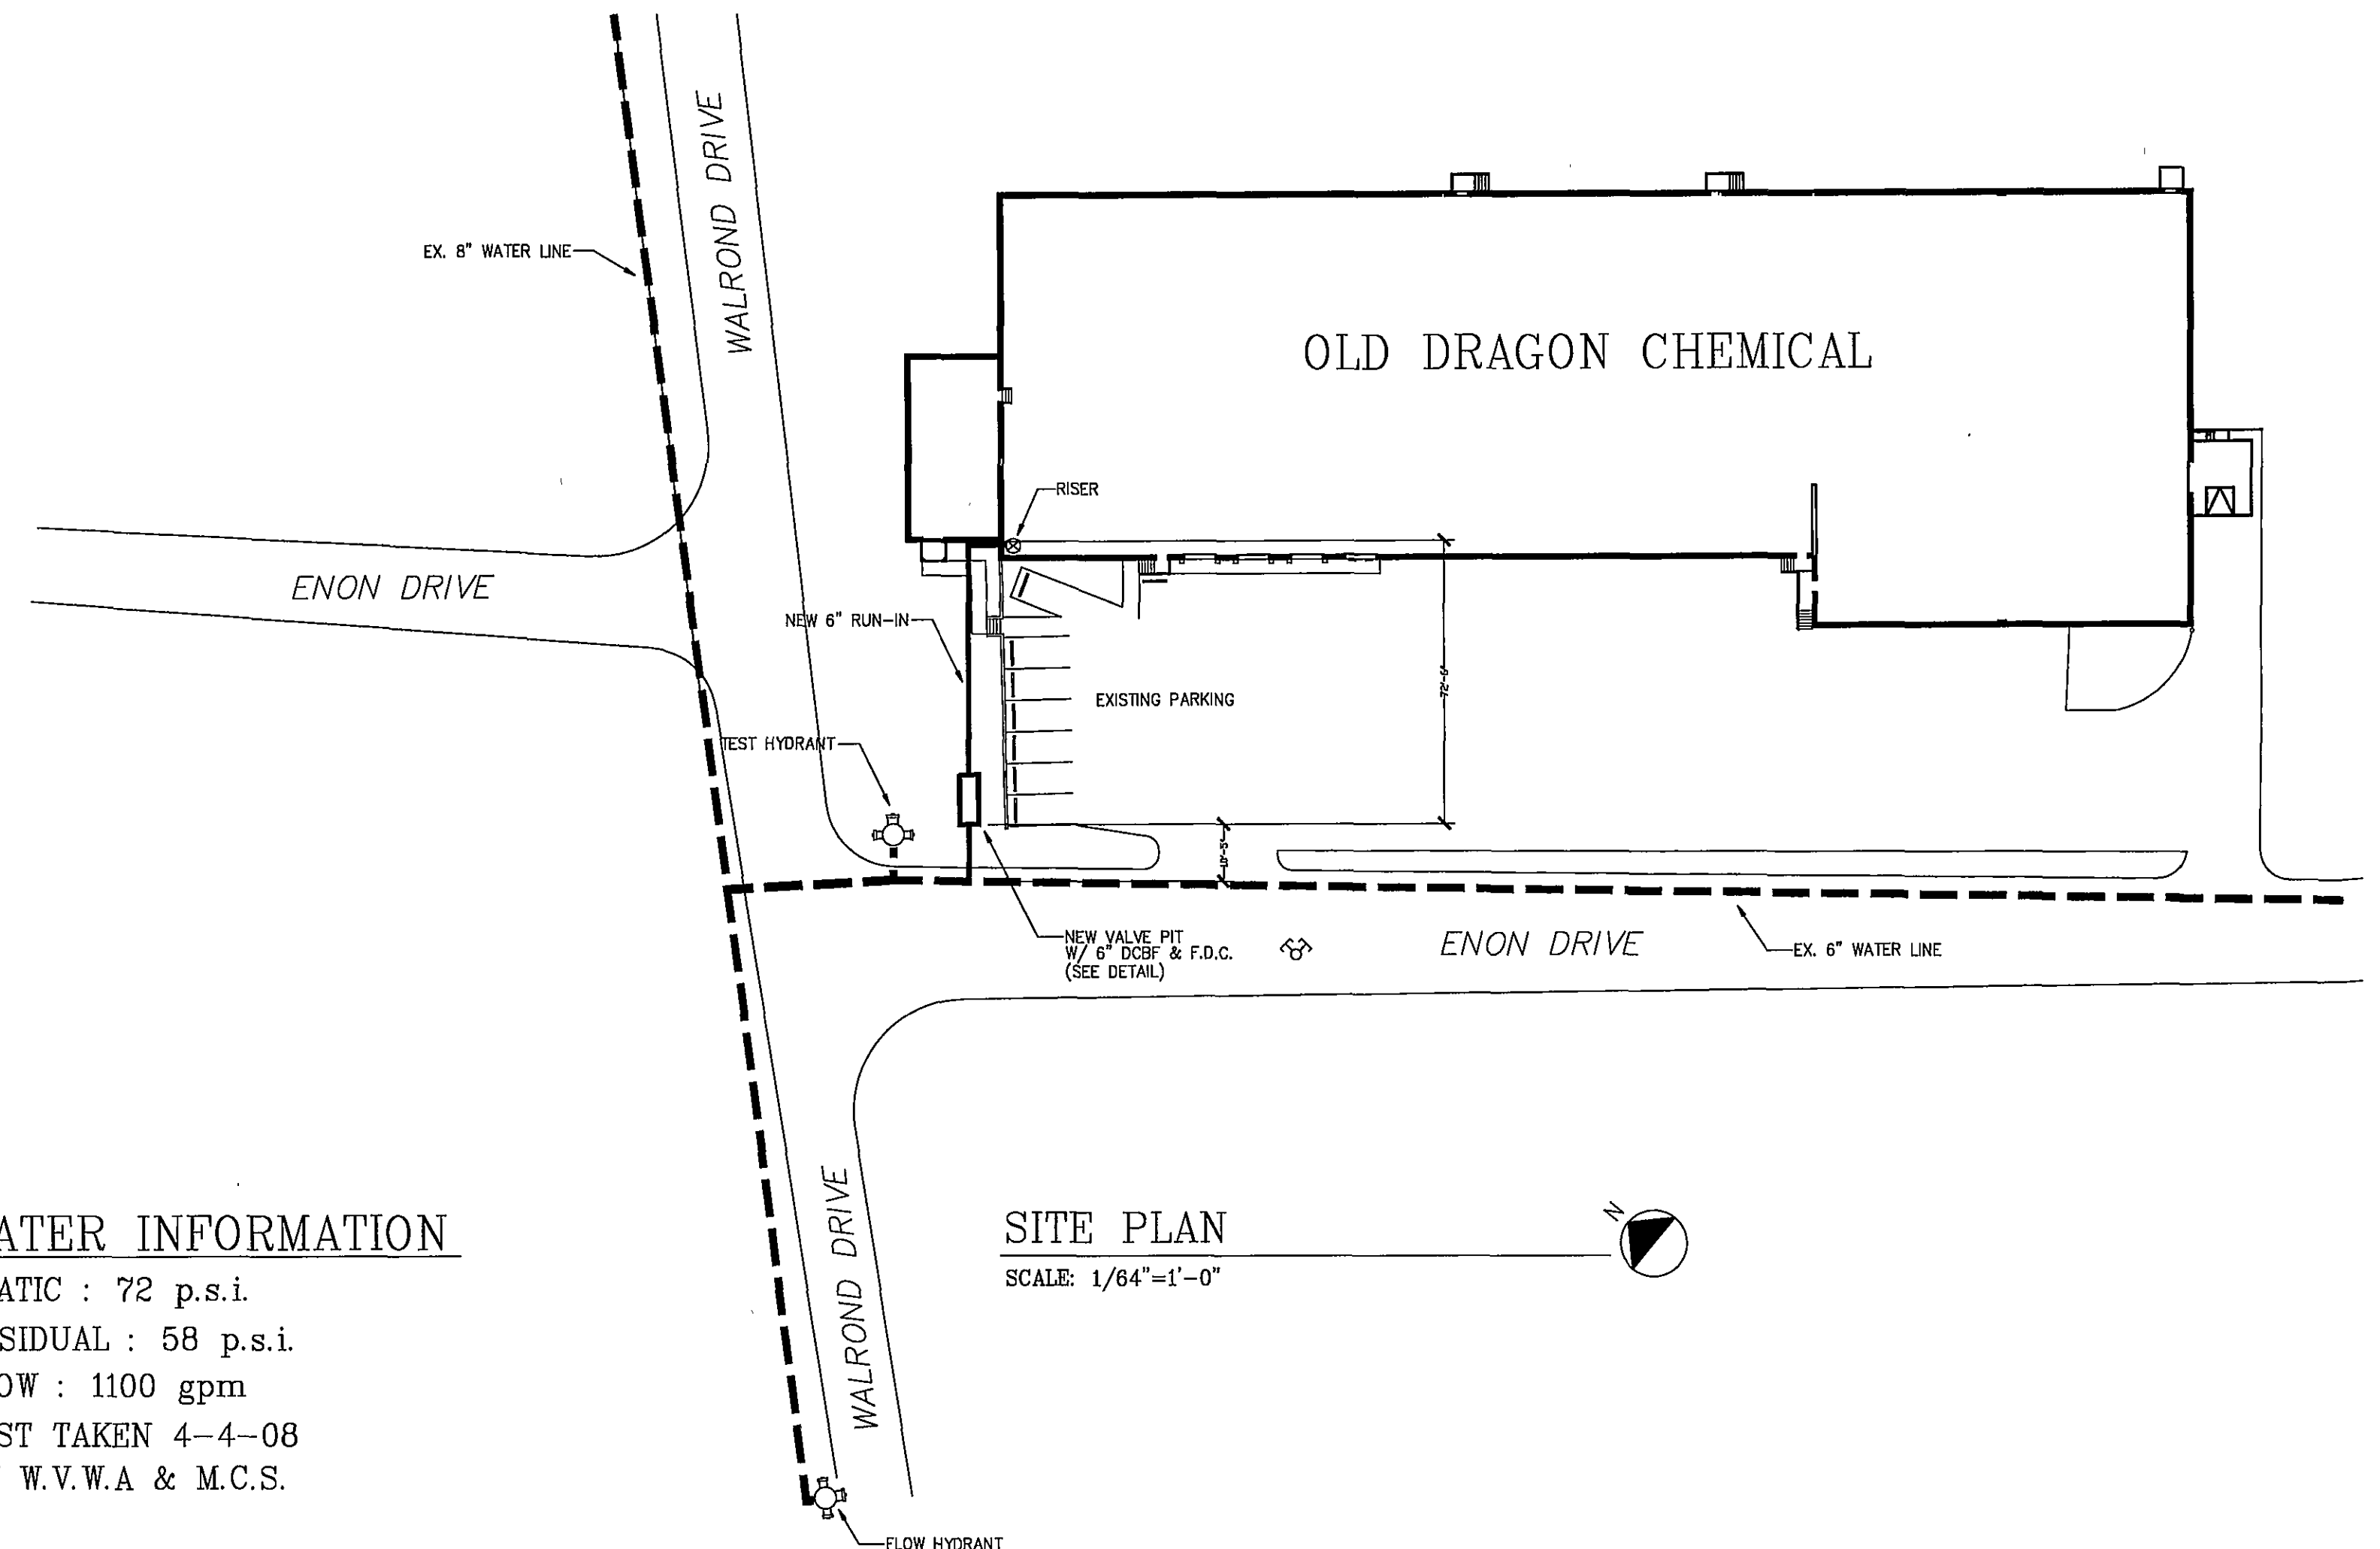


SITE PLAN

SCALE: 1/64"=1'-0"

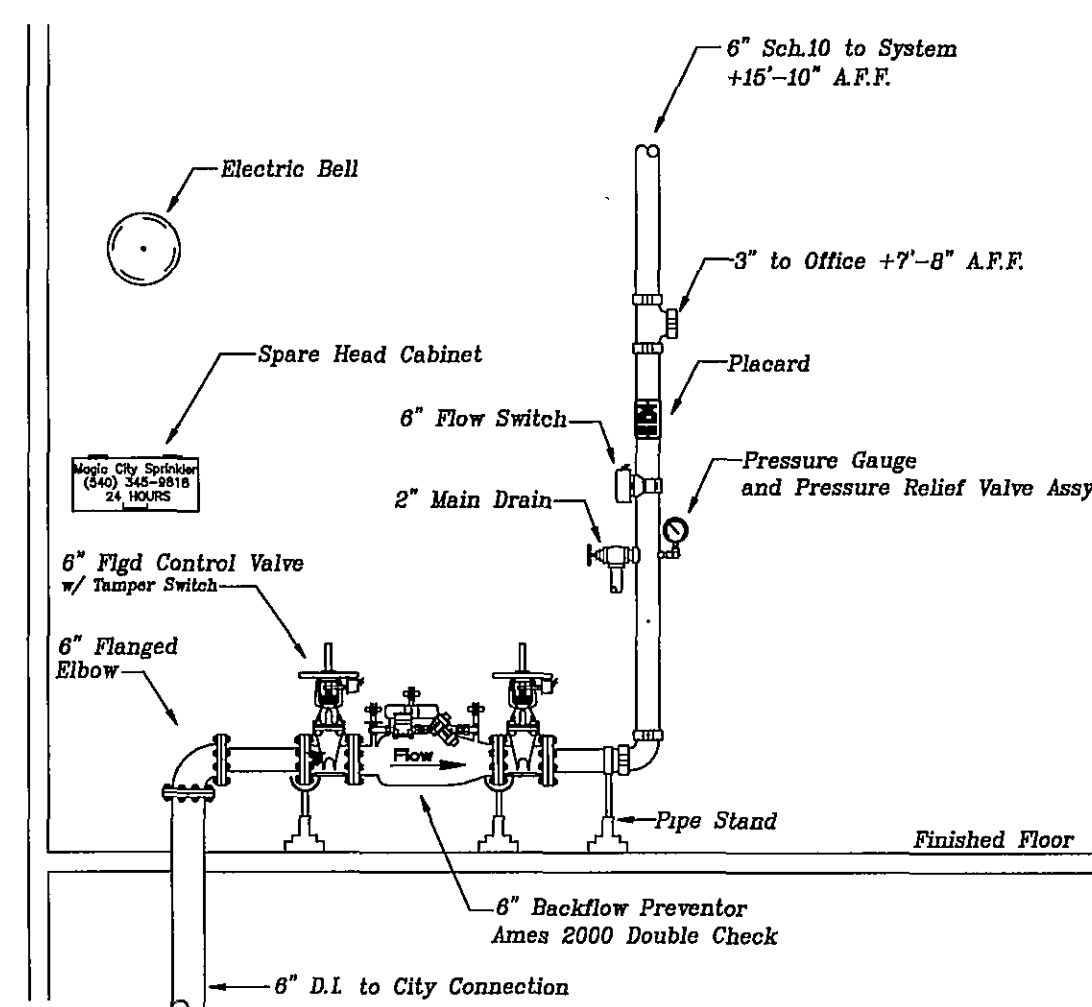


RISER DETAIL

NOT TO SCALE

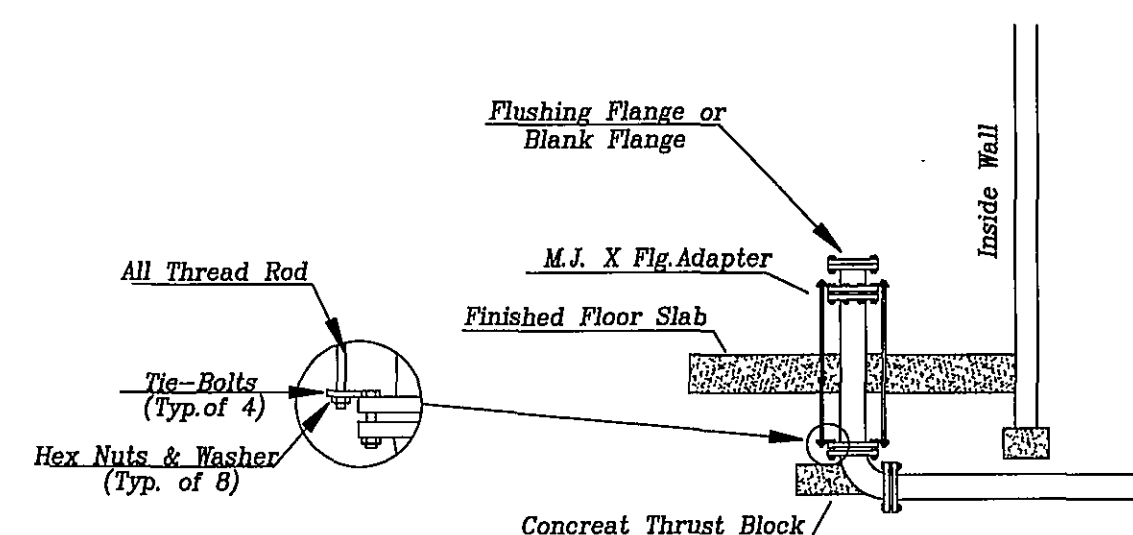

TYPICAL STUB-IN DETAIL

NOT TO SCALE

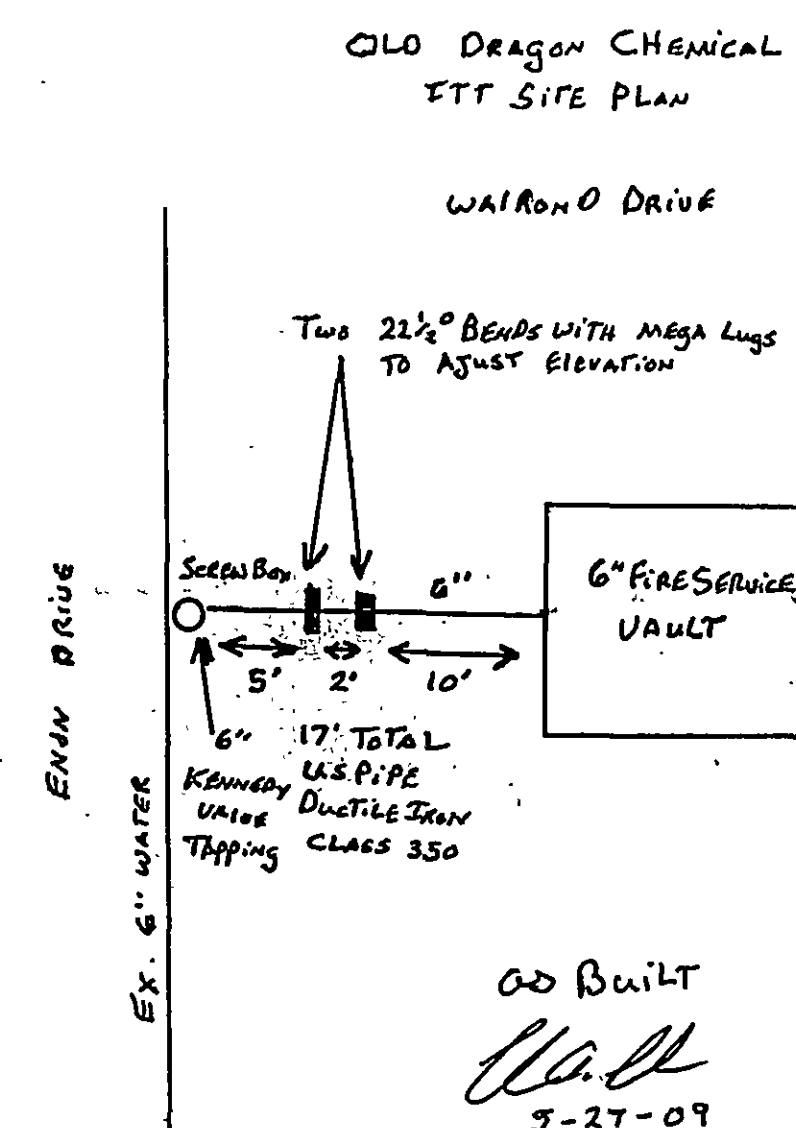[illegible]