



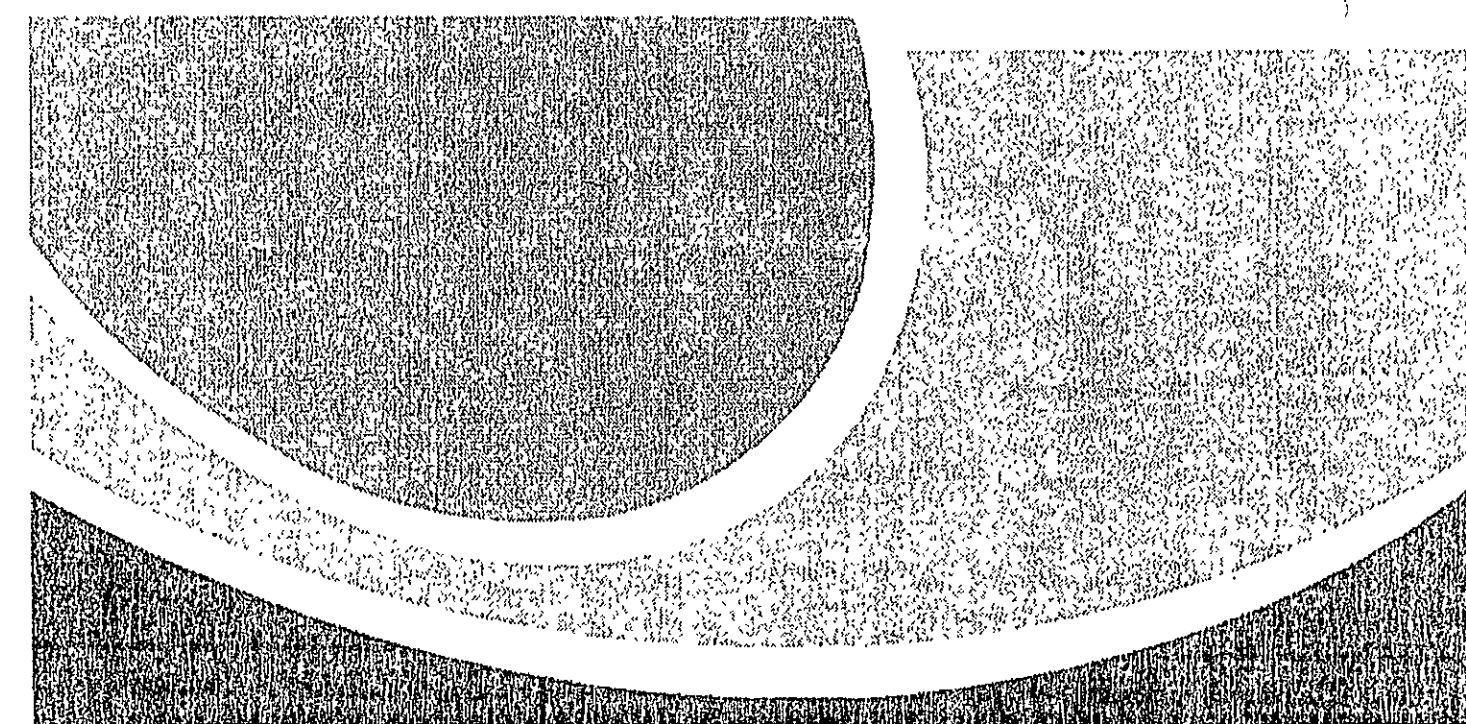

WESTERN VIRGINIA
WATER AUTHORITY

WESTERN VIRGINIA
WATER AUTHORITY
SUITE 200
2012 S. JEFFERSON STREET
ROANOKE, VIRGINIA 24014

CONSULTING ENGINEERS

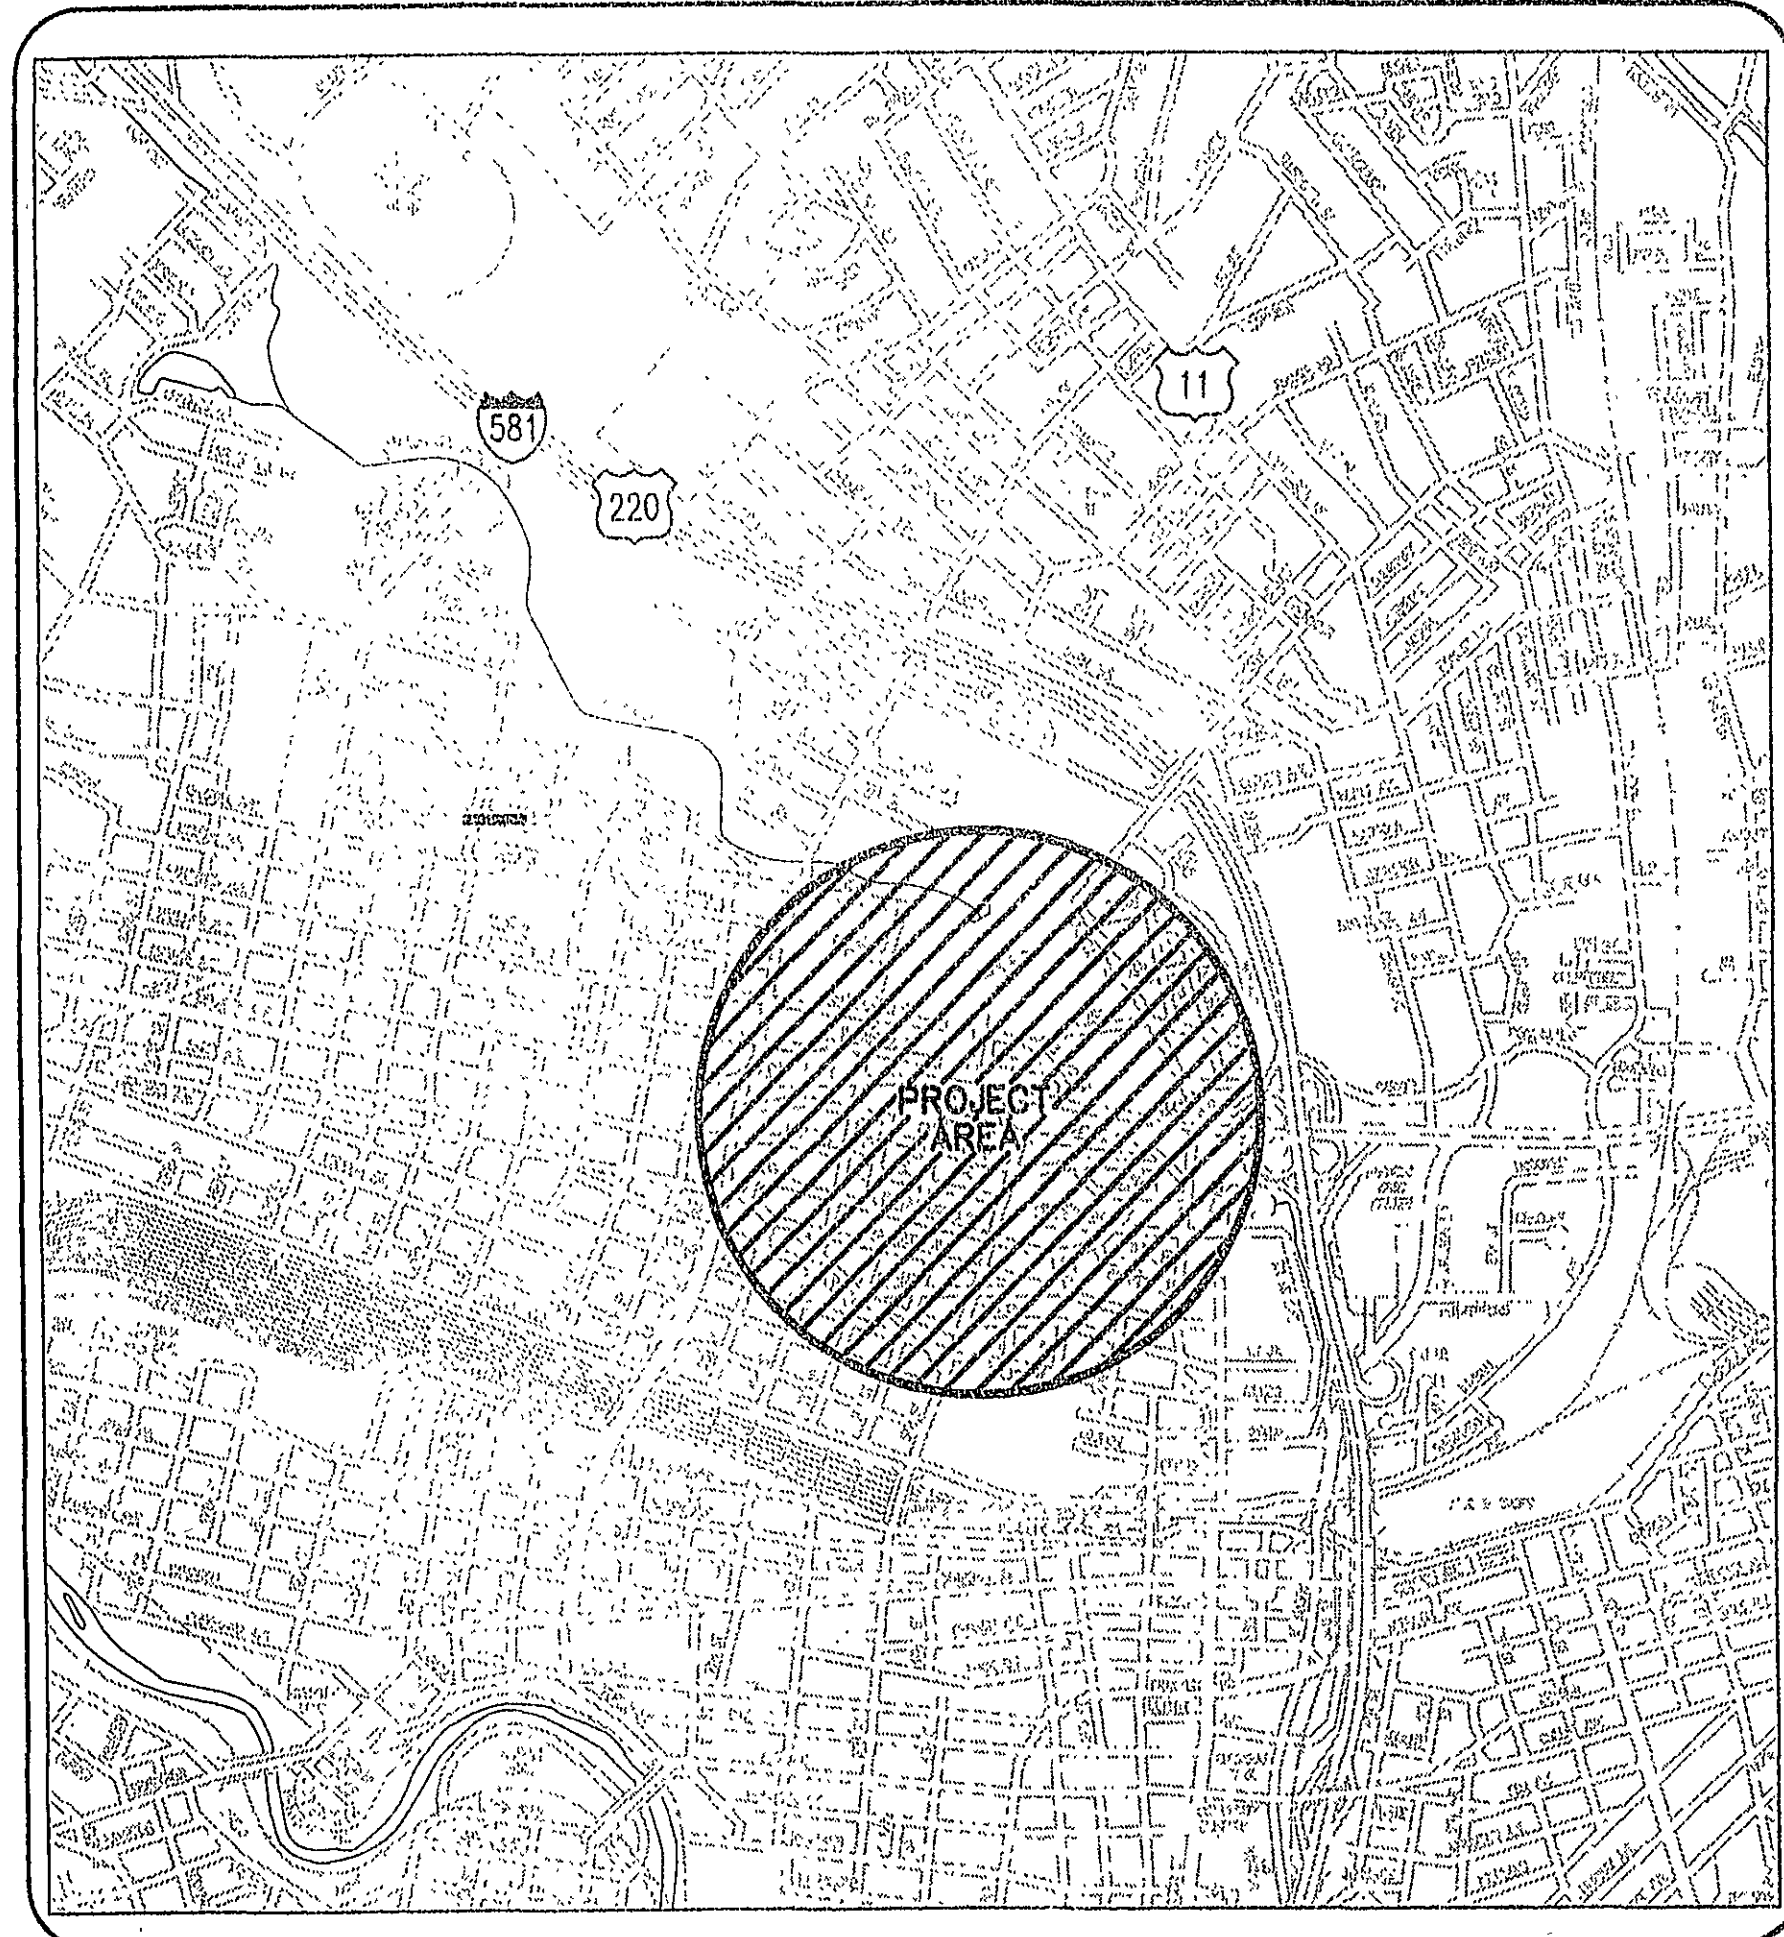


Mattern & Craig, Inc.

CONSULTING ENGINEERS
SURVEYORS

701 FIRST STREET, S.W.
ROANOKE, VIRGINIA 24016
(540) 345-9342
(540) 345-7691 FAX

COMMISSION NUMBER: 2120A

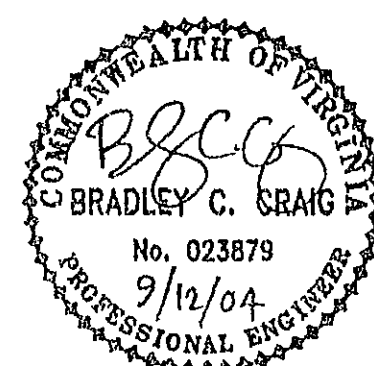

PROJECT NAME

ORANGE AVE.
WATER LINE PROJECT
ROANOKE, VIRGINIA

PROJECT NUMBER: 04-04

REVISION BY

DESCRIPTION:

DATE

REVISION BY

DESCRIPTION:

DATE

REVISION BY

DESCRIPTION:

DATE

REVISION BY

DESCRIPTION:

DATE

INDEX OF SHEETS

- 1 COVER SHEET
- 2 ABBREVIATIONS AND LEGEND
- 3 SHEET INDEX AND GENERAL NOTES
- 4 PLAN AND PROFILE- 12" WATERLINE
- 5 PLAN AND PROFILE- 12" WATERLINE
- 6 PLAN AND PROFILE- 12" WATERLINE
- 7 PLAN AND PROFILE- 12" WATERLINE
- 8 PLAN AND PROFILE- 12" WATERLINE
- 9 PLAN AND PROFILE- 12" WATERLINE
- 10 PLAN AND PROFILE- 12" WATERLINE

APPROVED FOR CONSTRUCTION

MANAGER OF ENGINEERING SERVICES

9.14.04
DATE

AUTHORITY DIRECTOR

9-14-04
DATE

DATE

DATE

DATE

ADVERTISED DATE: _____

SET NUMBER: 4

SHEET NUMBER: 1 OF 10

As-Builts - 06/02/2005

Orange Ave. As-Builts