

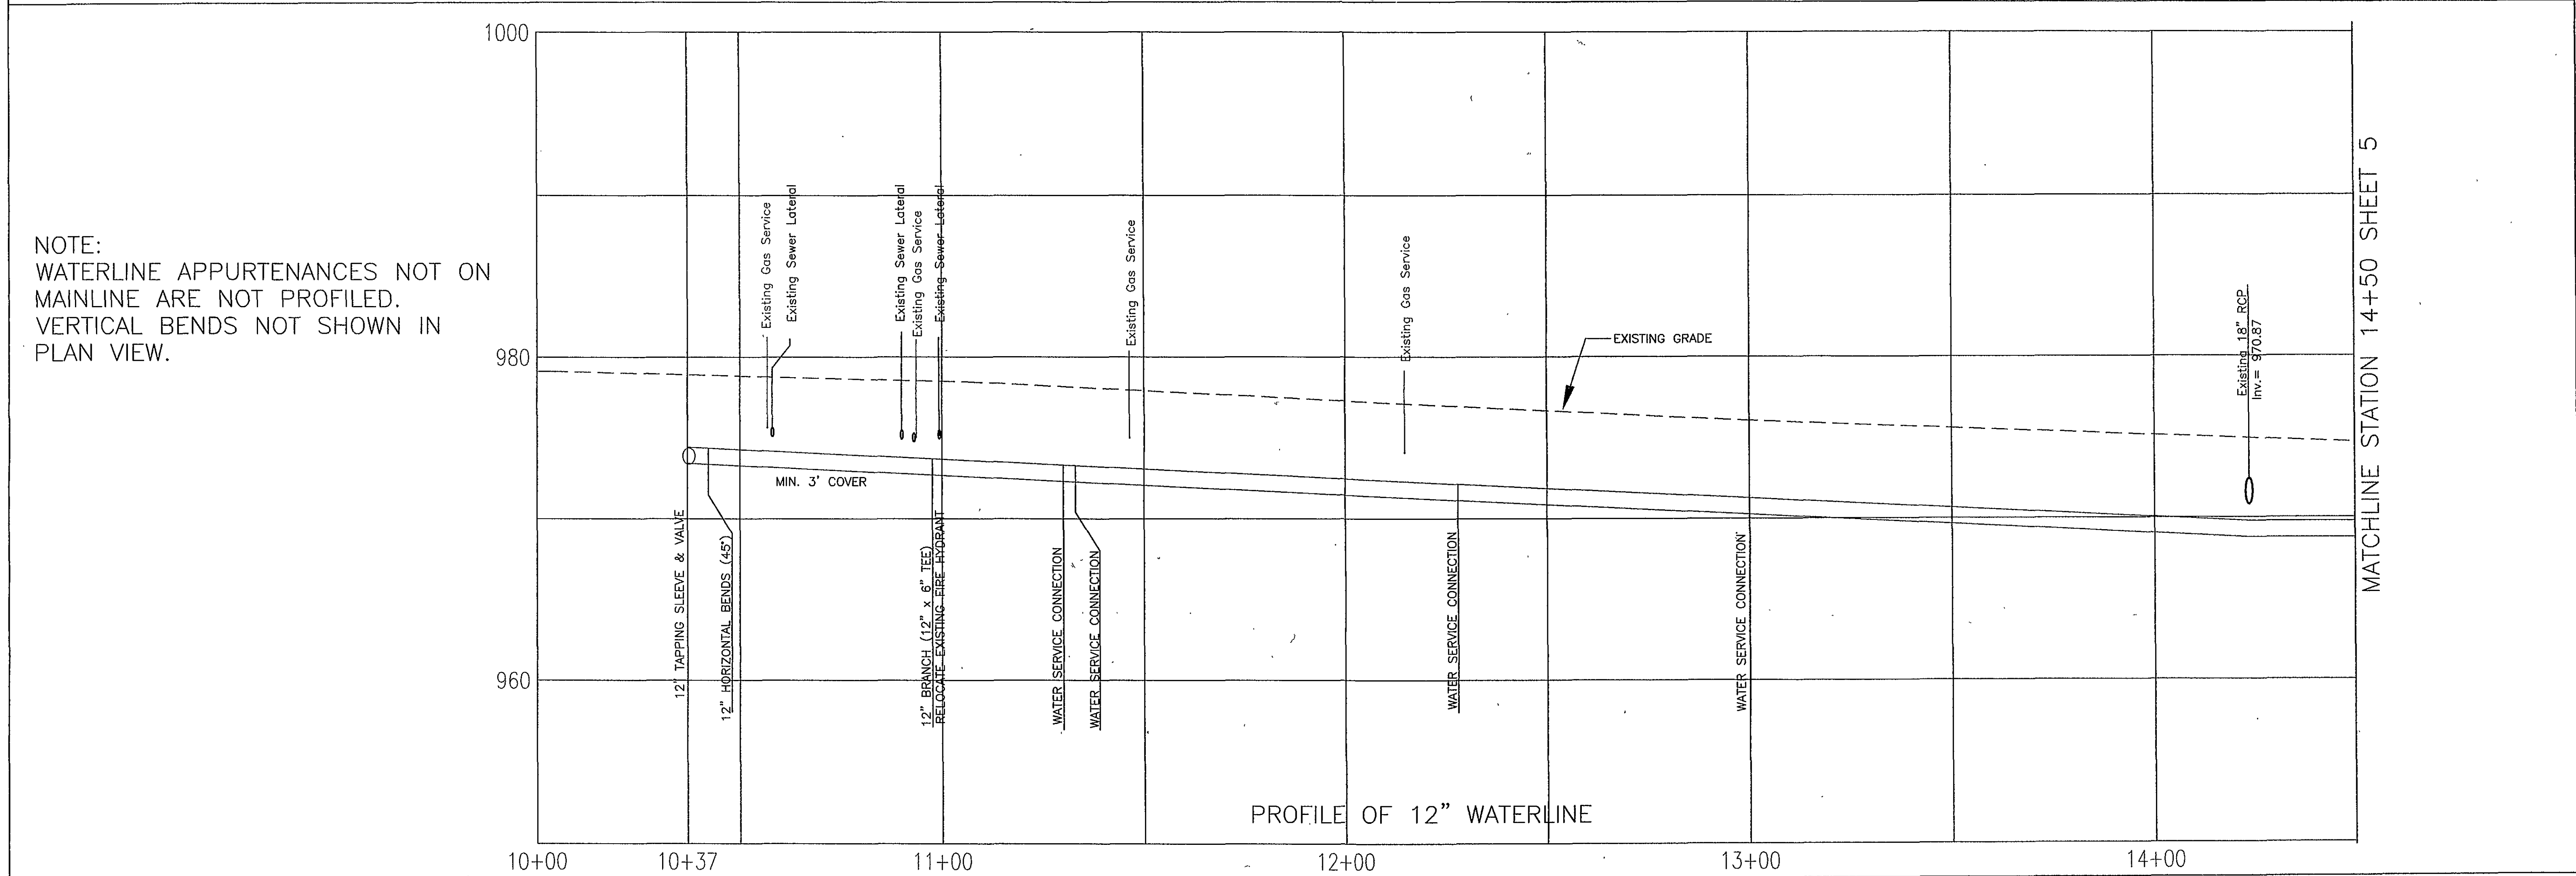


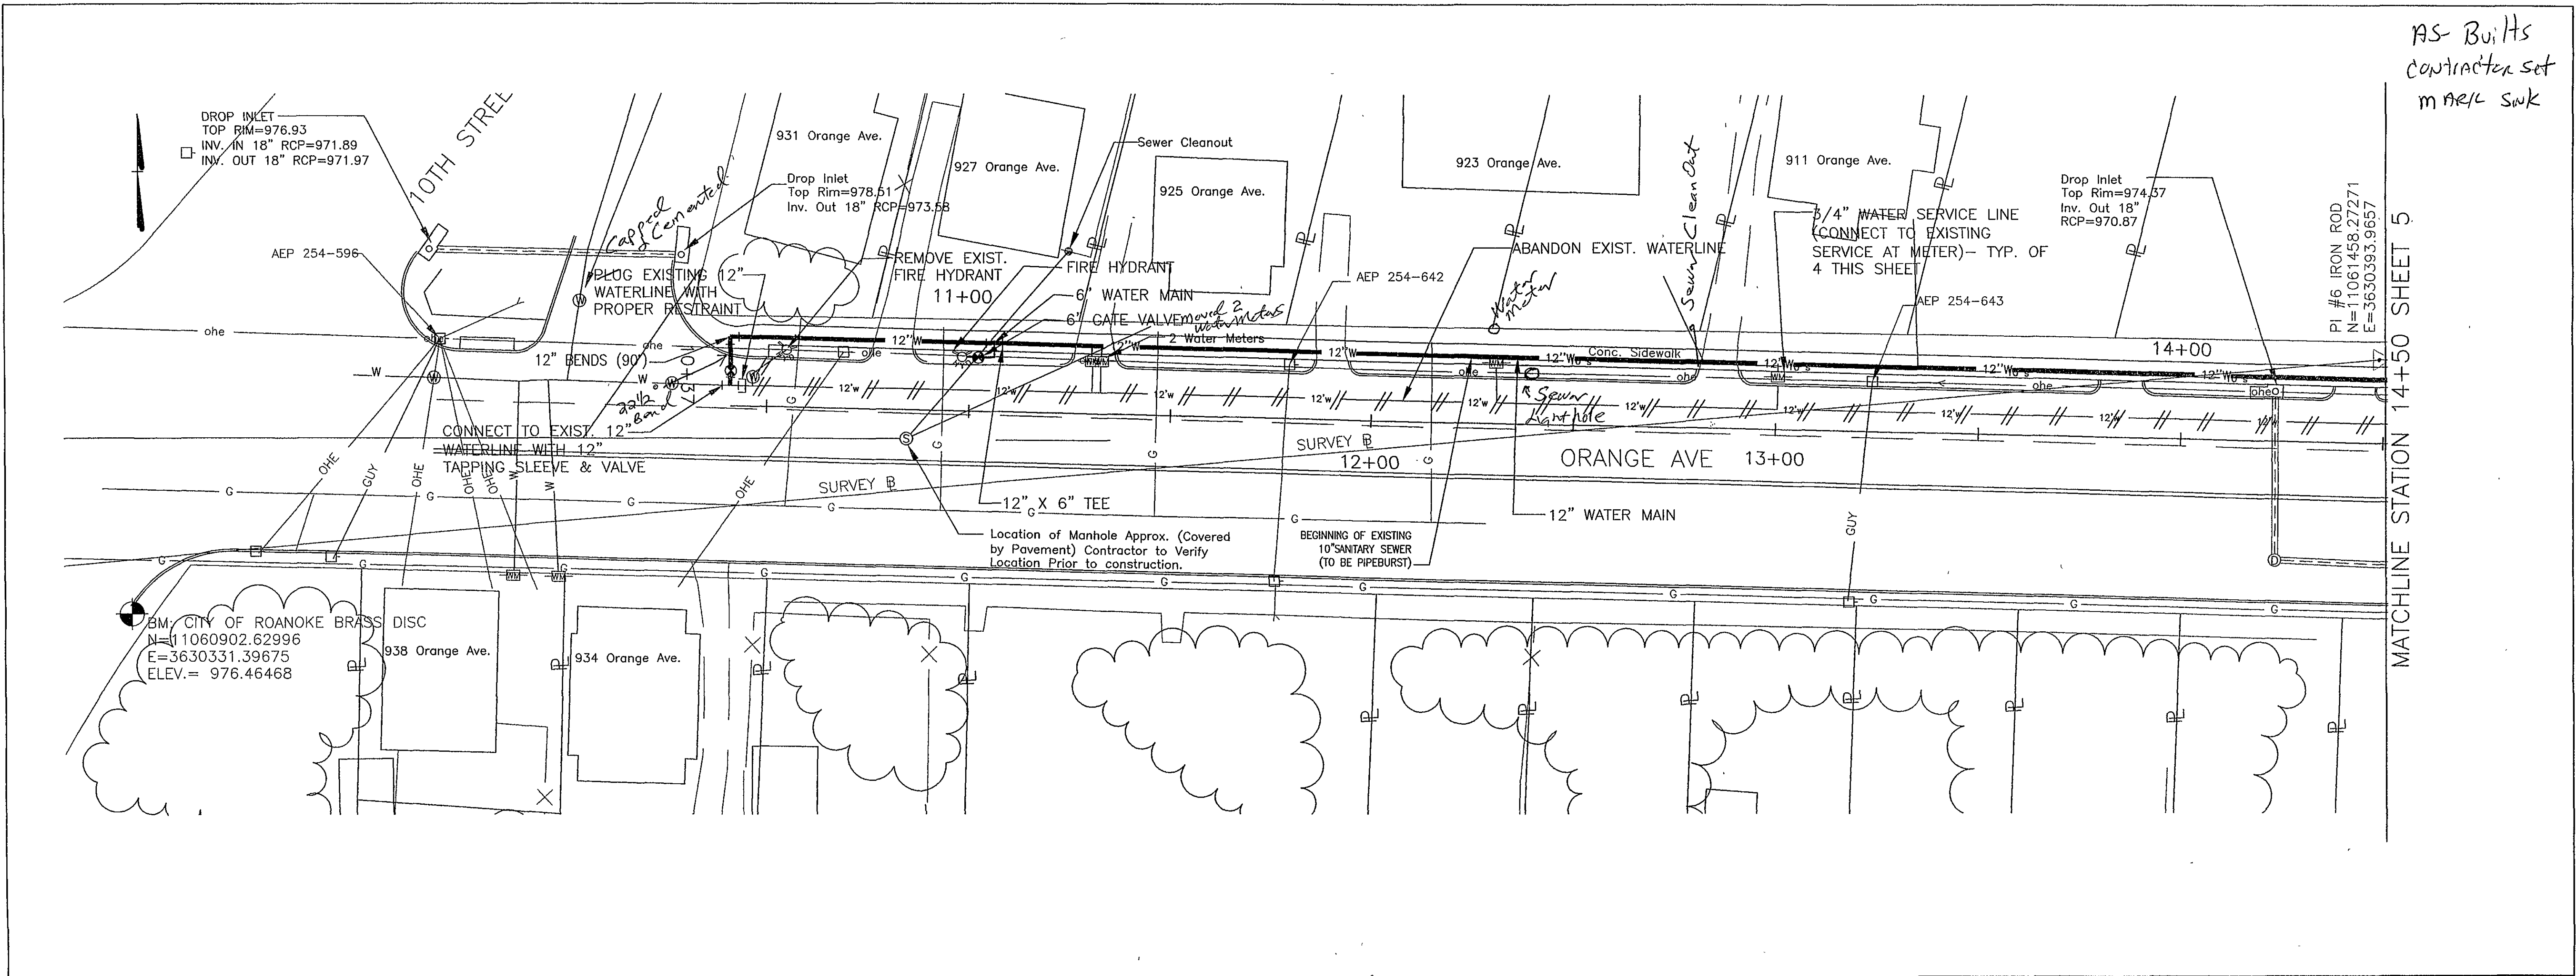

AS-BUILT
contractor set
m ARL SWK

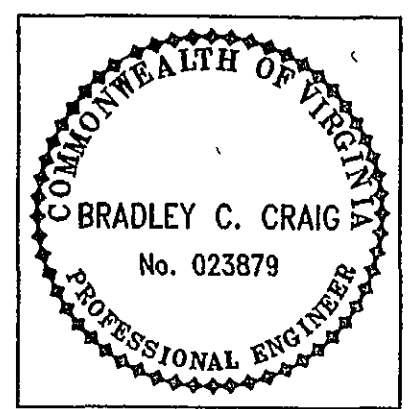

Date	
Revisions	

Issue Date: 4/6/04	Drawn By: DBL	Designed By: BCC	Checked By: SWH
			Date: 4/6/04

Mattem & Craig
CONSULTING ENGINEERS • SURVEYORS
701 FIRST STREET, S.W.
ROANOKE, VA 24016
(540) 346-9342
FAX (540) 346-7891

ORANGE AVE. WATER LINE PROJECT
**PLAN AND PROFILE -
12" WATERLINE**
ROANOKE, VIRGINIA

Vertical Scale: 1" = 5'	Sheet No.: 4
Horizontal Scale: 1" = 20'	
Commission Number: 2120A	