

MATCHLINE STATION 14+50 SHEET 4

MATCHLINE STATION 14+50 SHEET 4




940

MATCHLINE STATION 20+50 SHEET 6

MATCHLINE STATION 20+50 SHEET 6

940

NOTE:
WATERLINE APPURTENANCES NOT ON
MAINLINE ARE NOT PROFILED.
VERTICAL BENDS NOT SHOWN IN
PLAN VIEW.

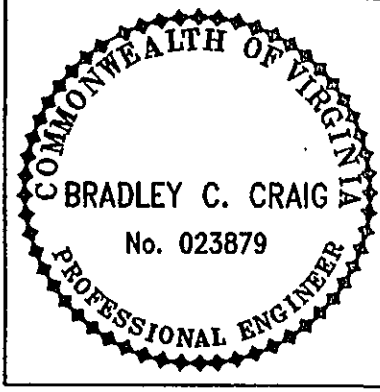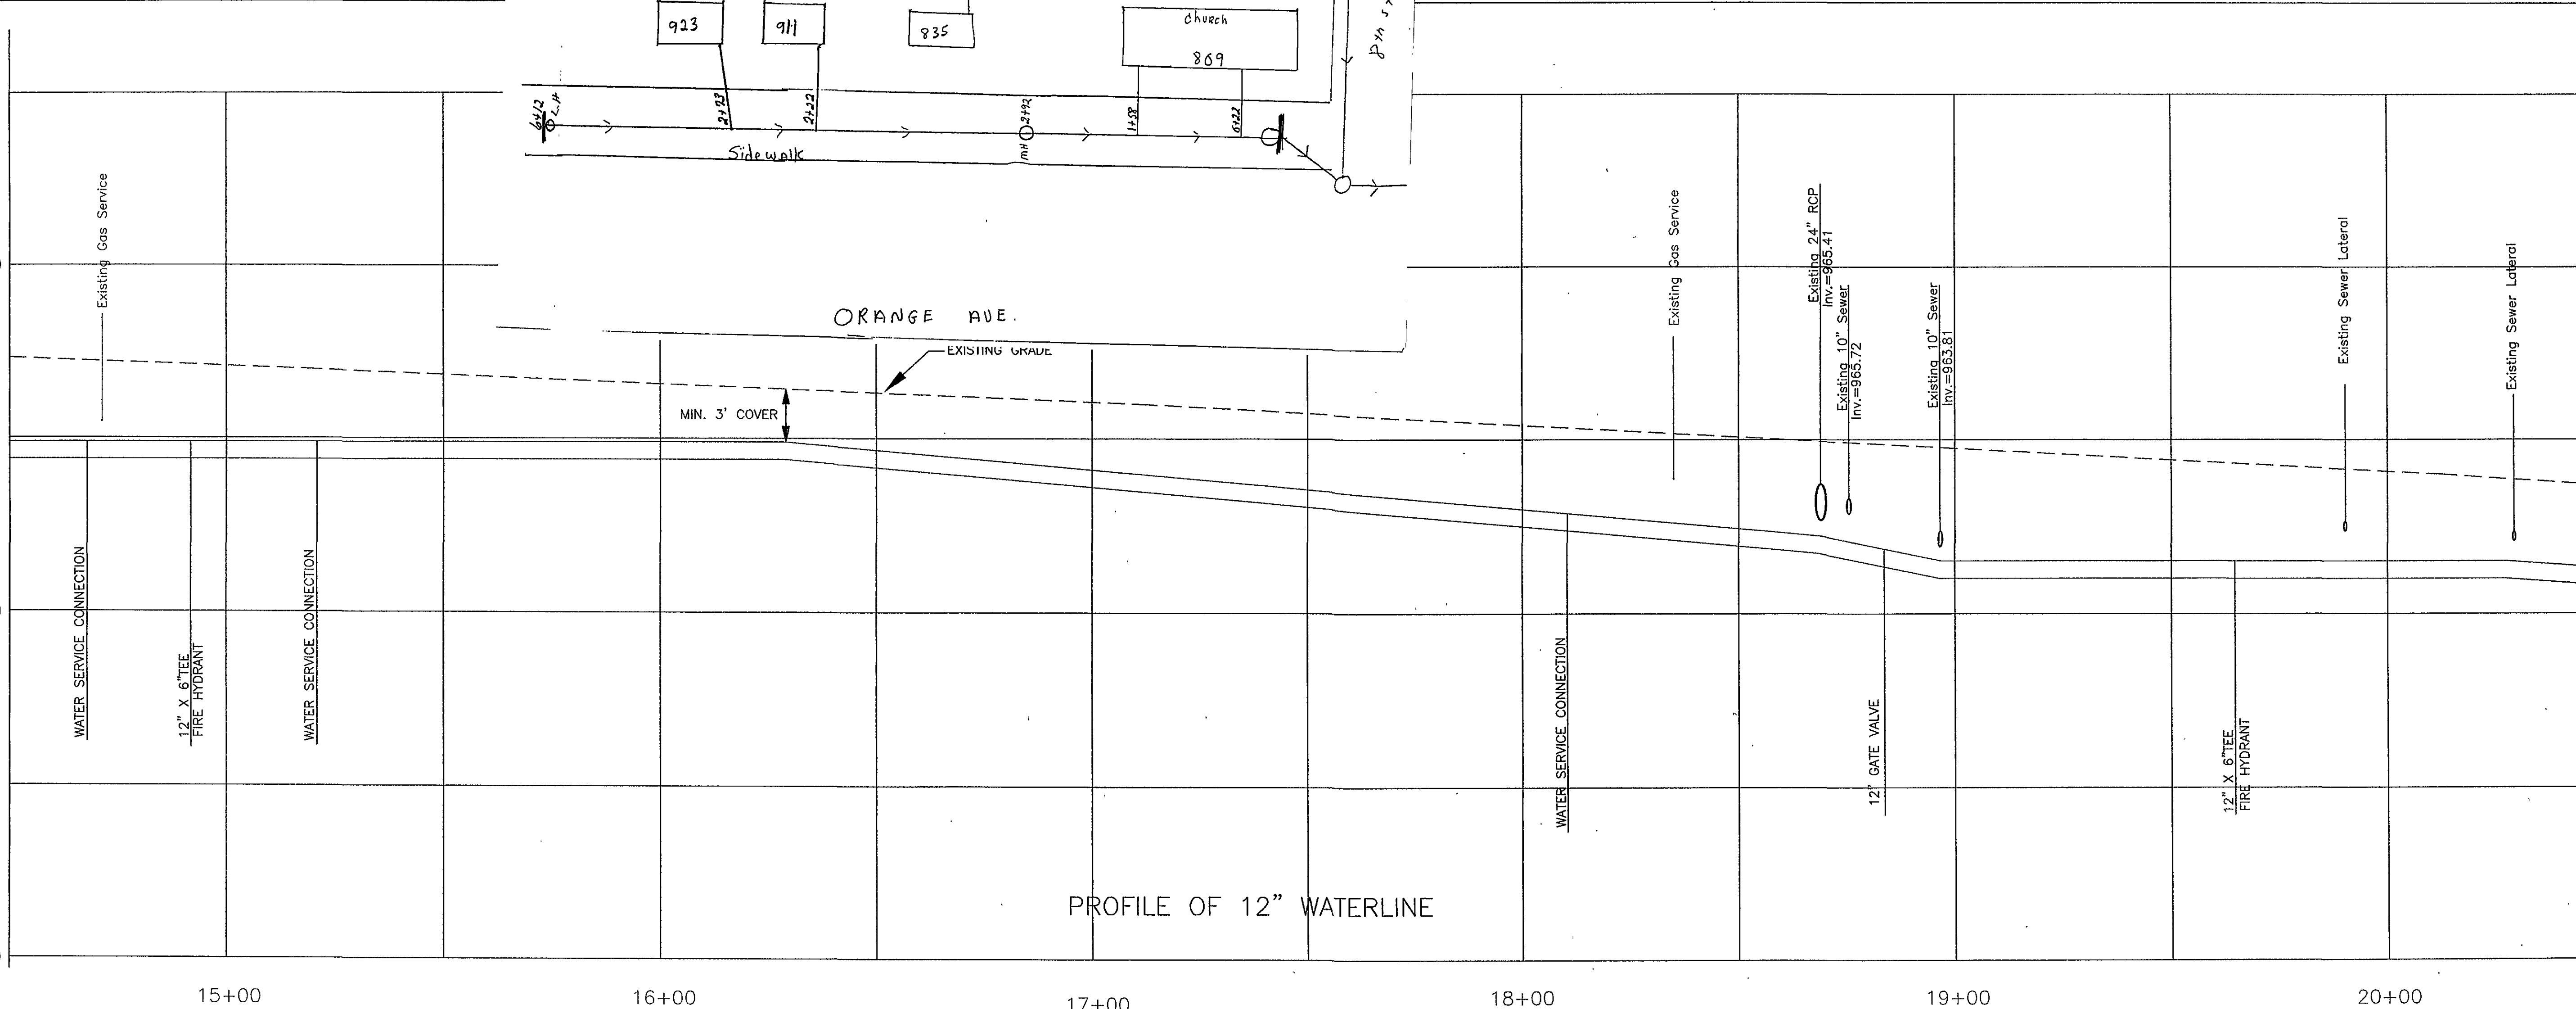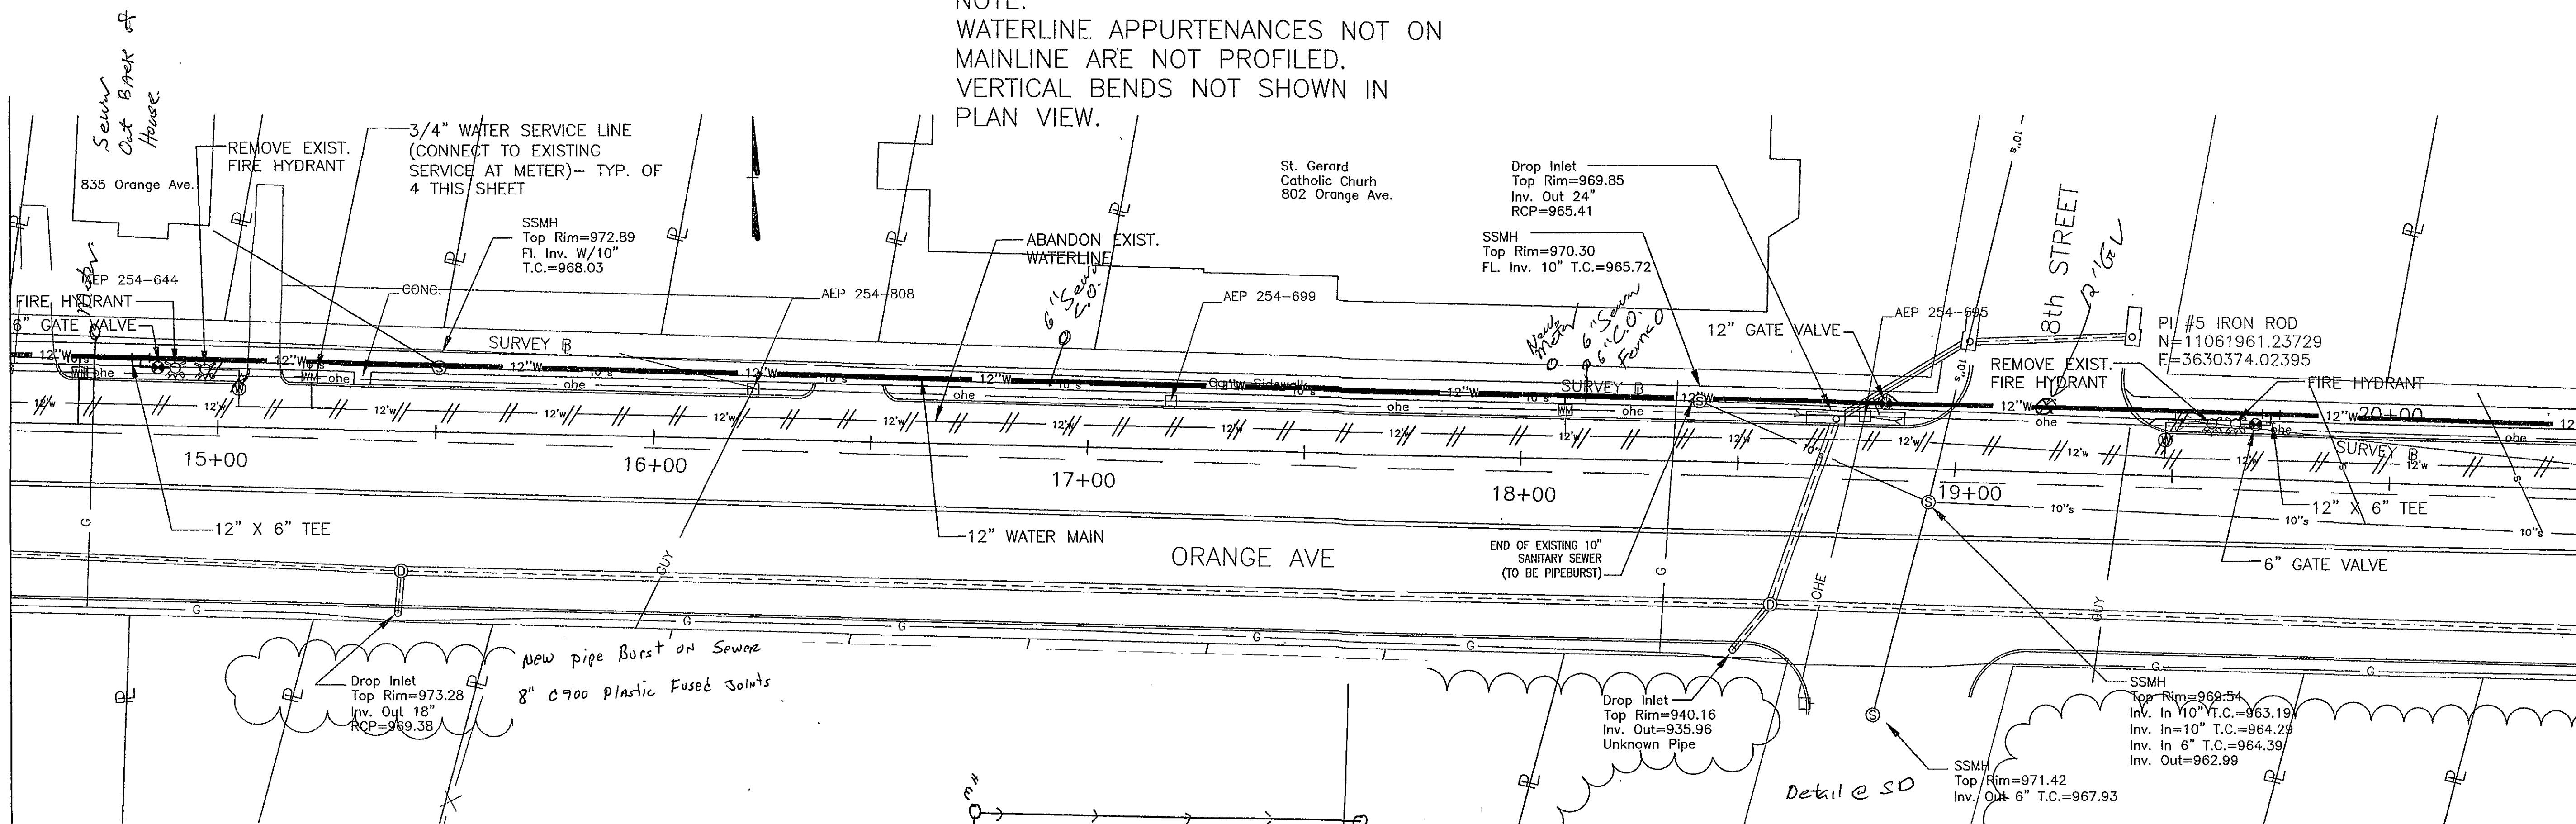

Date	
Revisions	

Issue Date:	4/6/04
Drawn By:	DBL
Designed By:	BOC
Checked By:	SWH
Date:	4/6/04

Mattem & Craig
CONSULTING ENGINEERS • SURVEYORS
701 FIRST STREET, S.W.
ROANOKE, VIRGINIA 24016
(540) 345-9342
FX (540) 345-7891

ORANGE AVE. WATER LINE PROJECT
**PLAN AND PROFILE—
12" WATERLINE**
ROANOKE, VIRGINIA

Vertical Scale:	1" = 5'
Horizontal Scale:	1" = 20'
Commission Number:	2120A
Sheet No.:	