
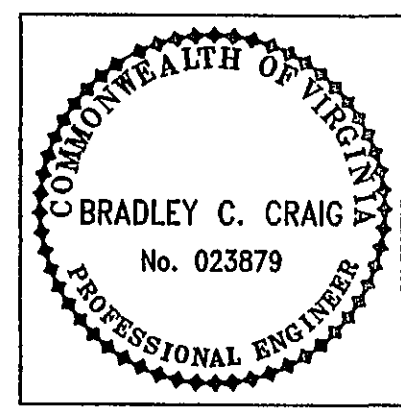
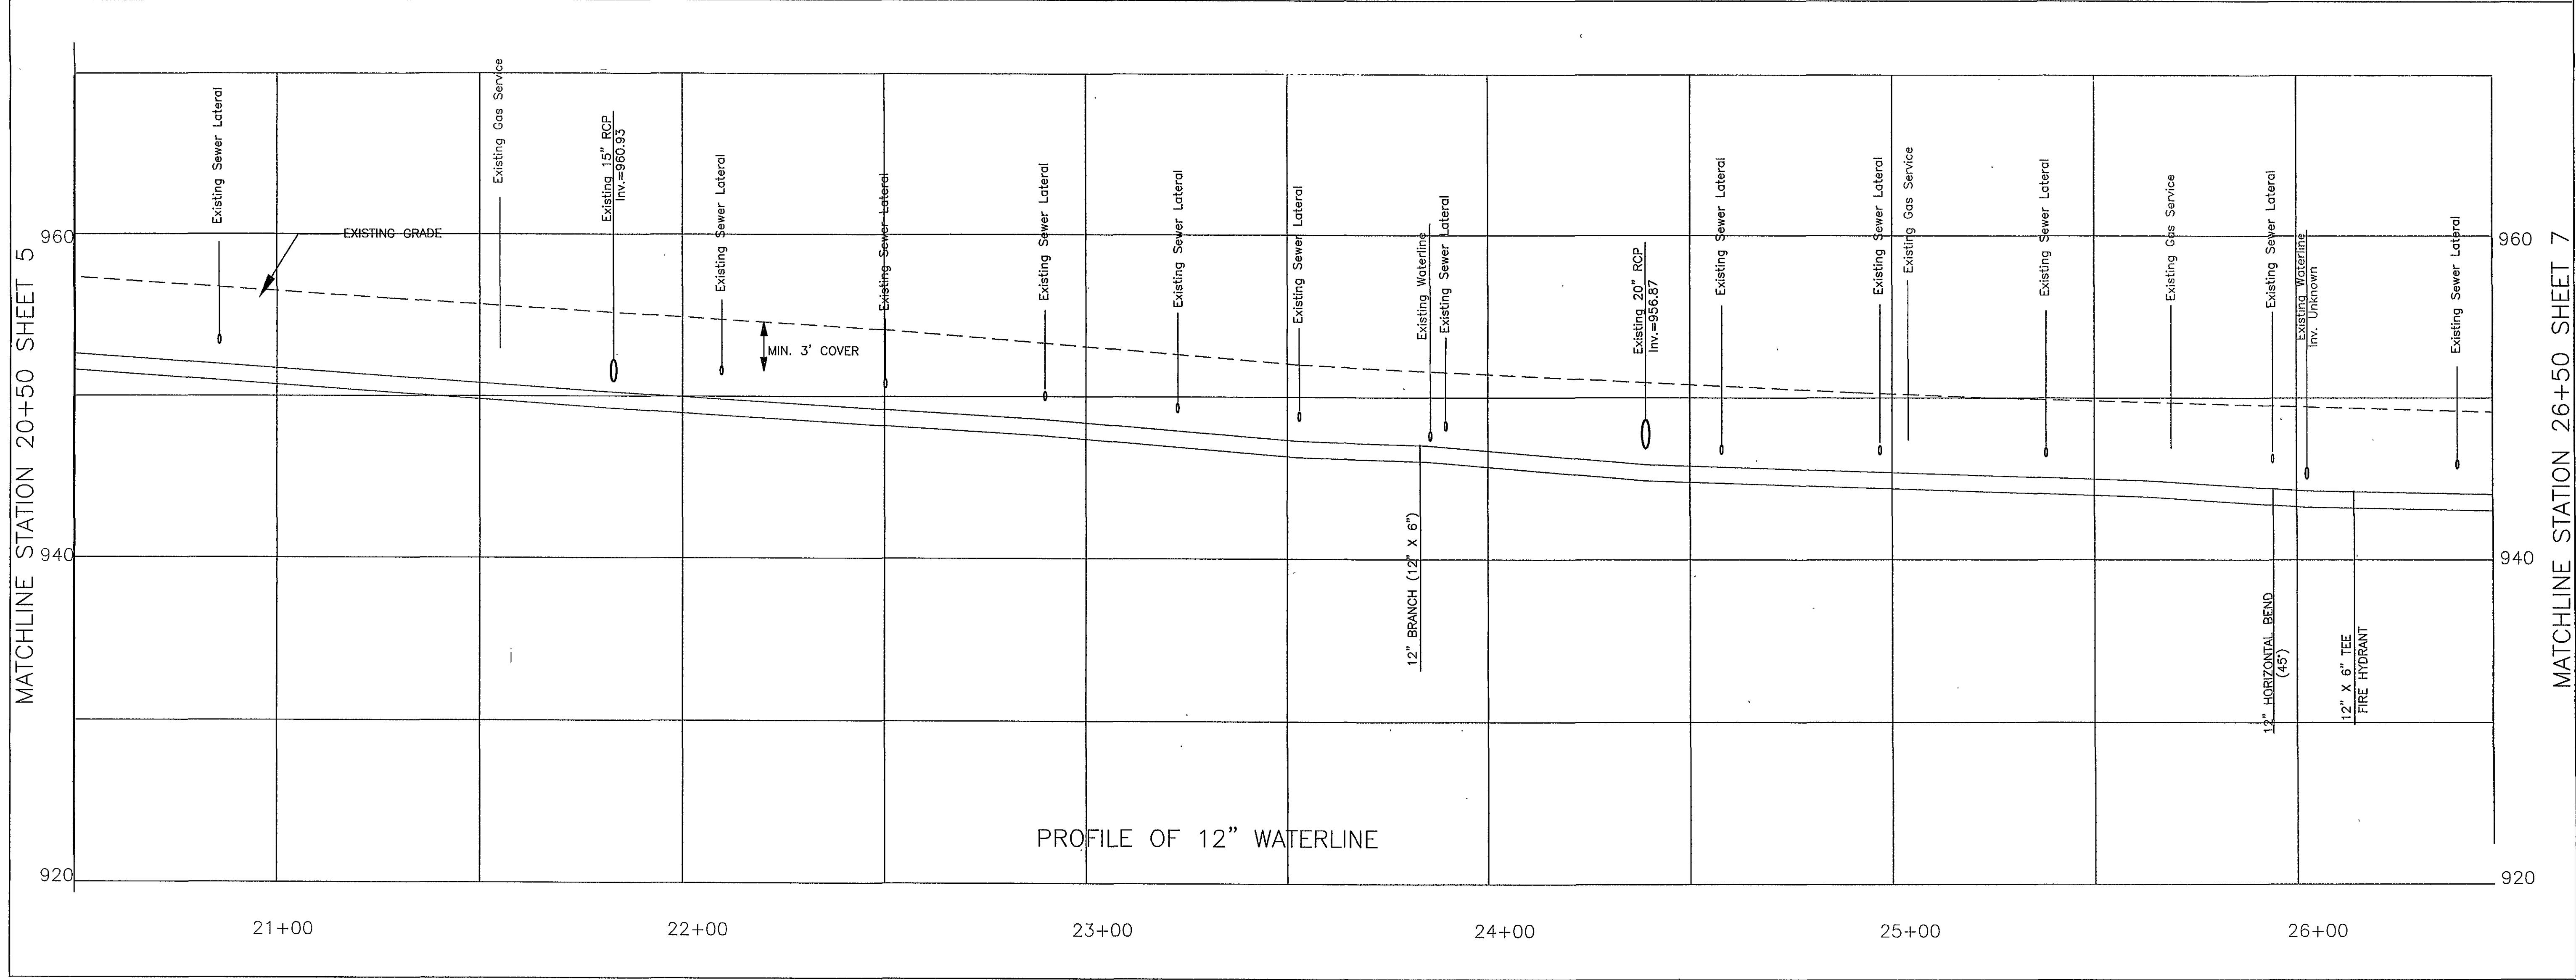


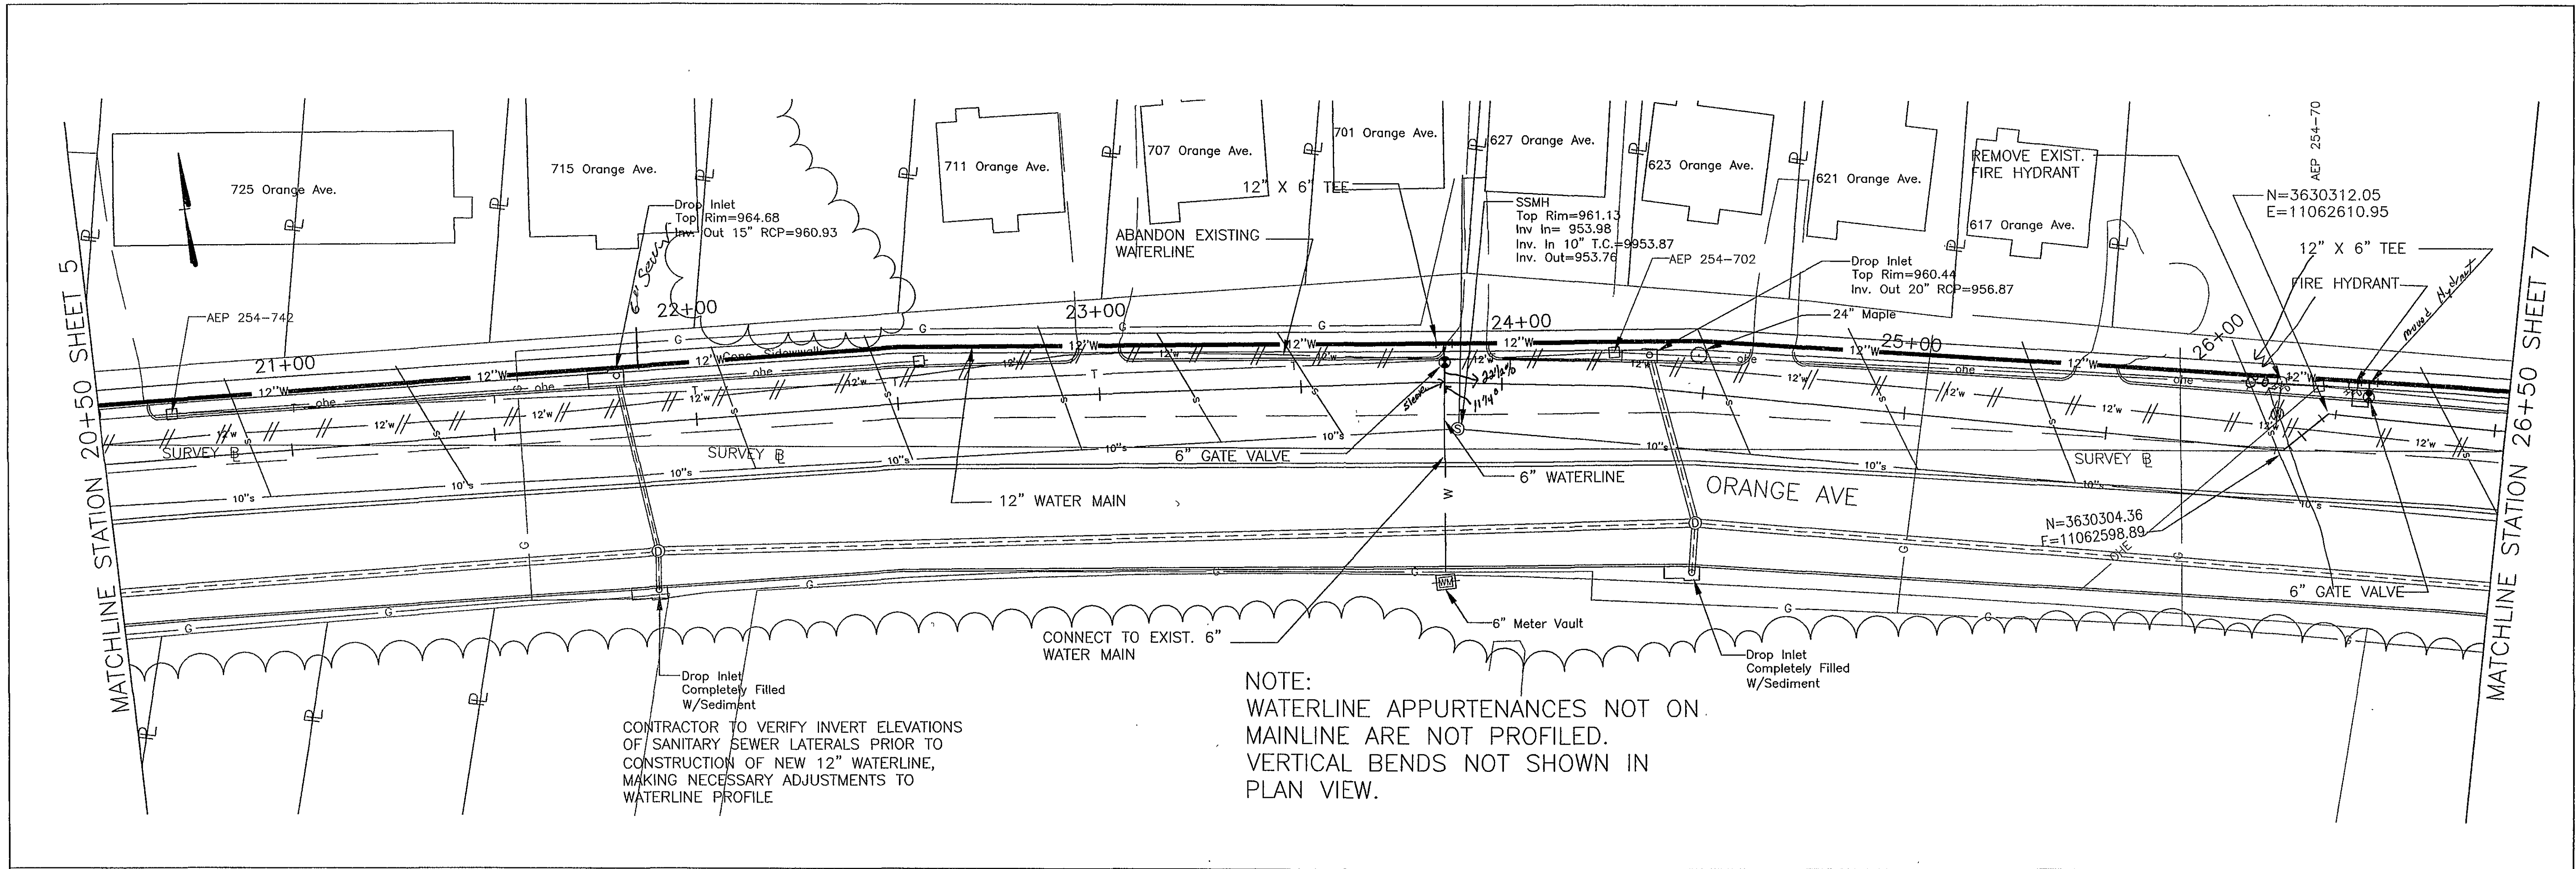

Date	
Revisions	

Issue Date:	4/6/04
Drawn By:	DBL
Designed By:	BCC
Checked By:	SWH
Date:	4/6/04

Mattem & Craig
CONSULTING ENGINEERS • SURVEYORS
704 FIRST STREET, S.W.
ROANOKE, VA 24016
(800) 345-3342
FX (540) 345-7693

ORANGE AVE. WATER LINE PROJECT
PLAN AND PROFILE
12" WATERLINE
ROANOKE, VIRGINIA

Vertical Scale:	1" = 5'
Horizontal Scale:	1" = 20'
Commission Number:	2120A
Sheet No.:	6