


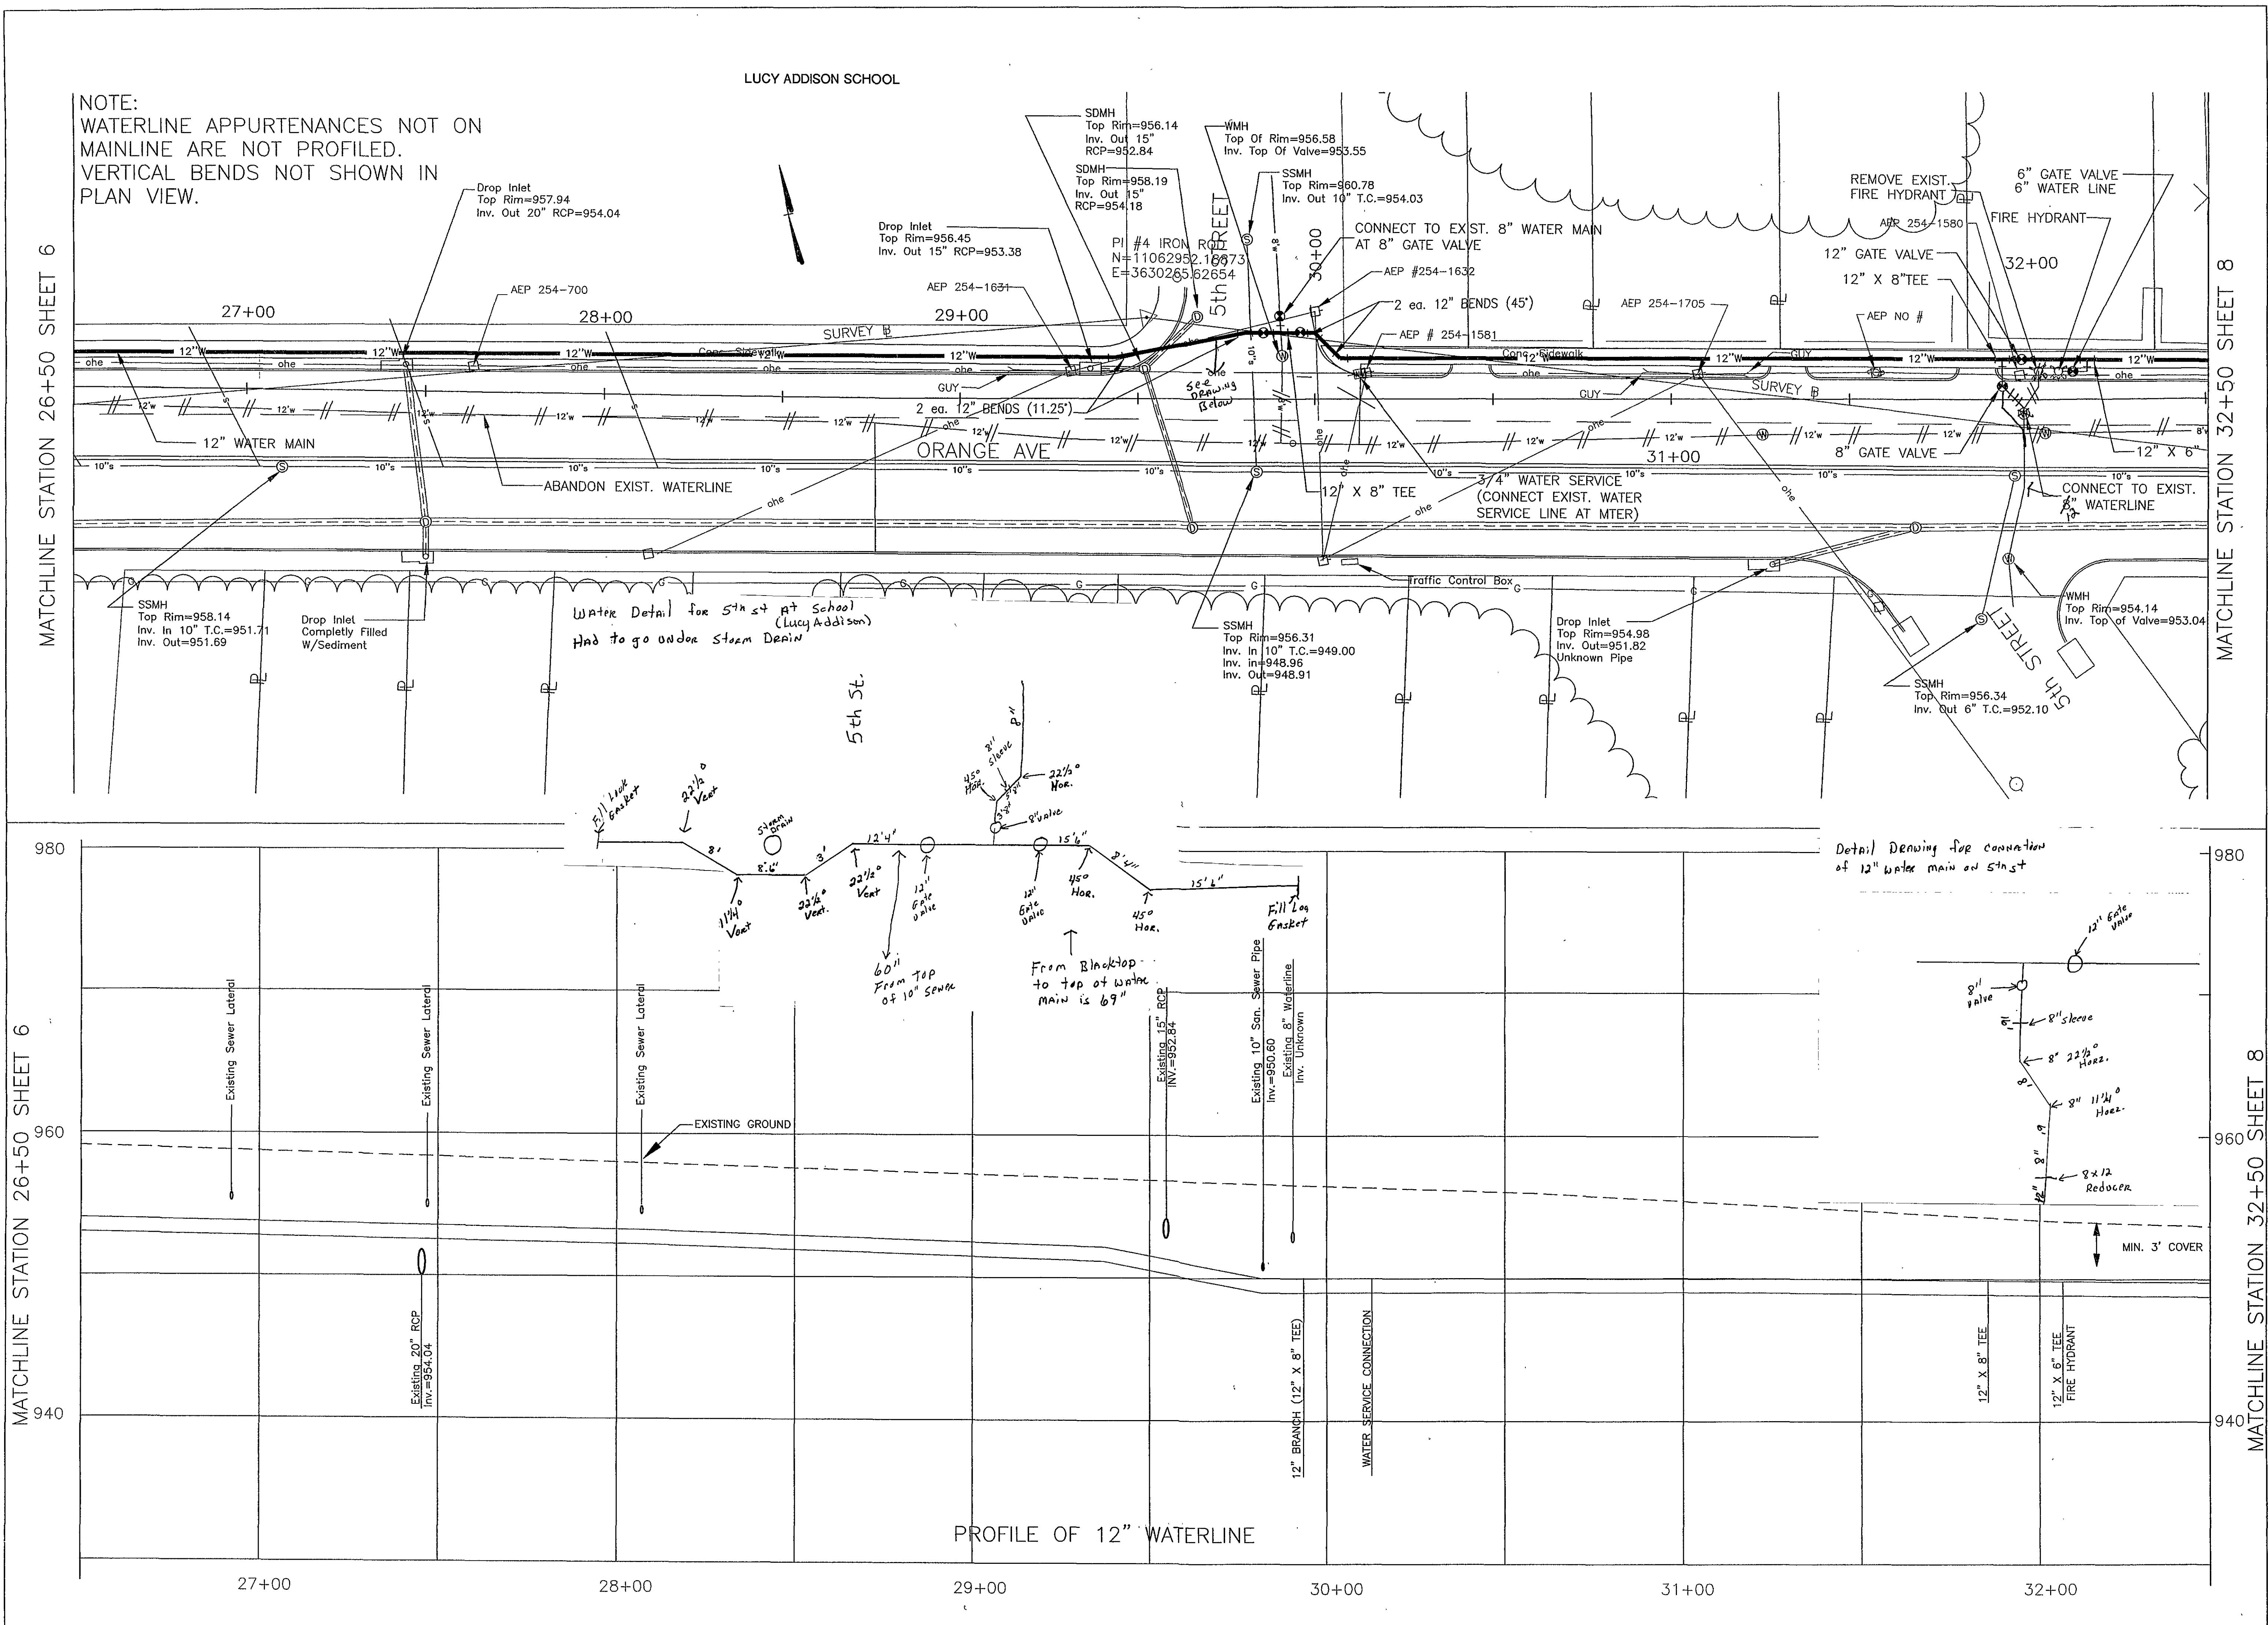

COMMONWEALTH OF VIRGINIA

BRADLEY C. CRAIG

No. 023879

PROFESSIONAL ENGINEER

Date	
Revisions	

Issue Date:	4/6/04
Drawn By:	DBL
Designed By:	BCC
Checked By:	SWH
Date:	4/6/04

Mattem & Craig

CONSULTING ENGINEERS • SURVEYORS

701 FIRST STREET, S.W.
ROANOKE, VA 24016
(540) 340-7542
FAX (540) 340-7551

ORANGE AVE. WATER LINE PROJECT

PLAN AND PROFILE

12" WATERLINE

ROANOKE, VIRGINIA

Vertical Scale:	1" = 5'
Horizontal Scale:	1" = 20'
Commission Number:	2120A
Sheet No.:	7