
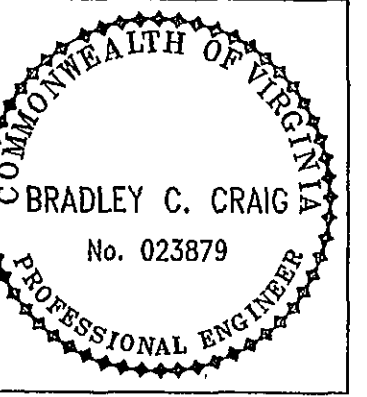
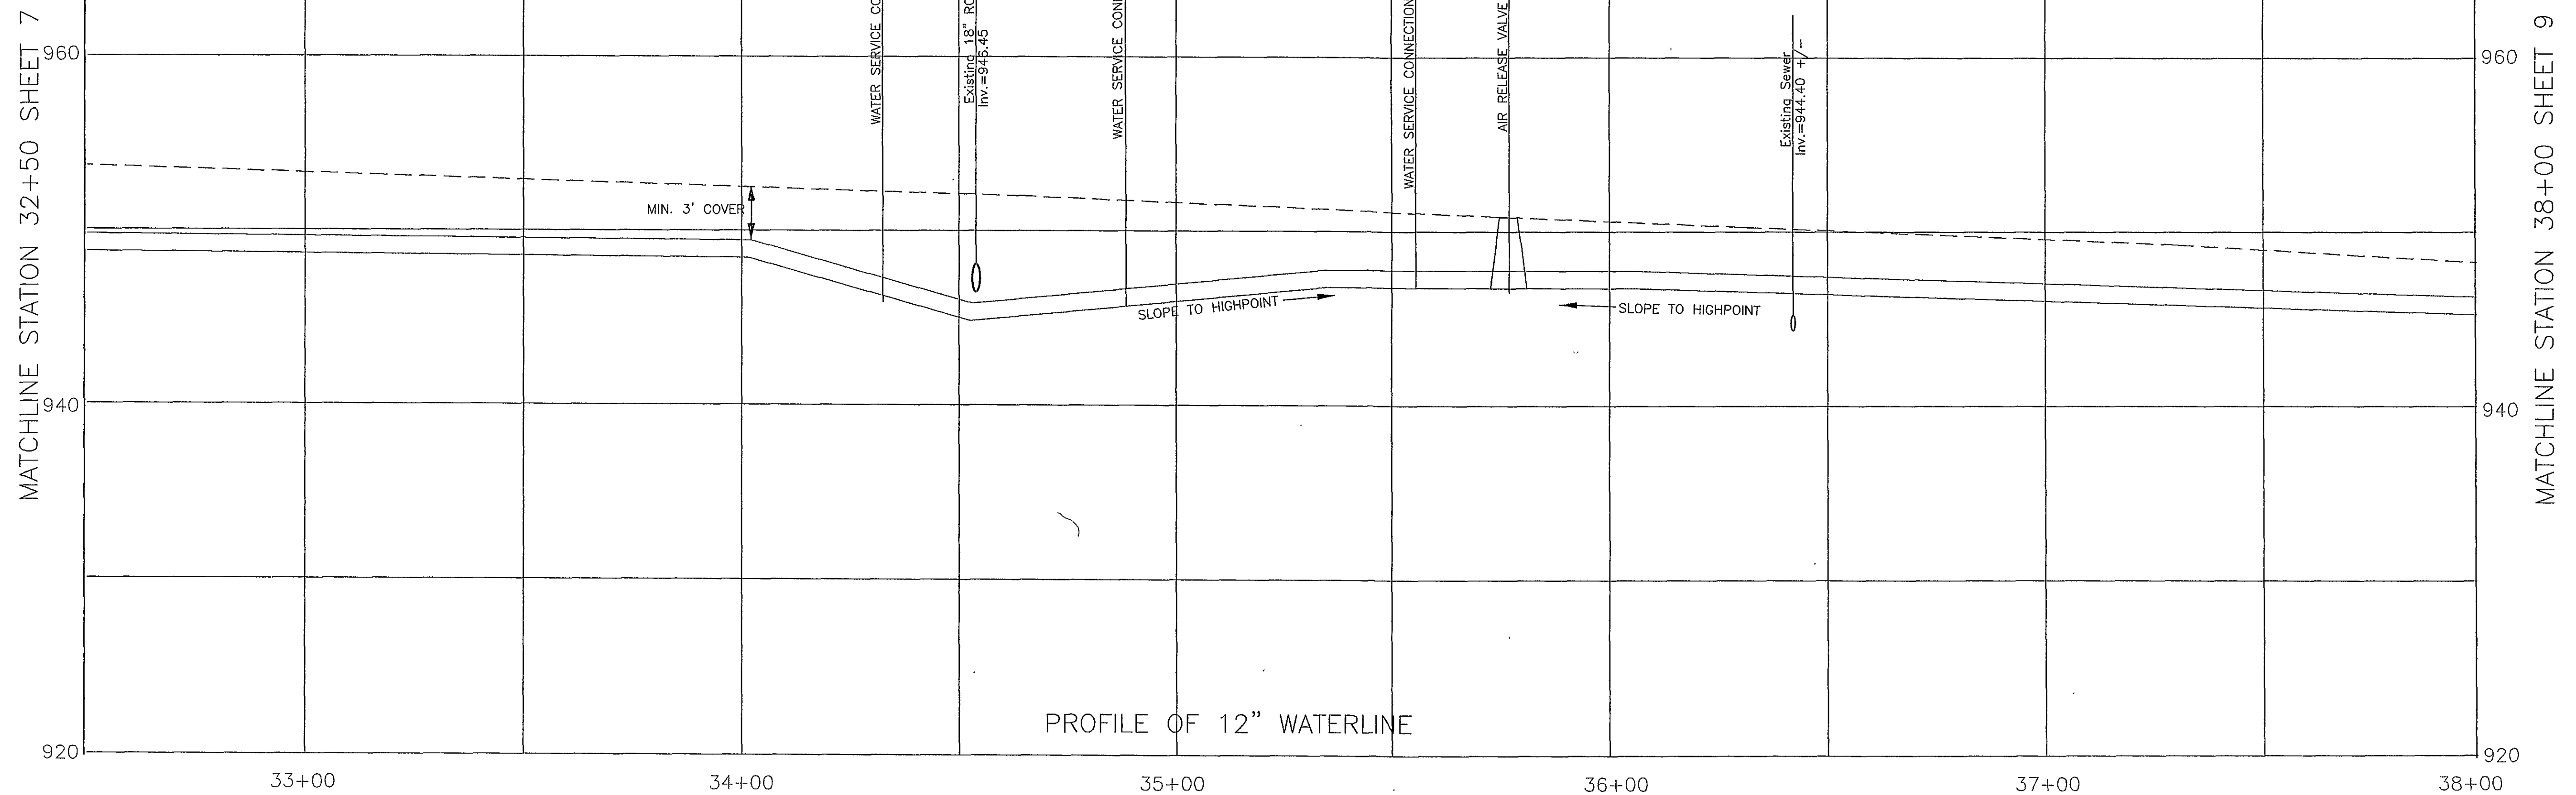


NOTE:
WATERLINE APPURTENANCES NOT ON
MAINLINE ARE NOT PROFILED.
VERTICAL BENDS NOT SHOWN IN
PLAN VIEW.

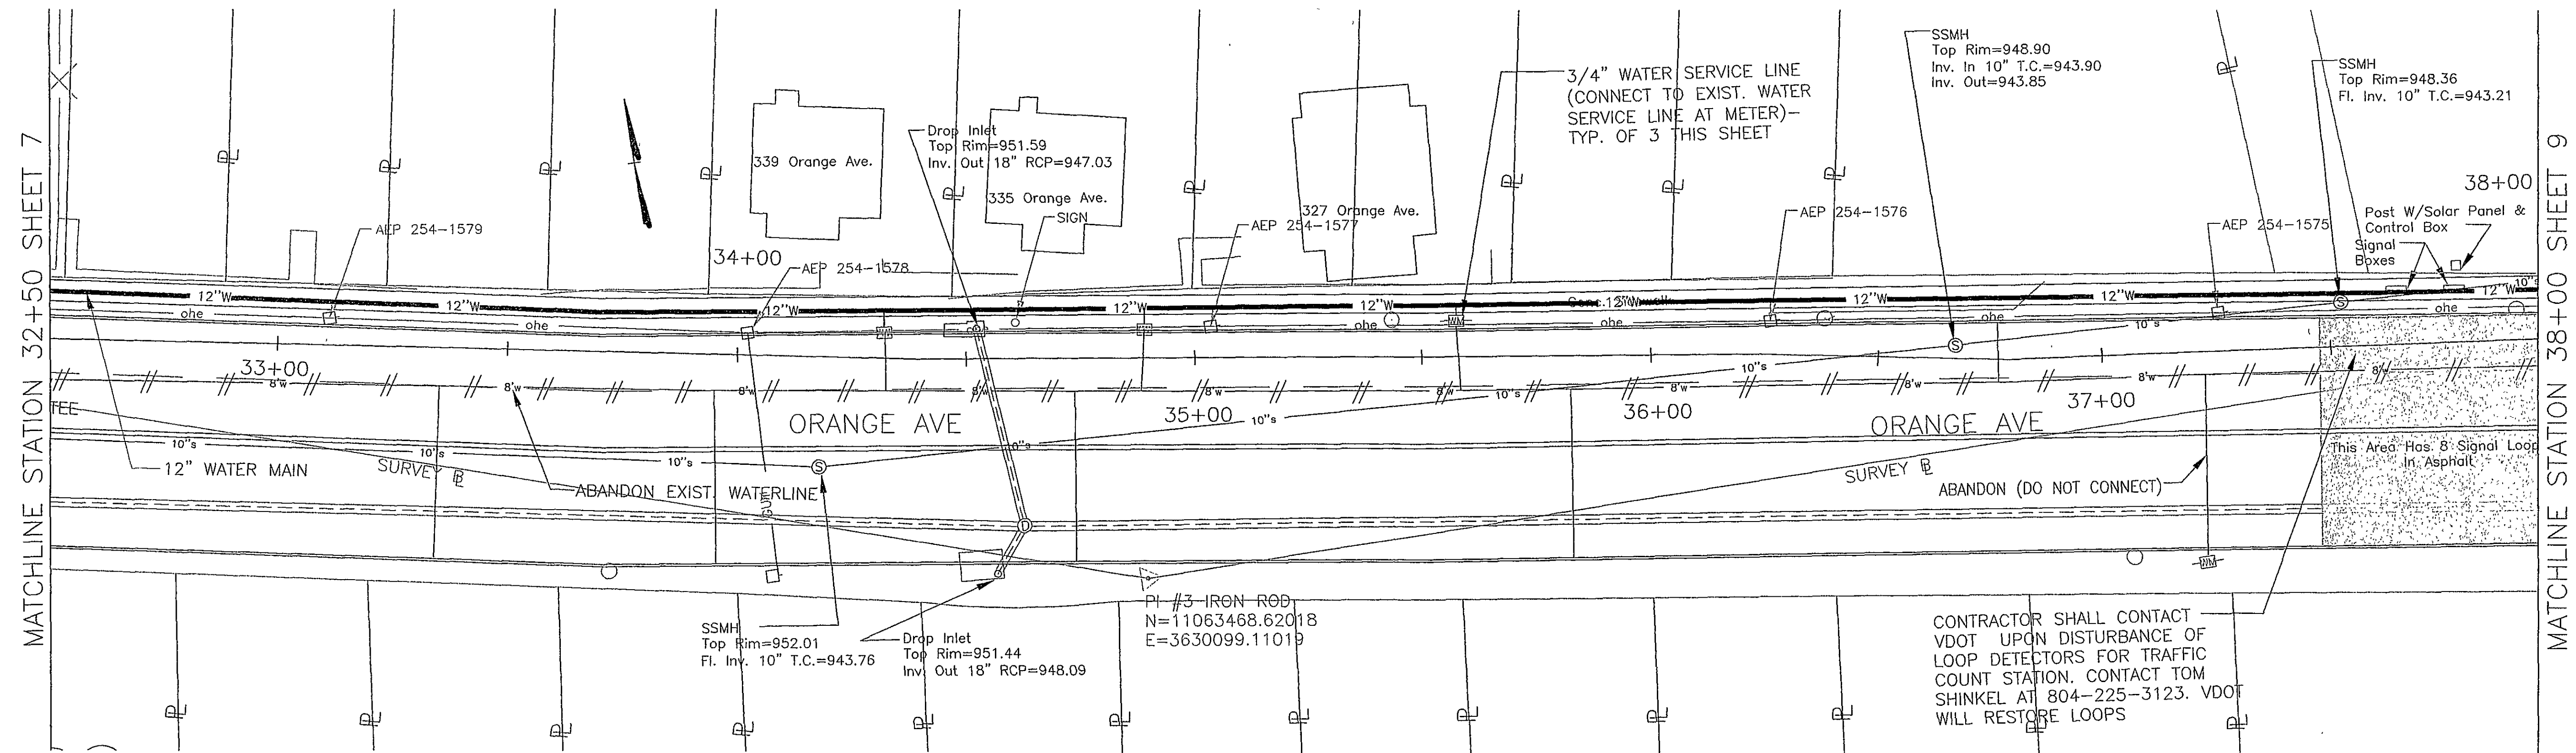

Date	
Revisions	

Issue Date: 4/6/04	Drawn By: DEL	Designed By: BCC	Checked By: SWH	Date: 4/6/04
-----------------------	---------------	------------------	-----------------	--------------

Matter & Craig
CONSULTING ENGINEERS • SURVEYORS
701 FIRST STREET, S.W.
ROANOKE, VIRGINIA 24016
(540) 345-5542
FAX (540) 345-7891

ORANGE AVE. WATER LINE PROJECT
PLAN AND PROFILE
12" WATERLINE
ROANOKE, VIRGINIA

Vertical Scale:
1" = 5'

Horizontal Scale:
1" = 20'

Commission Number:
2120A

Sheet No.:

8