


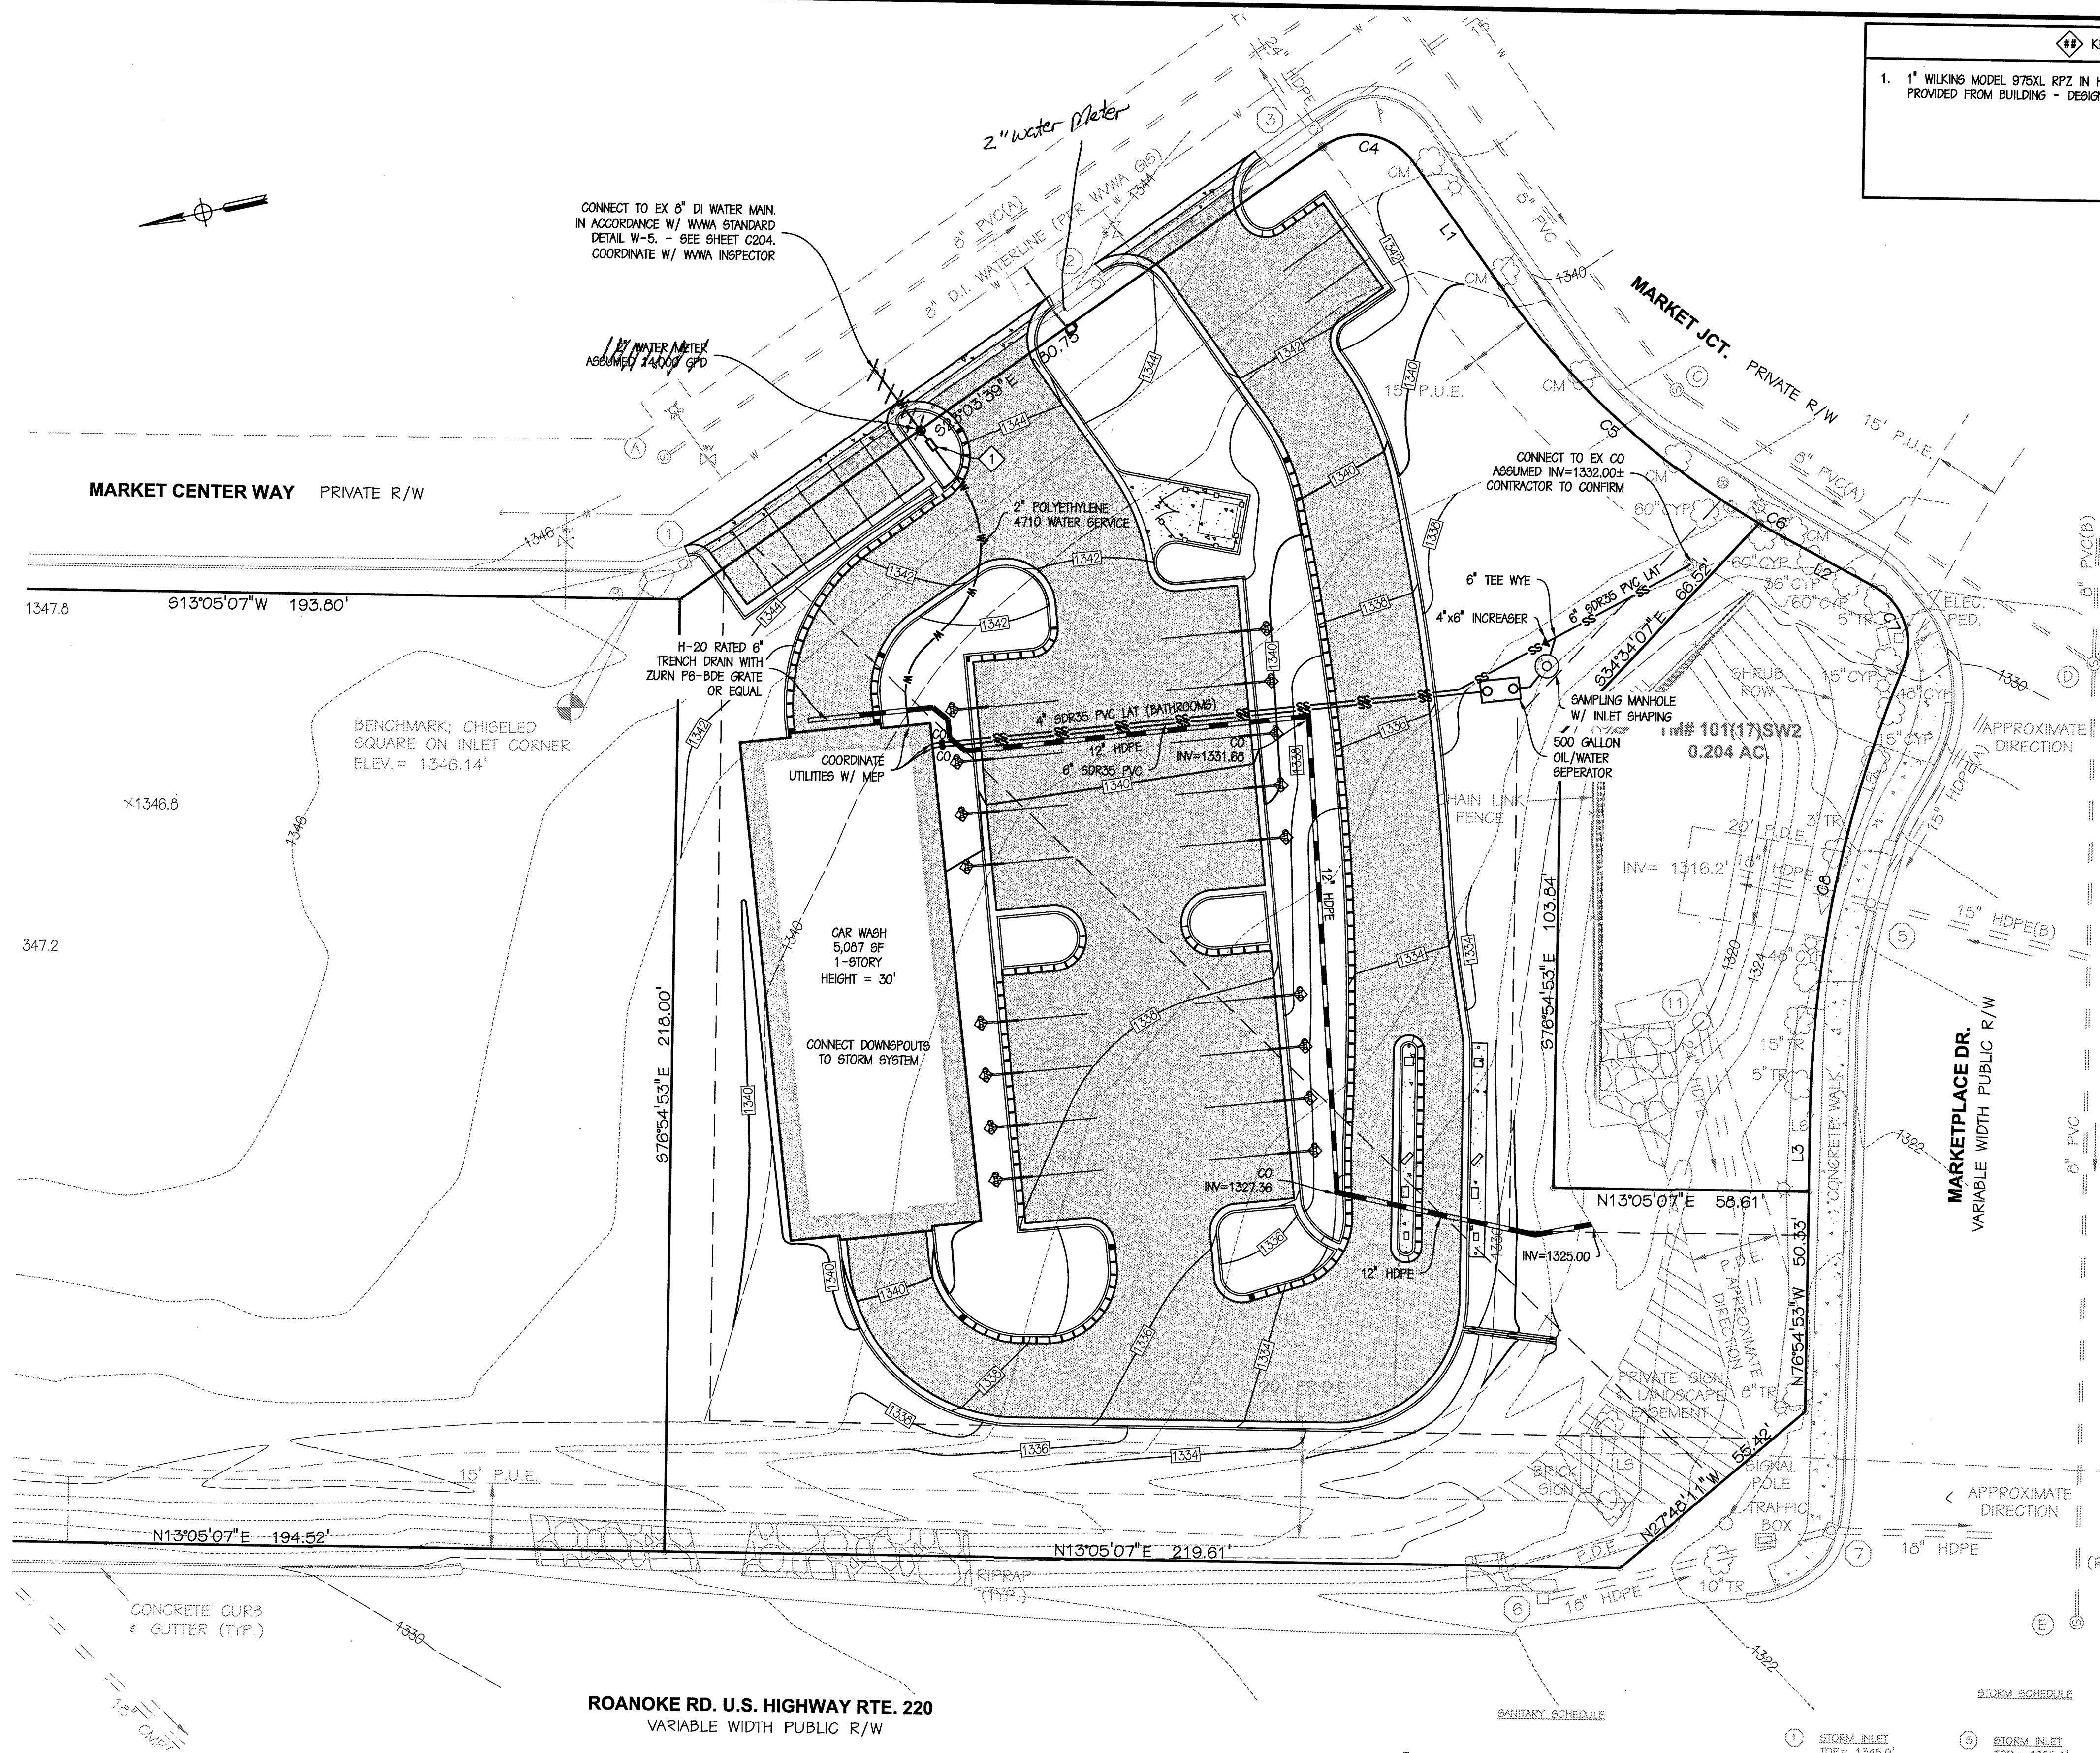

KEYNOTES

1. 1" WILKINS MODEL 975XL RPZ IN HEATED ENCLOSURE. ELEC CIRCUIT TO BE PROVIDED FROM BUILDING - DESIGNED BY OTHERS

PERKINS & ORRISON
ENGINEERS ▲ PLANNERS ▲ SURVEYORS

317 BROOK PARK PL., FOREST, VIRGINIA 24551
PHONE: 540-525-5985 FAX: 540-525-5986
EMAIL: pno@perkins-orrison.com

17 W. NELSON STREET LEXINGTON, VIRGINIA 24450
PHONE: 540-484-9001 FAX: 540-484-6009
EMAIL: pno@perkins-orrison.com

CONSULTANTS

SEAL:



JOB:

ORCHARD MARKETPLACE
CAR WASH
AMSTERDAM MAGISTERIAL DISTRICT
DALEVILLE, VIRGINIA
BOTETOURT COUNTY


CLIENT:

THOMAS BUILDERS

2	06/02/2022	PER WMA COMMENTS
1	06/16/2022	PER COUNTY COMMENT
MARK	DATE	DESCRIPTION
ISSUE:	04/04/2022	
CONTOUR INTERVAL:	2'	
DESIGNED BY:	RHO	
DRAWN BY:	PWS	
CHECKED BY:	RHO	

SHEET TITLE

 UTILITY PLAN



SHEET	PROJECT #
C203	DEV-SITE-22-00005
JOB NO. 21442	SHEET NO. 6 of 14