

All public utility work was done in accordance with these documents, with reasonable accuracy, and any deviations have been red-line annotated or otherwise captured in change order documentation.

No changes have been made for this project.

Daniel Cyrus  
Digitally signed by Daniel Cyrus  
DN: cn=Daniel Cyrus  
Date: 2023.07.17 14:59:13-04'00'

PERKINS  
&  
ORRISON

ENGINEERS ▲ PLANNERS ▲ SURVEYORS

317 BROOK PARK PL., FOREST, VIRGINIA 24551  
PHONE: 434-525-5985 FAX: 434-525-5986  
EMAIL: prn@perkins-orrison.com

17 W. NELSON STREET LEXINGTON, VIRGINIA 24450  
PHONE: 540-464-9001 FAX: 540-464-5009  
EMAIL: prn@perkins-orrison.com

CONSULTANTS

SEAL:

COMMONWEALTH OF VIRGINIA

RUSSELL H. ORRISON

Lic. No. 031849

09/30/2022

PROFESSIONAL ENGINEER

JOB:

ORCHARD MARKETPLACE  
RETAIL SHELL  
AMSTERDAM MAGISTERIAL DISTRICT  
DALEVILLE, VIRGINIA  
BOTETOURT COUNTY

 
CLIENT:

THOMAS BUILDERS


2	09/30/2022	REVISE SAMPLING MH PER WWA
1	09/28/2022	PER COUNTY COMMENTS
MARK	DATE	DESCRIPTION
ISSUE: 06/21/2022		
CONTOUR INTERVAL: 2'		
DESIGNED BY: RHO		
DRAWN BY: PWS		
CHECKED BY: RHO		

SHEET TITLE

UTILITY PLAN



SHEET	C203	JURISDICTION PROJECT #
SHEET NO.	22122	SHEET NO. 6 OF 14

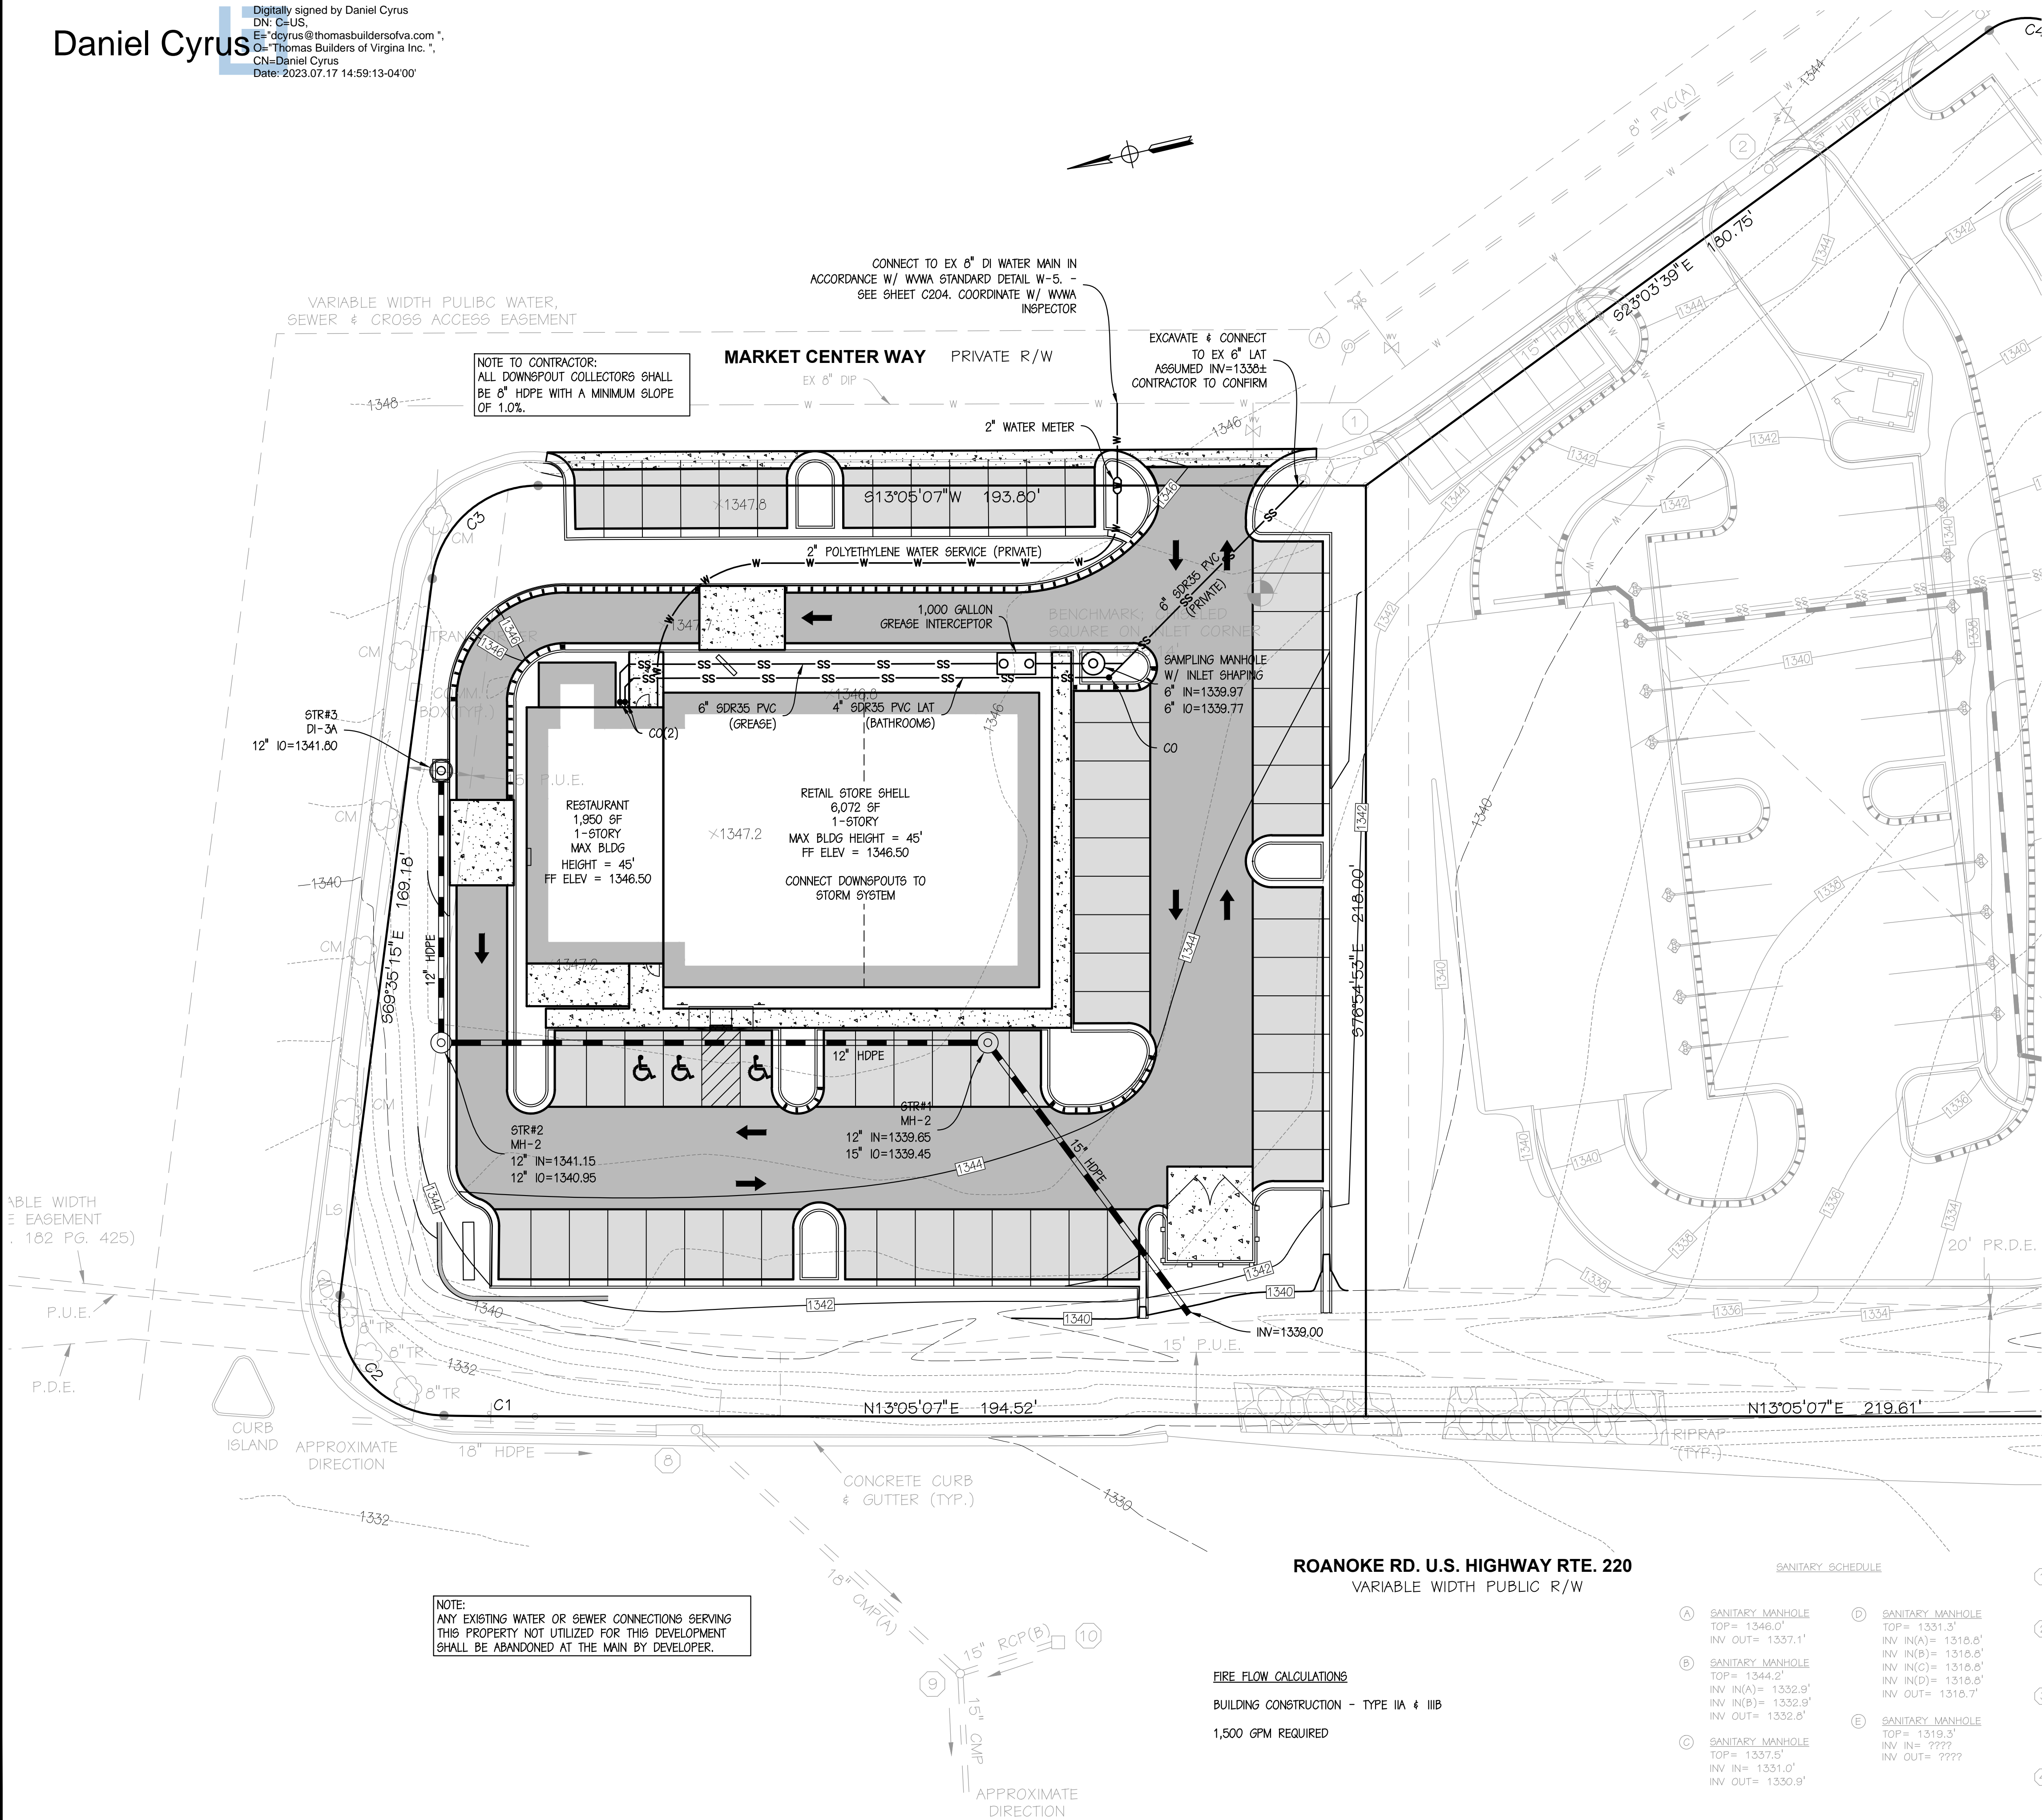

\\P\2021\21442 - Orchard\Drawing\Civil\Sheets\Junkin\22122 Utility Plandwg - Fri, 30 Sep 2022 - 14:28