

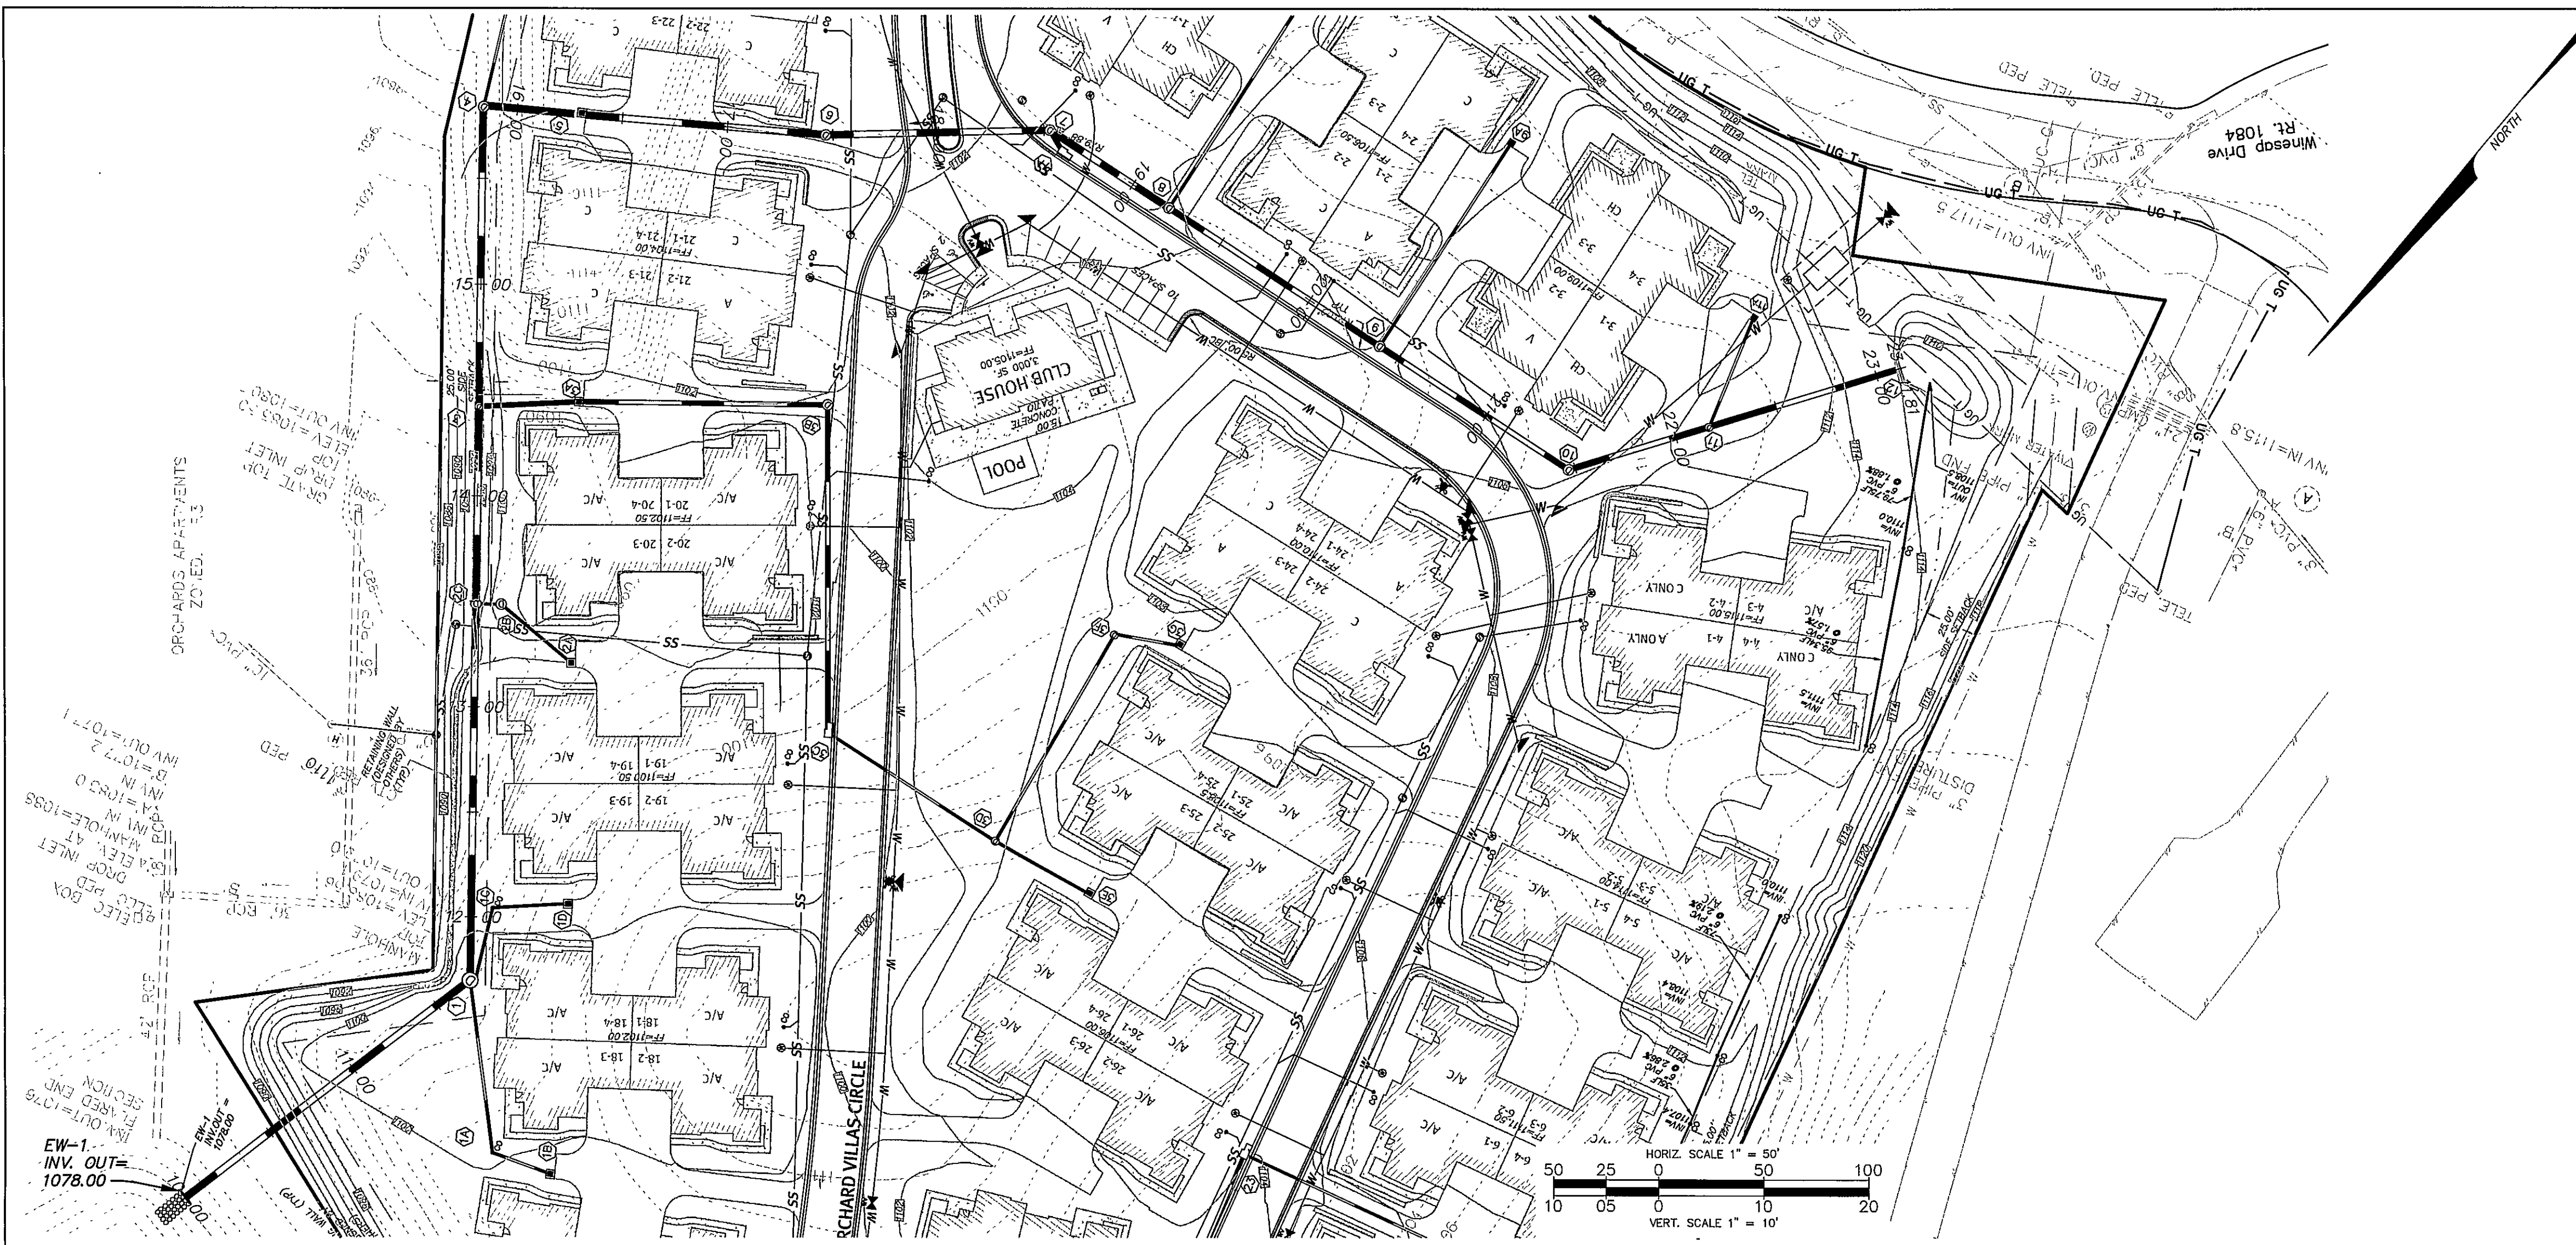


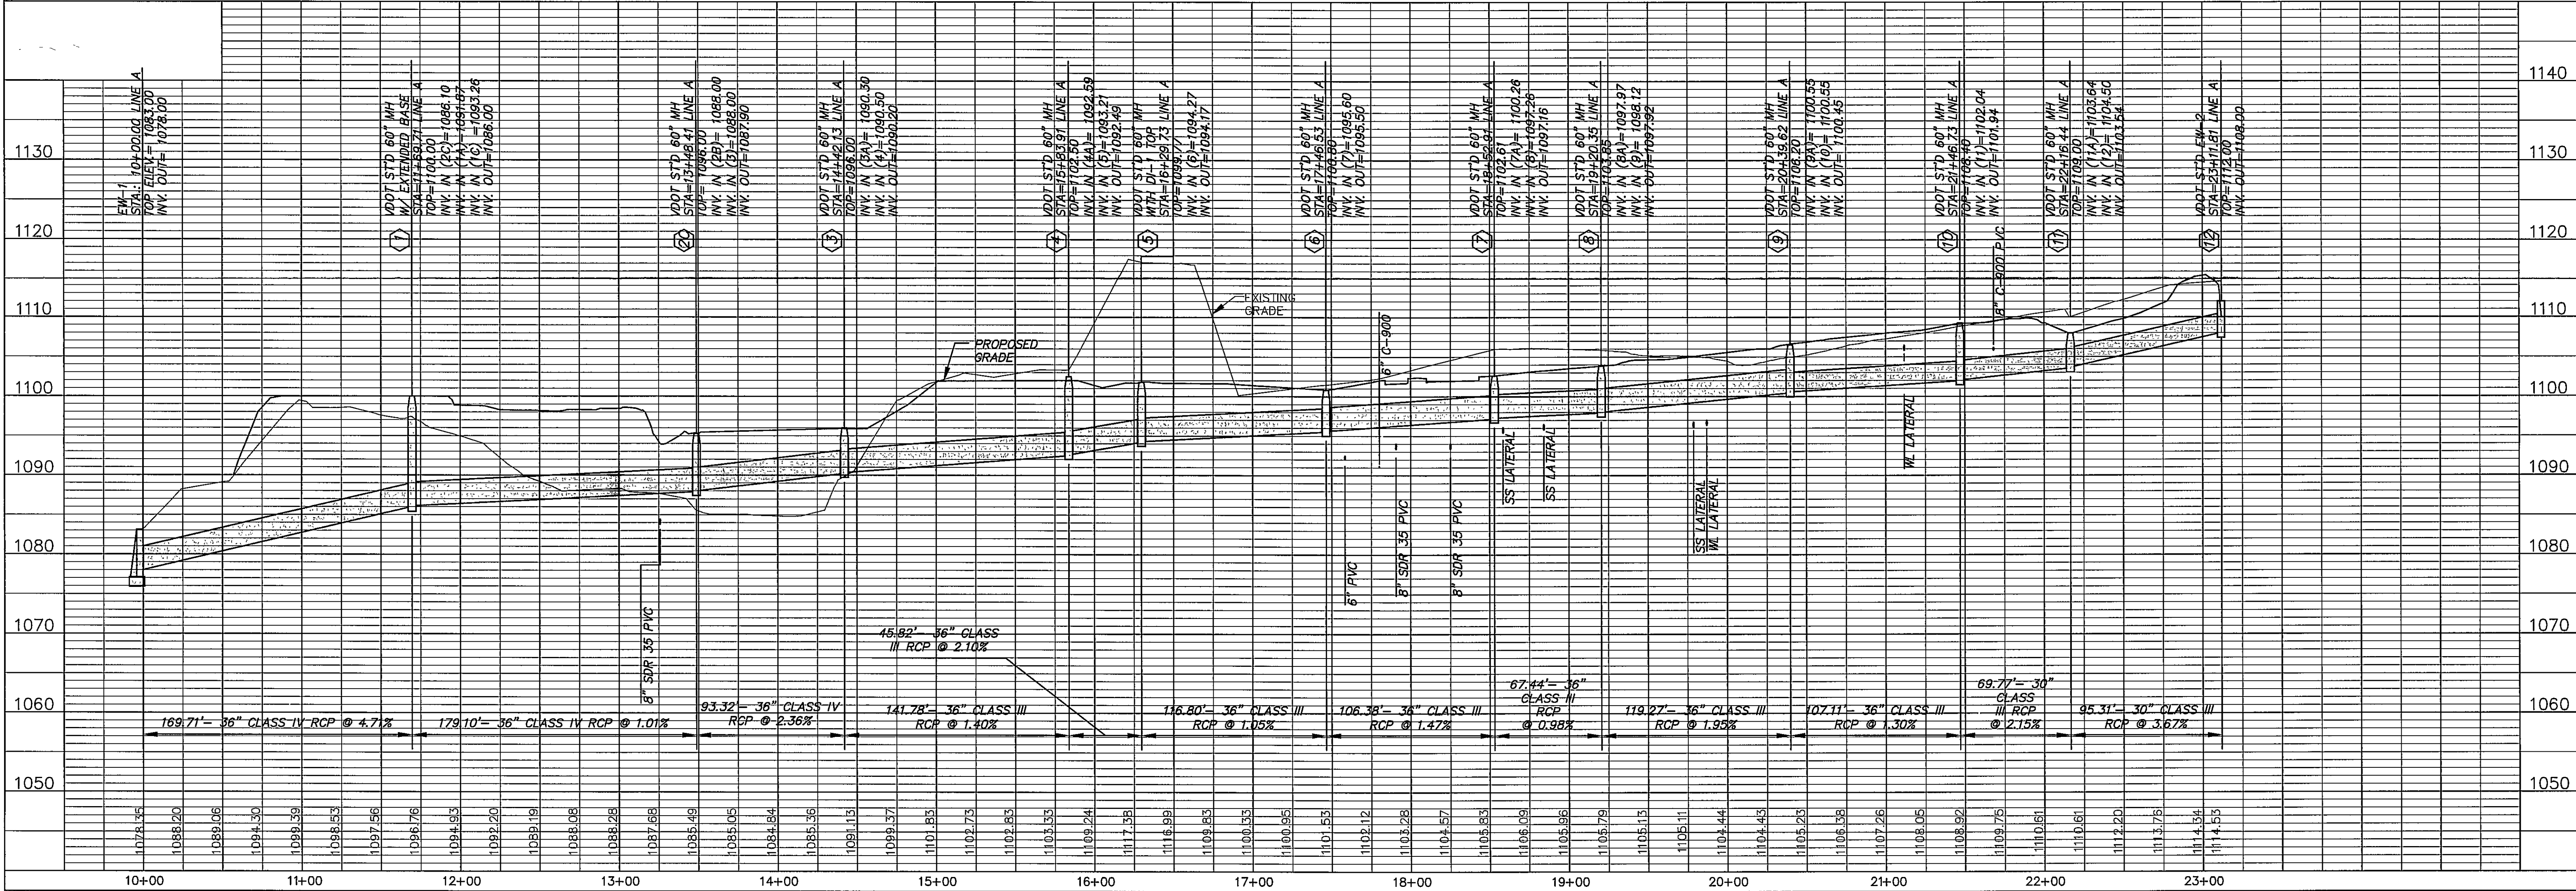

1	09/06/05	PER COUNTY COMMENTS
2	09/06/05	PER CLIENT COMMENTS
3	11/04/05	PER COUNTY COMMENTS
4	12/06/05	PER COUNTY COMMENTS
6	01/23/06	PER COUNTY AND VDOT COMMENTS

STORM SEWER PLAN AND PROFILE FOR ORCHARD VILLAS ROANOKE COUNTY, VIRGINIA

PROJECT NO. 20040345
G.I. NO. 260-04-C4.7
FILE NO. LS-11039
DATE: 09/06/05
DRAWN BY: DLC/MCB
CHECKED BY: MDM

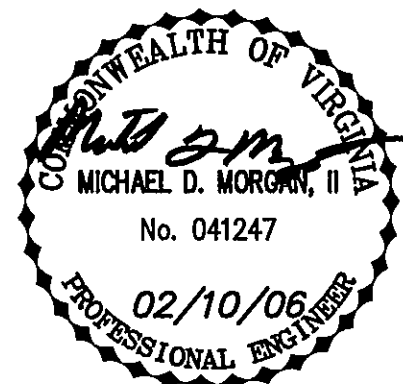

HURT & PROFFITT

SHEET NO.
25 OF 33

HURT & PROFFITT
INCORPORATED
2524 LANGHORNE ROAD
LYNCHBURG VA 24501
800.242.4906 TOLL FREE
434.847.7795 MAIN
434.847.0047 FAX

ENGINEERING >> SURVEYING >> PLANNING